


Contractor must verify all dimensions on site before commencing any work or shop drawings. If this drawing exceeds the quantities taken in any way, the building designers are to be informed before the work is initiated.  
Only figured dimensions to be taken from this drawing. Do not scale off this drawing.  
Drawing based on Ordnance Survey and/or existing record drawings - design and drawing content subject to Site Survey, Structural Survey, Site Investigations, Planning and Statutory Requirements and Approvals.  
All drainage layouts are schematic and invert levels must be established prior to construction.

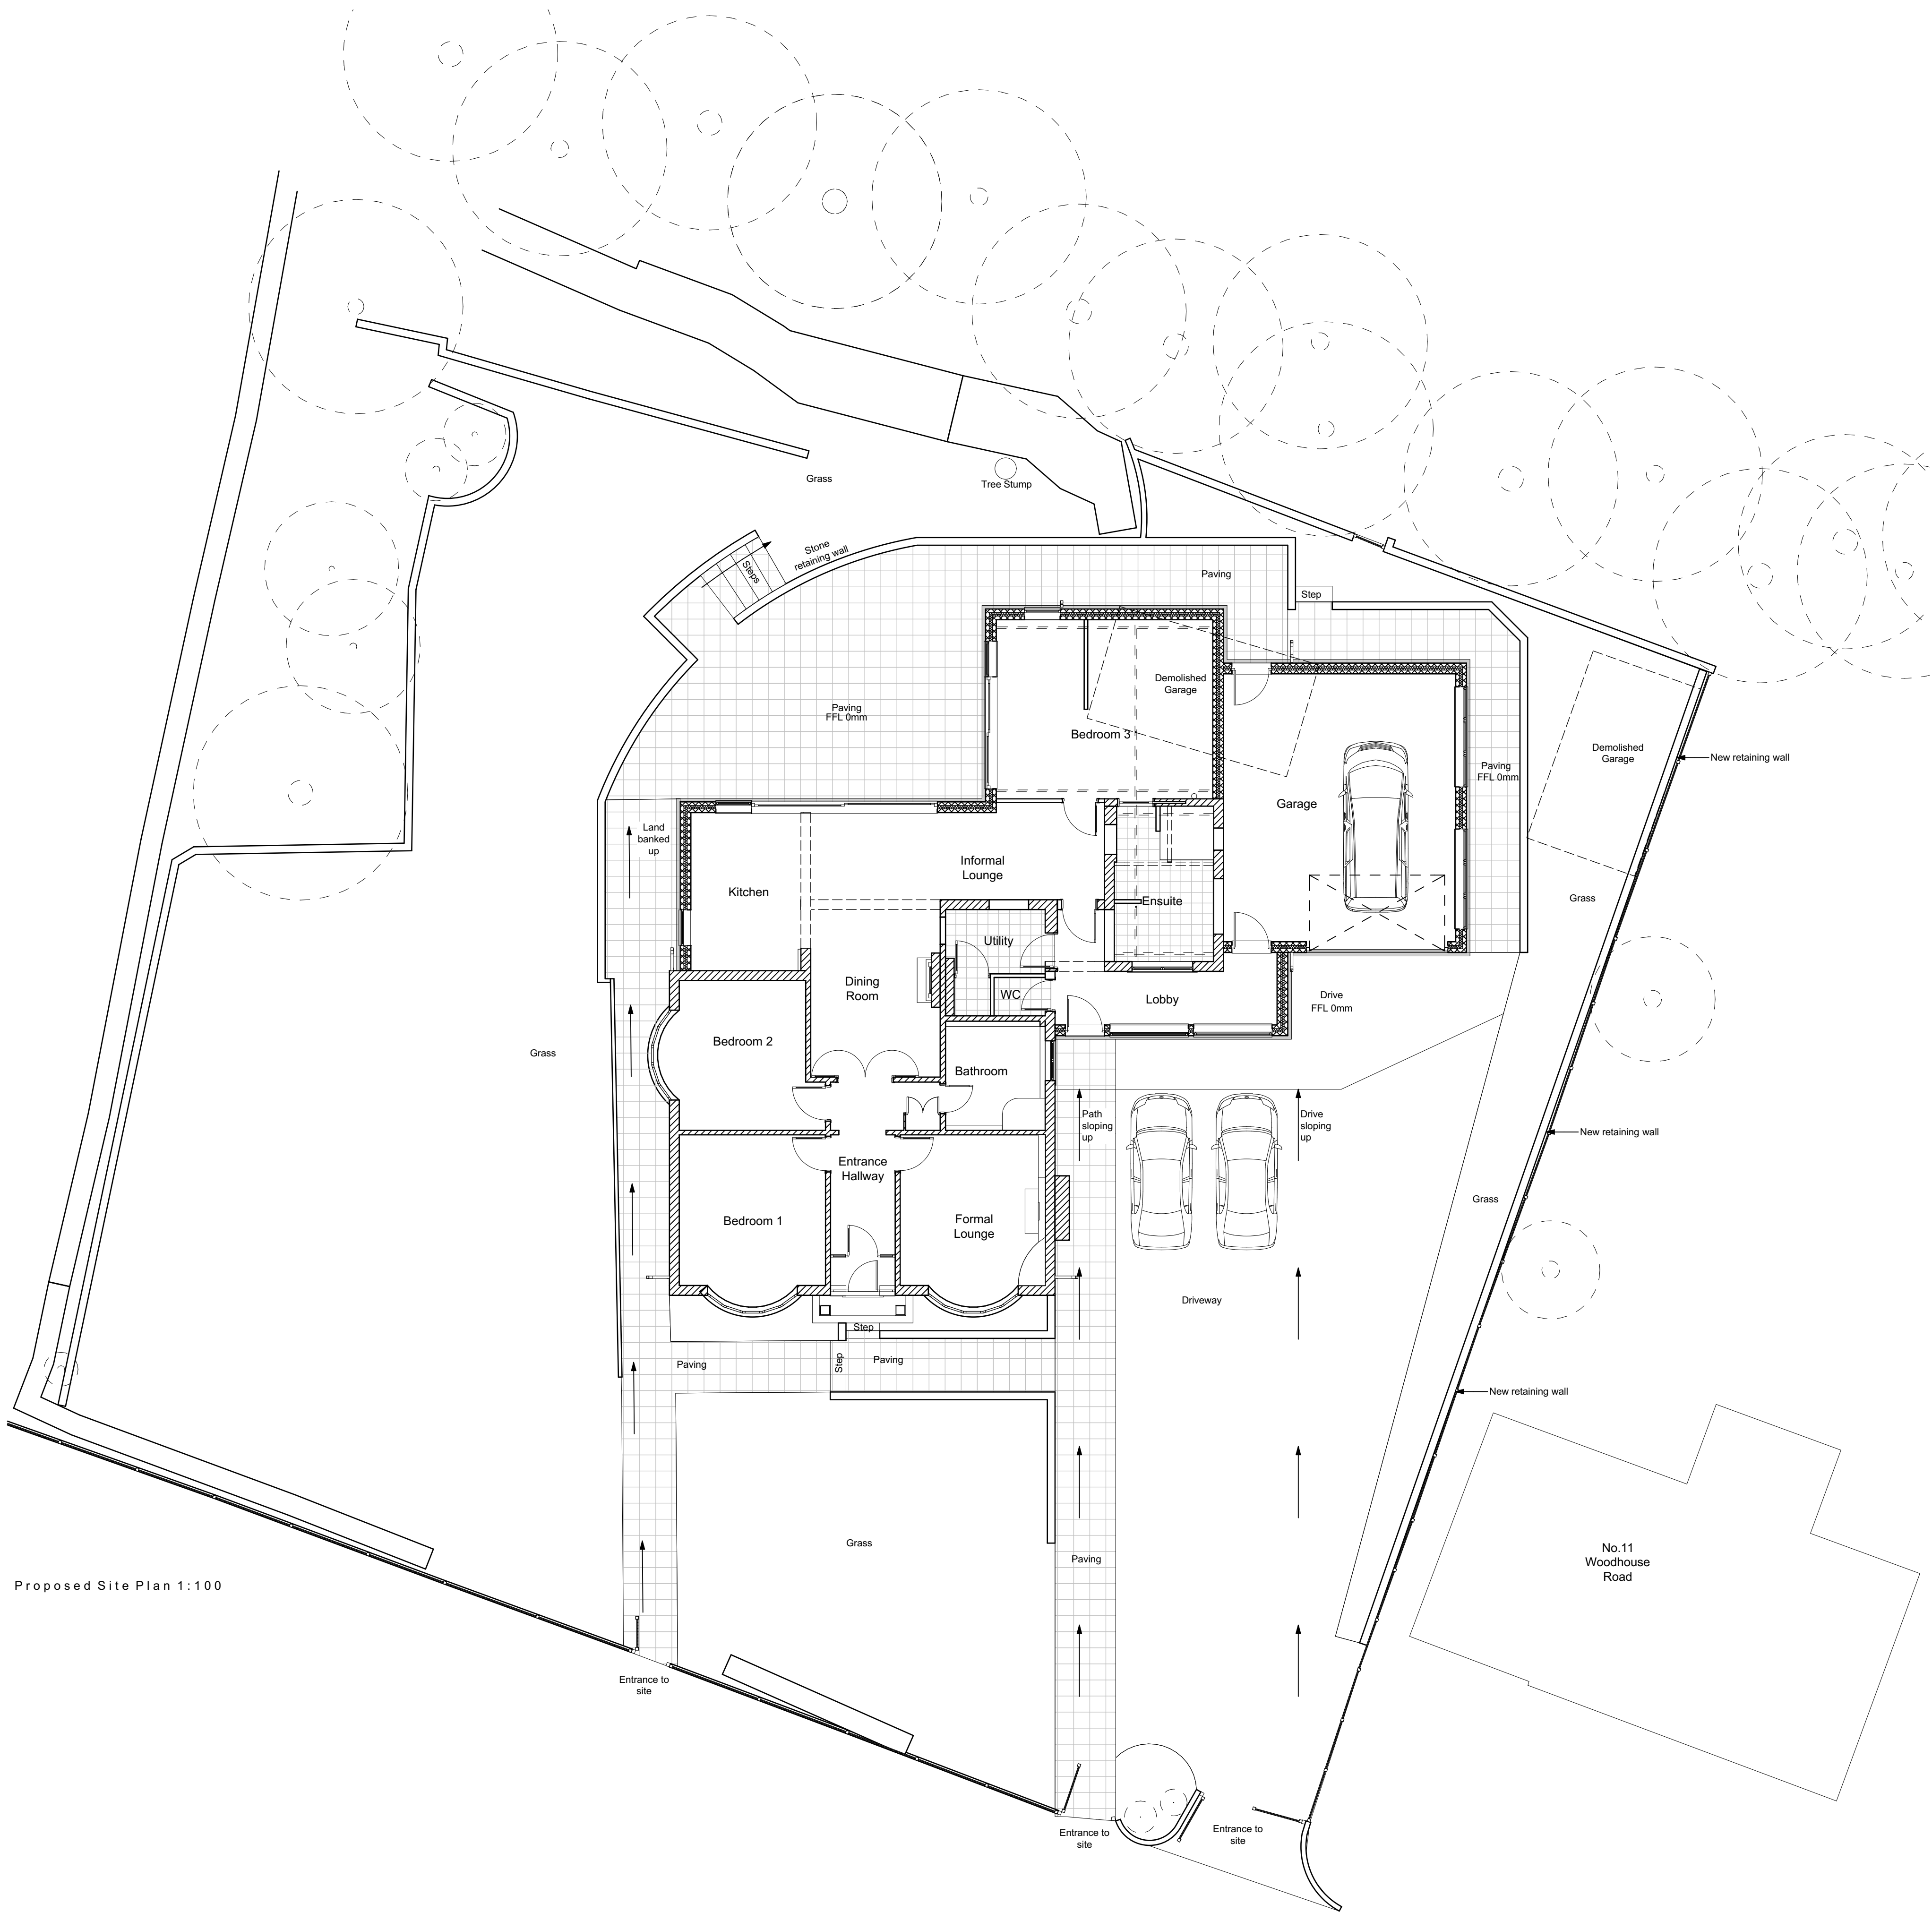

Proposed Site Plan 1:100

|                                                                                                                                                           |                                                     |
|-----------------------------------------------------------------------------------------------------------------------------------------------------------|-----------------------------------------------------|
| Project Status:                                                                                                                                           | PLANNING ONLY                                       |
| <div>ita transform architects...</div> <div>Defining problems with beautiful solutions...</div>                                                           |                                                     |
| 4 Rushmead Court, Ossett, WF5 0NZ<br>tel: 01924 265 080 - fax: 0871 66 11 003<br>web: www.transformarchitects.co.uk email: info@transformarchitects.co.uk |                                                     |
| Project Address:                                                                                                                                          | 13 Woodhouse Road<br>Hoyland<br>Barnsley<br>S74 9AW |
| Client:                                                                                                                                                   | Mr & Mrs Pickles                                    |
| Drawing Title:                                                                                                                                            | Proposed Site Plan A1                               |
| Scale:                                                                                                                                                    | 1:100                                               |
| Date:                                                                                                                                                     | 06.02.2017                                          |
| Drawn By:                                                                                                                                                 | MNB                                                 |
| Drawing Number:                                                                                                                                           | T894 - PL05                                         |
| Revision:                                                                                                                                                 | Nil                                                 |