



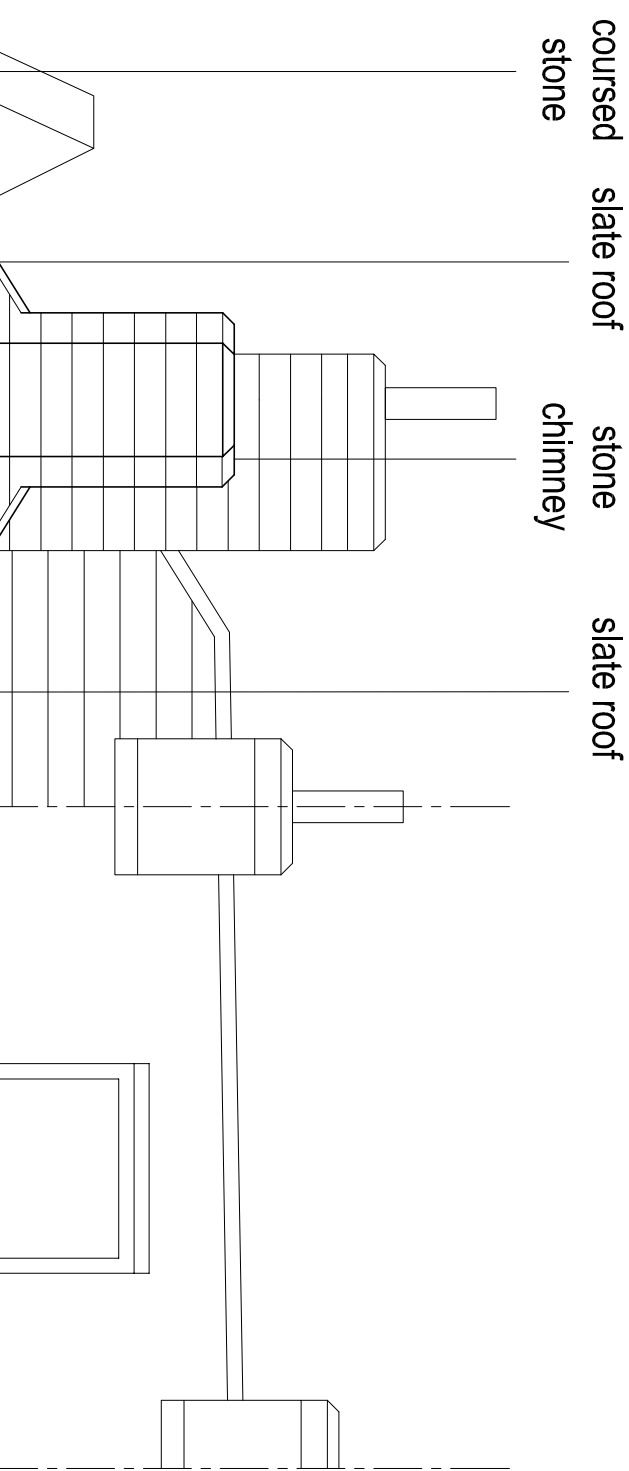

NOTES

1. This drawing is copyright.
2. Do not scale from drawing.
3. Contractor to check and verify that dimensions, details, drainage layouts etc. correspond to working drawings before providing client with final quotation, commencing work on site or fabricating specific bespoke items.
- Contractor / Subcontractor to bring any discrepancy to the attention of the Architect.
4. Client and Contractor to study and understand the contents of drawings and approvals relating to the project as no claim arising out of the failure to do so will be entertained.
5. Conditions stated in either the current title deed or council approvals should be complied with to the satisfaction of the local authority or any other relevant party.
6. All applicable health and safety requirements to be complied with during and after construction.
7. Drawing to be read in conjunction with specifications, notes and structural calculations.

PROPOSED SIDE ELEVATION 1:50

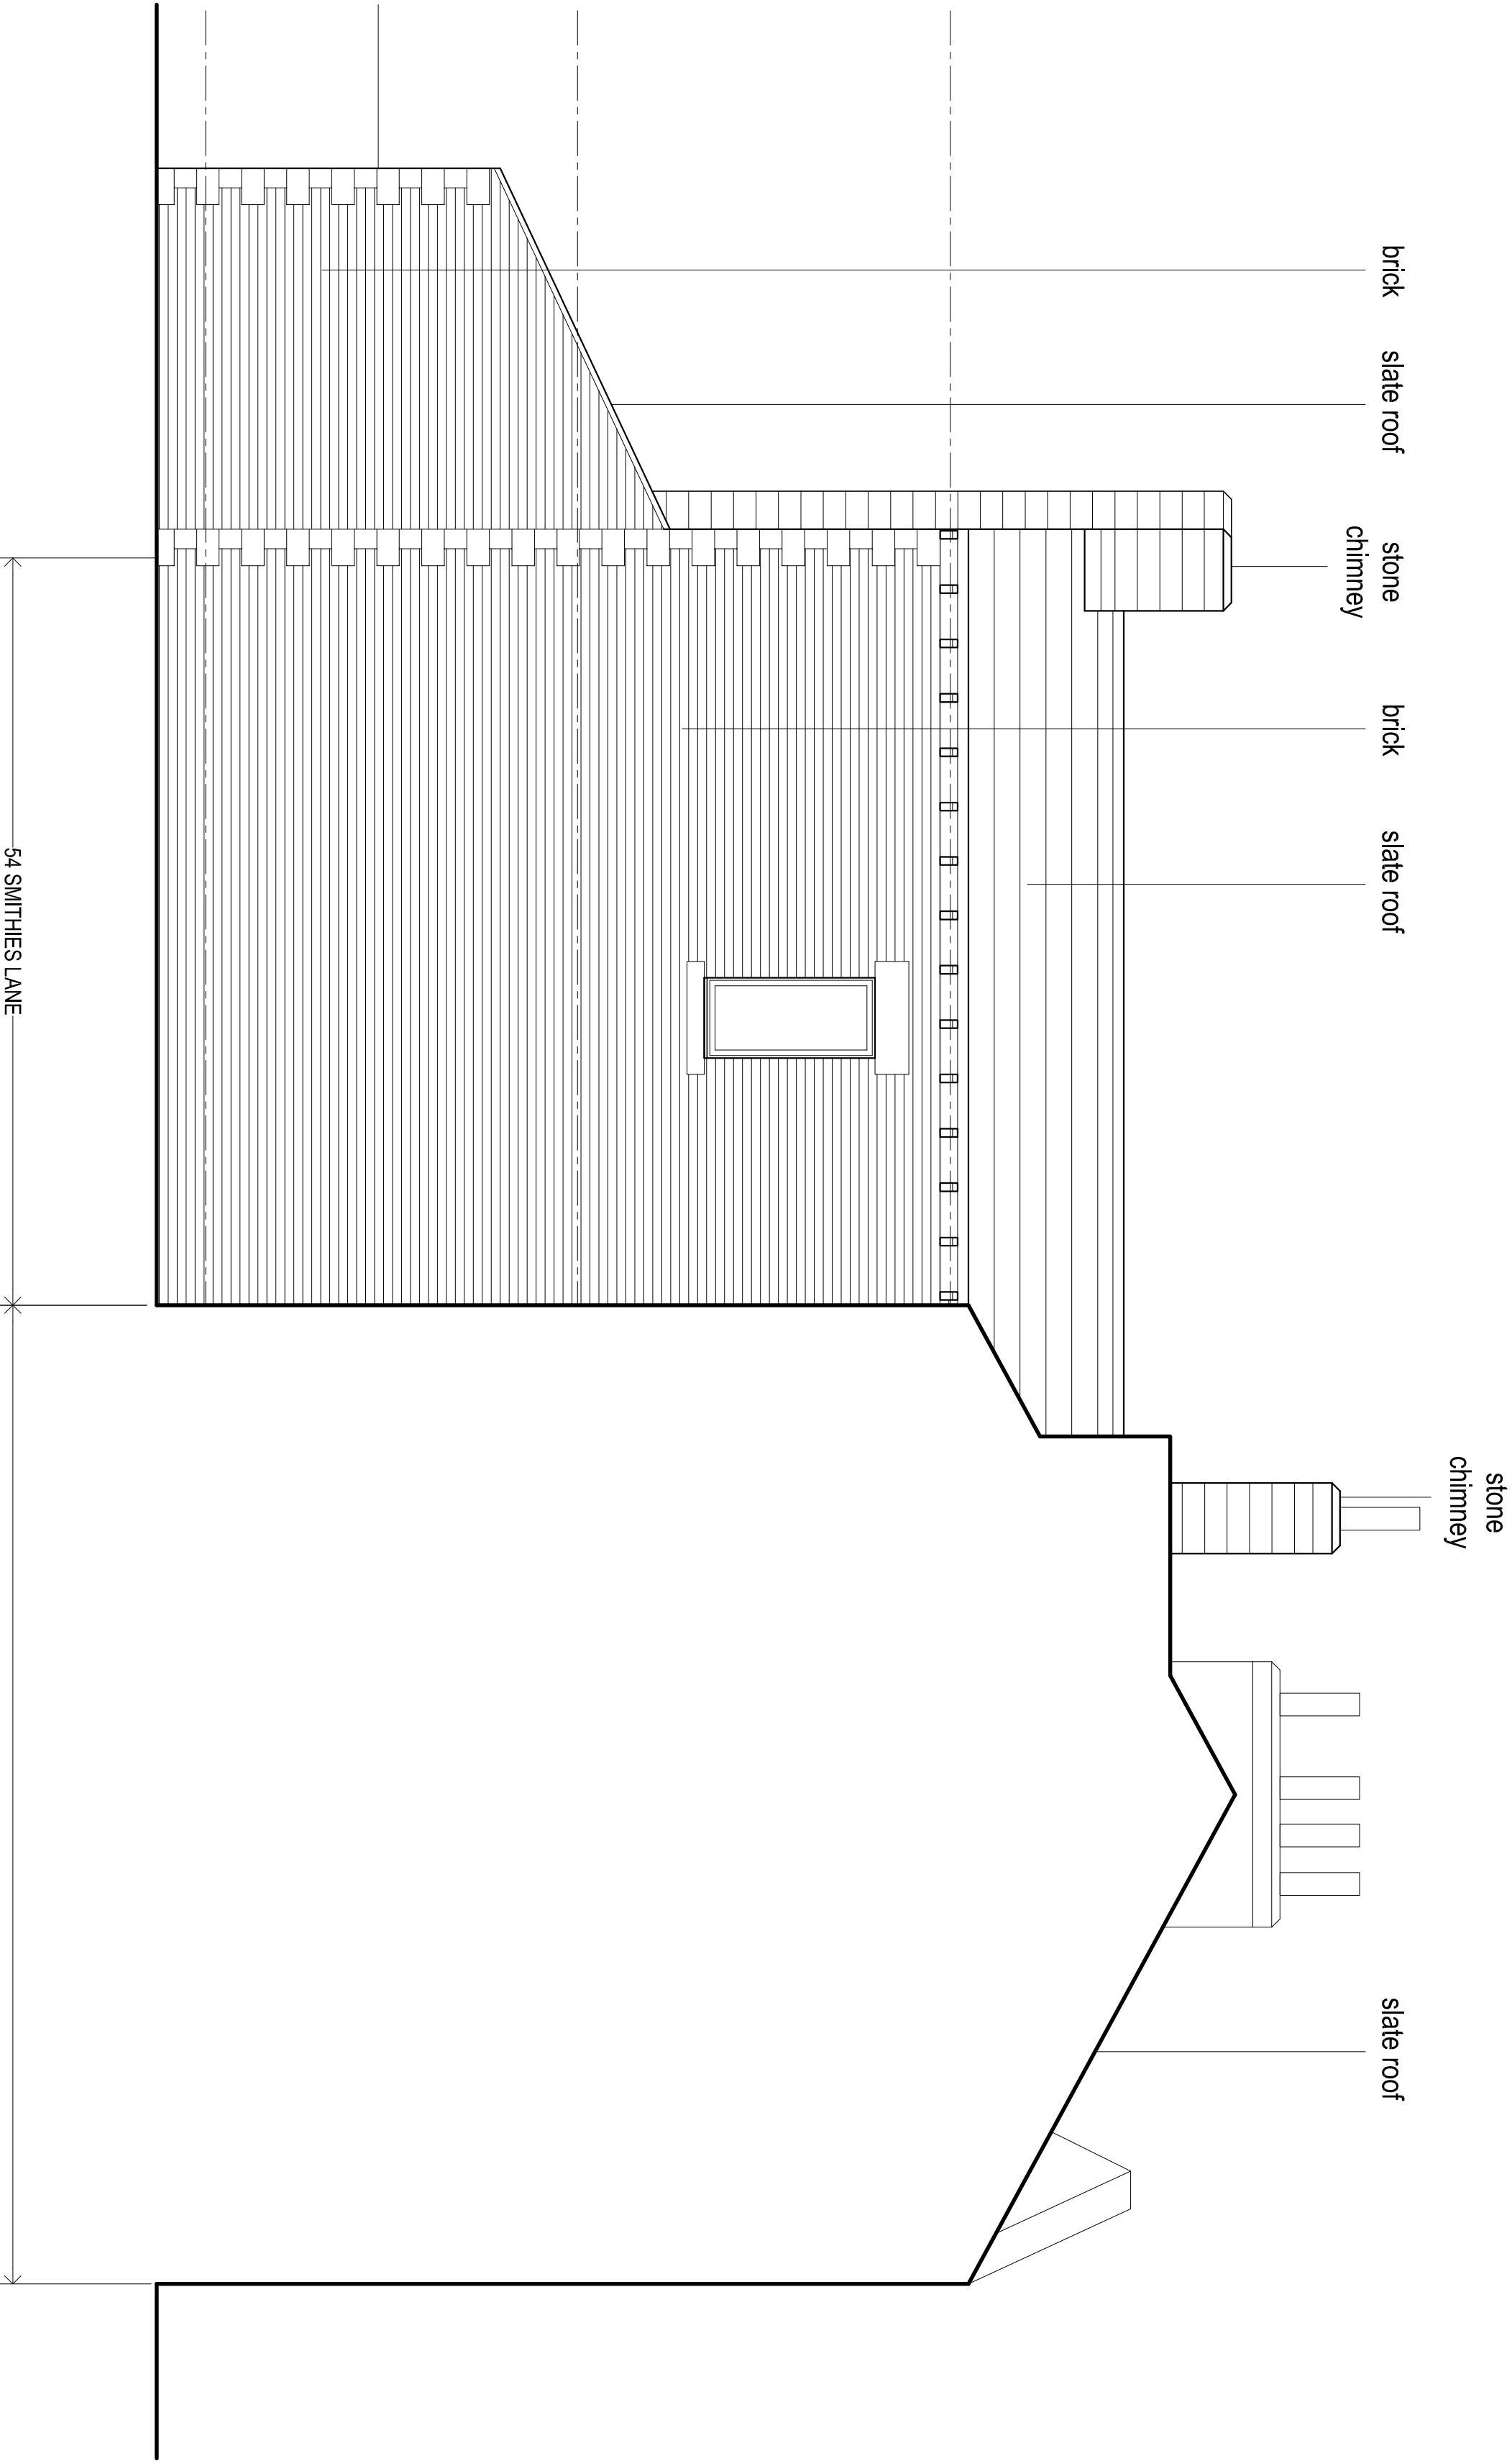

NEIGHBOURING
PROPERTY (INDICATIVE)

flat roof

cladding
panels

54 SMITHIES LANE

NEIGHBOURING
PROPERTY (INDICATIVE)

PROPOSED REAR ELEVATION 1:50



Project	Extension & Alterations for Ms Amy Styles at: 54 Smithies Lane, Barnsley, S71 1QW.
Drawing Title	Proposed Elevations
Drawing no.	14
Scale	STATED @ A1
Date	02/07/20
Drawn	DM
Stage	Planning
Revision	