


Dimensions are not to be scaled from this drawing



Kingfisher Lighting

Part of the Luceco PLC group of companies

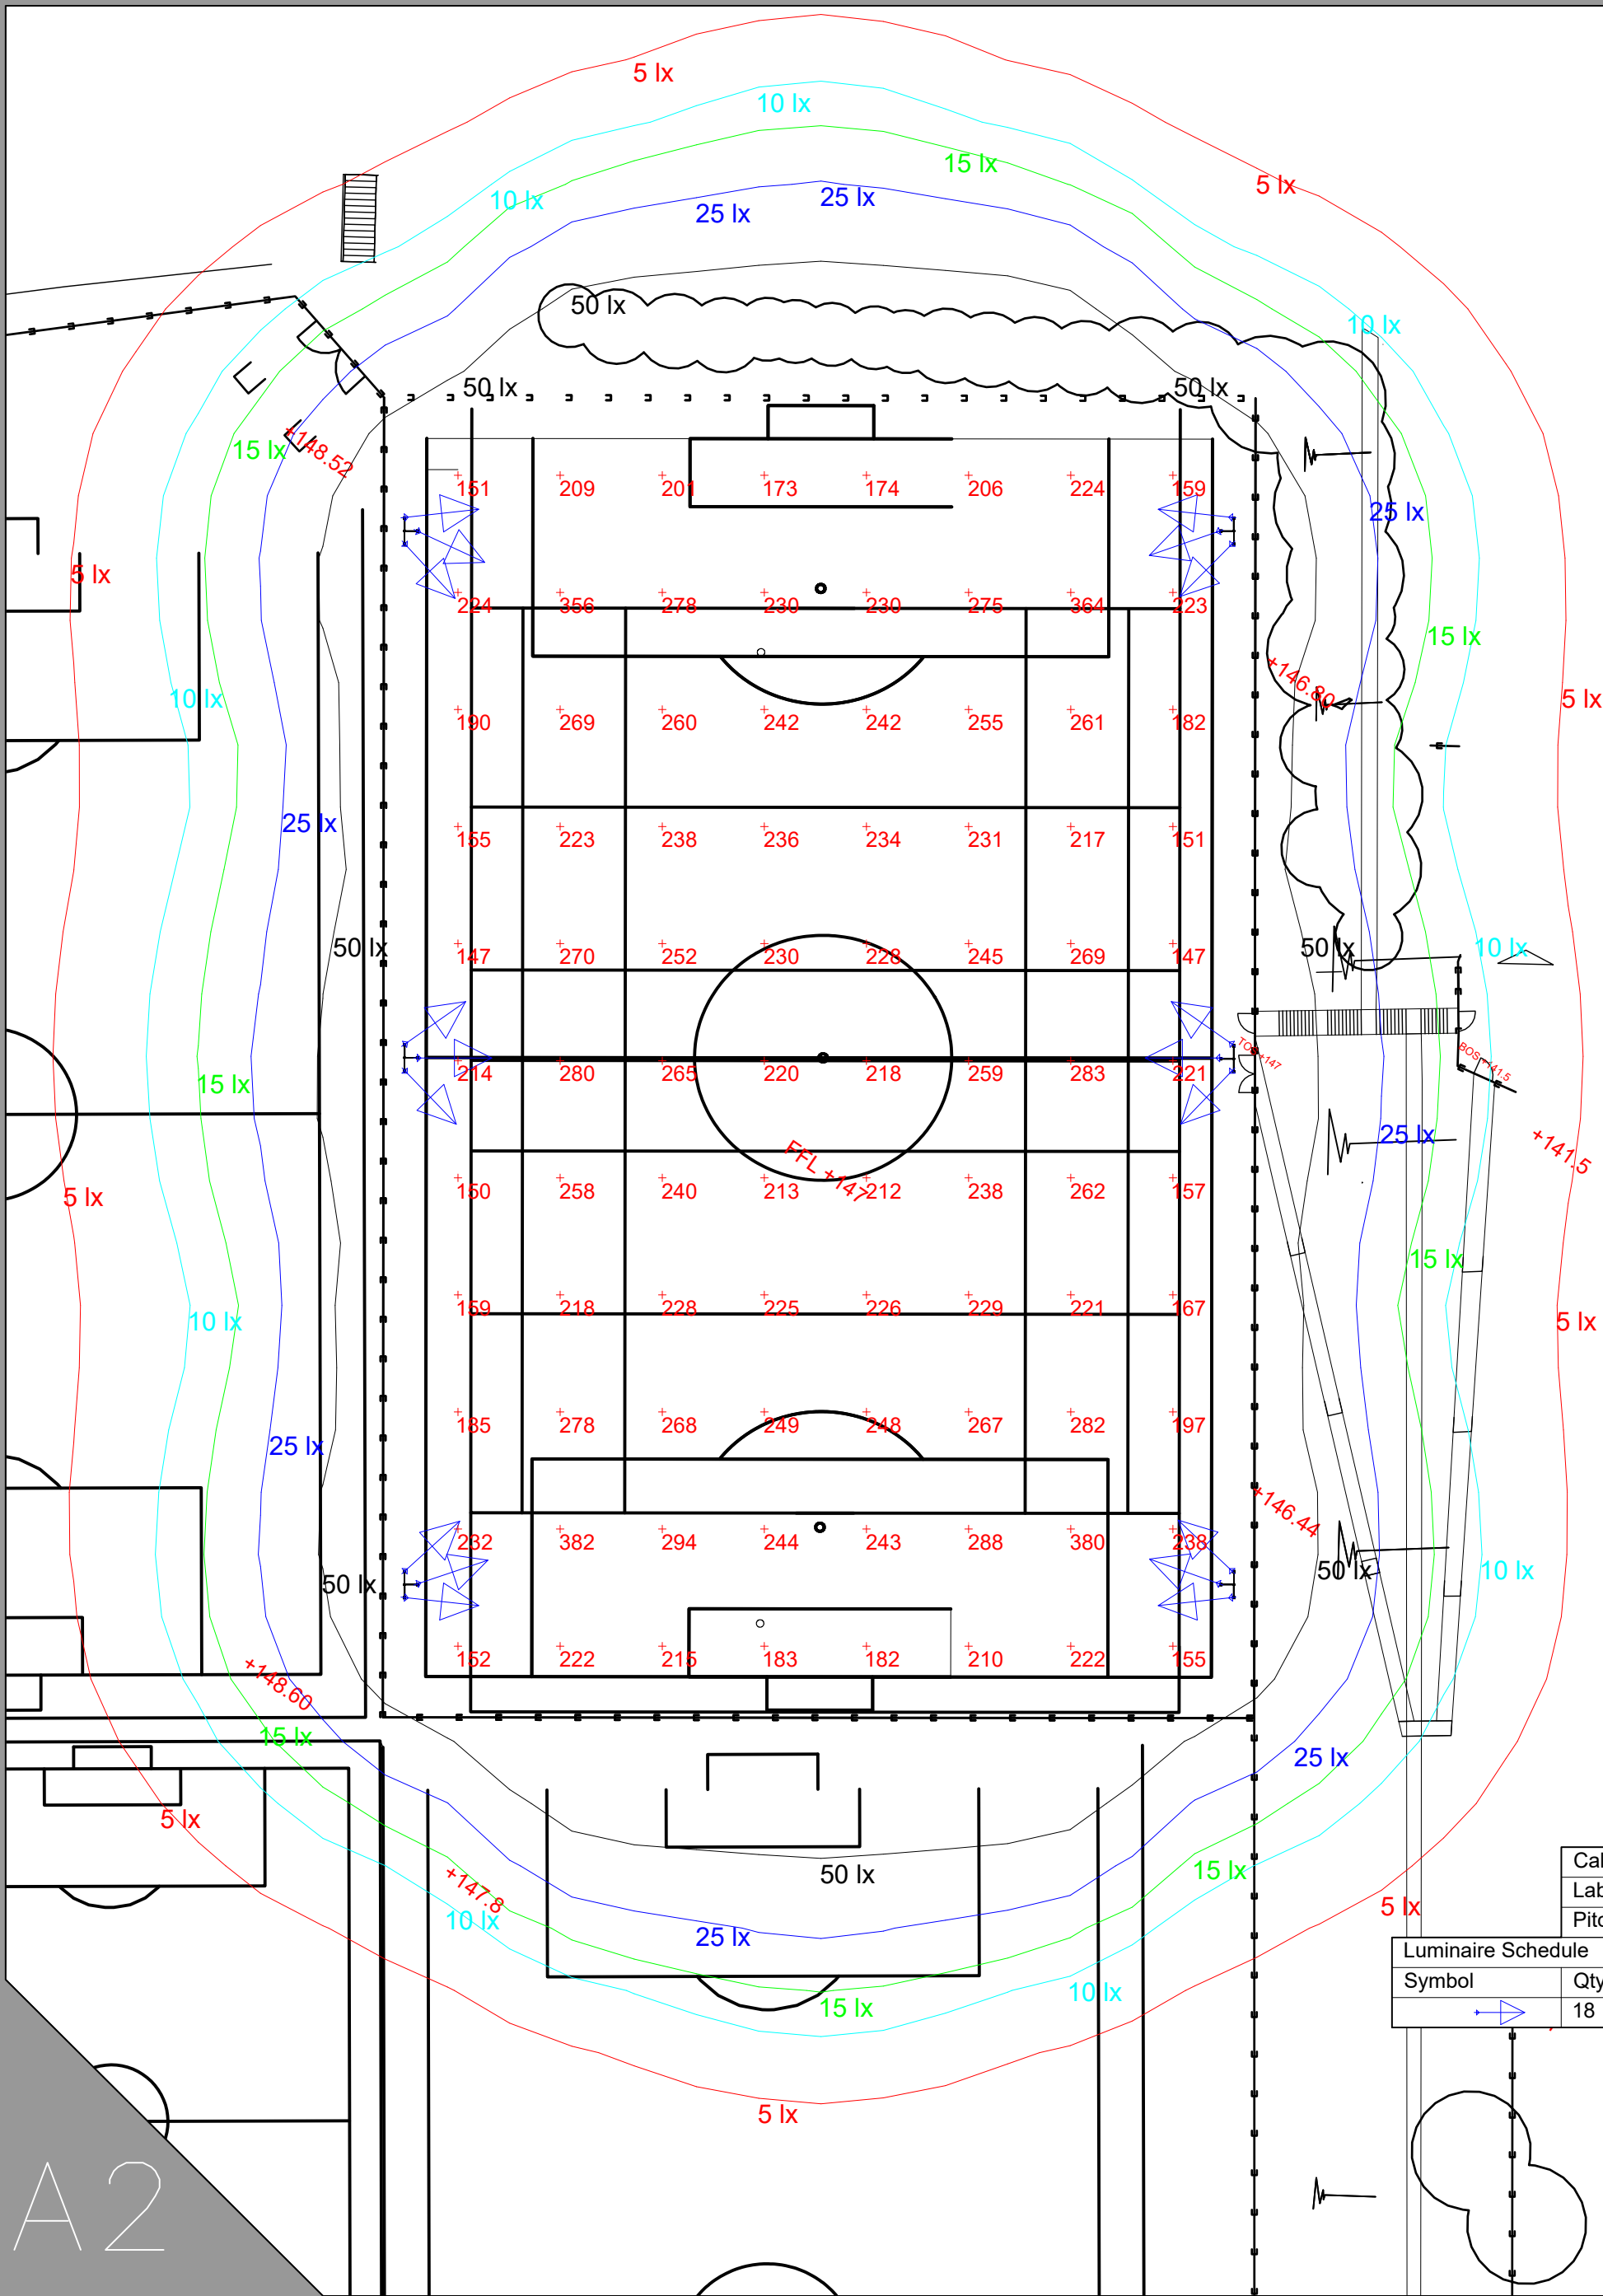

| Calculation Summary |             |       |        |     |     |         |         |
|---------------------|-------------|-------|--------|-----|-----|---------|---------|
| Label               | CalcType    | Units | Avg    | Max | Min | Min/Avg | Min/Max |
| Pitch               | Illuminance | Lux   | 229.89 | 382 | 147 | 0.64    | 0.38    |

| Luminaire Schedule |     |       |             |                                           |
|--------------------|-----|-------|-------------|-------------------------------------------|
| Symbol             | Qty | Label | Arrangement | Description                               |
|                    | 18  | A     | SINGLE      | 1 x 900w Amnis Flood with NST Optic @ 15m |



Project Title: Trinity Academy

Scale  
1:500 at A2

Project Number  
44255



For our LED lighting designs a 0.9mf has been used. If this differs from the maintenance period for this project then you must advise us accordingly

Date  
08/10/2021

Drawing No.  
Rev A

Lighting Designer

A lighting applications design service is provided by us in good faith and without charge, relating to Kingfisher products only. As such, whilst every endeavor is made for accuracy from information provided by yourselves, the final responsibility for the suitability of the design lies with the client. The company cannot, therefore, accept any liability or consequential loss incurred.

A2