

Contractor must verify all dimensions on site before commencing any work or shop drawings. If this drawing exceeds the quantities taken in any way, the building designers are to be informed before the work is initiated.


Only figured dimensions to be taken from this drawing. Do not scale off this drawing.

Drawing based on Ordnance Survey and/or existing record drawings - design and drawing content subject to Site Survey, Structural Survey, Site Investigations, Planning and Statutory Requirements and Approvals.

All drainage layouts are schematic and invert levels must be established prior to construction.




Front Elevation 1:100

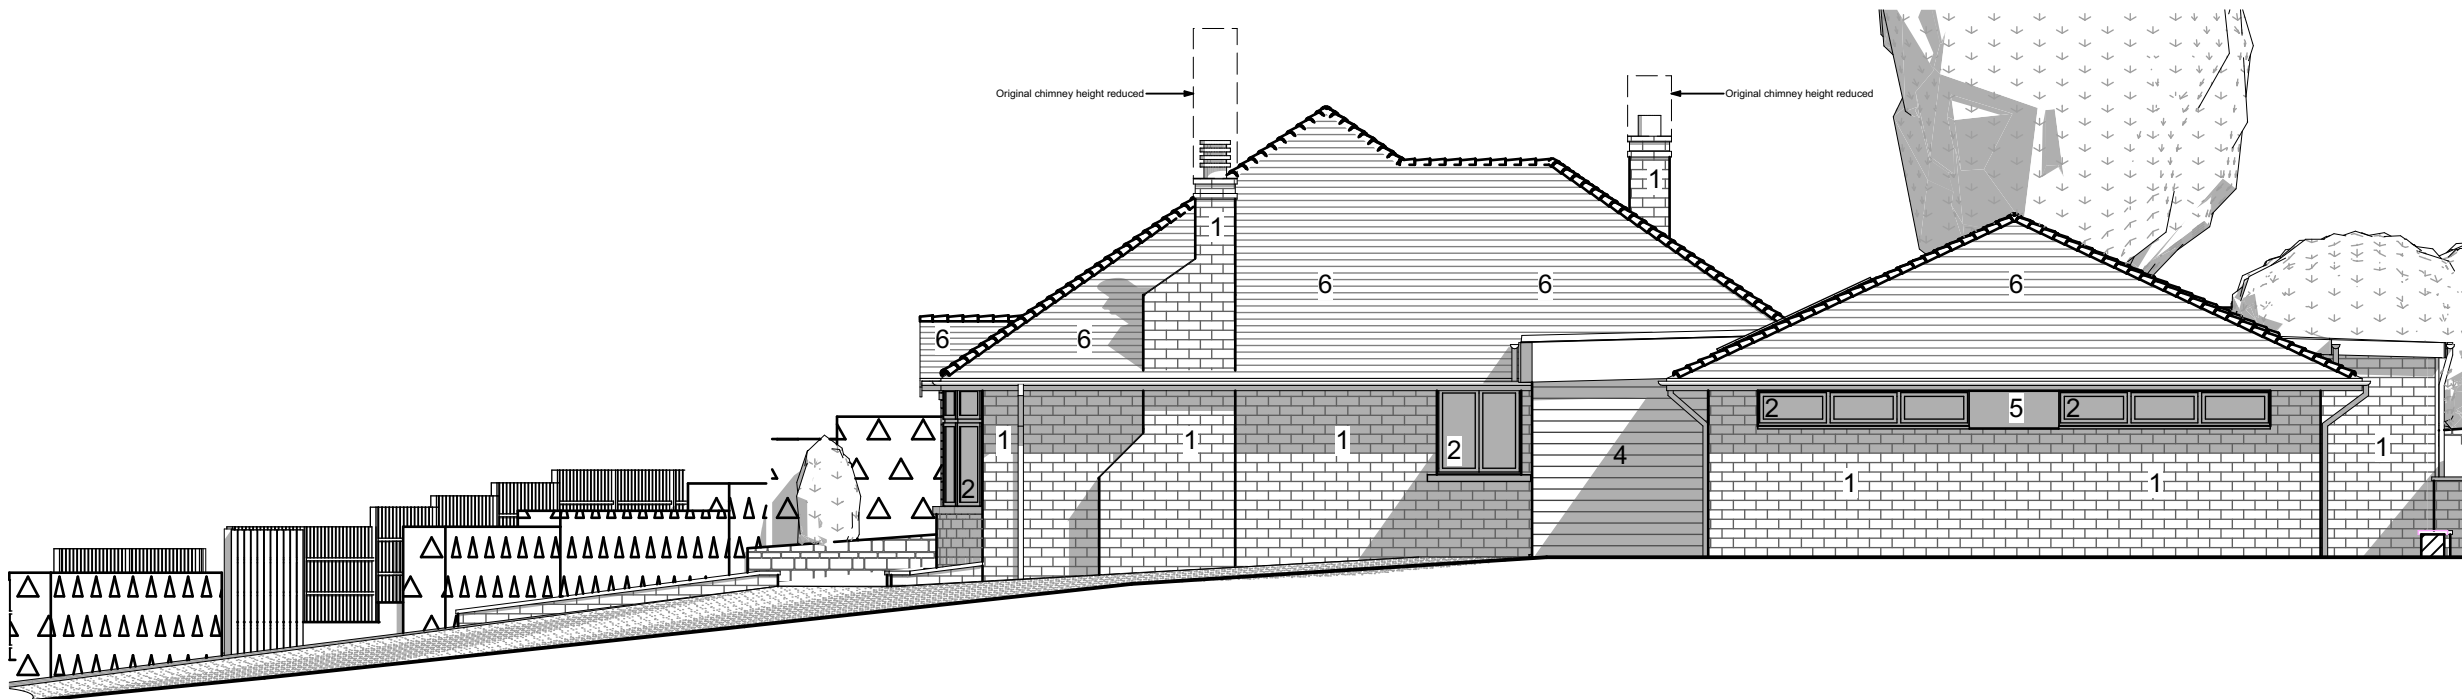

Side 01 Elevation 1:100



Elevation From No.11 Woodhouse Road 1:100

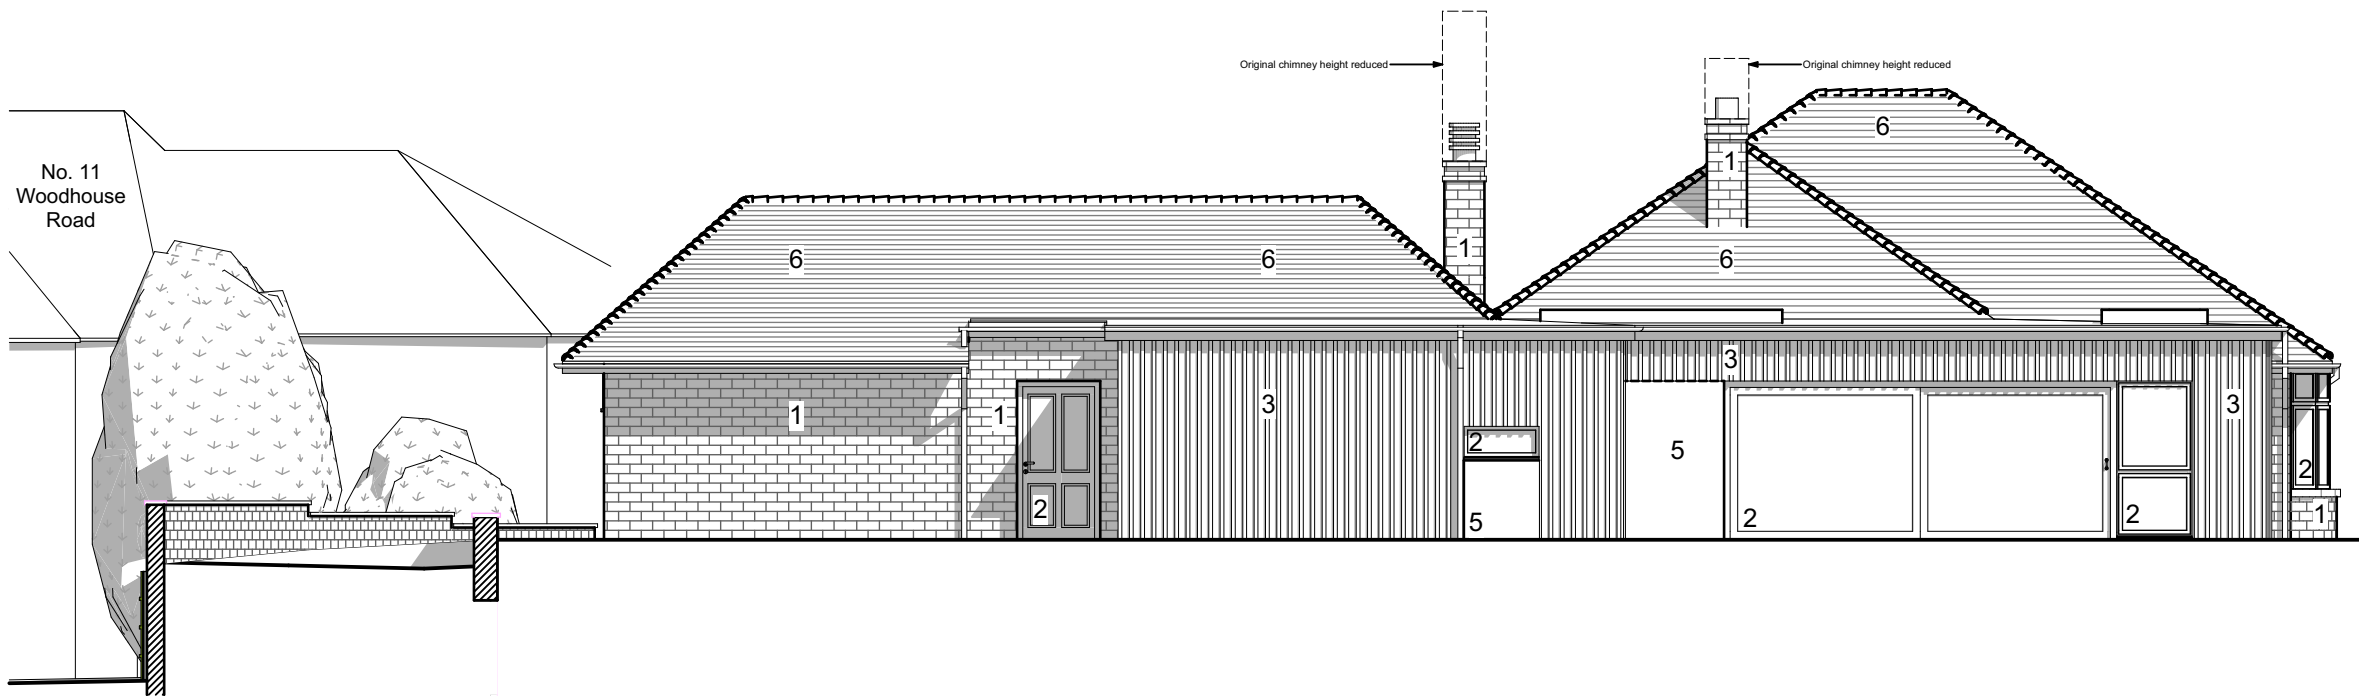


Rear Elevation 1:100

Material Key:


1. Stonework.
2. Black Ral 9005 windows and doors.
3. Vertical board on board timber cladding.
4. Horizontal timber cladding.
5. Black Ral 9005 Aluminium
6. Grey roof tiles.
7. Solar thermal panels.

Note:
All black soffits, fascias, gutters and rainwater pipes.

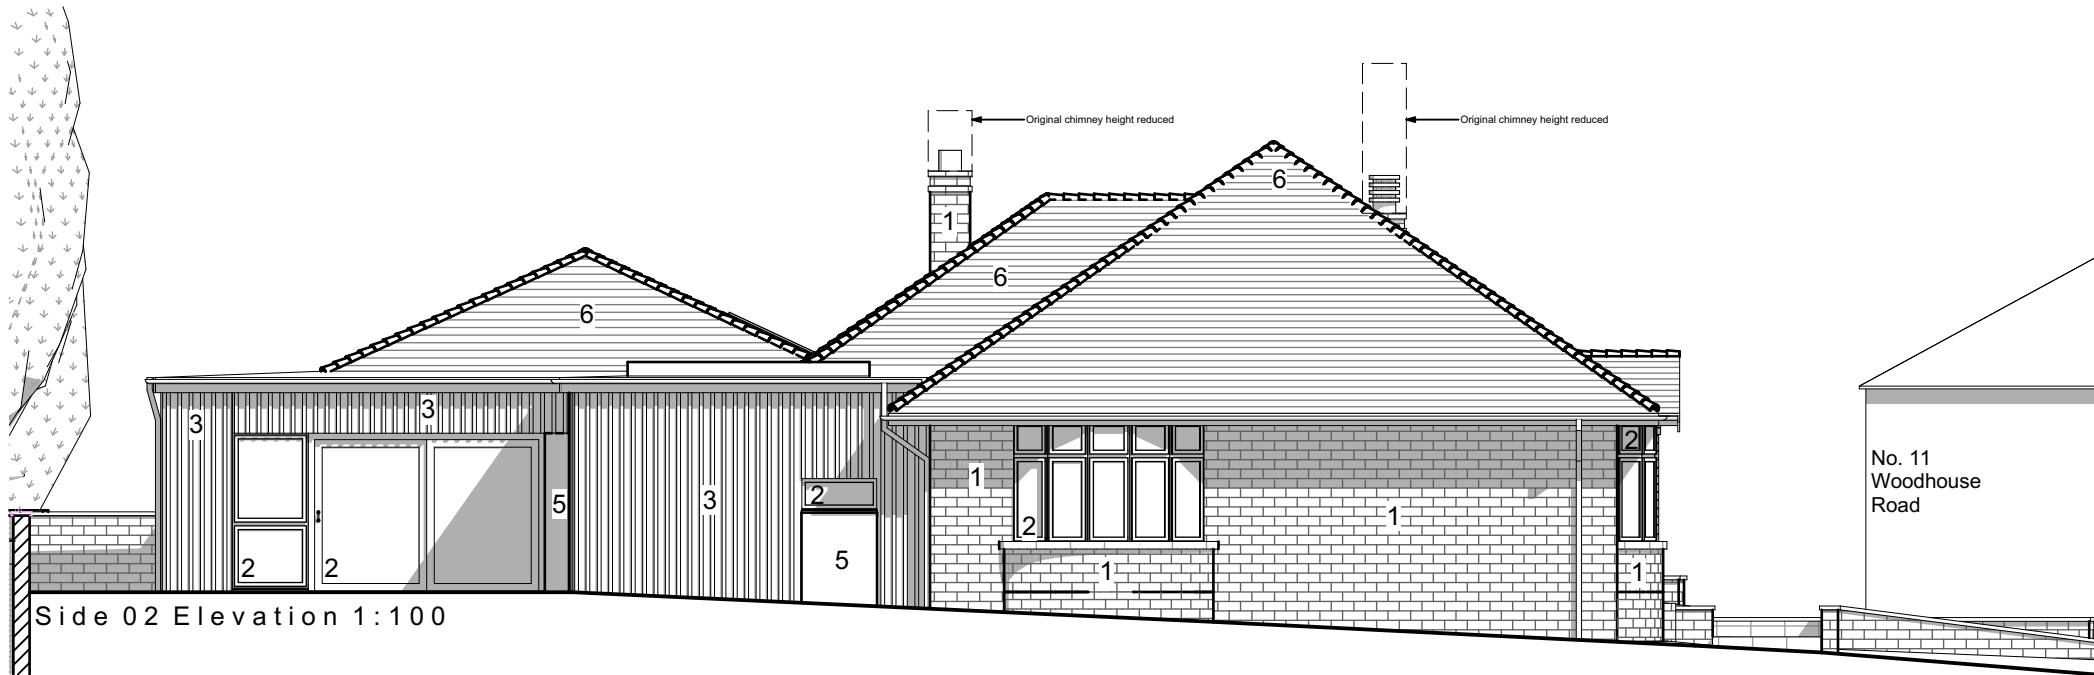


Side 02 Elevation 1:100

Site Block Plan 1:500

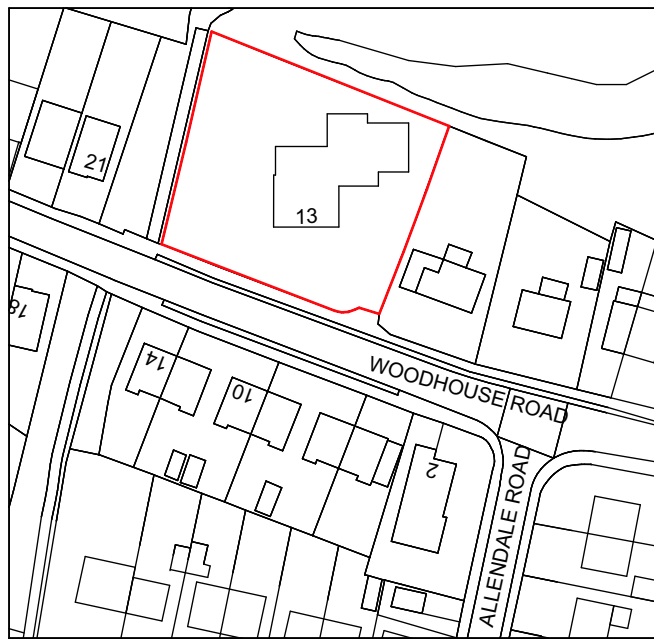

Site Location Plan 1:1250

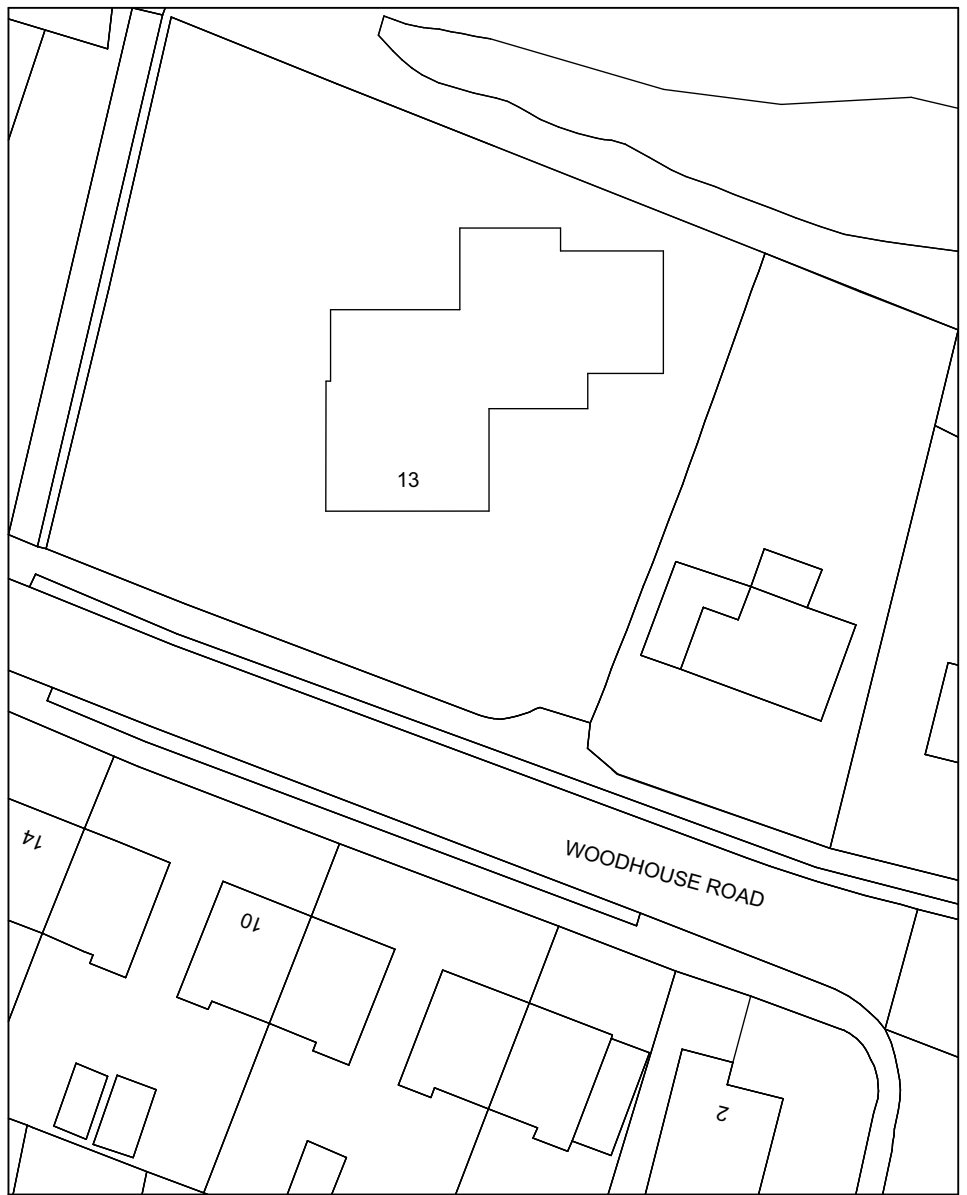

Site Block Plan 1:500

Rev A - 27.03.2017 Roof pitch changed to clients request. JN

Project Status: PLANNING ONLY

ita transform
architects...
Defining problems with beautiful solutions...

4 Rushmead Court, Ossett, WF5 0NZ
tel: 01924 265 080 - fax: 0871 66 11 003
web: www.transformarchitects.co.uk email: info@transformarchitects.co.uk

Project Address:	13 Woodhouse Road Hoyland Barnsley S74 9AW
Client:	Mr & Mrs Pickles
Drawing Title:	Proposed Elevations A1
Scale:	1:100, 1:1250, 1:500
Date:	27.03.2017
Drawn By:	MNB
Drawing Number:	T894 - PL04
Revision:	Rev A