


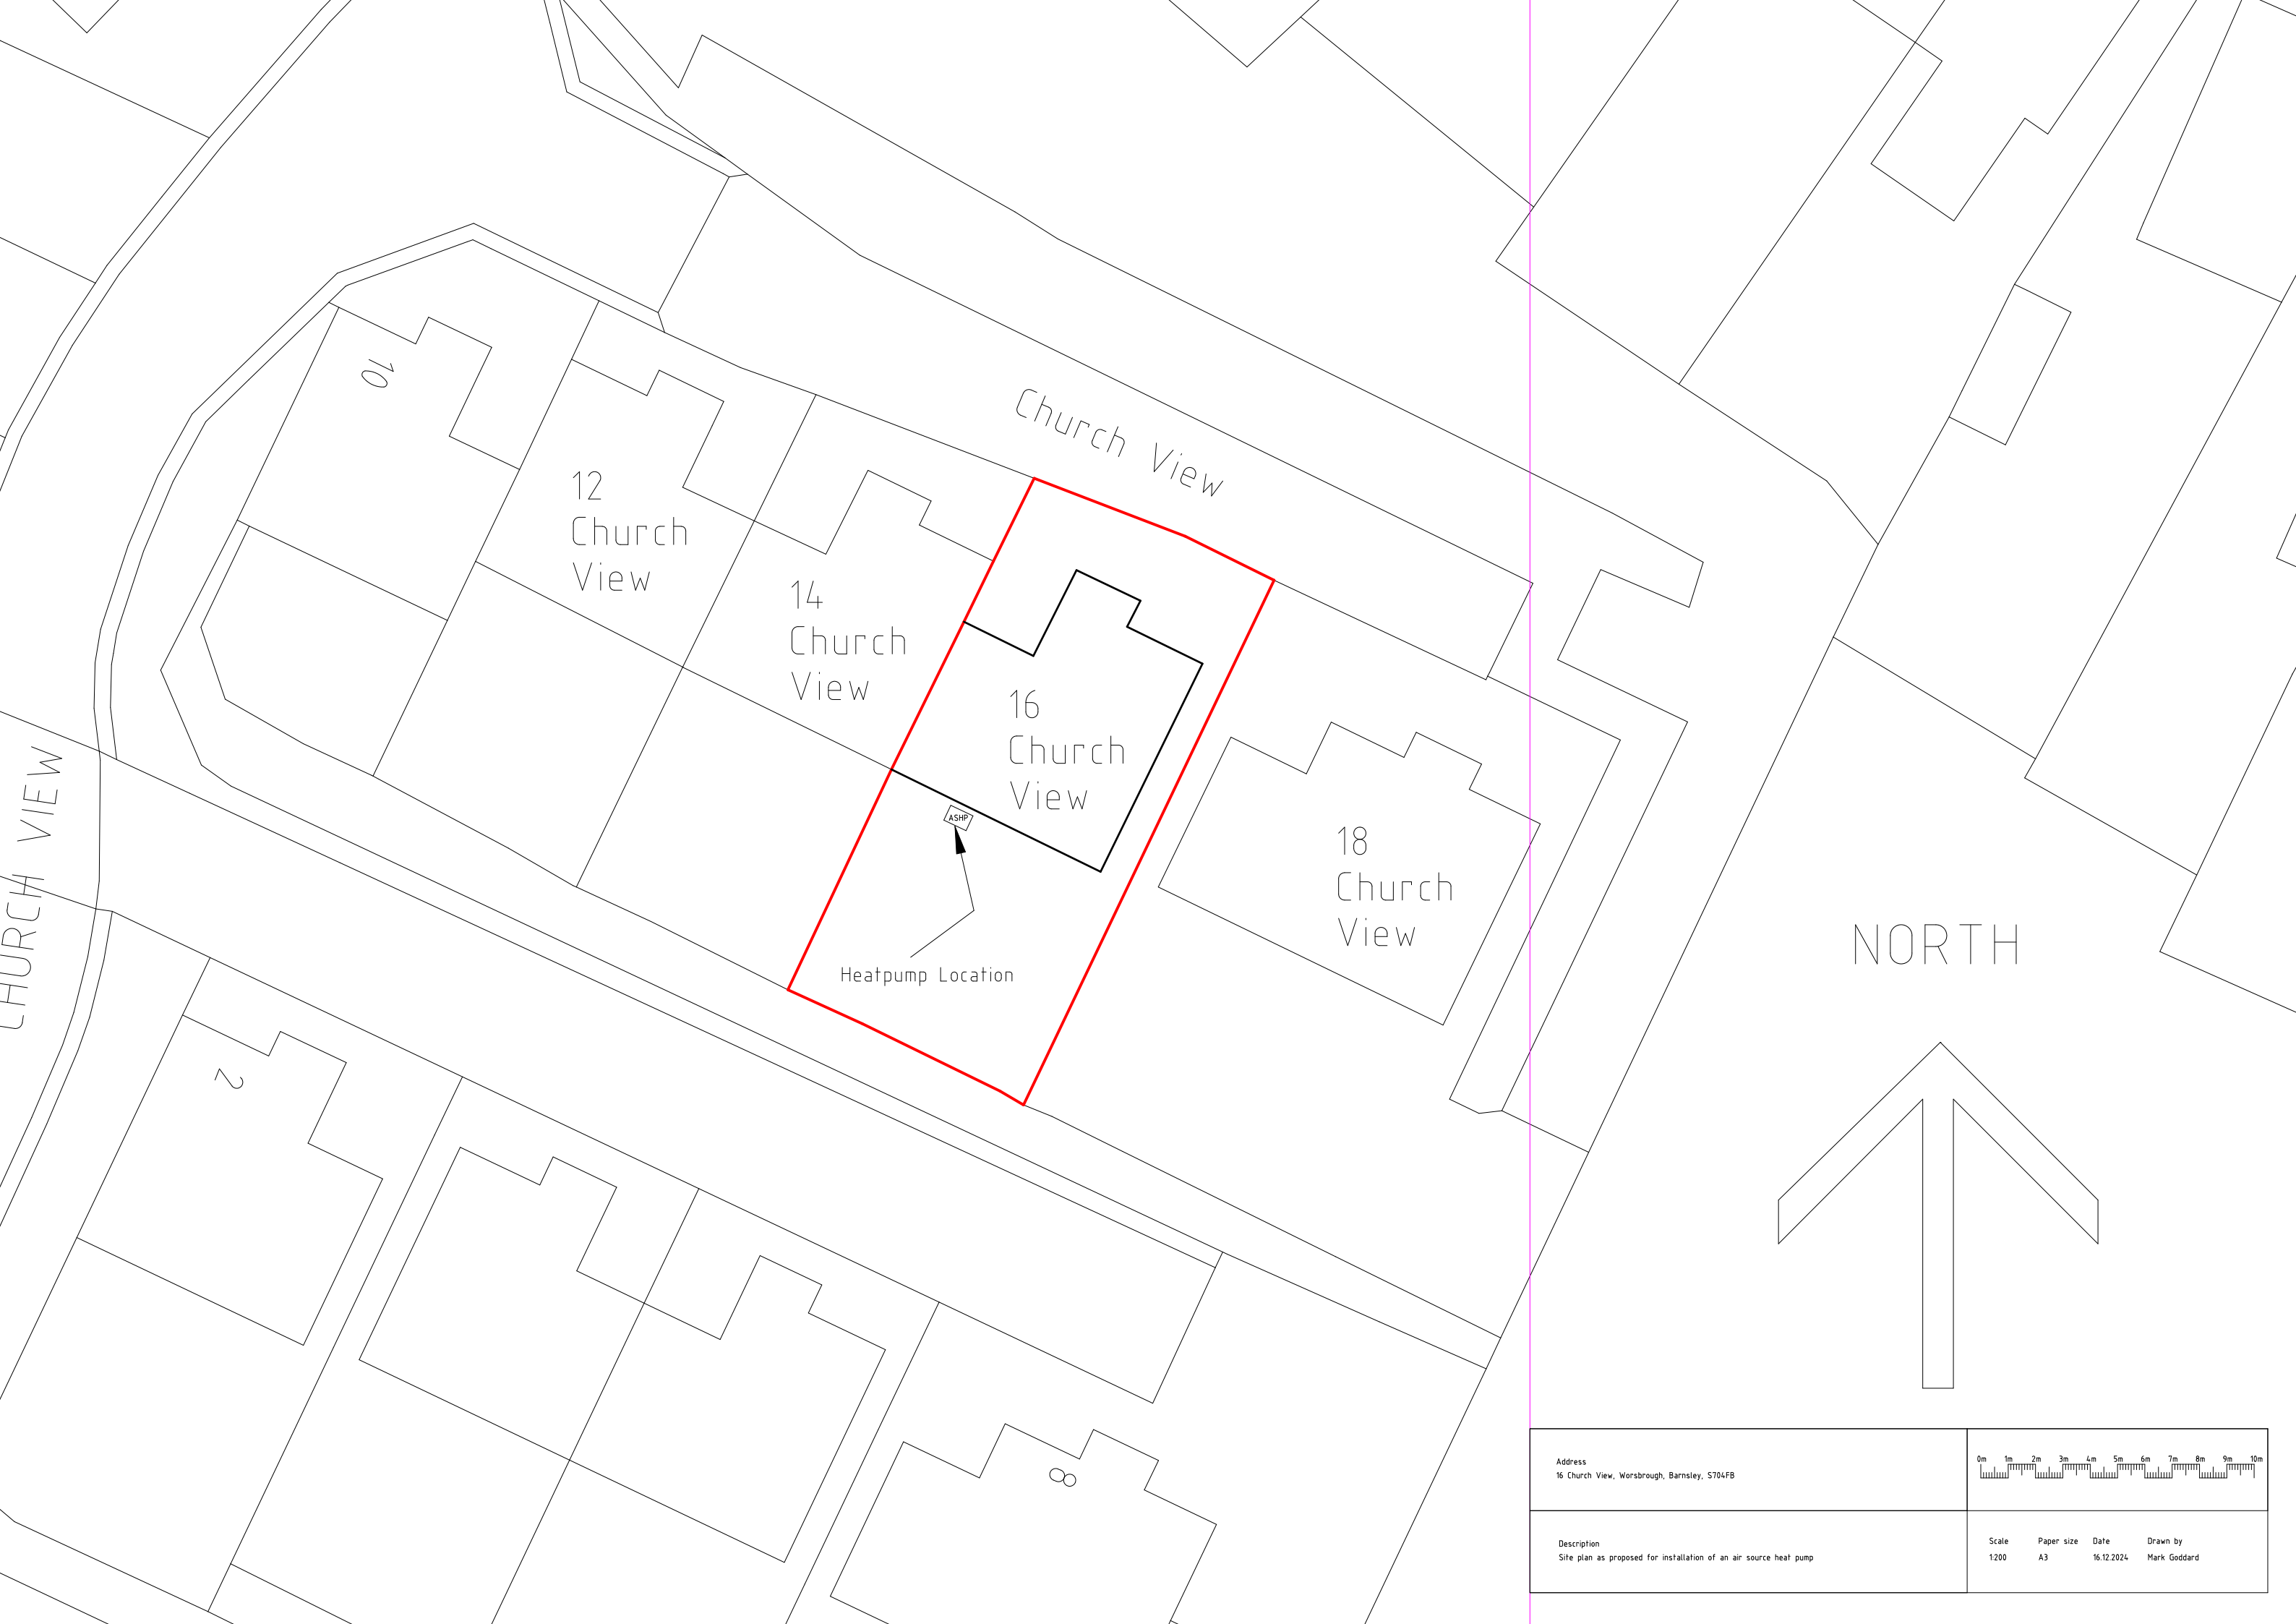

CHURCH VIEW

Church View

12
Church
View

14
Church
View

16
Church
View

18
Church
View

NORTH

Heatpump Location

ASHP

Address 16 Church View, Worsbrough, Barnsley, S704FB	0m1m2m3m4m5m6m7m8m9m10m
Description Site plan as proposed for installation of an air source heat pump	Scale 1:200 Paper size A3 Date 16.12.2024 Drawn by Mark Goddard