


Notes

1. THIS DRAWING IS NOT TO BE SCALED.
2. THIS DRAWING IS TO BE READ IN CONJUNCTION WITH ALL RELEVANT ARCHITECTURAL, STRUCTURAL AND M&E DRAWINGS.
3. THIS IS NOT AN INSTALLATION DRAWING NOR A CO-ORDINATION DRAWING.
4. REFER TO RAMBOLL DRAWING BAR-RAM-ZZ-XX-DR-CD-00100 FOR THE DRAINAGE LAYOUT.
5. THE DESIGN AND CONSTRUCTION OF MANHOLES WILL NEED TO COMPLY WITH THE RELEVANT UNDERTAKER'S SAFETY POLICY.

TYPICAL DETAILS OF WAVIN OSMA AQUACELL ATTENUATION TANK

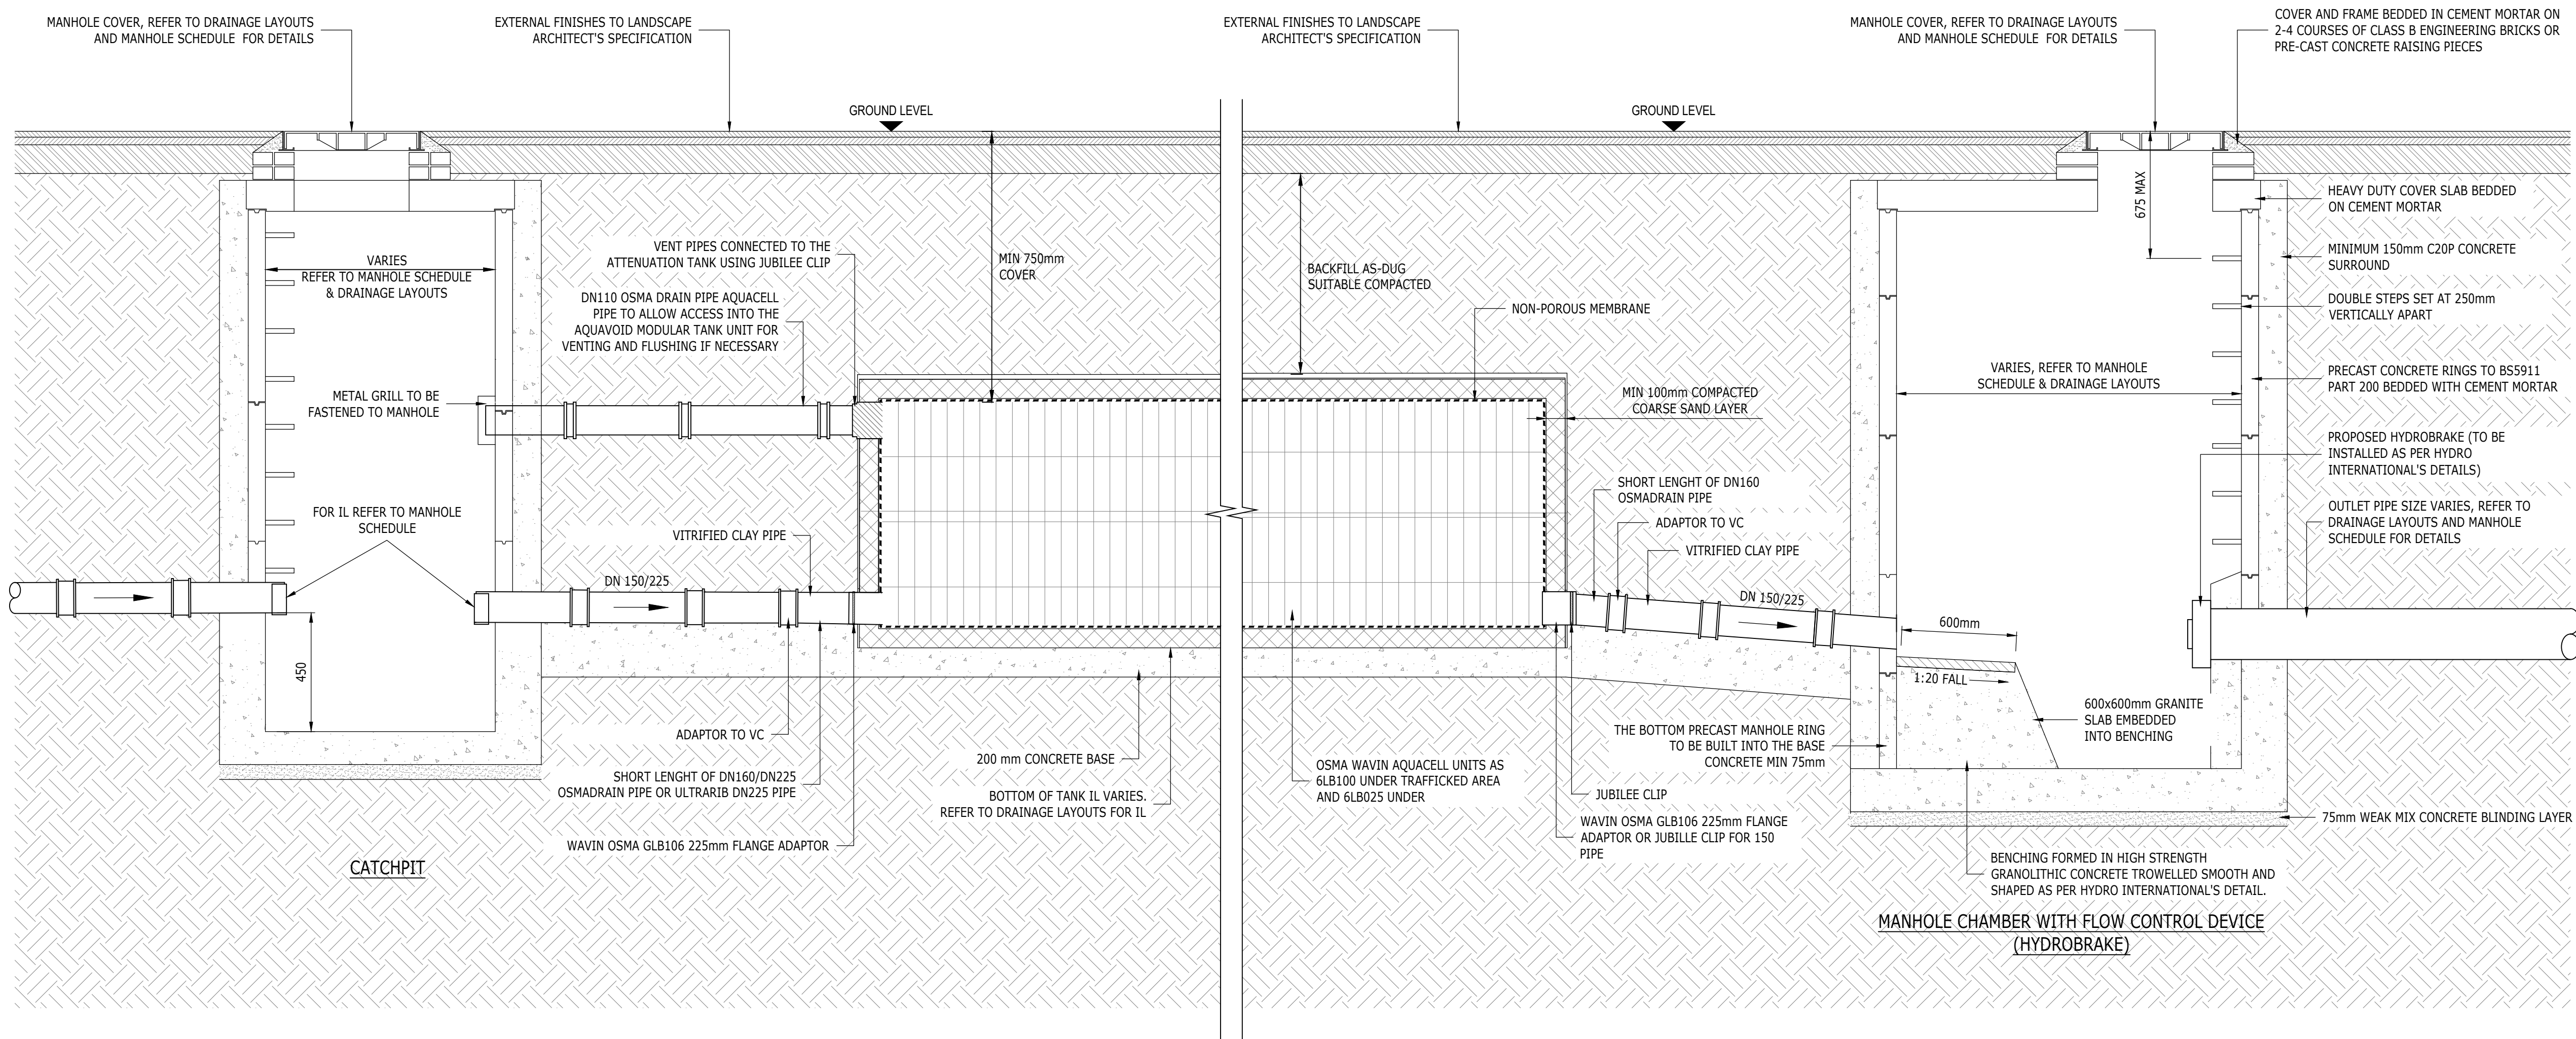

T2	ISSUED FOR TENDER	10.03 2023	EA	NH
T1	ISSUED FOR TENDER	19.02 2023	EA	NH
Rev	Description	Date	By	App

TENDER

ONSIDE - BARNSELY  
YOUTH ZONE

RAMBOLL

tel 020 7631 5291 london@ramboll.co.uk  
www.ramboll.co.uk

PROPOSED  
DRAINAGE DETAILS  
SHEET 3

Project No:	Scale (@A1):	Drawn:	Date:
1620014415-004	NTS	EA	FEB 2023
Drawing No:	Rev:		
BAR-RAM-ZZ-XX-DR-CD-00402	T2		