


Contractor must verify all dimensions on site before commencing any work or shop drawings. If this drawing exceeds the quantities taken in any way, the building designers are to be informed before the work is initiated.
 Only figured dimensions to be taken from this drawing. Do not scale off this drawing.
 Drawing based on Ordnance Survey and/or existing record drawings - design and drawing content subject to Site Survey, Structural Survey, Site Investigations, Planning and Statutory Requirements and Approvals.
 All drainage layouts are schematic and invert levels must be established prior to construction.

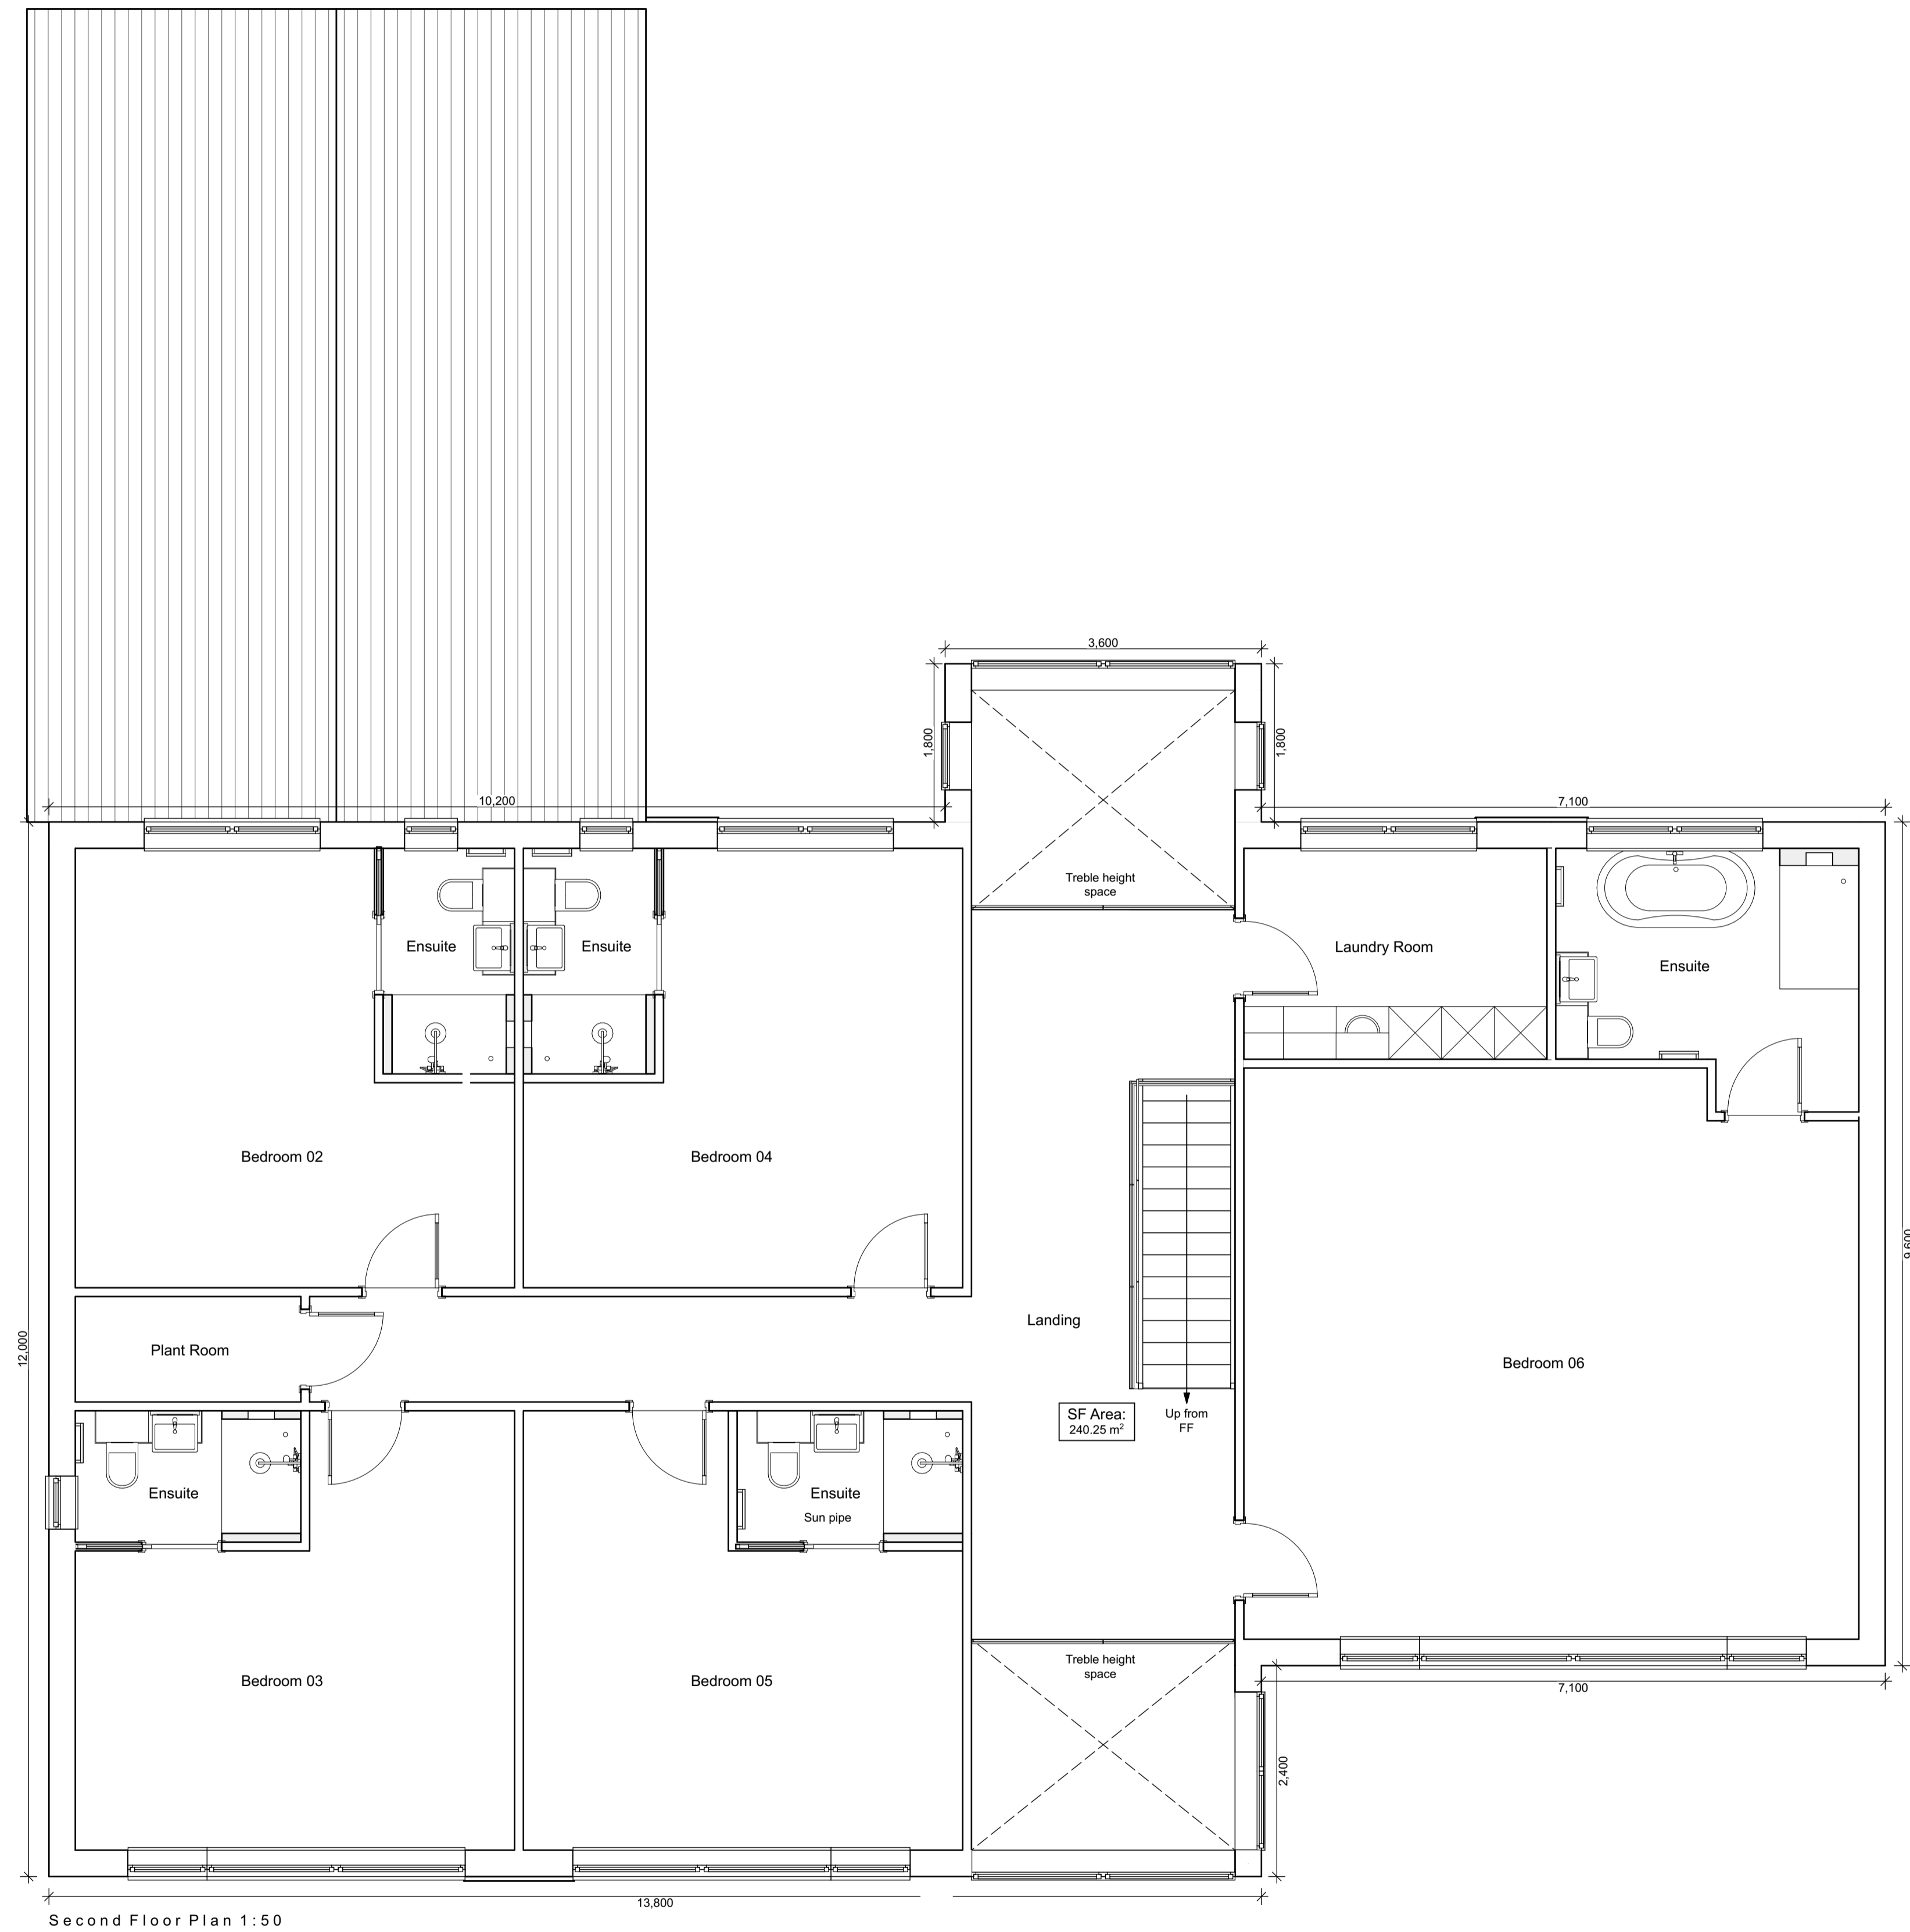

Second Floor Plan 1:50

Rev A 14.10.2019 The side window in bedroom 02 has been relocated to the front elevation as per received comments from the planner_JN

Project Status:	PLANNING ONLY
 Defining problems with beautiful solutions...	
4 Rushmead Court, Ossett, WF5 0NZ tel: 01924 275 594 web: www.transformarchitects.co.uk email: info@transformarchitects.co.uk	
Project Address:	50 Don St, Penistone, Sheffield, S36 6HA
Client:	Mr & Mrs Kirk
Drawing Title:	Proposed Second Floor Plan A1
Scale:	1:50
Date:	11.06.2019
Drawn By:	MNB
Drawing Number:	T1034 - PL06
Revision:	Rev A