



Roof Plan

P01 - FIRST ISSUE. RA 19.07.21

PLANNING APPLICATION

PROJECT REFERENCE
352 001 MSERV

DRAWING REFERENCE
project code - originator - volume - level - type - role - number
352001-SoS-00-00-DR-A-1004


DRAWING NUMBER
1004

REVISION P01 SUITABILITY S4

PROJECT
BARNESLEY COLLEGE
TEMPORARY KITCHEN

DRAWING
ROOF PLAN AS EXISTING

SCALE 1:100 @ A1 DATE JULY 2021
DRAWN RA CHECKED

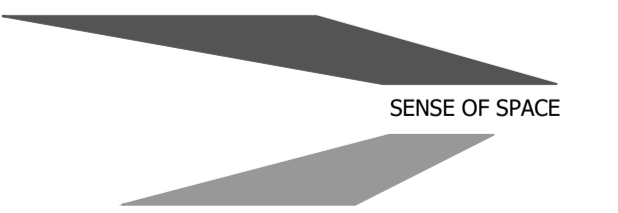

ARCHITECTS | INTERIOR DESIGNERS | BUILDING SURVEYORS

25a THE GROVE PROMENADE ILKLEY LS29 8AF TEL: +44 (0) 1943 816 489

THE STANLEY BUILDING 7 PANCRAS SQUARE LONDON N1C 4AG TEL: +44 (0) 208 090 0005