 





Reproduced by permission of Ordnance Survey on behalf of the Controller of His Majesty's Stationery Office
All rights reserved. © Crown Copyright licence no. 100022432

SITE AREA PLAN



SITE PHOTOGRAPH

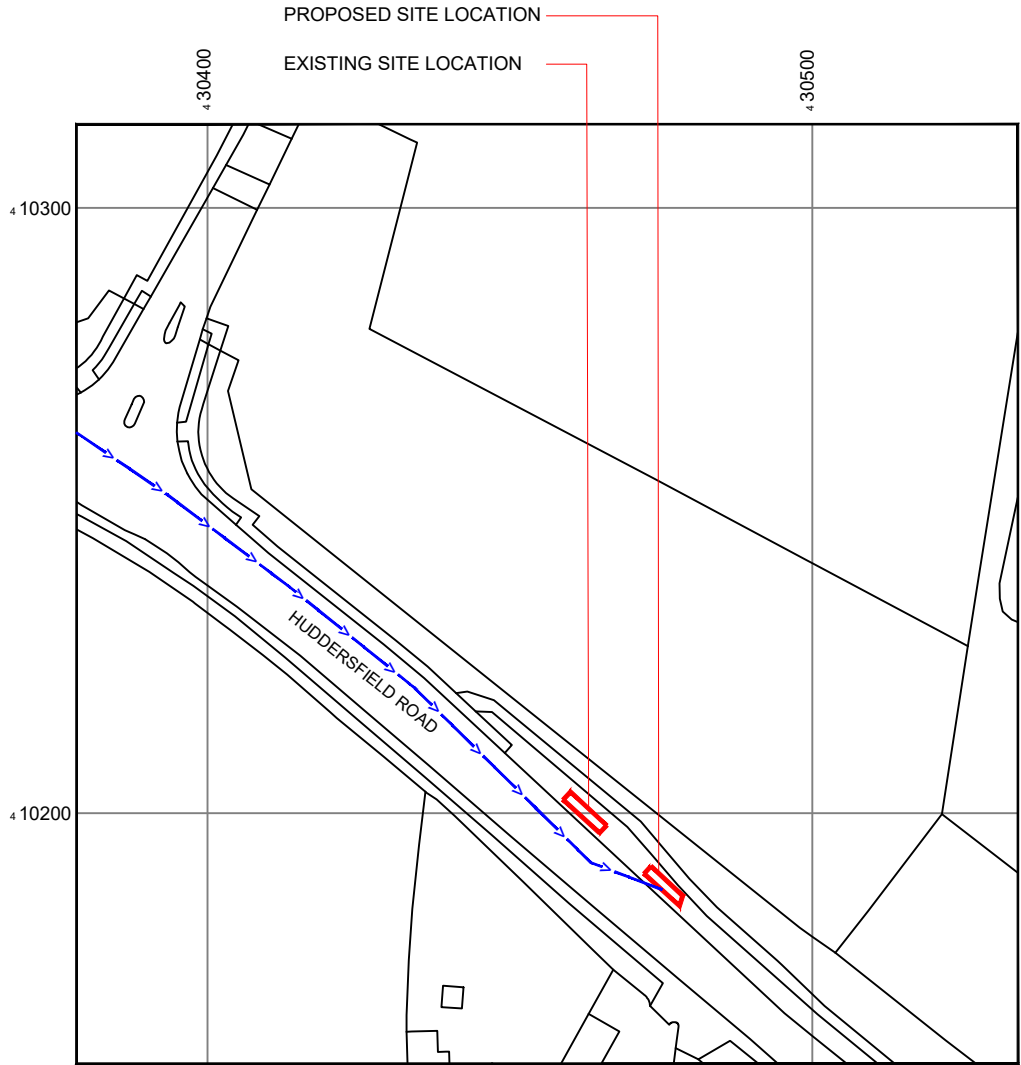


Reproduced by permission of Ordnance Survey on behalf of the Controller of His Majesty's Stationery Office
All rights reserved. © Crown Copyright licence no. 100022432

EXTG. NGR E: 430461 N: 410205

PROP. NGR E: 430473 N: 410189

 SITE LOCATION PLAN



GOOGLE MAPS QR CODE

GOOGLE MAPS - Hyperlink to map of the site

GOOGLE STREETVIEW - Hyperlink to Streetview of the site

NOTES:

1. ALL DIMENSIONS IN MM UNLESS OTHERWISE NOTED.

DIRECTIONS TO SITE:

HEADING NORTH OR SOUTH ON THE M1, EXIT AT J38 AND TAKE THE A637 EXIT TO HUDDERSFIELD. AT THE ROUNDABOUT EXIT ONTO HUDDERSFIELD ROAD / A637. CONTINUE TO FOLLOW THE A637 FOR APPROX 1.5 MILES. SITE WILL BE ON THE LEFT

Site Boundary:



Access Route To Site:



Master:	MBNL / EE / 3UK:	Project:	Purpose of Issue:	Issue:
M003	MBNL	MBNL 3UK BUY-IN	Planning	C
Date:	16.01.2023	Revision / Upgrade Description:		
Drawn:	M.Williams	Existing and proposed NGR's noted		
Checked:	A.Dobson			
Approved:	A.Dobson			
Master:	MBNL / EE / 3UK:	Project:	Purpose of Issue:	Issue:
M002	MBNL	MBNL 3UK BUY-IN	Planning	B
Date:	10.01.2023	Revision / Upgrade Description:		
Drawn:	M.Williams	Proposed line diagram amended		
Checked:	A.Dobson			
Approved:	A.Dobson			
Master:	MBNL / EE / 3UK:	Project:	Purpose of Issue:	Issue:
M001	MBNL	MBNL 3UK BUY-IN	Planning	A
Date:	06.01.2023	Revision / Upgrade Description:		
Drawn:	M.Williams	First Issue - For comments		
Checked:	A.Dobson			
Approved:	A.Dobson			



Hutchison 3G UK Limited
Green Park, 450 Longwater Avenue
Reading, RG30 3UR
Tel: 01628 765 500
Fax: 01628 765 501



Hatfield Business Park
Hatfield
Hertfordshire
AL10 9BW
Tel: 01707 315000
Fax: 01707 319001



Mobile Broadband Network Limited
Sixth Floor, Thames Tower, Station Road, Reading, RG1 1LX

Design Consultant & Principal Contractor:



Unit E, Madison Place, Northampton Road,
Manchester, M40 5AG
Tel: 0161 785 4500 Fax: 0161 785 4501
Web: www.clarke-telecom.com

Site Name:

VERGE ADJ. TO BUS PARK

Site ID:

1190591

Address:

HUDDERSFIELD ROAD
DARTON
BARNSELY
SOUTH YORKSHIRE
S75 5JS

Title:

002 SITE LOCATION PLAN


Project:

MBNL - 3UK BUY-IN

Purpose of Issue:

PLANNING

EE Cell ID:	MBNL Cell ID:	3UK Cell ID:
57221	BAR104	S0870
Master Drawing No:		
1190591_BAR104_57221_S0870_M003		
Issue:		
C		

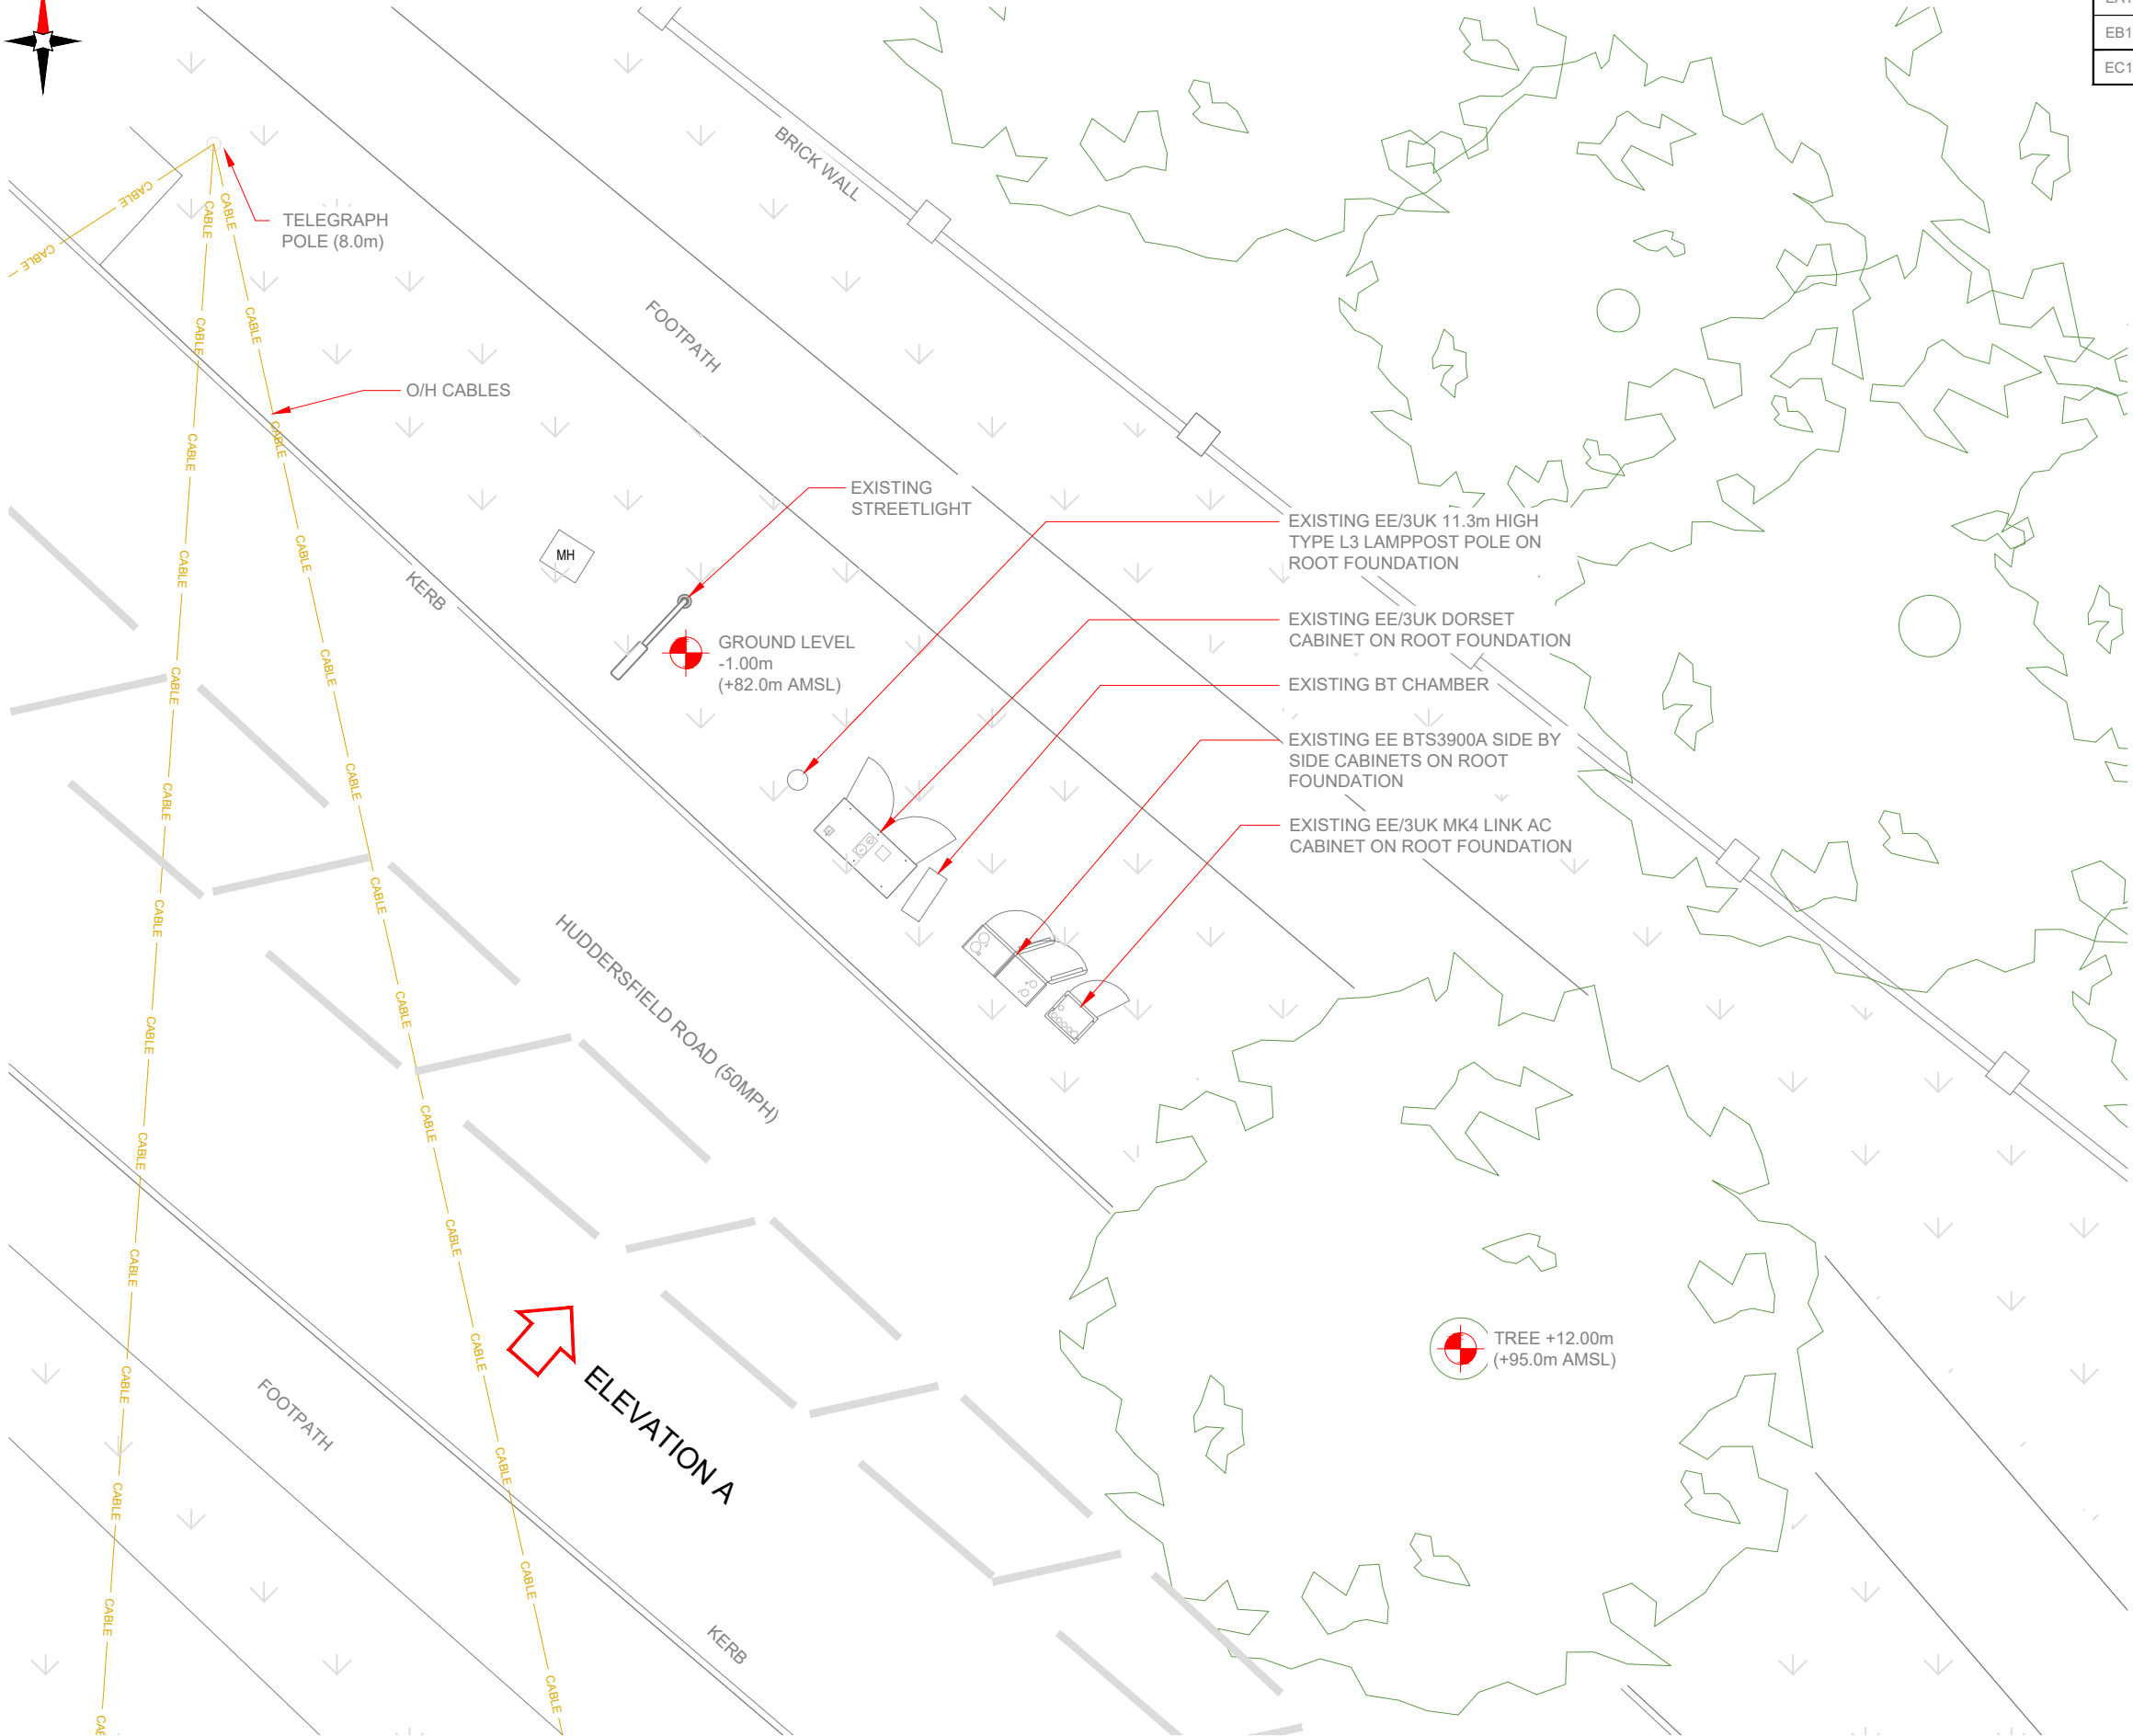

100mm
50mm
10mm



3G / 4G Antenna ID	Existing 3G Bearing
EA1	0°
EB1	120°
EC1	240°

NOTES:

1. ALL DIMENSIONS IN MM UNLESS OTHERWISE NOTED.

Master:	MBNL / EE / 3UK:	Project:	MBNL 3UK BUY-IN	Purpose of Issue:	Planning	Issue:	C
Date:	16.01.2023	Revision / Upgrade Description:					
Drawn:	M.Williams	Existing and proposed NGR's noted					
Checked:	A.Dobson						
Approved:	A.Dobson						

Master:	MBNL / EE / 3UK:	Project:	MBNL 3UK BUY-IN	Purpose of Issue:	Planning	Issue:	B
Date:	10.01.2023	Revision / Upgrade Description:					
Drawn:	M.Williams	Proposed line diagram amended					
Checked:	A.Dobson						
Approved:	A.Dobson						

Master:	MBNL / EE / 3UK:	Project:	MBNL 3UK BUY-IN	Purpose of Issue:	Planning	Issue:	A
Date:	06.01.2023	Revision / Upgrade Description:					
Drawn:	M.Williams	First Issue - For comments					
Checked:	A.Dobson						
Approved:	A.Dobson						

Hutchison 3G UK Limited
Green Park, 450 Longwater Avenue
Reading, RG30 3UR
Tel: 01628 765 500
Fax: 01628 765 501

3UK Base Station Information line:
0845 6043000
Available 8am-8pm Monday to Friday

Hatfield Business Park
Hatfield
Hertfordshire
AL10 9BW

Tel: 01707 315000
Fax: 01707 319001

Design Consultant & Principal Contractor:

Unit E, Madison Place, Northampton Road,
Manchester, M40 5AG
Tel: 0161 785 4500 Fax: 0161 785 4501
Web: www.clarke-telecom.com

Site Name:

VERGE ADJ. TO BUS PARK

Site ID:

1190591

Address:

HUDDERSFIELD ROAD
DARTON
BARNSELY
SOUTH YORKSHIRE
S75 5JS

Title:

100 EXISTING SITE PLAN

Project:


MBNL - 3UK BUY-IN

Purpose of Issue:

PLANNING

EE Cell ID:	MBNL Cell ID:	3UK Cell ID:
57221	BAR104	S0870

Master Drawing No:	Issue:
1190591_BAR104_57221_S0870_M003	C

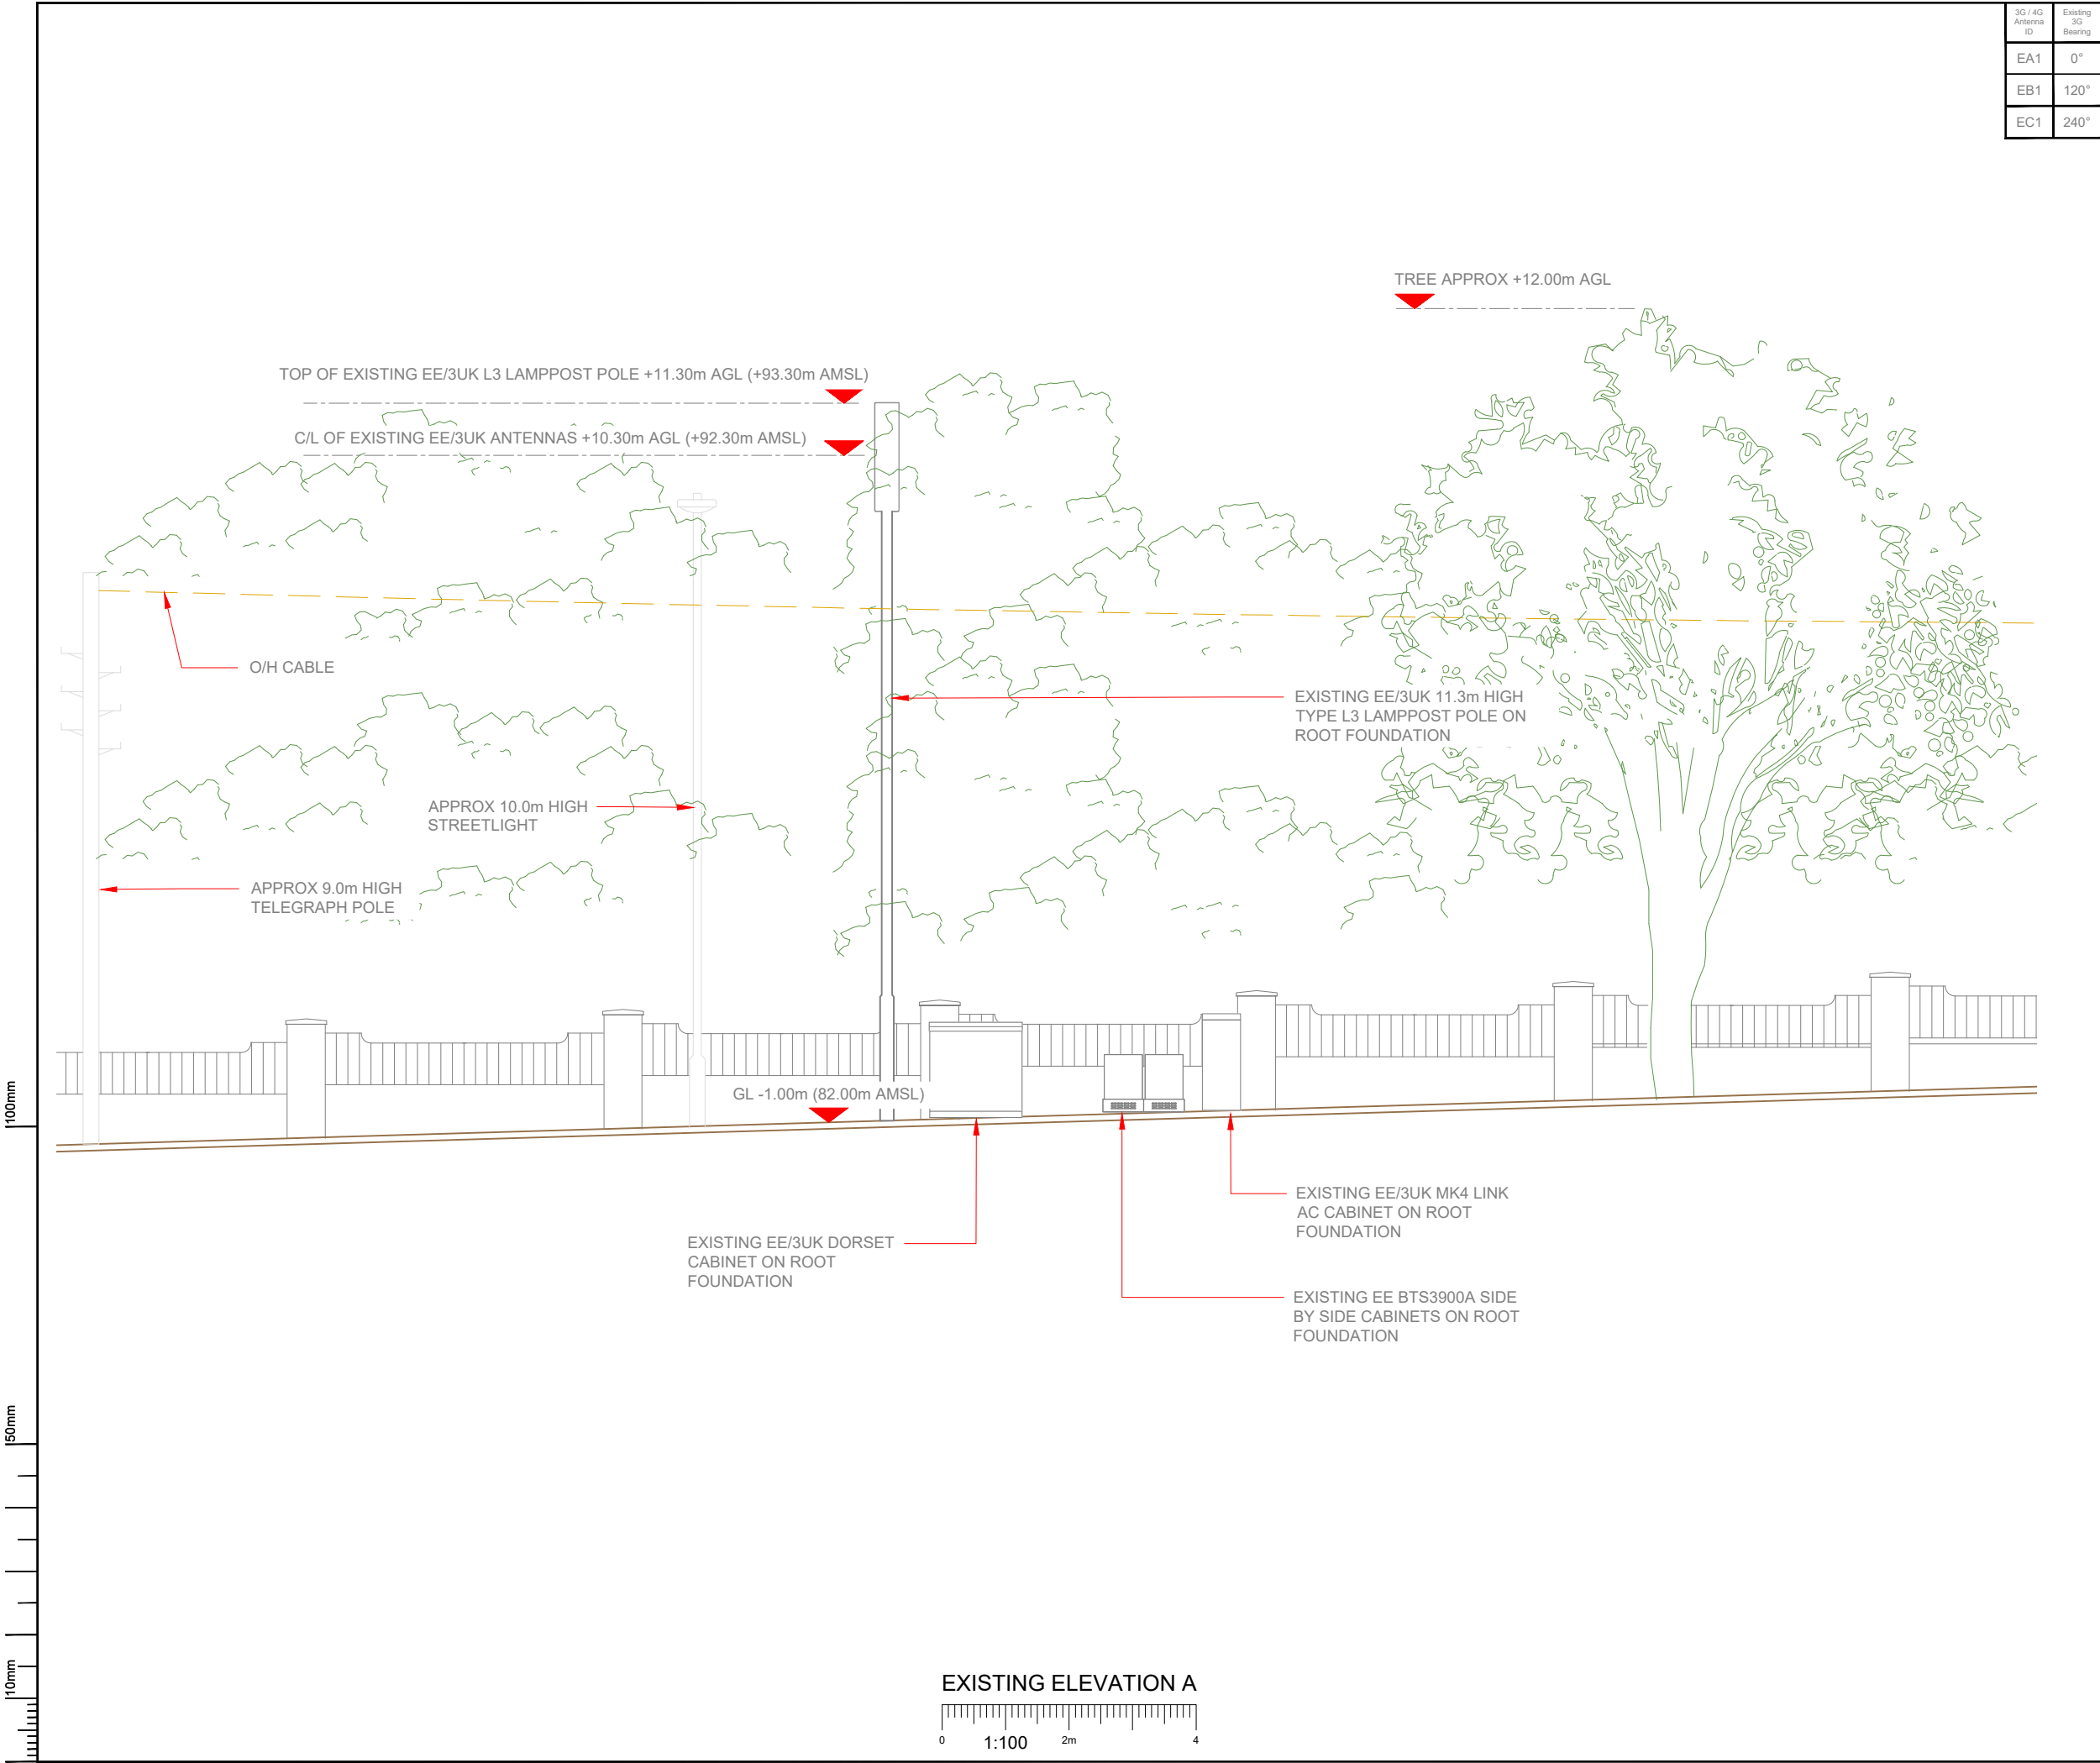


3G / 4G Antenna ID	Existing 3G Bearing
EA1	0°
EB1	120°
EC1	240°

NOTES:


1. ALL DIMENSIONS IN MM UNLESS OTHERWISE NOTED.

Master:	MBNL / EE / 3UK:	Project:	Purpose of Issue:	Issue:
M003	MBNL	MBNL 3UK BUY-IN	Planning	C
Date:	16.01.2023	Revision / Upgrade Description:		
Drawn:	M.Williams	Existing and proposed NGR's noted		
Checked:	A.Dobson			
Approved:	A.Dobson			
Master:	MBNL / EE / 3UK:	Project:	Purpose of Issue:	Issue:
M002	MBNL	MBNL 3UK BUY-IN	Planning	B
Date:	10.01.2023	Revision / Upgrade Description:		
Drawn:	M.Williams	Proposed line diagram amended		
Checked:	A.Dobson			
Approved:	A.Dobson			
Master:	MBNL / EE / 3UK:	Project:	Purpose of Issue:	Issue:
M001	MBNL	MBNL 3UK BUY-IN	Planning	A
Date:	06.01.2023	Revision / Upgrade Description:		
Drawn:	M.Williams	First Issue - For comments		
Checked:	A.Dobson			
Approved:	A.Dobson			




Hutchison 3G UK Limited
Green Park, 450 Longwater Avenue
Reading, RG30 3UR
Tel: 01628 765 000
Fax: 01628 765 001

3UK Base Station Information line:
0845 6043000
Available 8am-8pm Monday to Friday




Hatfield Business Park
Hatfield
Hertfordshire
AL10 9BW

Tel: 01707 315000
Fax: 01707 319001



Mobile Broadband Network Limited
Sixth Floor, Thames Tower, Station Road, Reading, RG1 1LX

Design Consultant & Principal Contractor:



Unit E, Madison Place, Northampton Road,
Manchester, M40 5AG
Tel: 0161 785 4500 Fax: 0161 785 4501
Web: www.clarke-telecom.com

Site Name:

VERGE ADJ. TO BUS PARK

Site ID:

1190591

Address:

HUDDERSFIELD ROAD
DARTON
BARNESLEY
SOUTH YORKSHIRE
S75 5JS

Title:

150 EXISTING ELEVATION A

Project:

MBNL - 3UK BUY-IN

Purpose of Issue:

PLANNING


EE Cell ID:	MBNL Cell ID:	3UK Cell ID:
57221	BAR104	S0870

Master Drawing No:

1190591_BAR104_57221_S0870_M003

Issue:

C

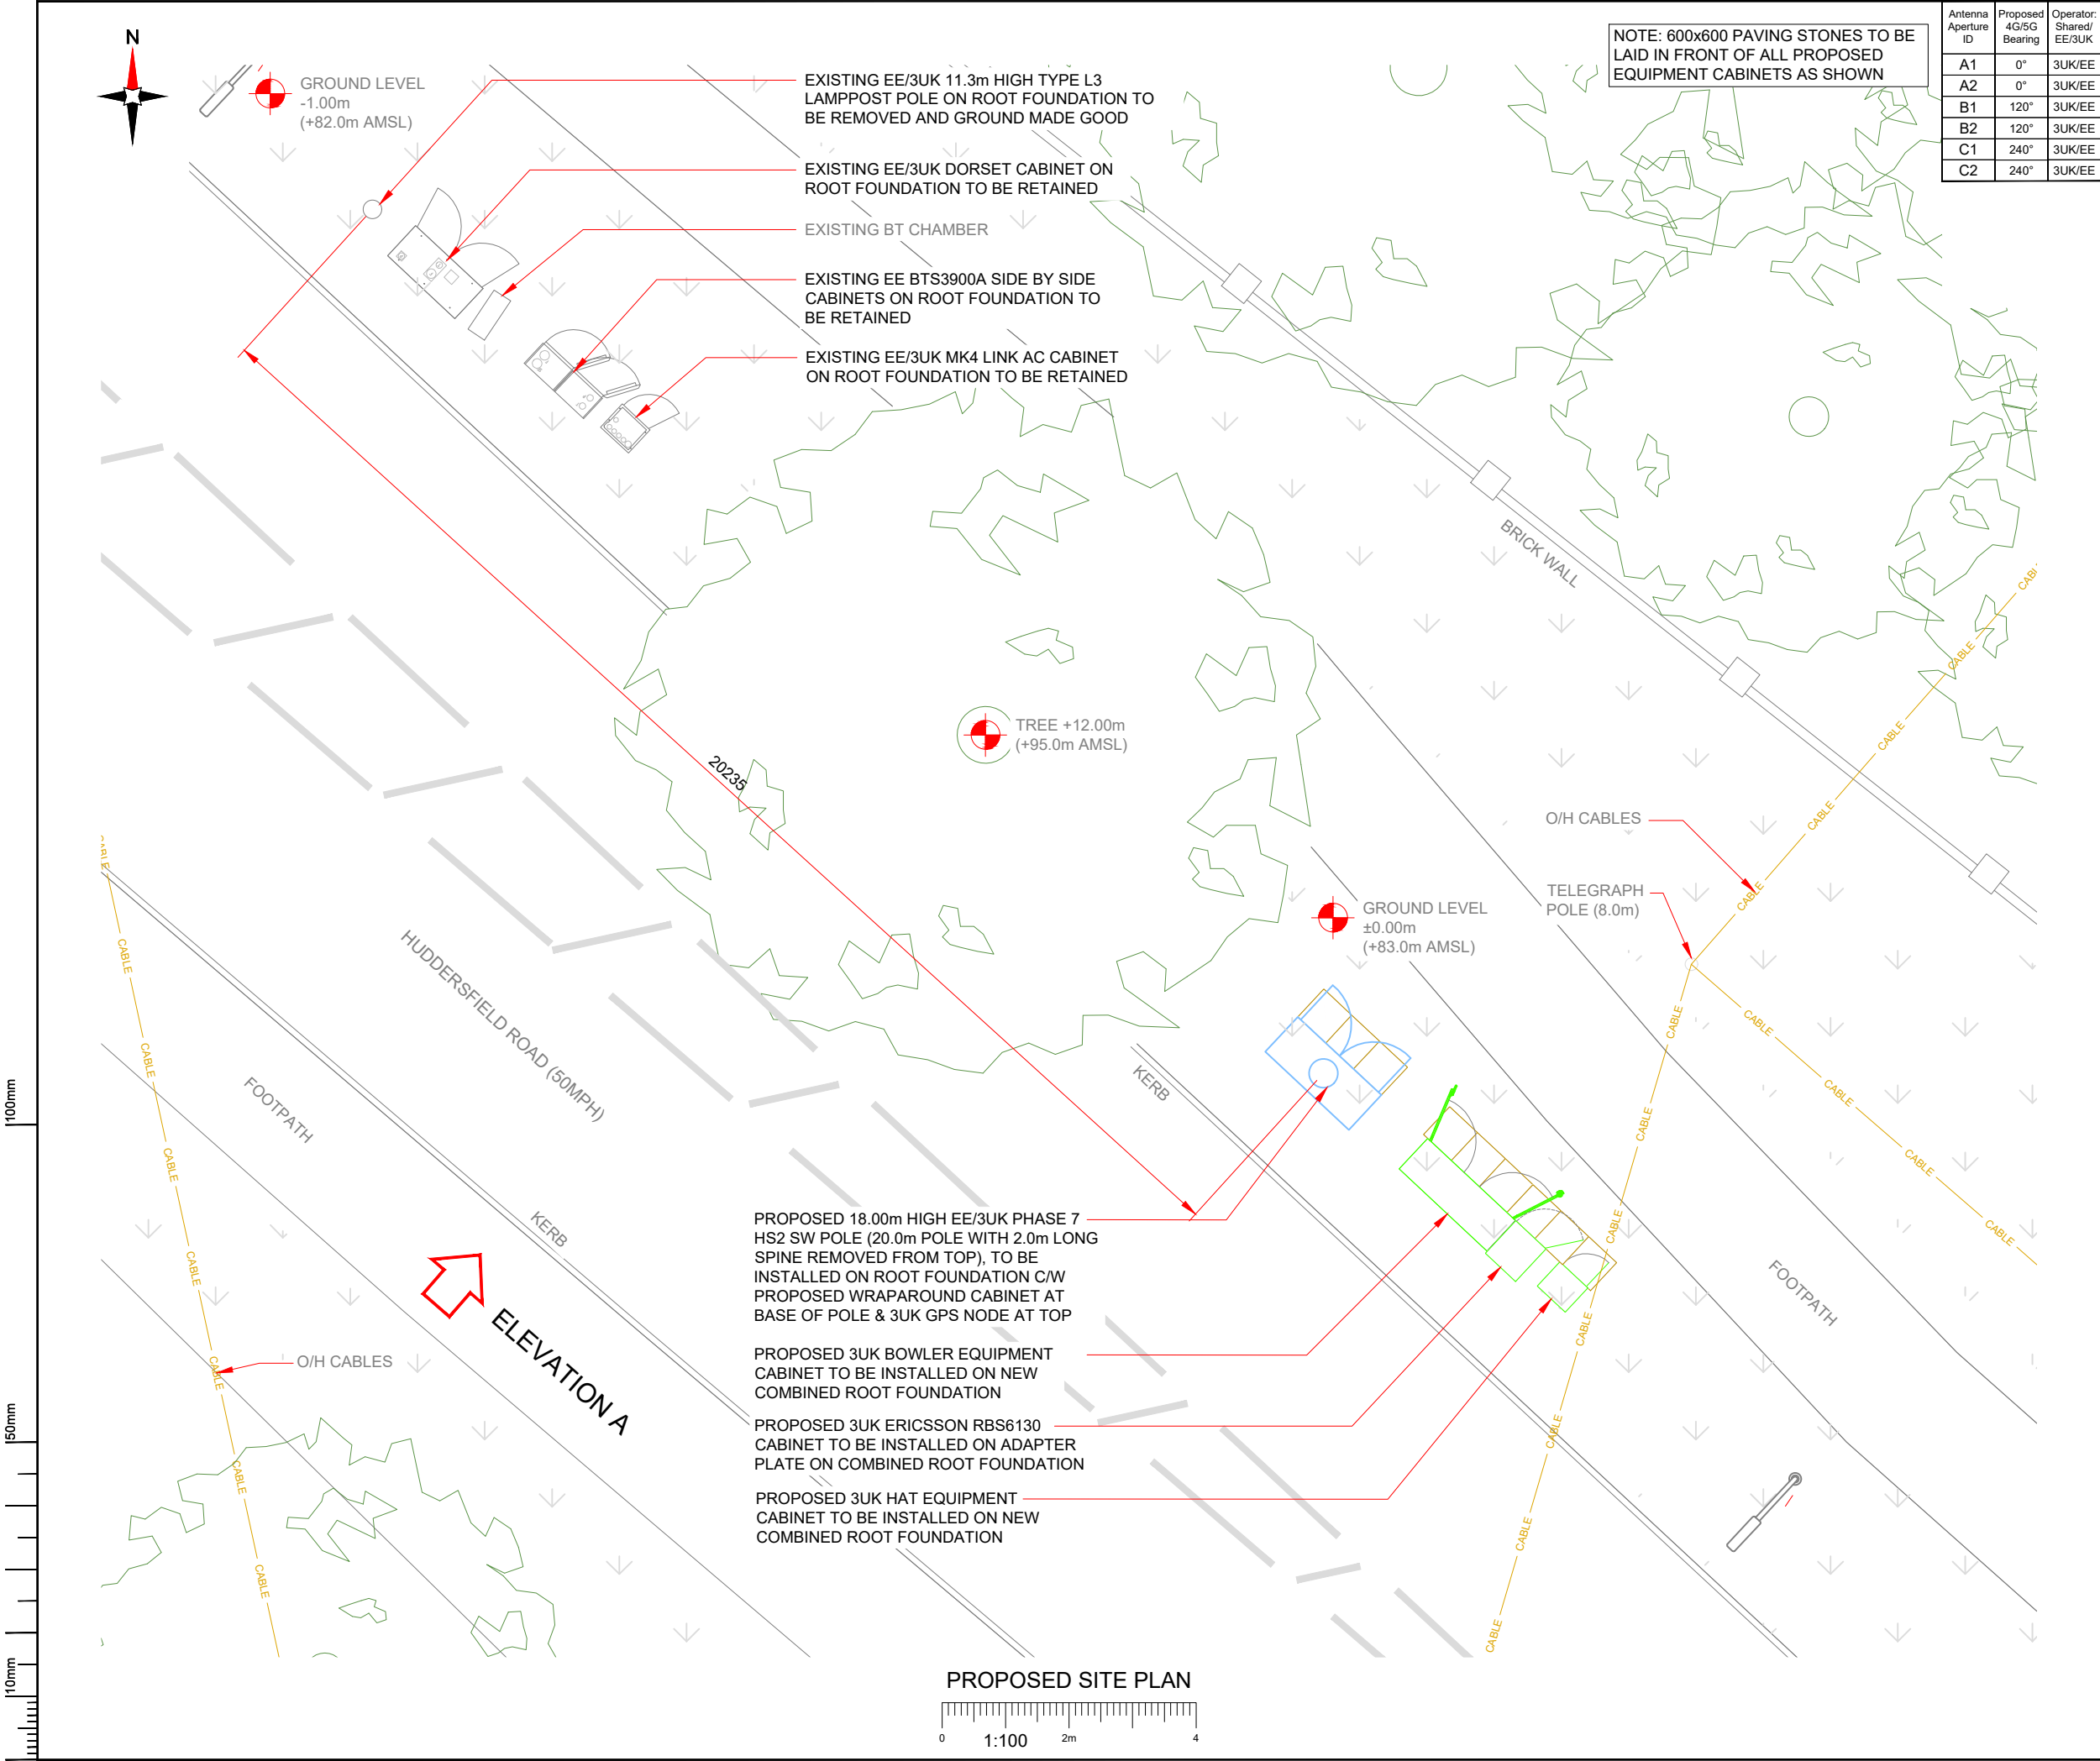

Antenna Aperture ID	Proposed 4G/5G Bearing	Operator: Shared/ EE/3UK
A1	0°	3UK/EE
A2	0°	3UK/EE
B1	120°	3UK/EE
B2	120°	3UK/EE
C1	240°	3UK/EE
C2	240°	3UK/EE

NOTES:
1. ALL DIMENSIONS IN MM UNLESS OTHERWISE NOTED.

Master:	MBNL / EE / 3UK:	Project:	MBNL 3UK BUY-IN	Purpose of Issue:	Planning	Issue:	C
Date:	16.01.2023	Revision / Upgrade Description:					
Drawn:	M.Williams	Existing and proposed NGR's noted					
Checked:	A.Dobson						
Approved:	A.Dobson						

Master:	MBNL / EE / 3UK:	Project:	MBNL 3UK BUY-IN	Purpose of Issue:	Planning	Issue:	B
Date:	10.01.2023	Revision / Upgrade Description:					
Drawn:	M.Williams	Proposed line diagram amended					
Checked:	A.Dobson						
Approved:	A.Dobson						

Master:	MBNL / EE / 3UK:	Project:	MBNL 3UK BUY-IN	Purpose of Issue:	Planning	Issue:	A
Date:	06.01.2023	Revision / Upgrade Description:					
Drawn:	M.Williams	First Issue - For comments					
Checked:	A.Dobson						
Approved:	A.Dobson						

Hutchison 3G UK Limited
Green Park, 450 Longwater Avenue
Reading, RG30 3UR
Tel: 01628 785 500
Fax: 01628 785 501

3UK Base Station Information line:
0845 6043000
Available 8am-6pm Monday to Friday

Hatfield Business Park
Hatfield
Hertfordshire
AL10 9BW

Tel: 01707 315000
Fax: 01707 319001

Mobile Broadband Network Limited
Sixth Floor, Thames Tower, Station Road, Reading, RG1 1LX

Design Consultant & Principal Contractor:

Unit E, Madison Place, Northampton Road,
Manchester, M40 5AG
Tel: 0161 785 4500 Fax: 0161 785 4501
Web: www.clarke-telecom.com

Site Name:
VERGE ADJ. TO BUS PARK

Site ID:
1190591

Address:
HUDDERSFIELD ROAD
DARTON
BARNSELY
SOUTH YORKSHIRE
S75 5JS

Title:
215 PROPOSED SITE PLAN

Project:
MBNL - 3UK BUY-IN

Purpose of Issue:
PLANNING


EE Cell ID: 57221	MBNL Cell ID: BAR104	3UK Cell ID: S0870
----------------------	-------------------------	-----------------------

Master Drawing No: 1190591_BAR104_57221_S0870_M003	Issue: C
---	-------------


Antenna Aperture ID	Proposed 4G/5G Bearing	Operator: Shared/ EE/3UK
A1	0°	3UK/EE
A2	0°	3UK/EE
B1	120°	3UK/EE
B2	120°	3UK/EE
C1	240°	3UK/EE
C2	240°	3UK/EE

NOTES:

1. ALL DIMENSIONS IN MM UNLESS OTHERWISE NOTED.

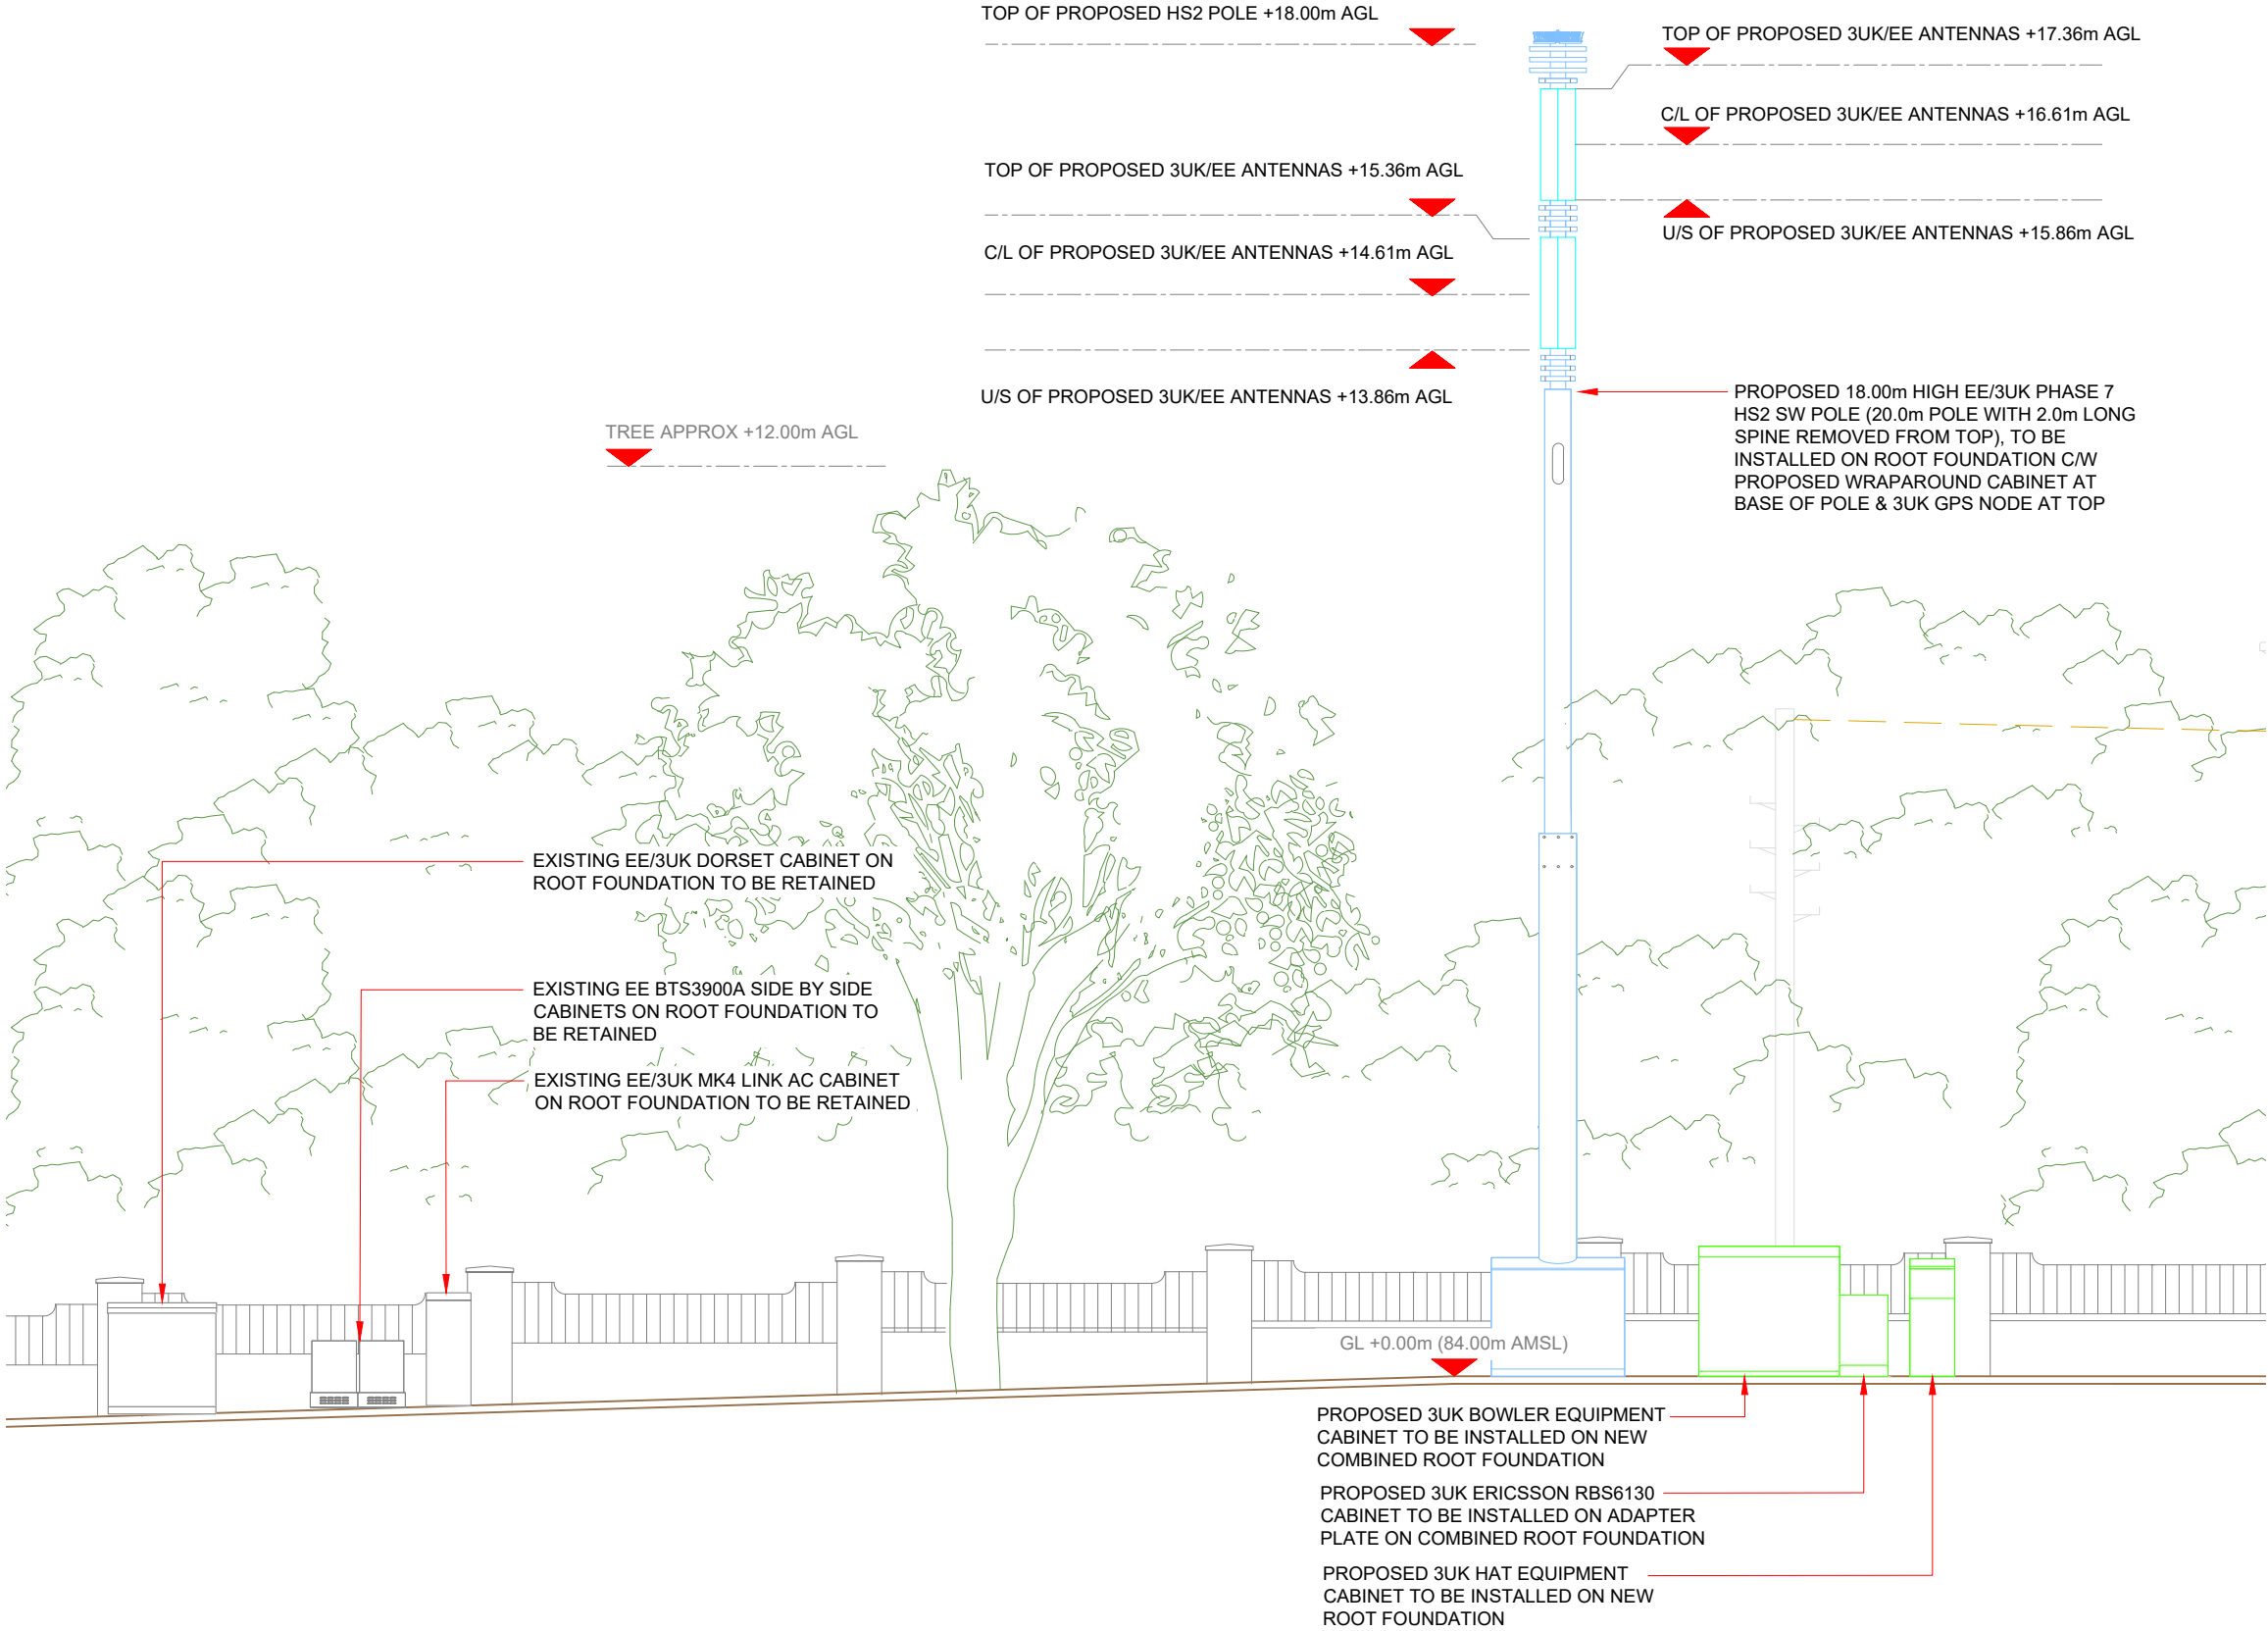

PROPOSED ELEVATION A (PLANNING)

 

Master:	MBNL / EE / 3UK:	Project:	MBNL 3UK BUY-IN	Purpose of Issue:	Planning	Issue:	C
Date:	16.01.2023	Revision / Upgrade Description:					
Drawn:	M.Williams	Existing and proposed NGR's noted					
Checked:	A.Dobson						
Approved:	A.Dobson						
Master:	MBNL / EE / 3UK:	Project:	MBNL 3UK BUY-IN	Purpose of Issue:	Planning	Issue:	B
Date:	10.01.2023	Revision / Upgrade Description:					
Drawn:	M.Williams	Proposed line diagram amended					
Checked:	A.Dobson						
Approved:	A.Dobson						
Master:	MBNL / EE / 3UK:	Project:	MBNL 3UK BUY-IN	Purpose of Issue:	Planning	Issue:	A
Date:	06.01.2023	Revision / Upgrade Description:					
Drawn:	M.Williams	First Issue - For comments					
Checked:	A.Dobson						
Approved:	A.Dobson						

Hutchison 3G UK Limited
Green Park, 450 Longwater Avenue
Reading, RG30 3UR
Tel: 01628 765 000
Fax: 01628 765 001

3UK Base Station Information line:
0845 6043000
Available 8am-8pm Monday to Friday

Hatfield Business Park
Hatfield
Hertfordshire
AL10 9BW

Tel: 01707 315000
Fax: 01707 319001

Mobile Broadband Network Limited
Sixth Floor, Thames Tower, Station Road, Reading, RG1 1LX

Design Consultant & Principal Contractor:

Unit E, Madison Place, Northampton Road,
Manchester, M40 5AG
Tel: 0161 785 4500 Fax: 0161 785 4501
Web: www.clarke-telecom.com

Site Name: VERGE ADJ. TO BUS PARK

Site ID: 1190591

Address: HUDDERSFIELD ROAD
DARTON
BARNSELY
SOUTH YORKSHIRE
S75 5JS

Title: 266 PROPOSED ELEVATION (PLANNING)

Project: MBNL - 3UK BUY-IN

Purpose of Issue: PLANNING

EE Cell ID:	MBNL Cell ID:	3UK Cell ID:
57221	BAR104	S0870

Master Drawing No:	Issue:
1190591_BAR104_57221_S0870_M003	C