 
 
 



LEGEND	
SYMBOL	DESCRIPTION
	BS 5489-1 PARKING AREAS Em: ± 20lx Uo: ± 0.40 Rgl: 50 Ra: ± 80 3000/4000k LUMINAIRES
	BS EN 12464-2 WALKWAYS EXCLUSIVELY FOR PEDESTRIANS Em: ± 5lx Uo: ± 0.25 Rgl: 50 Ra: ± 80 3000/4000k
	BS EN 12464-2 TRAFFIC AREAS FOR SLOWLY MOVING VEHICLES Em: ± 10lx Uo: ± 0.25 Rgl: 50 Ra: ± 80 3000/4000k
	BS 8300-1 STATUES Em: ± 50lx Uo: ± 0.40 Rgl: 50 Ra: ± 80 3000k
	BS 8300-1 PEDESTRIAN CROSSINGS Em: ± 30lx TO 15lx MINIMUM Uo: ± 0.40 Rgl: 50 Ra: ± 80 4000k

- NOTES
1. THIS DRAWING IS PROVIDED AS PART OF ANDERSON GREEN PERFORMANCE DOCUMENTATION AND INDICATES DESIGN INTENT. IT DOES NOT CONSTITUTE A DETAILED DESIGN AND IT WILL REMAIN THE RESPONSIBILITY OF THE CONTRACTOR TO ENSURE THE FINAL DESIGN AND INSTALLATION COMPLIES FULLY WITH THE PROJECT SPECIFICATION.
 2. THIS DRAWING SHALL BE READ IN COLOUR.
 3. THIS DRAWING SHALL BE READ IN CONJUNCTION WITH SPECIFICATION AND ALL OTHER RELEVANT DOCUMENTS.
 4. THE EXTERNAL LIGHTING SHALL BE IN ACCORDANCE WITH CIBSE LIGHTING GUIDE 6, BS 5489-1, BS 8300-1, BS EN 12464-2 AND INSTITUTION OF LIGHTING.
 5. GENERALLY THE EXTERNAL LIGHTING SHALL BE WIRED IN XLPE/SW/LSZH ARMORED CABLES, BASEC APPROVED WITH THE CE MARK. ALLOW FOR THE STEEL WIRE ARMOURING TO BE FULLY BONDED BACK TO THE MAIN EARTH PROVISION OF THE INSTALLATION USING PURPOSE MADE TERMINATIONS, EARTH TAG WITH BRASS NUTS AND BOLTS AND SUPPLEMENTARY BONDING LEADS BETWEEN EARTH TAG AND THE EXTERNAL LIGHTING DISTRIBUTION BOARD EARTH BAR. CW GLANDS SHALL BE USED FOR ALL EXTERNAL CONNECTIONS.
 6. LIGHTING LAYOUT IS INDICATIVE ONLY AND SUBJECT TO FULLY DETAILED DESIGN & COORDINATION.

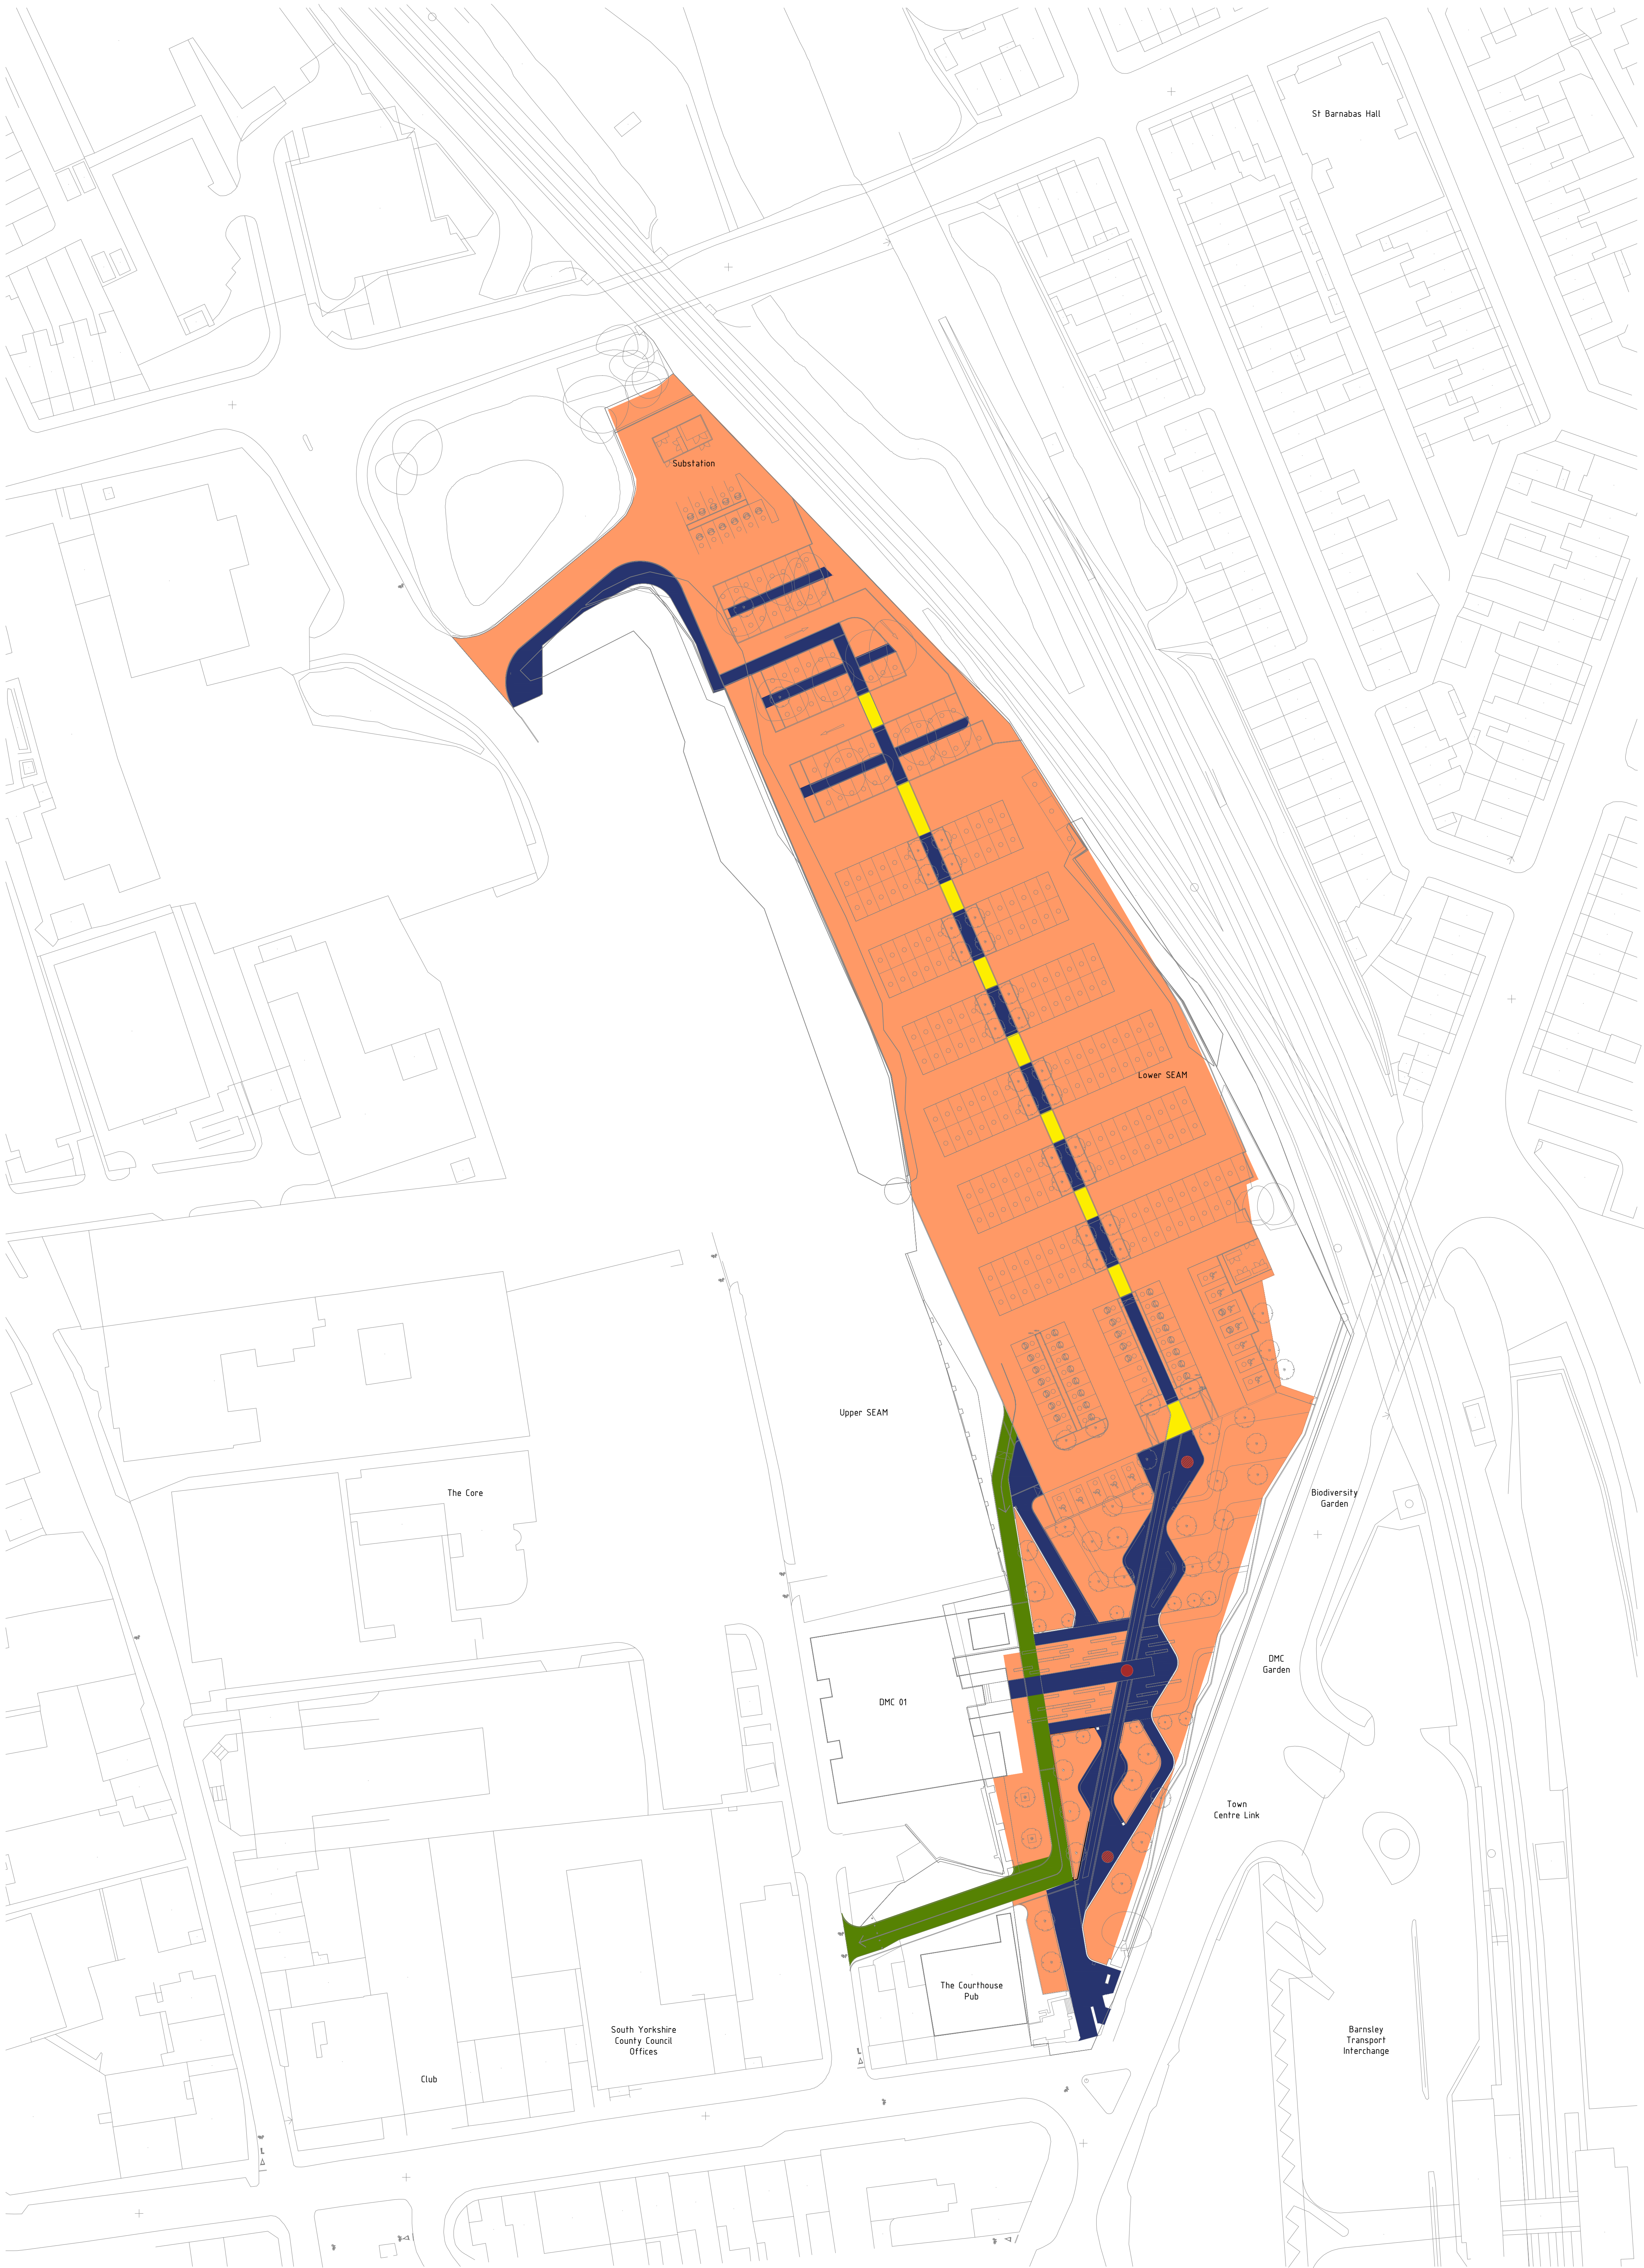

THIS DRAWING IS BASED ON:
SEAM-DRG-22-XX-DR-L-0001 - Landscape Site Plan - Rev P18

 Building services consultants Killinghall 0115 757 4141 Sheffield 0114 240 2913 London 0207 807 4941 Leeds 0113 240 2472 www.andersongreen.co.uk		 SINCE 1892				Project THE SEAM		Title LIGHTING LUX LEVELS		Rev M.Dove G.Menzies UNCLASSIFIED		Rev M.Schofield V.Denisovs 23.04.06 A0 1:500		Project No. - Designer - Function - Level - Form - Discipline - Drawing No. SEAM-AGL-Z2-XX-DR-E-24003		Status S2		Revision P02	
P02 STAGE 3 16.10.24		P01 STAGE 3 23.08.24		Rev Description Date		Stage STAGE 3		Scale 50 m		Author STAGE 3		Check STAGE 3		Drawn STAGE 3		Reviewed STAGE 3		Approved STAGE 3	