


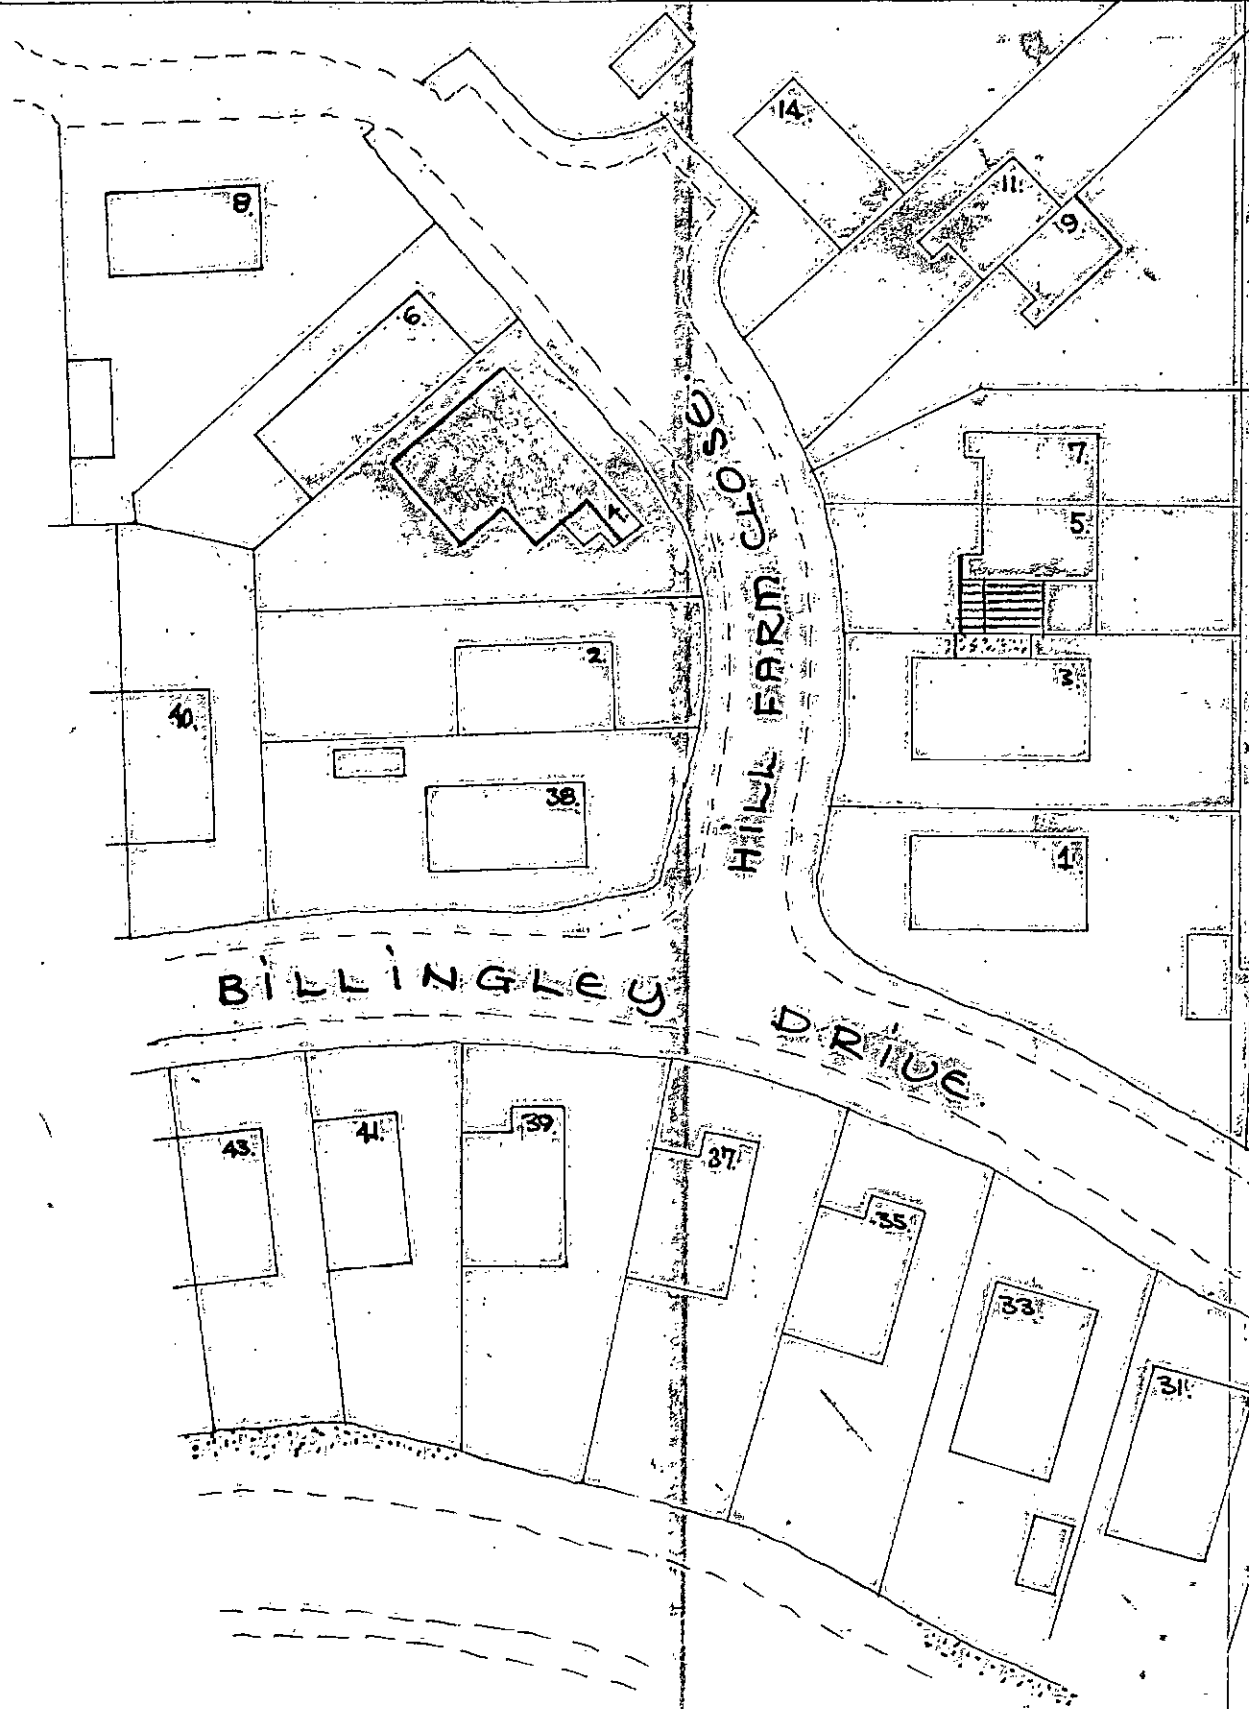
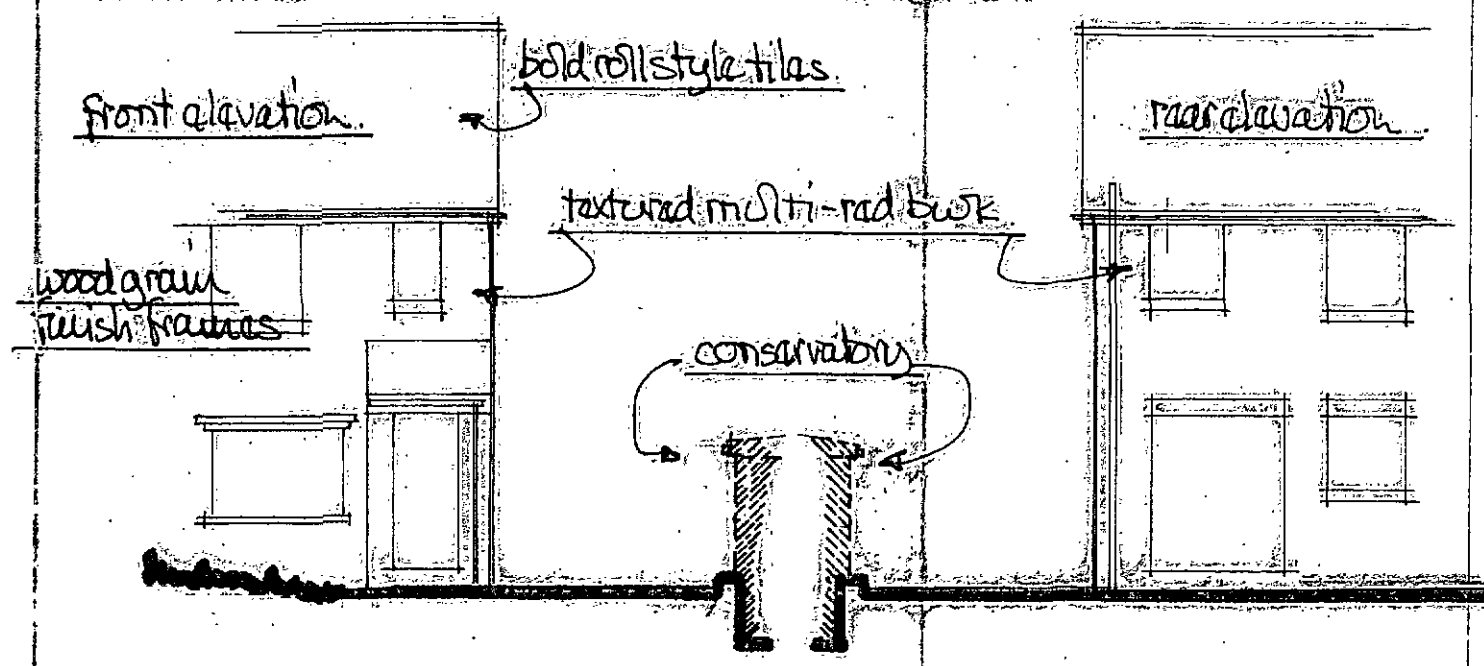


SITE PLAN: SCALE 1:500 M.

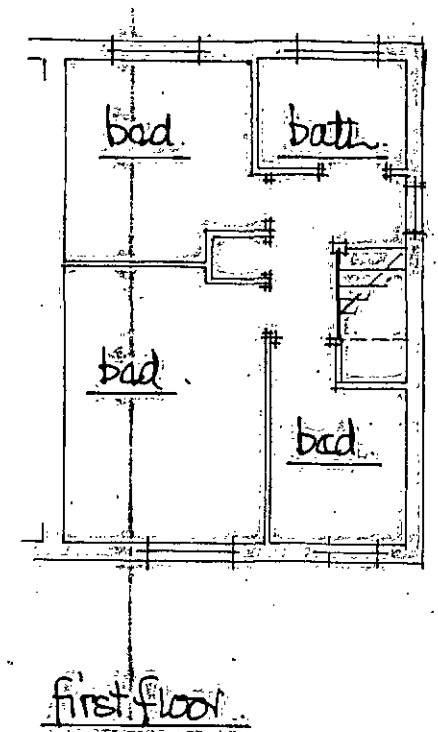


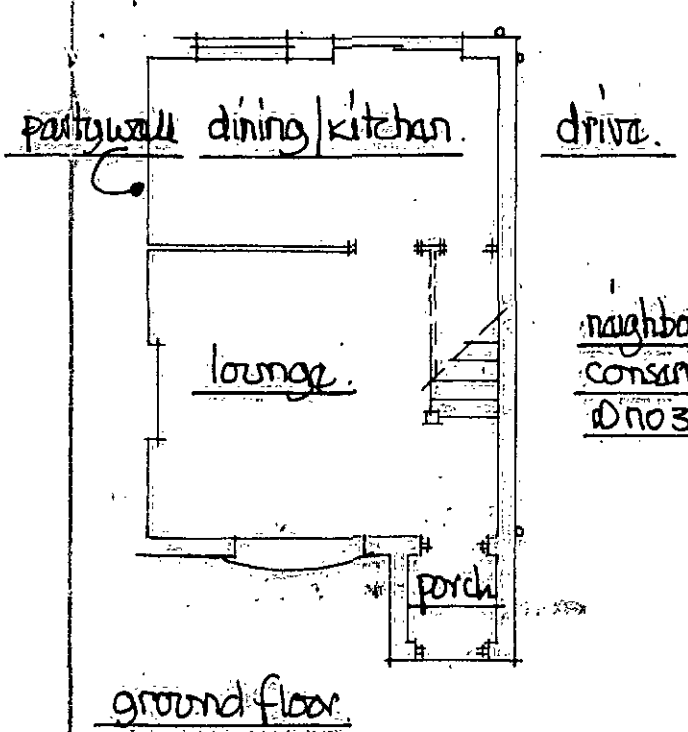


gable view from no 3.

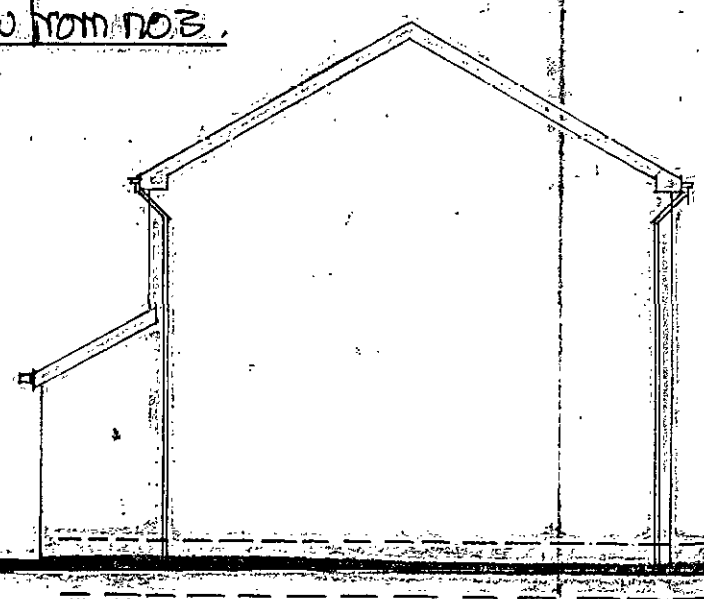

existing details  
scale 1:100m.

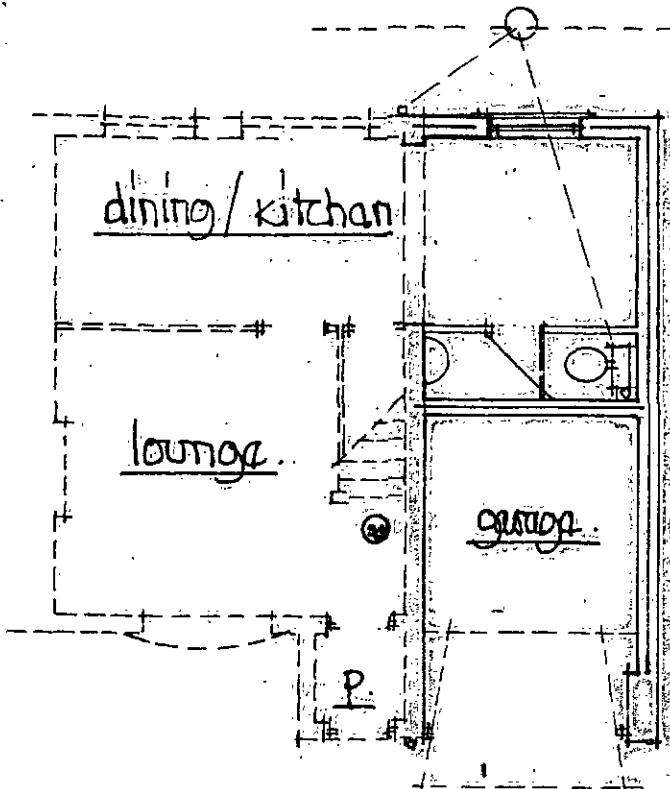

proposed ground floor layout


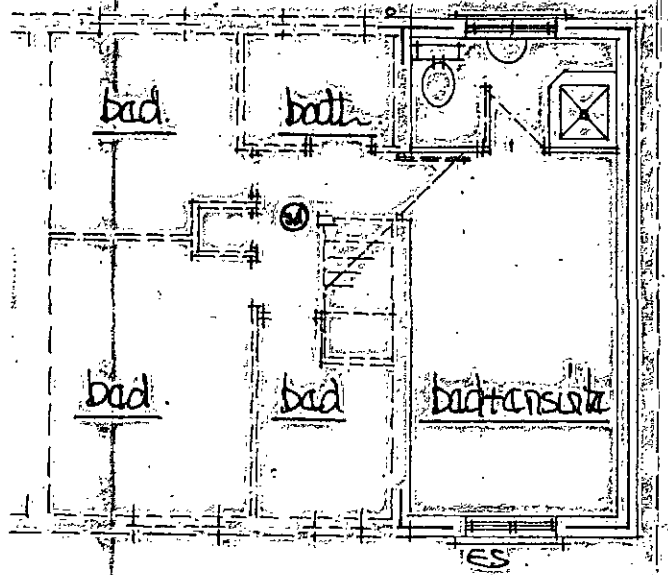


proposed first floor layout

scale 1:100m

proposed front view


proposed rear view

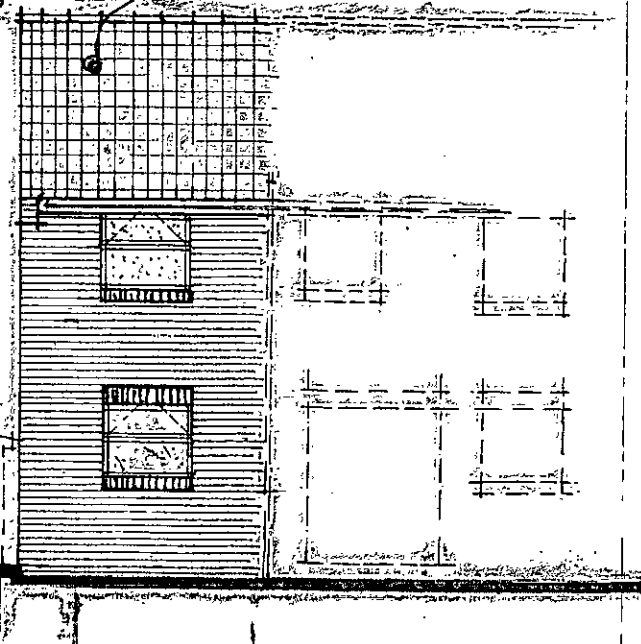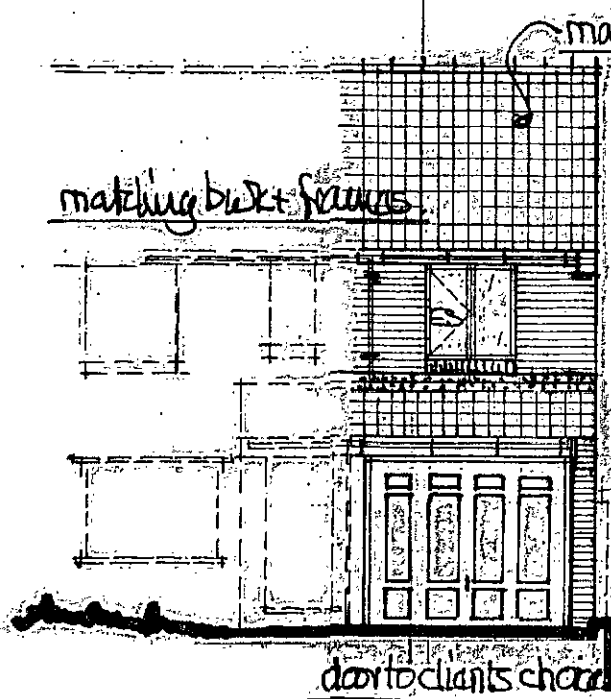


ⓐ shows ceiling mounted smoke detectors wired back to fuse box + interlinked + battery back up - fixed 300mm min from wall junctions + light fittings

ES shows fire safety escape sash 750mm high x 450mm wide to open thro 90° bottom of sash between 800/1000 above floor level

section 1:50m.

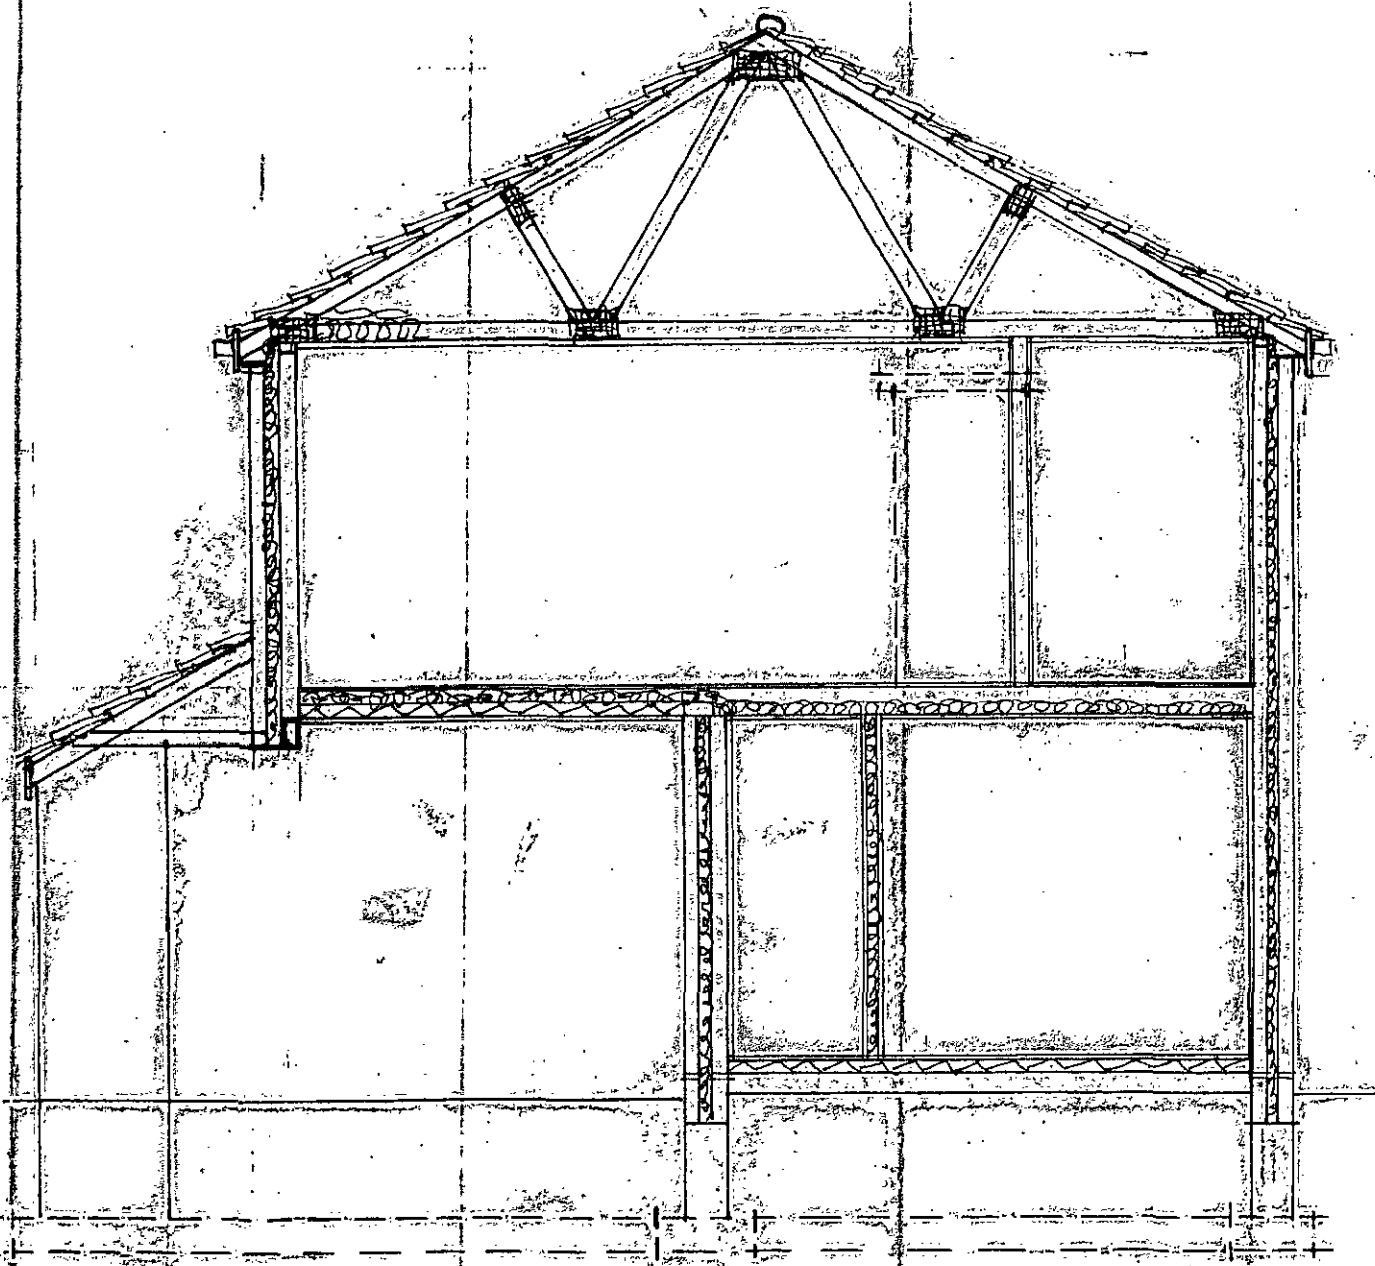

proposed view from no 3

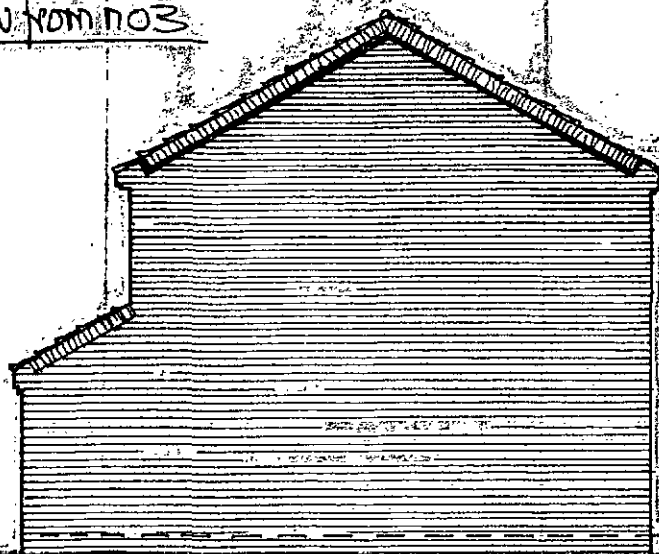

scale 1:100m.