


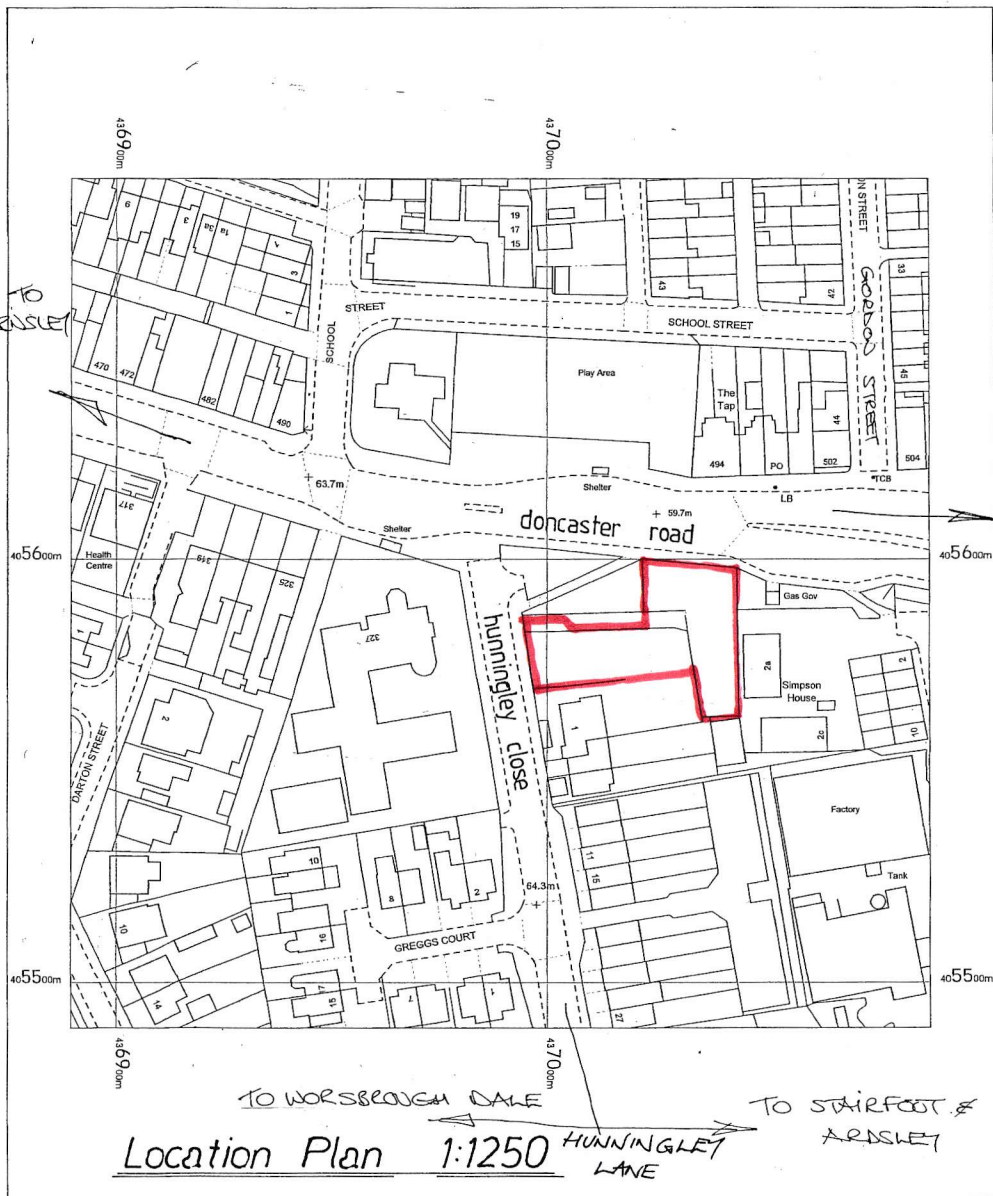

347 Doncaster Road,
And Land
Stairfoot,
Barnsley
S70 3PH

OS MasterMap 1250/2500/10000 scale
Thursday, March 20, 2025, ID: BW1-01213336
www.blackwellmapping.co.uk


1:1250 scale print at A4, Centre: 436989 E, 405589 N

© Crown Copyright Ordnance Survey. Licence no.
100041041




BLACKWELL'S
www.blackwellmapping.co.uk

TEL: 0114 268 7658
maps.sheffield@blackwell.co.uk


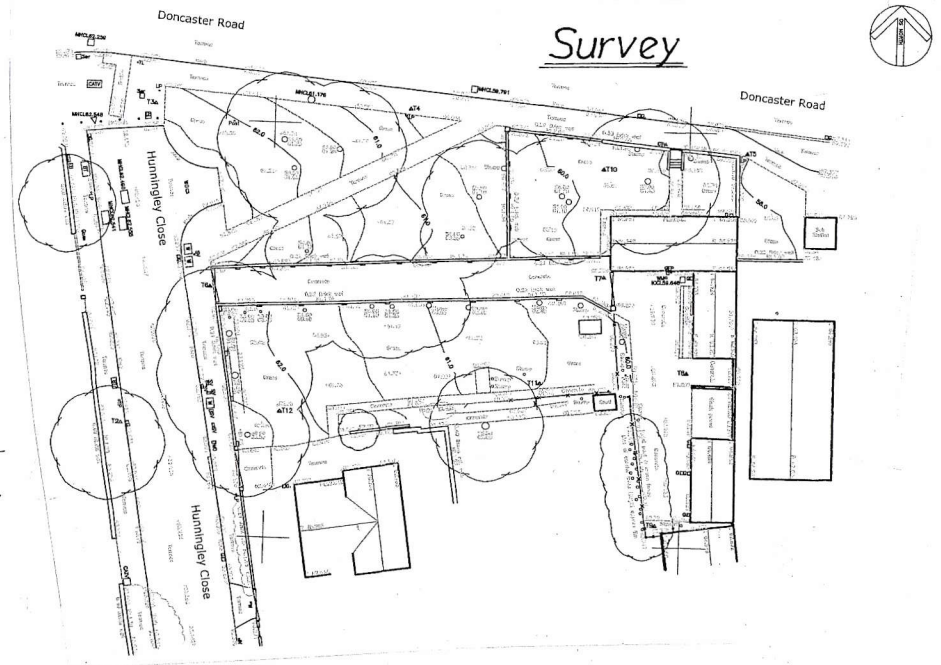


Scale 1:500

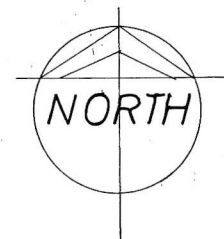

Garry Greatham Associates Residential Design Consultant Westwood House 18 Carr Lane Tankersley Barnsley S75 3BE Tel 07786062364	
Project Residential Development	
Client Mr. Dove Gill	
Title Location & Survey Layouts	
Address off Hunningley Close, Stairfoot, Barnsley, S70 3PH	
Drawn by 999	
Scale scales @ A3 DATE Mar 25	
Drawing No 514-01	
Member of the Chartered Institute of Architectural Technologists	

Rev	Notes	Date

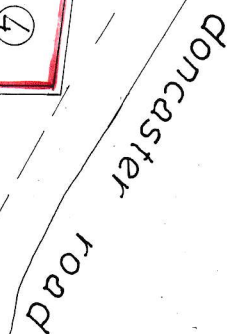 

sub station

B/Regs:

Rev	Notes	Date
-----	-------	------

Garry
Greetham
Associates
Residential
Design Consultant
Westwood House
18 Carr Lane
Tankersley
Barnsley S75 3BE
Tel 07786062364

PROJECT Residential Development

CLIENT
Mr. Dave Gill

TITLE
Site Layout

ADDRESS
off Hunningley Close,
Clifford


Barnsley. S70 3PH

DRAWN BY 999

SCALE 1:200 @ A3 DATE Mar 25

DRAWING NO 514-02

Member of the Chartered Institute
of Architectural Technologists

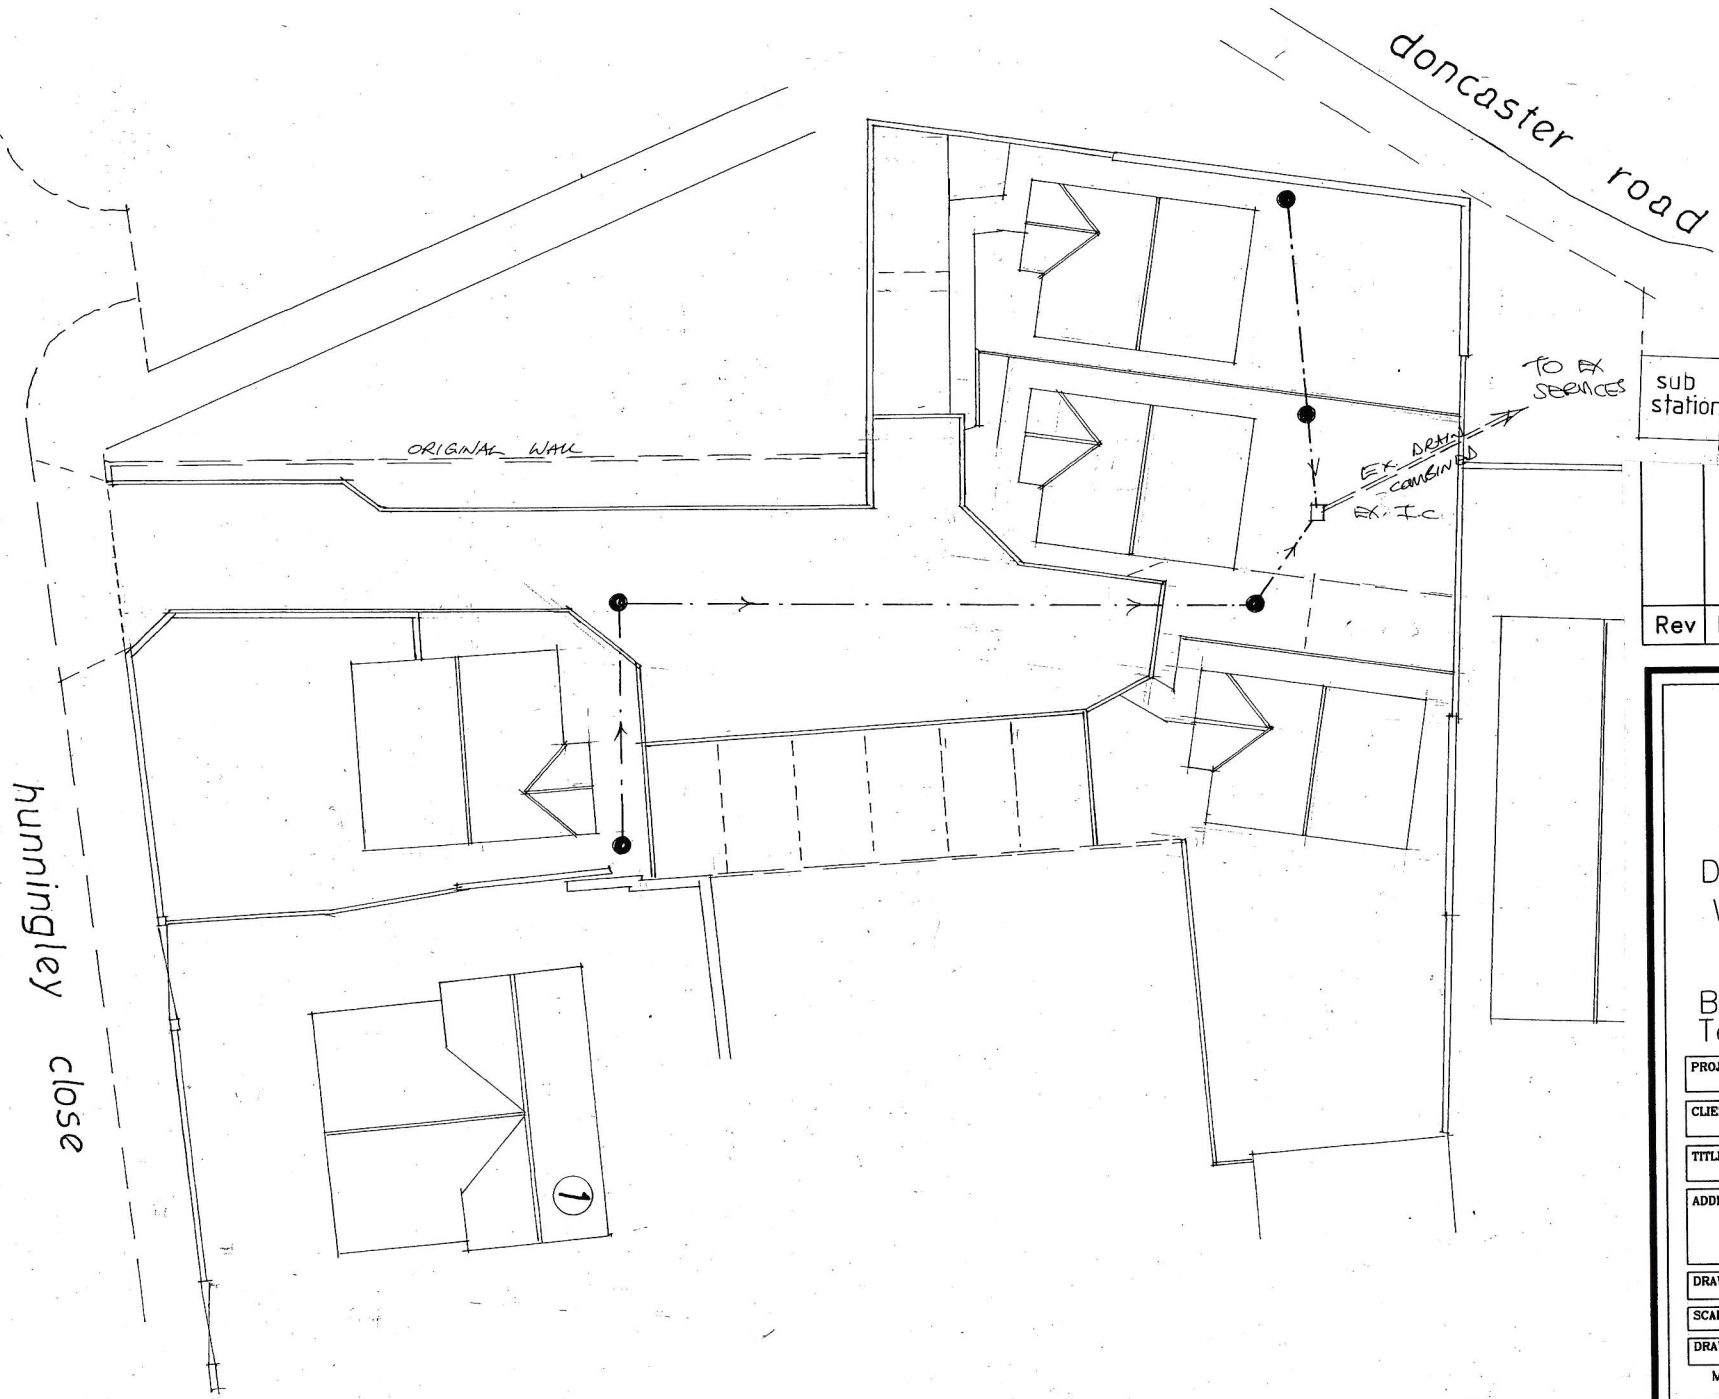

Rev	Notes	Date

Garry Greetham Associates
 Residential Design Consultant
 Westwood House
 18 Carr Lane
 Tankersley
 Barnsley S75 3BE
 Tel 07786062364

PROJECT	Residential Development	
CLIENT	Mr. Dave Gill	
TITLE	Drainage Layout	
ADDRESS	off Hunningley Close, Stairfoot, Barnsley. S70 3PH	
DRAWN BY	ggg	
SCALE	1:200 @ A3	DATE Mar 25
DRAWING No	514-03	REV
Member of the Chartered Institute of Architectural Technologists		