

EXTRACT GRILLE SCHEDULE

REF	TYPE	SIZE mm
EG1	SIG-GRL Egg-Crate	595-595
EG2	SIG-GRL Egg-Crate	595-595
EG3	SIG-GRL Egg-Crate	595-595
EG4	SIG-GRL Egg-Crate	595-595
EG5	SIG-GRL Egg-Crate	595-595
EG6	SIG-GRL Egg-Crate	595-595
EG7	SIG-GRL Egg-Crate	595-595
EG8	SIG-GRL Egg-Crate	595-595
EG9	SIG-GRL Egg-Crate	595-595
EG10	SIG-GRL Egg-Crate	595-595
EG11	SIG-GRL Egg-Crate	595-595
EG12	SIG-GRL Egg-Crate	595-595
EG13	SIG-GRL Egg-Crate	595-595
EG14	SIG-GRL Egg-Crate	595-595
EG15	SIG-GRL Egg-Crate	595-595
EG16	SIG-GRL Egg-Crate	595-595
EG17	SIG-GRL Egg-Crate	595-595
EG18	SIG-GRL Egg-Crate	595-595
EG19	SIG-GRL Egg-Crate	595-595
EG20	SIG-GRL Egg-Crate	595-595
EG21	SIG-GRL Egg-Crate	595-595
EG22	SIG-GRL Egg-Crate	595-595
EG23	SIG-GRL Egg-Crate	595-595

SUPPLY GRILLE SCHEDULE

REF	TYPE	SIZE mm
SG1	SIG-GRL 4-Way Diffuser	595-595
SG2	SIG-GRL 4-Way Diffuser	595-595
SG3	SIG-GRL 4-Way Diffuser	595-595
SG4	SIG-GRL 4-Way Diffuser	595-595
SG5	SIG-GRL 4-Way Diffuser	595-595
SG6	SIG-GRL 4-Way Diffuser	595-595
SG7	SIG-GRL 4-Way Diffuser	595-595
SG8	SIG-GRL 4-Way Diffuser	595-595
SG9	SIG-GRL 4-Way Diffuser	595-595
SG10	SIG-GRL 4-Way Diffuser	595-595
SG11	SIG-GRL 4-Way Diffuser	595-595
SG12	SIG-GRL 4-Way Diffuser	595-595
SG13	SIG-GRL 4-Way Diffuser	595-595
SG14	SIG-GRL 4-Way Diffuser	595-595
SG15	SIG-GRL 4-Way Diffuser	595-595
SG16	SIG-GRL 4-Way Diffuser	595-595
SG17	SIG-GRL 4-Way Diffuser	595-595
SG18	SIG-GRL 4-Way Diffuser	595-595
SG19	SIG-GRL 4-Way Diffuser	595-595
SG20	SIG-GRL 4-Way Diffuser	595-595
SG21	SIG-GRL 4-Way Diffuser	595-595
SG22	SIG-GRL 4-Way Diffuser	595-595
SG23	SIG-GRL 4-Way Diffuser	595-595
SG24	SIG-GRL 4-Way Diffuser	595-595
SG25	SIG-GRL 4-Way Diffuser	595-595
SG26	SIG-GRL 4-Way Diffuser	595-595
SG27	SIG-GRL 4-Way Diffuser	595-595
SG28	SIG-GRL 4-Way Diffuser	595-595
SG29	SIG-GRL 4-Way Diffuser	595-595

FIRE DAMPER SCHEDULE


REF	TYPE	SIZE
FSD1	ACTION AIR	300mm Dia
FSD2	ACTION AIR	400mm Dia
FSD3	ACTION AIR	250mm Dia
FSD4	ACTION AIR	150mm Dia
FSD5	ACTION AIR	450mm SQ
FSD6	ACTION AIR	250mm Dia
FSD7	ACTION AIR	400mm Dia
FSD8	ACTION AIR	200mm Dia
FSD9	ACTION AIR	200mm Dia
FSD10	ACTION AIR	300mm Dia
FSD11	ACTION AIR	300mm Dia
FSD12	ACTION AIR	450 x 350mm
FSD13	ACTION AIR	200mm Dia
FSD14	ACTION AIR	150mm Dia
FSD15	ACTION AIR	450 x 350mm
FSD16	ACTION AIR	300mm Dia
FSD17	ACTION AIR	300mm Dia
FSD18	ACTION AIR	200mm Dia
FSD19	ACTION AIR	250mm Dia
FSD20	ACTION AIR	400mm Dia
FSD21	ACTION AIR	400mm Dia

EXTRACT FAN SCHEDULE

REF	TYPE	SIZE	L/S
EF01	VECTAIRE EL 1003	100mm	17
EF02	VECTAIRE EL 1003	100mm	17
EF03	VECTAIRE EL 1003	100mm	17
EF04	VECTAIRE EL 1003	100mm	17
EF05	VECTAIRE EL 1003	100mm	17
EF06	VECTAIRE EL 1003	100mm	22
EF07	VECTAIRE AVX23/9AR	230mm	95
EF08	VECTAIRE AVX23/9AR	230mm	60

AC UNIT SCHEDULE

REF	TYPE	MODEL	SIZE
AC01	DAIKIN	FAA-A / RZASG-M	FAA71A 7.7kw
AC02	DAIKIN	FAA-A / RZASG-M	FAA71A 7.7kw

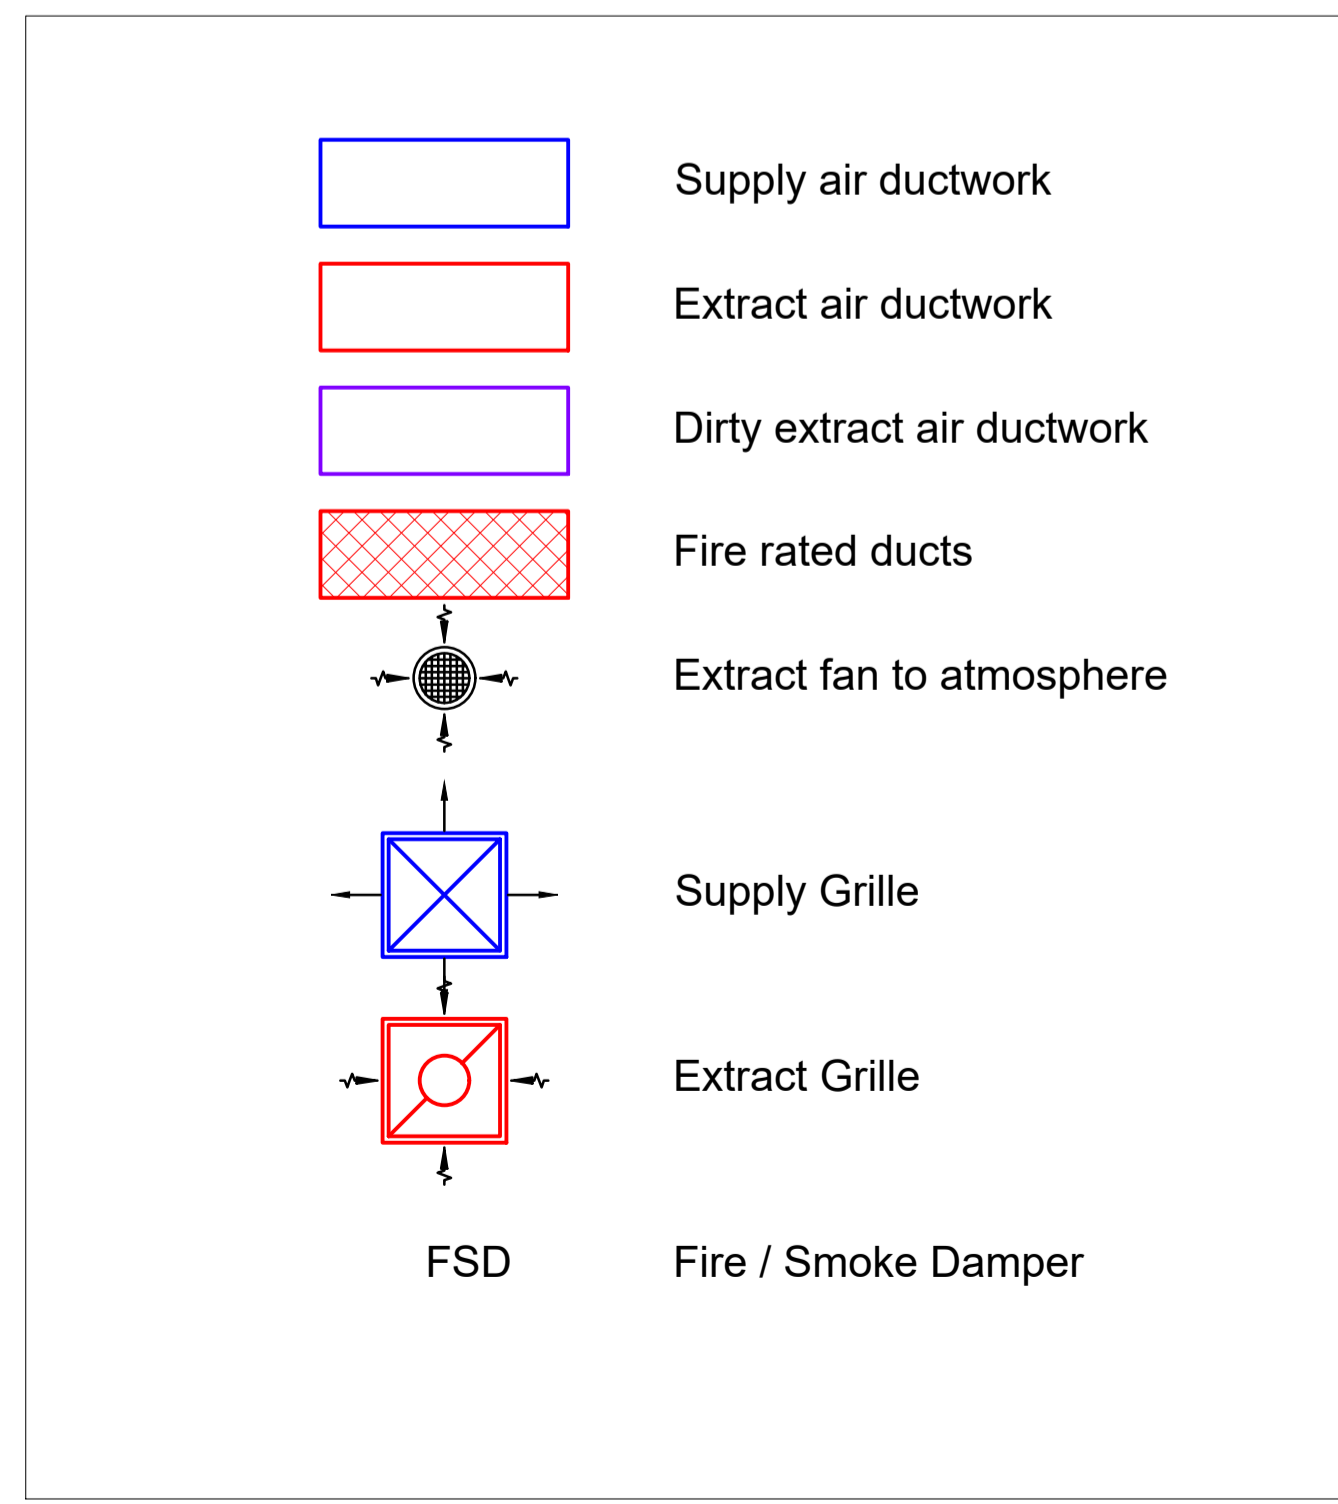

A ISSUED FOR COMMENT  
 B ISSUED FOR CONSTRUCTION  
 EG9 & SG17 REMOVED  
 GRILLE SCHEDULES AMENDED

CONSTRUCTION

ISSUE	AMENDMENT	DATE	INITIAL
A	ISSUED FOR COMMENT	26/03/2020	
B	ISSUED FOR CONSTRUCTION EG9 & SG17 REMOVED GRILLE SCHEDULES AMENDED	14/04/2020	

Project  
 BARNSELY HOSPITAL CAU

Client  
 I & G CONSTRUCTION LTD

Title  
 VENTILATION SERVICES LAYOUT

DRAWN DW	CHECKED	APPROVED	DATE 14-04-2020
SCALE 1:75	A1 DRAWING		

DRG.No. M009/BDGH/CAU  
 ISSUE B