
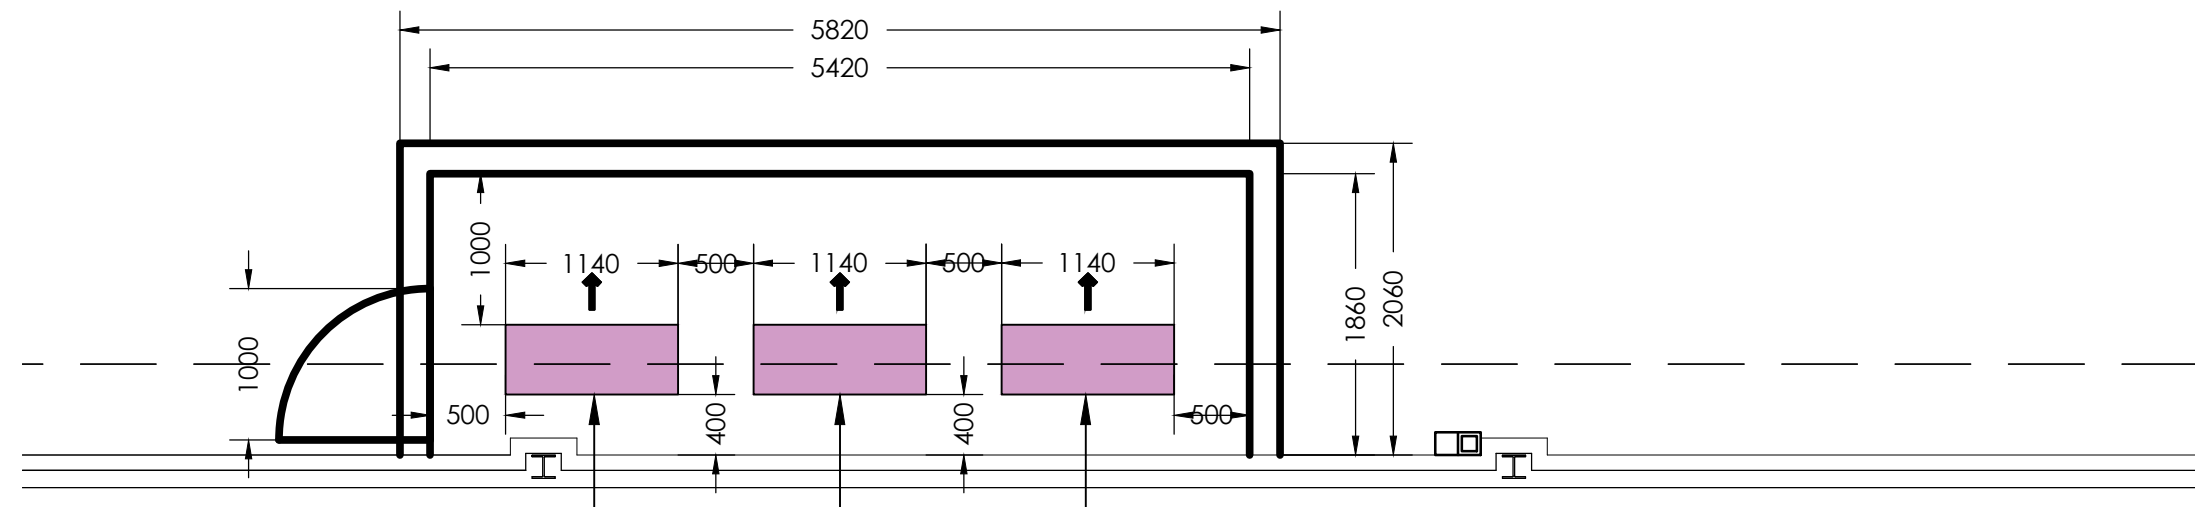


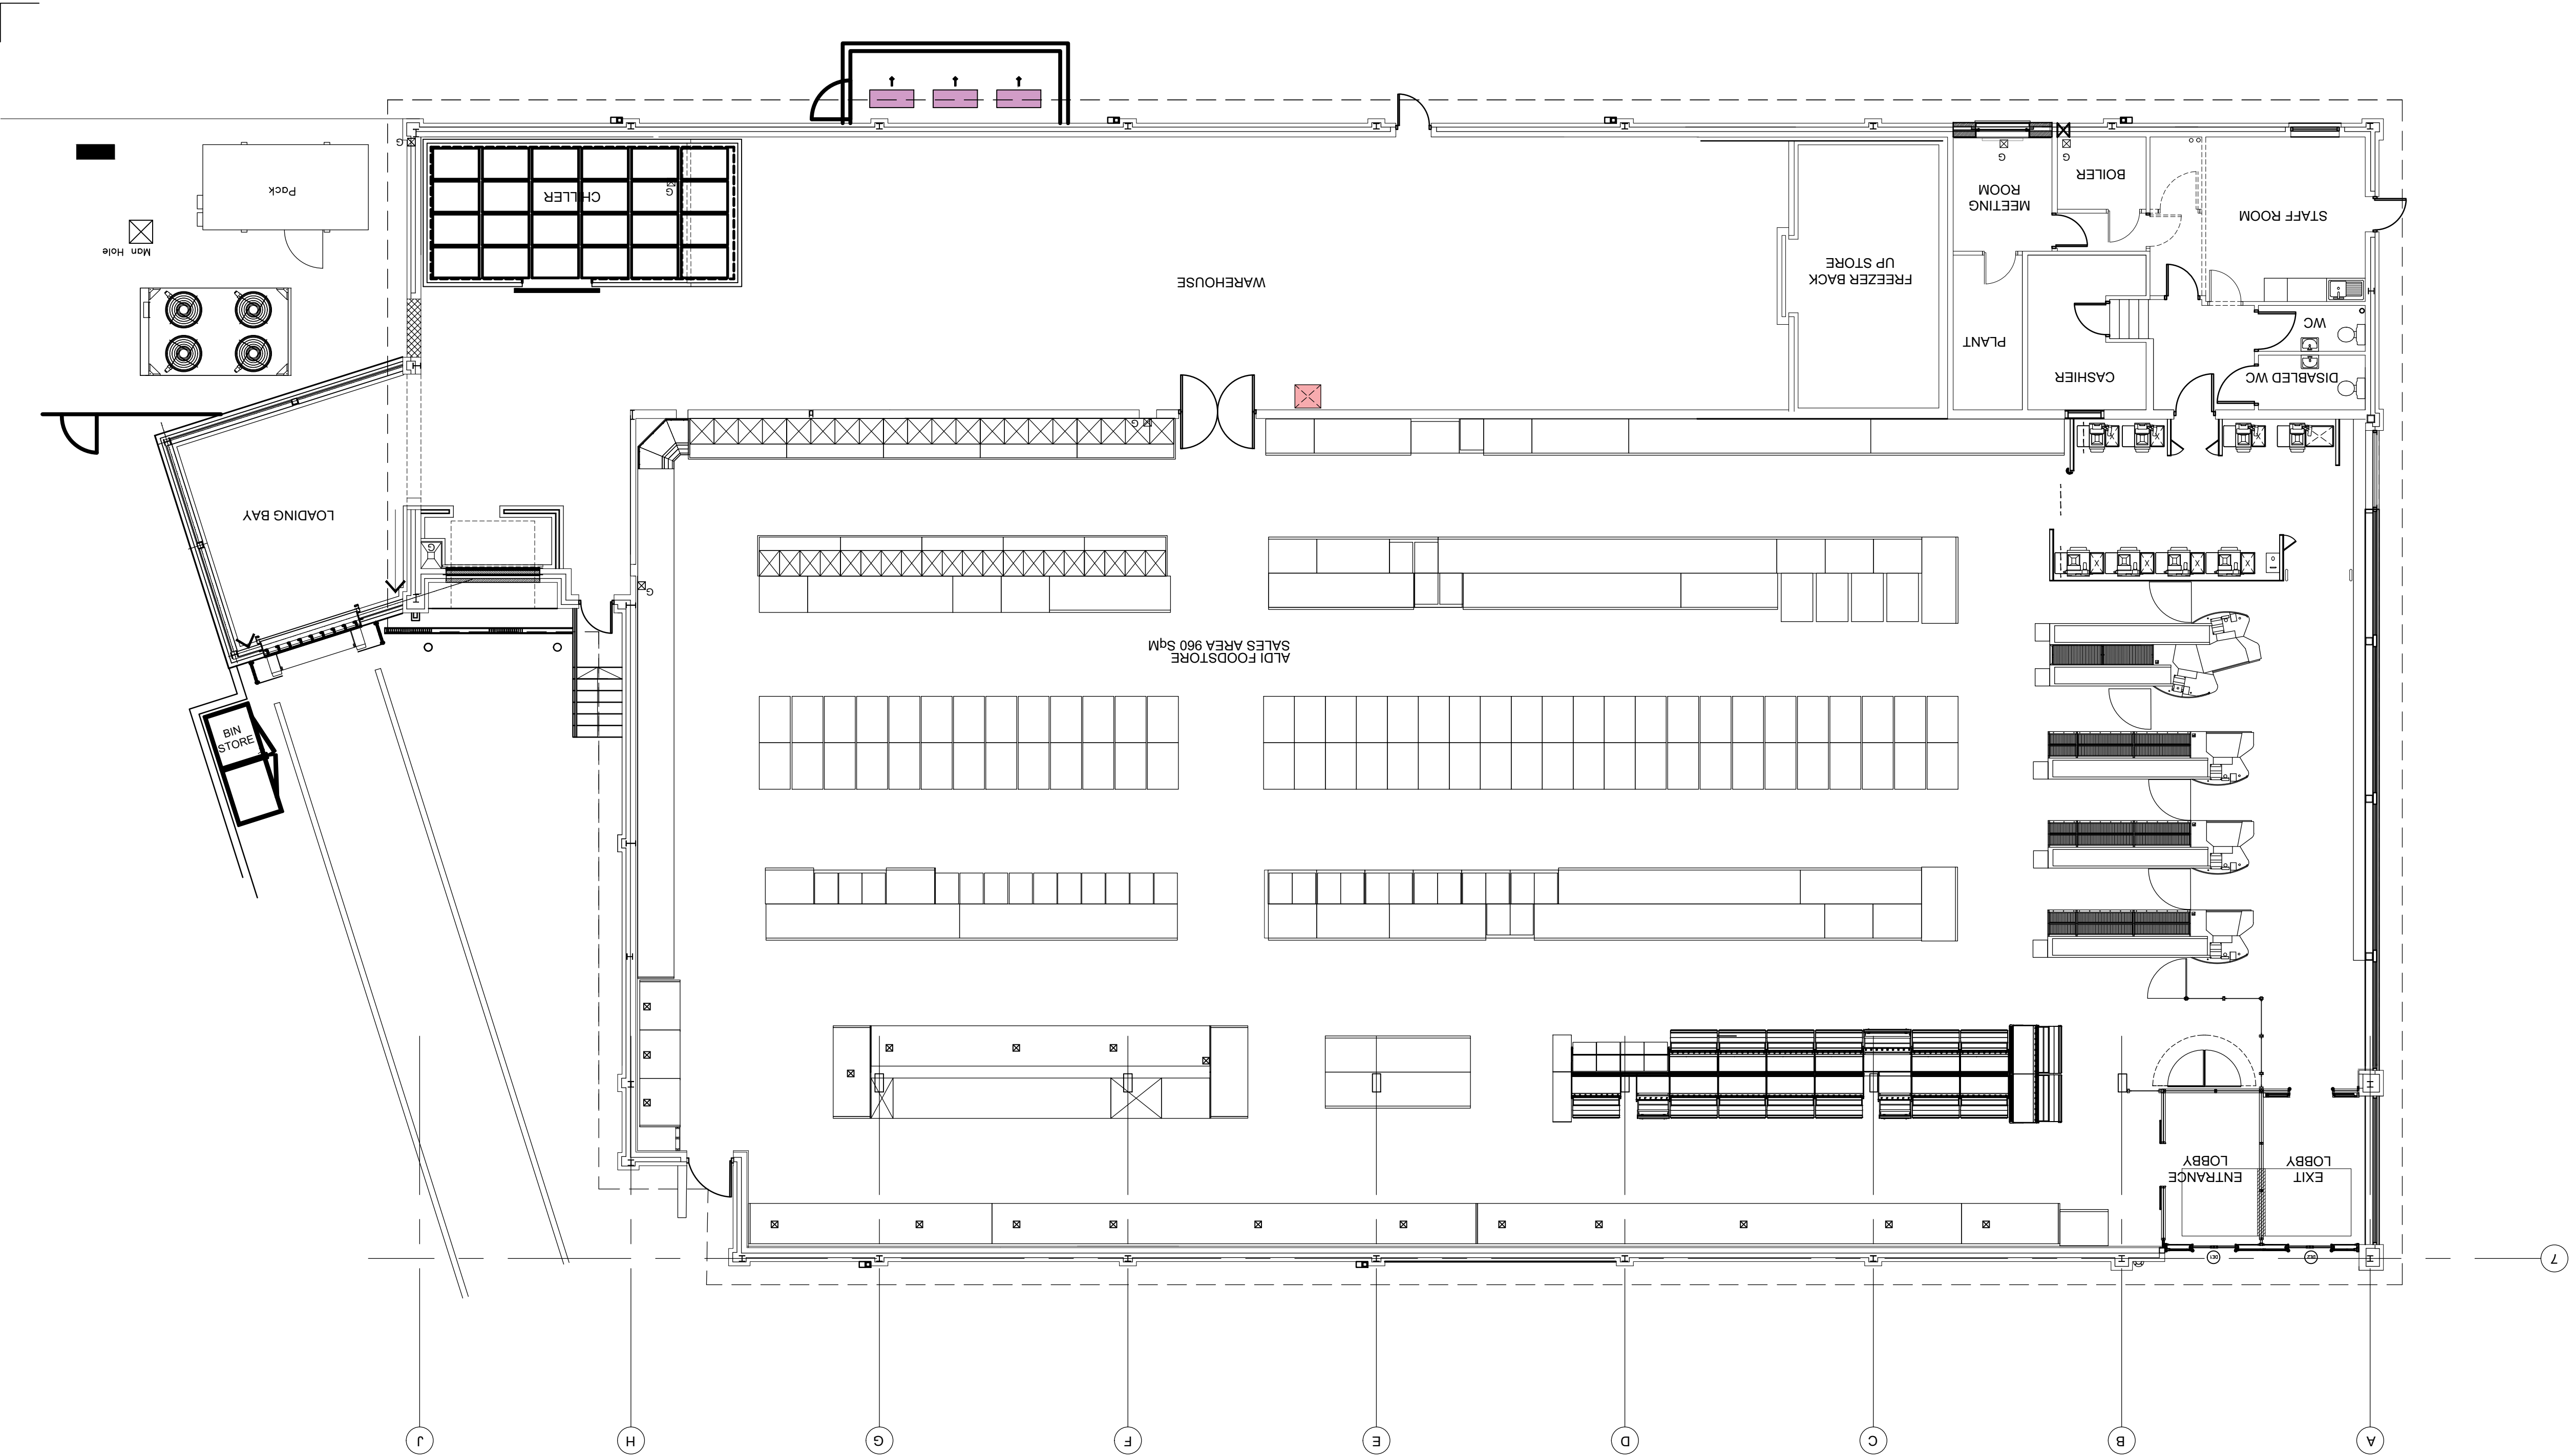


3NO. PANASONIC U-200PZH4E8
20kW DX HEAT PUMPS.
REFER TO MECHANICAL SERVICES
SPECIFICATION FOR FURTHER DETAIL.

Proposed ASHP location to be
confirmed by WGC.
Mechanical protection will be required.

PROPOSED ASHP PLANT - SCALE 1:50

The Harris Partnership Ltd does not accept liability for any deviation from our drawings or specification. This drawing is copyright and may not be reproduced or shared in whole or part without written authority. Do not scale off this drawing.

Rev	Date	Description	Drawn	CHK'd
P01	27.02.26	INITIAL ISSUE	EM	WH
P02	01.06.26	PLANNING DRAWING ISSUE	EM	WH

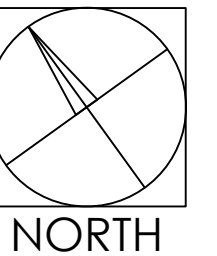

0 1000 2000 3000 4000 5000mm
SCALE 1:100



Architecture
Masterplanning
Interior Design

www.harrispartnership.com

Wakefield Manchester Milton Keynes Reading London Harrogate Edinburgh

Client

Aldi Stores Ltd



Project Title

National ASHP

GOL014

Doncaster Road

Barnsley

S70 3PE

Drawing Title

Proposed Floor Plan

Drawn	Checked	Scale	BIM Status	Date
-------	---------	-------	------------	------

EM	WH	1:100	S2	02/26
----	----	-------	----	-------

Drawing Status	Rev.	THP Project No
----------------	------	----------------

PLANNING	P02	23017
----------	-----	-------

Project No.	Originator	Volume	Level	Type	Role	Number
-------------	------------	--------	-------	------	------	--------

GOL014	THPW	XX	00	DR	A	(00)11
--------	------	----	----	----	---	--------