


1. All work to be in accordance with the current Building Regulations 2. Only written dimensions to be used 3. Discrepancies and abnormalities to be reported. 4. If in doubt Ask.

SEE GROUND INVESTIGATION REPORT FOR DETAILS OF TRIAL HOLES INDICATING THE PRESENCE OF CLAY SOILS AND CONFIRMATION THAT SOKKAWAYS ARE NOT A SUITABLE MEANS OF DRAINING SURFACE WATER

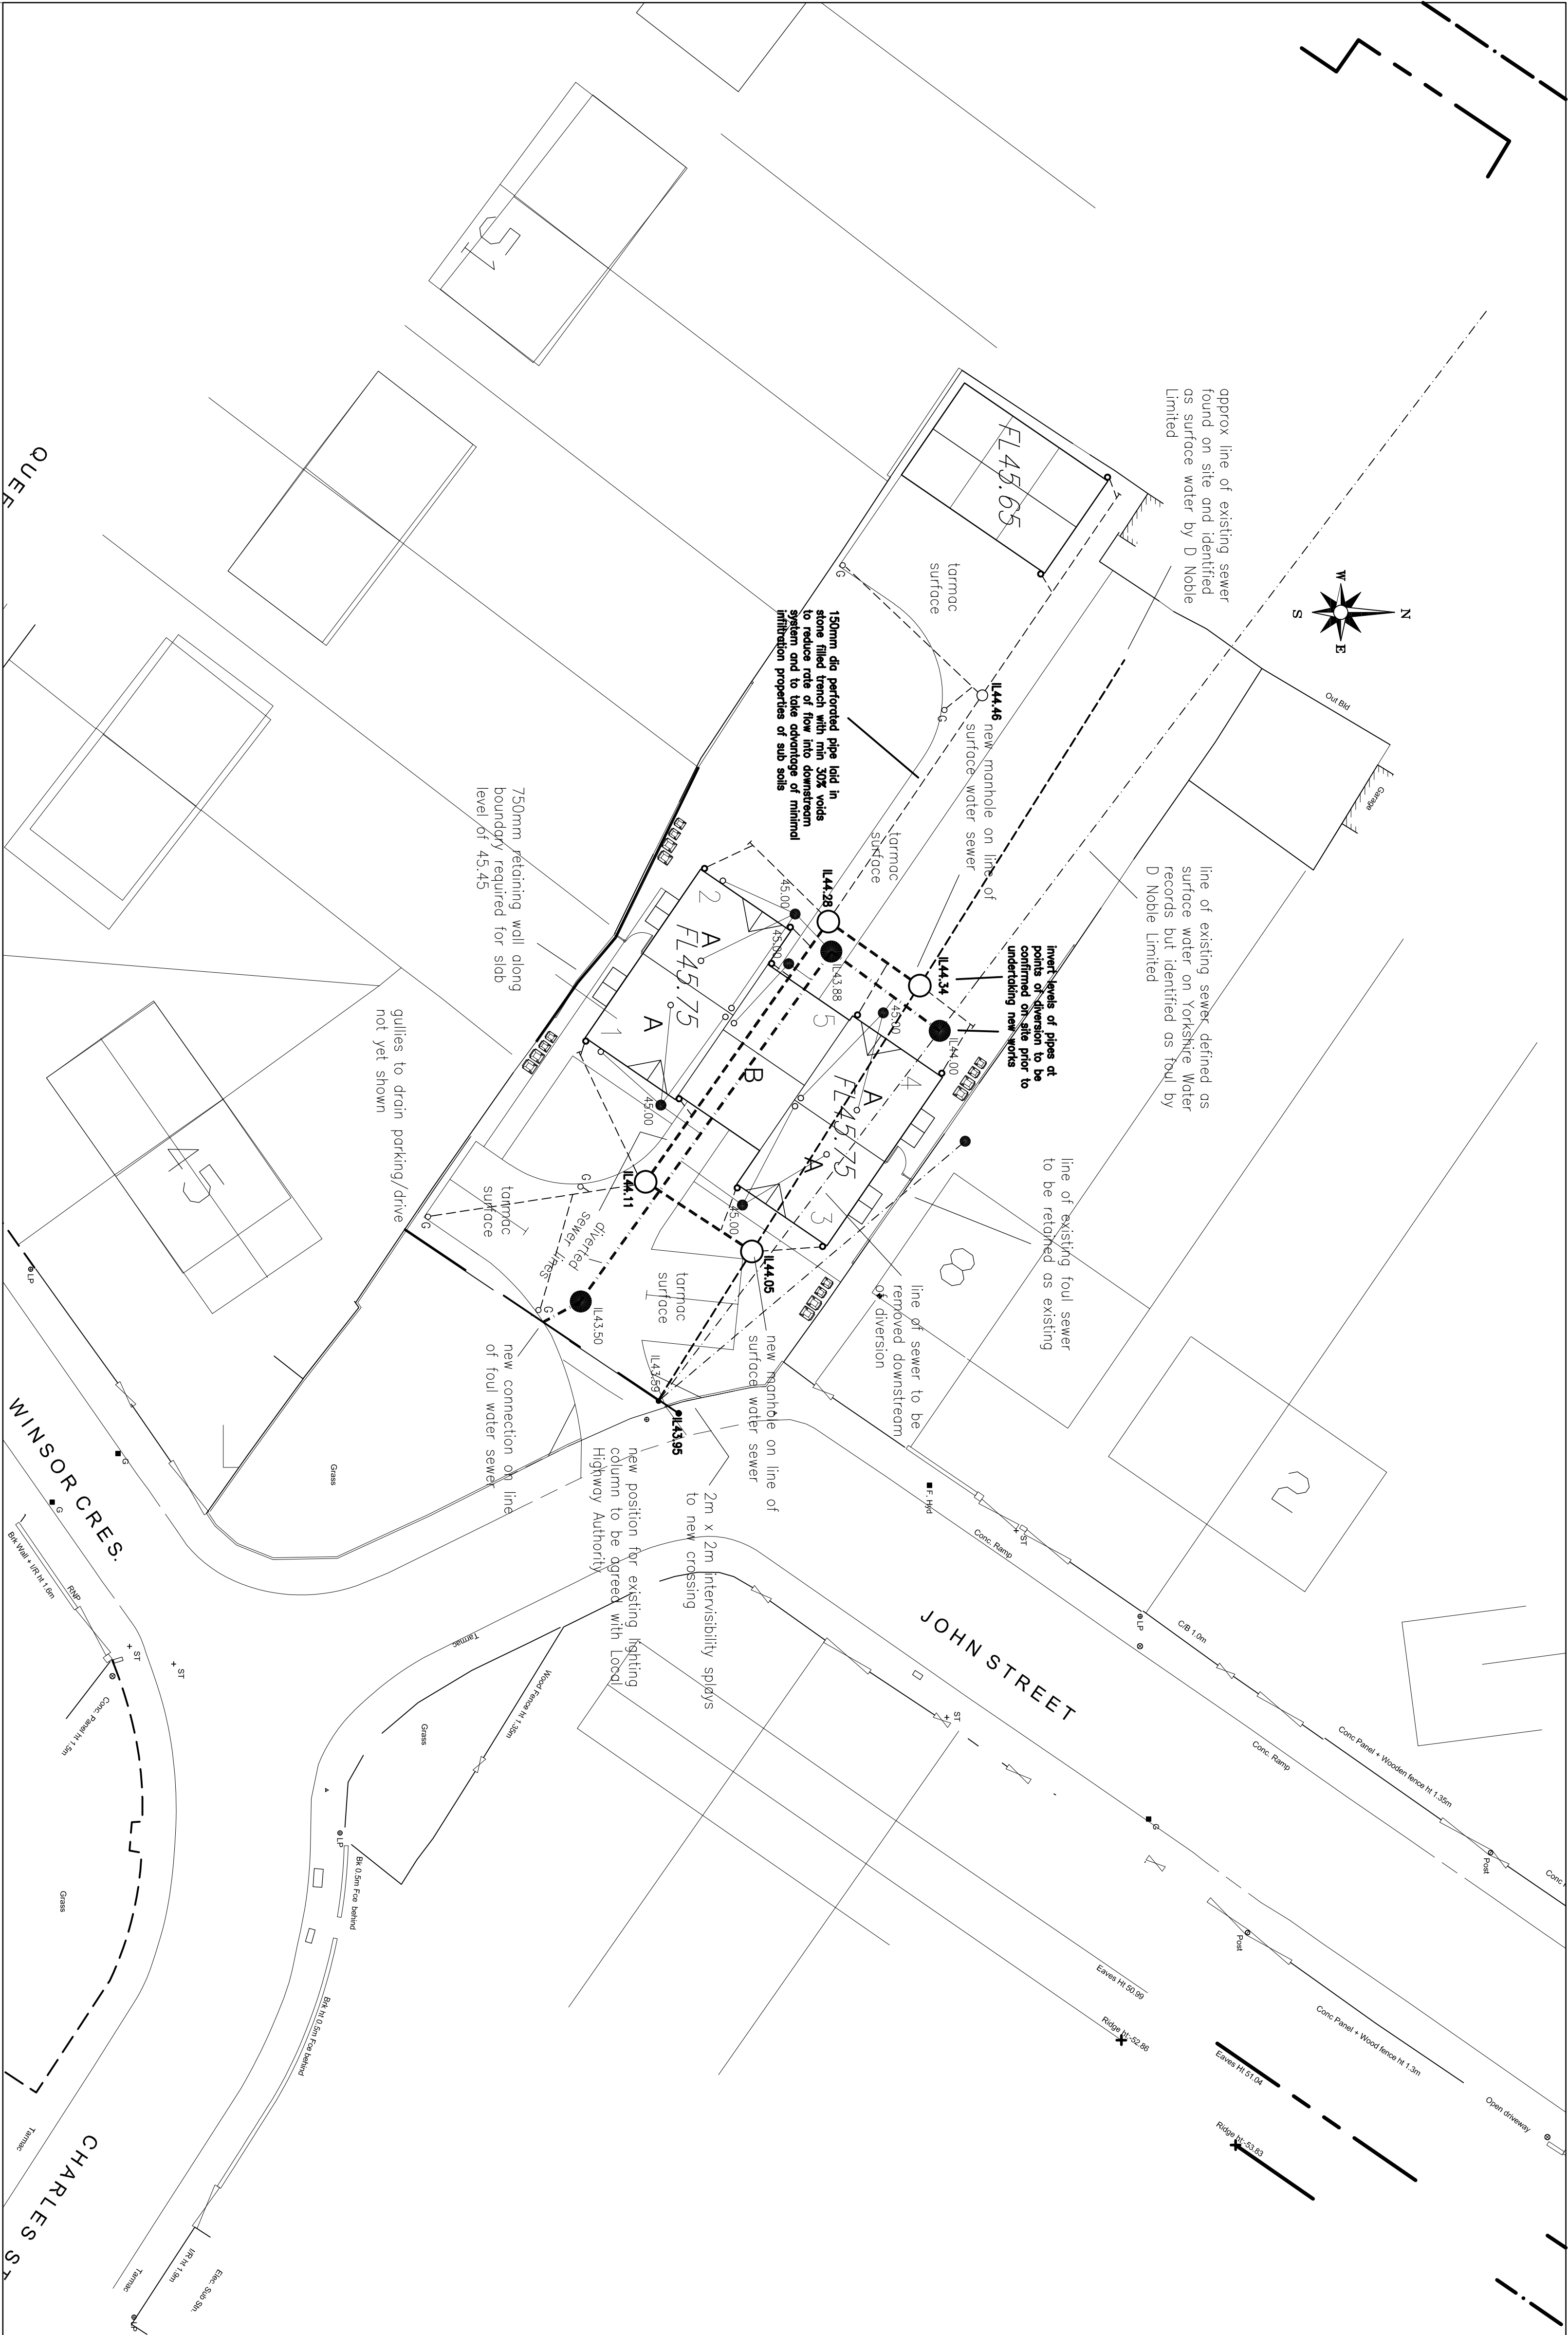

B. 17/06/10 surfacing notation/section added (CDN)
A. 28/04/10 extra drainage details added (CDN)
Revision.

James Eaton Design

Design Consultant

Development • Highways • Drainage

Stoneycroft, Brackenhill, Ackworth,
Pontefract. West Yorkshire WF7 7BG.

Tel. 01977 618626 Fax 01977 625114
e-mail iamos@iamosetopdesign.co.uk

Client.

D Noble Limited

Site. John Street,
Middlecliffe.

Title. *Drainage Layout*

Date: _____ Scales: _____ Drawing No. _____

Jan 2010 1/200