




Note to contractor  
 Contractor to check all dimensions on site. Do not scale from this drawing. All materials and works to comply with BS EN standards as appropriate and to meet Building Control approvals. Services to comply with L8 water regulations current gas and electricity supply regulations. All materials are to be new, unless otherwise described. This drawing to be read in conjunction with all other contract drawings and documents and also in conjunction where relevant with Mechanical & Electrical details and drawings. All works are to be carried out in compliance with CDM 2015 Regulations and all other Health and Safety legislation..

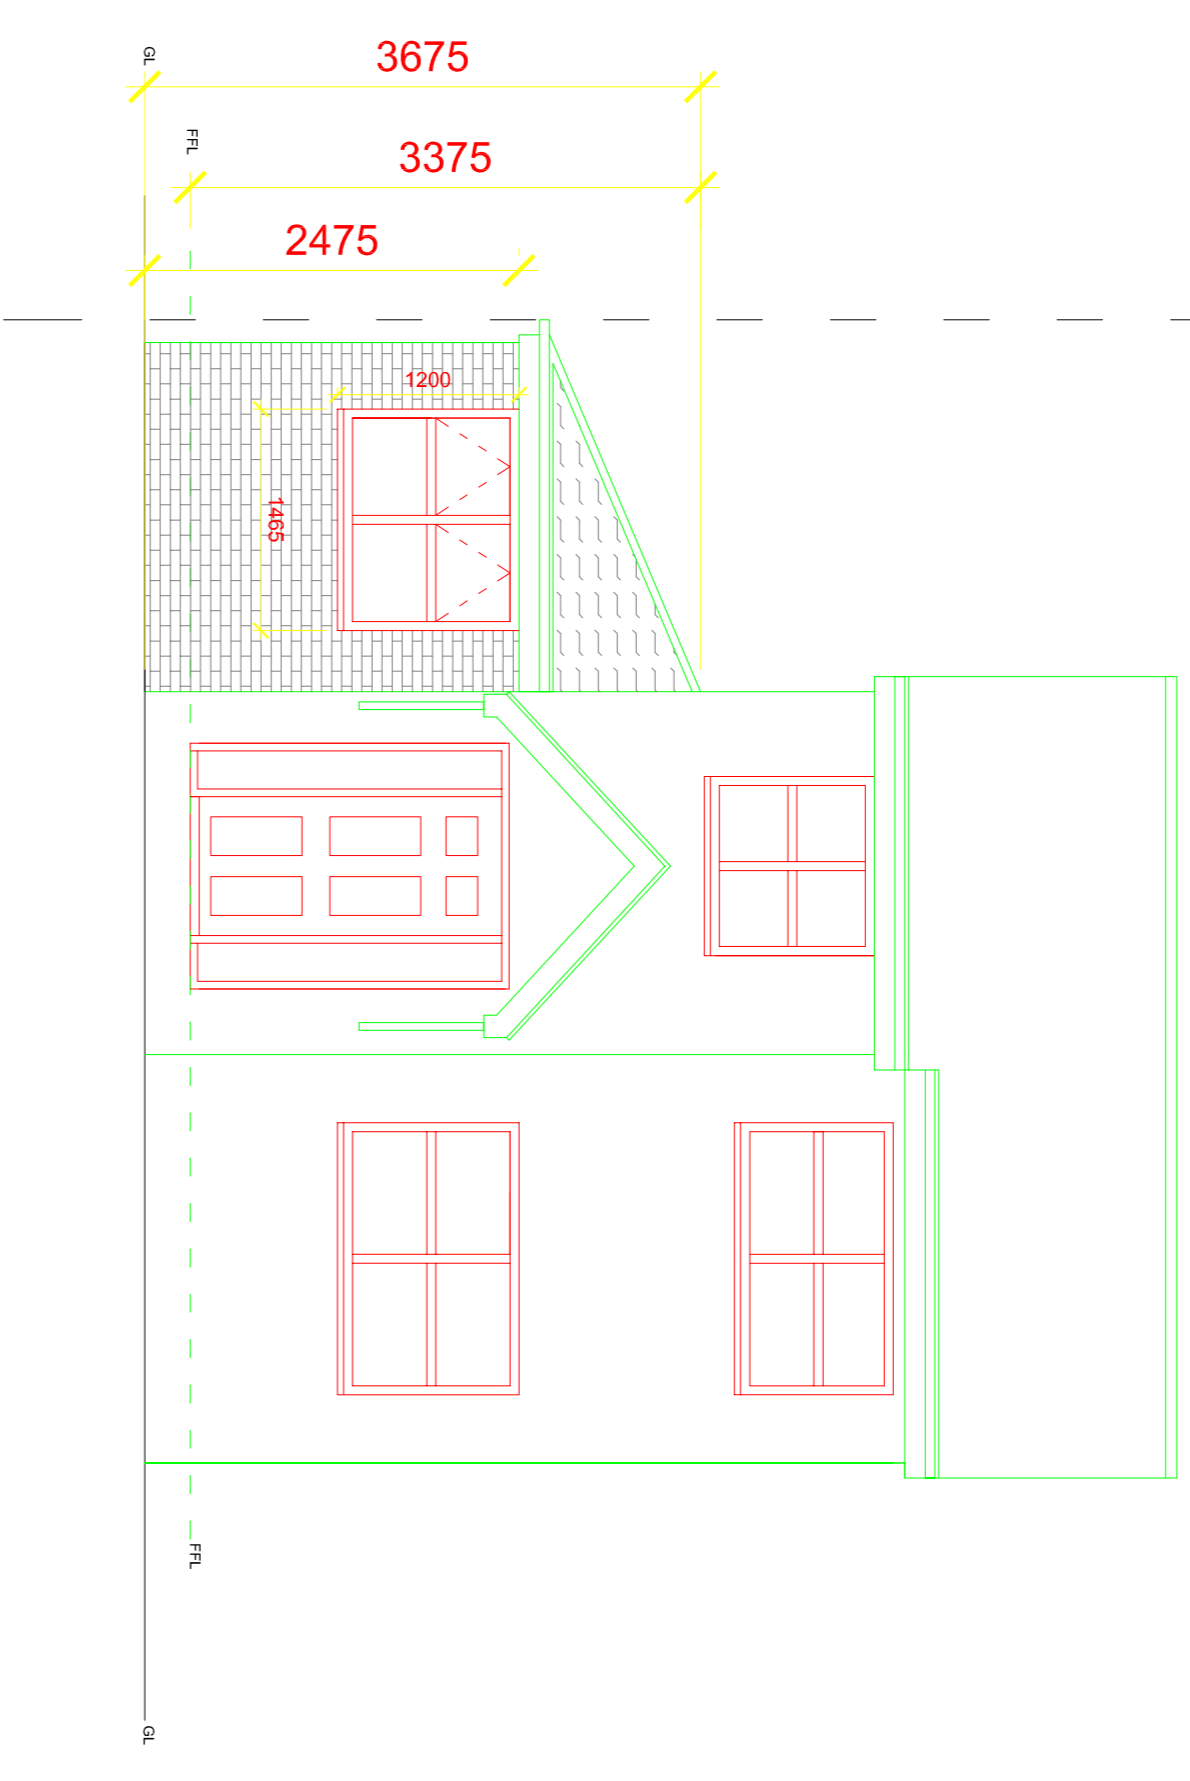


PROPOSED FRONT ELEVATION

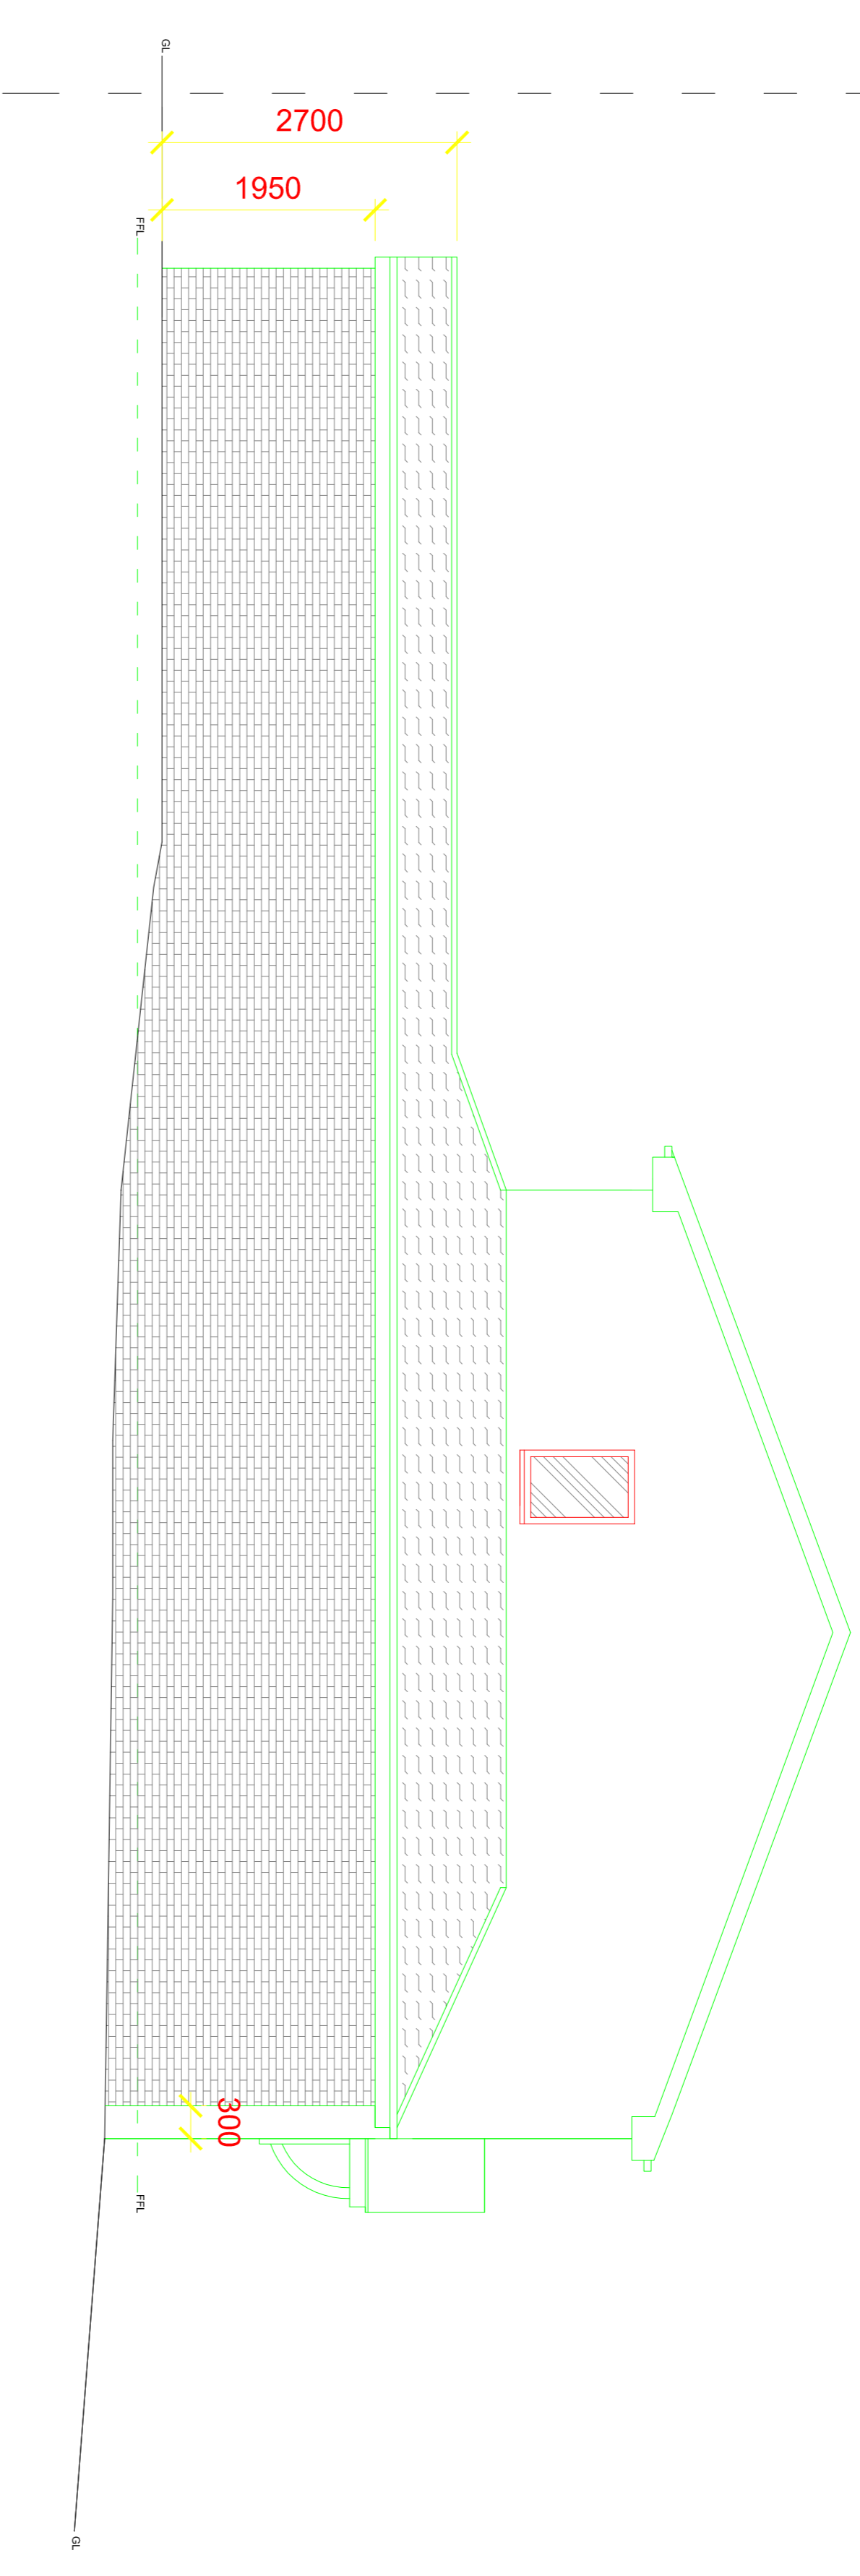

PROPOSED SIDE ELEVATION

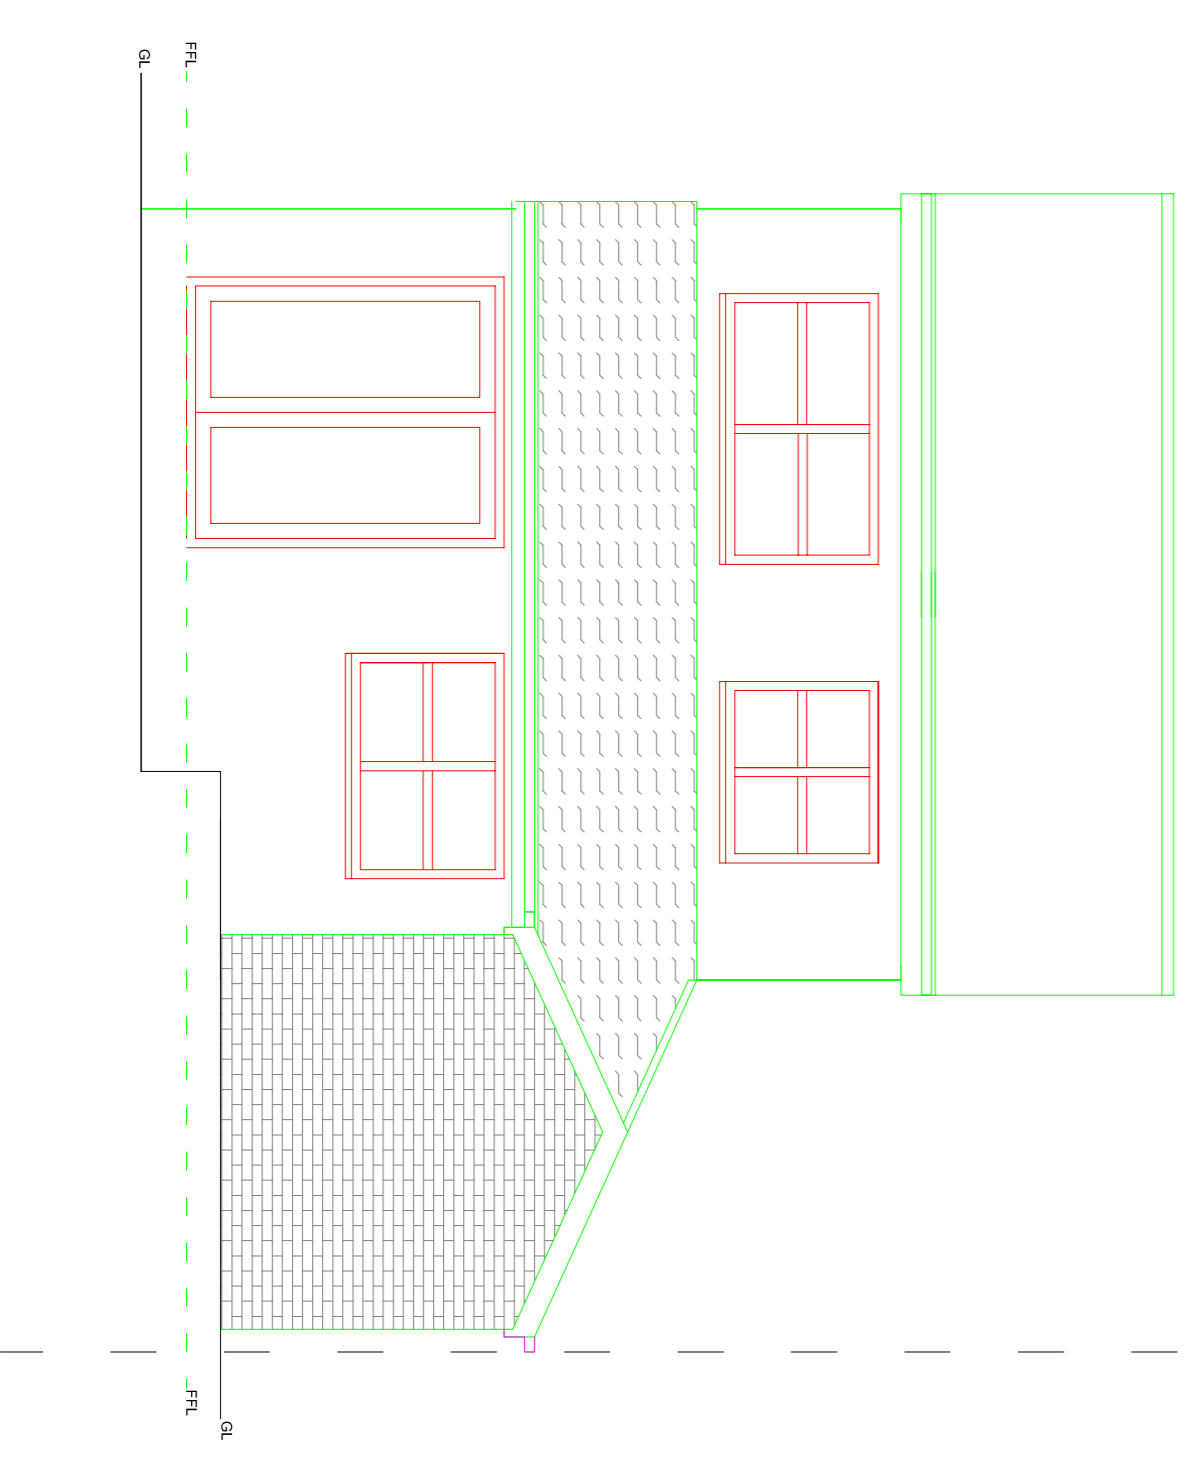


PROPOSED REAR ELEVATION

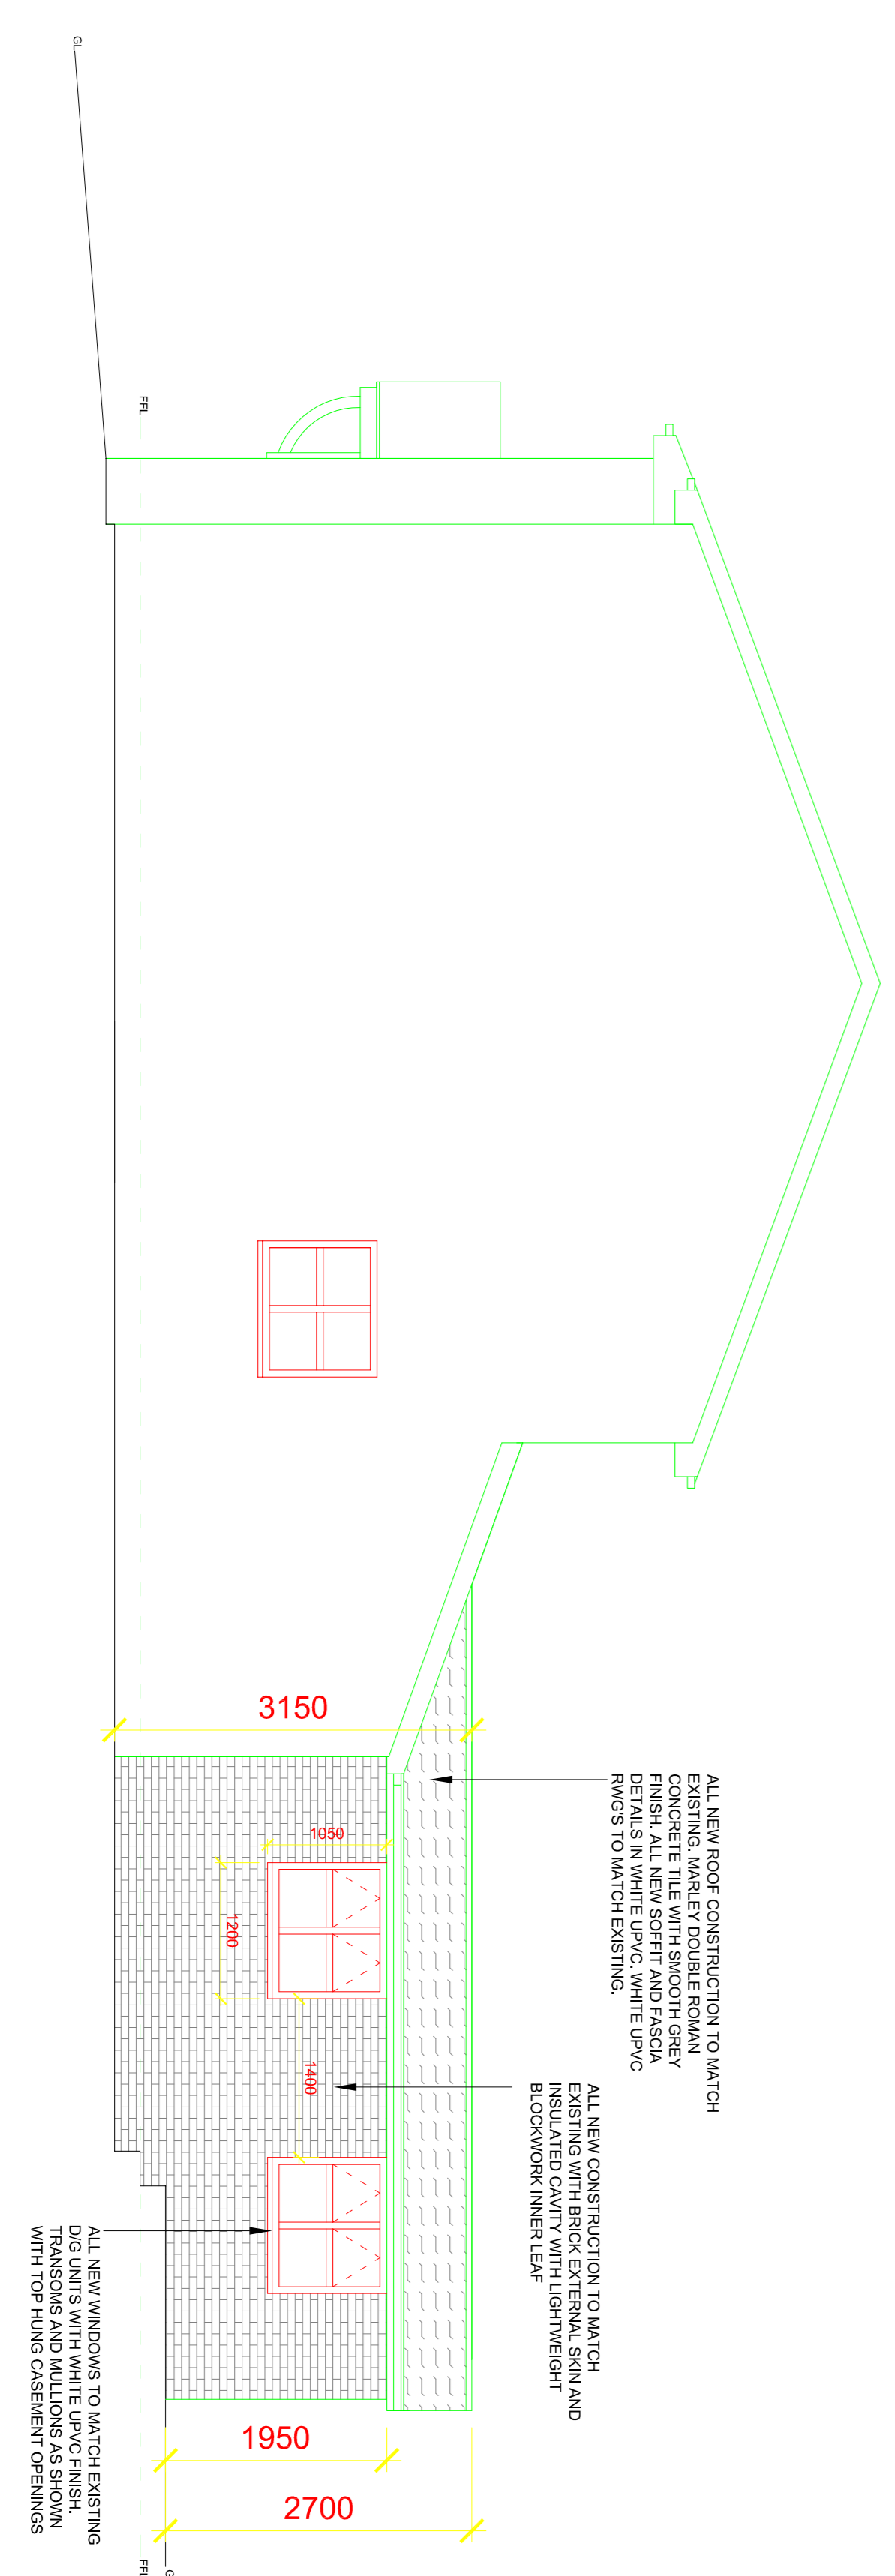

PROPOSED SIDE ELEVATION

**DO NOT SCALE**  
 © This drawing, including the design and technical information contained on it, is the copyright of sdb. The drawing may only be used for the specific purpose for which it was prepared and may not be reproduced or copied without prior permission.

email: [info@sdburysdesign.co.uk](mailto:info@sdburysdesign.co.uk)  


**PROJECT**  
 Proposed Single Storey Side & Rear Extension  
 2 Montrose Avenue, Darton, S75 5LS

<b>DRAWING TITLE</b> Proposed Elevations	<b>DRAWING NUMBER</b> 201801000005
---	---------------------------------------

<b>DATE</b> JUL 18	<b>SCALE</b> 1:100	<b>SHEET</b> A1	<b>DESIGNED</b> MM
<b>DRAWING NUMBER</b> 2018 000005			<b>REVISION</b> 1,1