



BUILDING DESIGN PARTNERSHIP SHALL HAVE NO RESPONSIBILITY FOR ANY USE MADE OF THIS DOCUMENT OTHER THAN FOR THAT WHICH IT WAS PREPARED AND ISSUED.
 ALL DIMENSIONS SHOULD BE CHECKED ON SITE.
 DO NOT SCALE FROM THIS DRAWING.
 ANY DRAWING ERRORS OR DIVERGENCES SHOULD BE BROUGHT TO THE ATTENTION OF BUILDING DESIGN PARTNERSHIP AT THE ADDRESS SHOWN BELOW.

NOTES

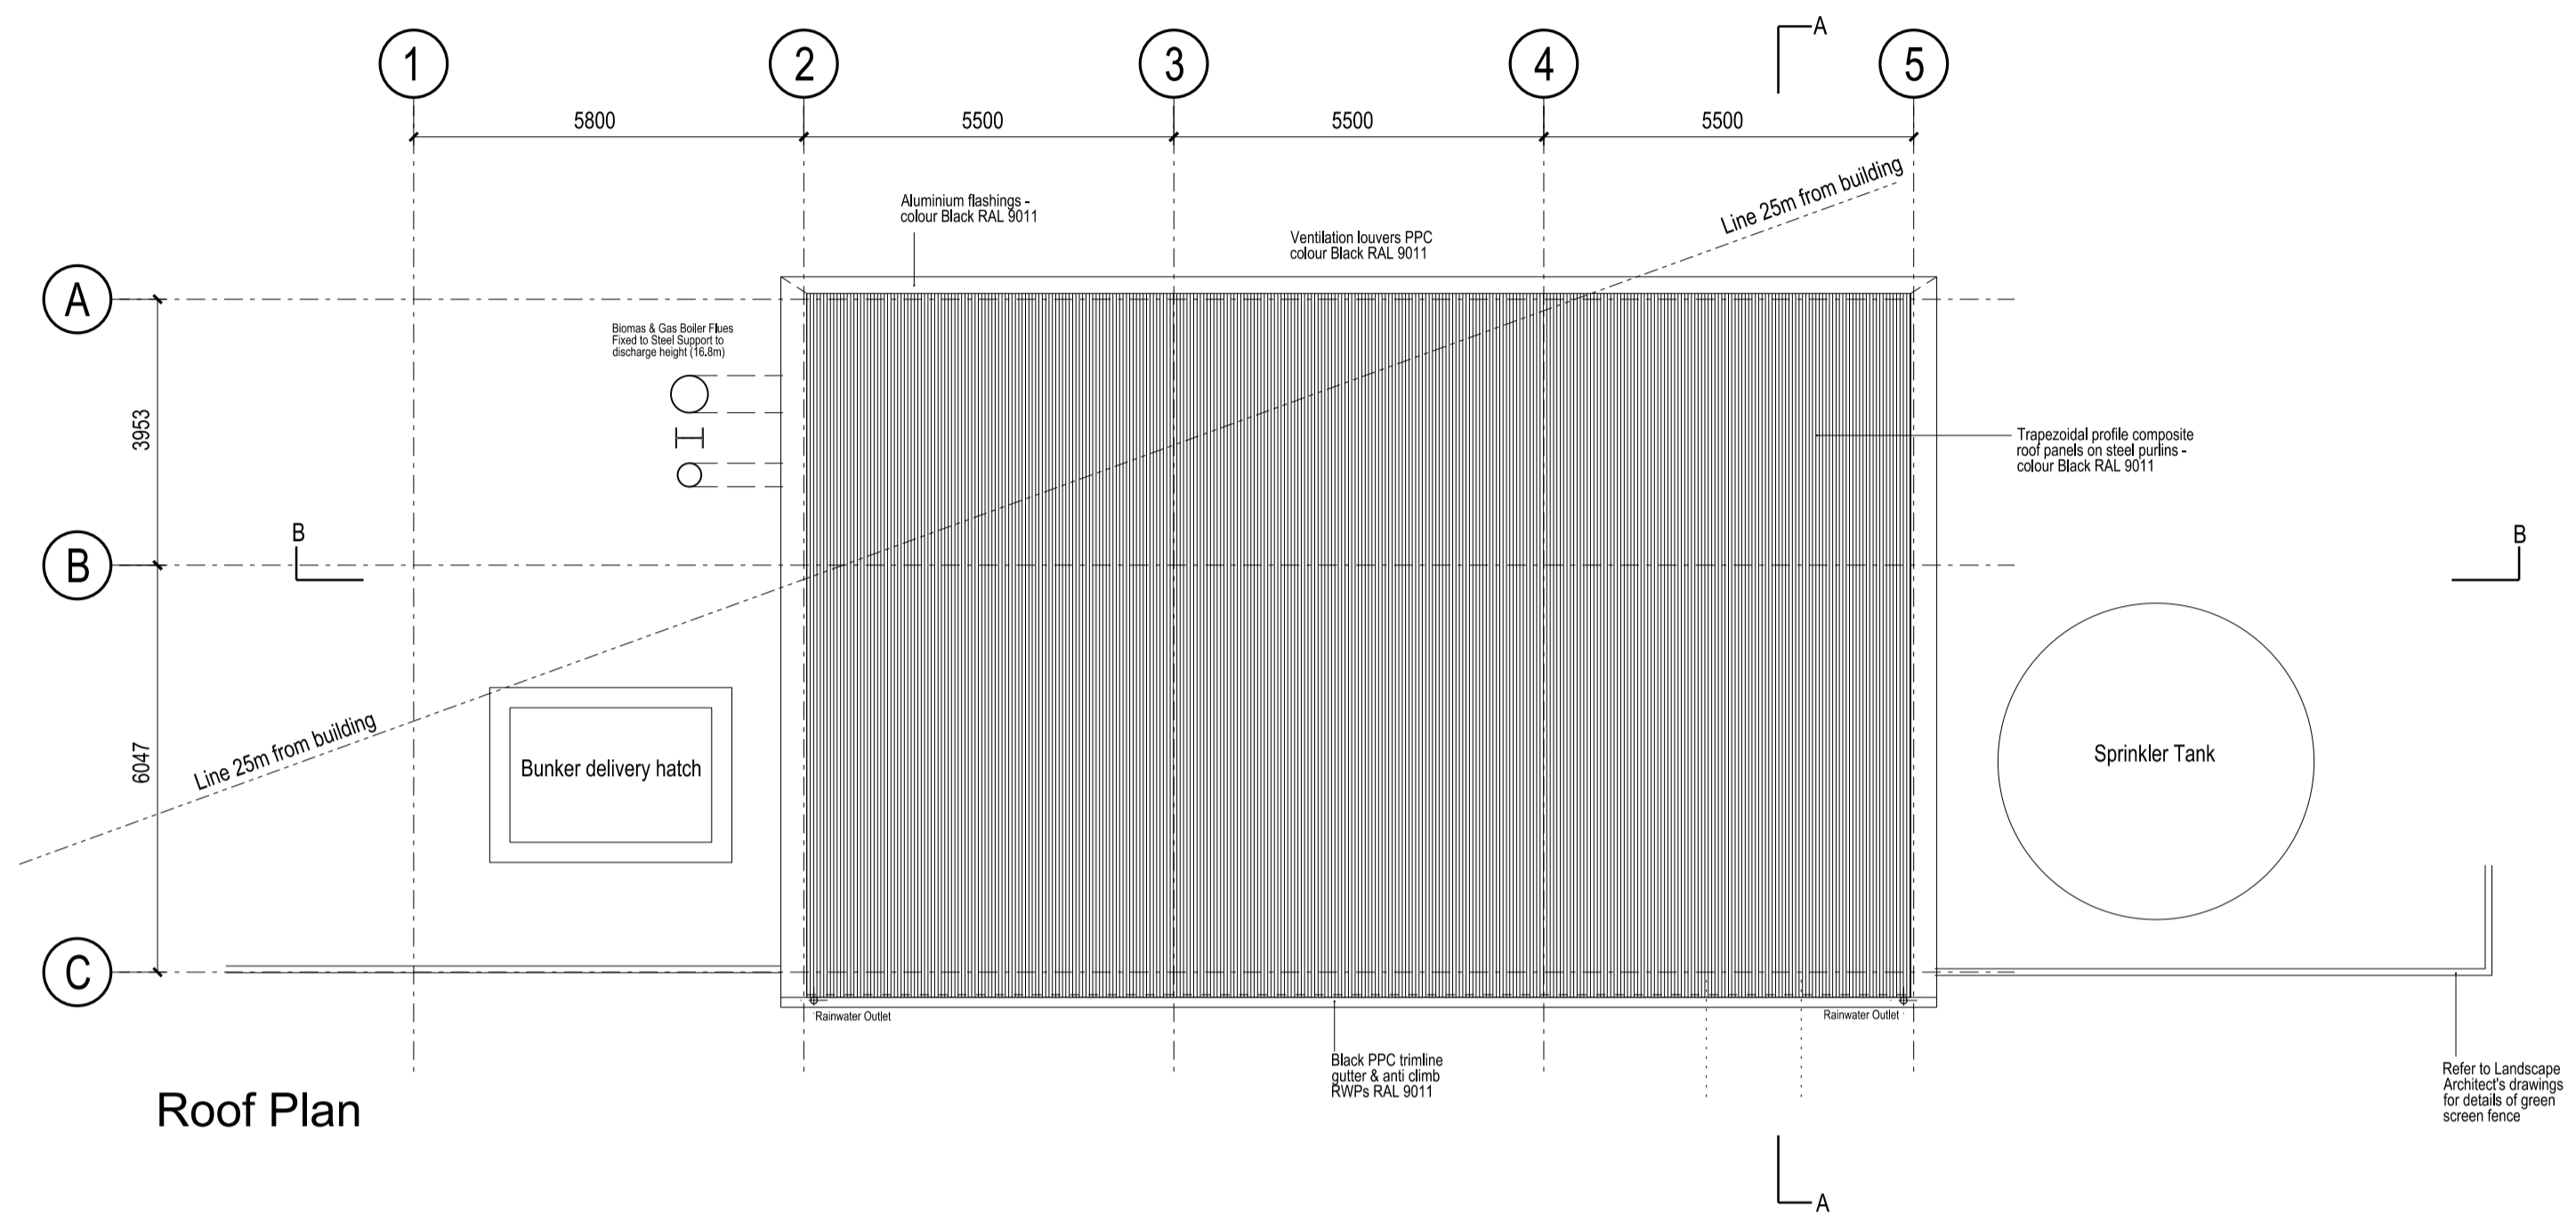

Roof Plan

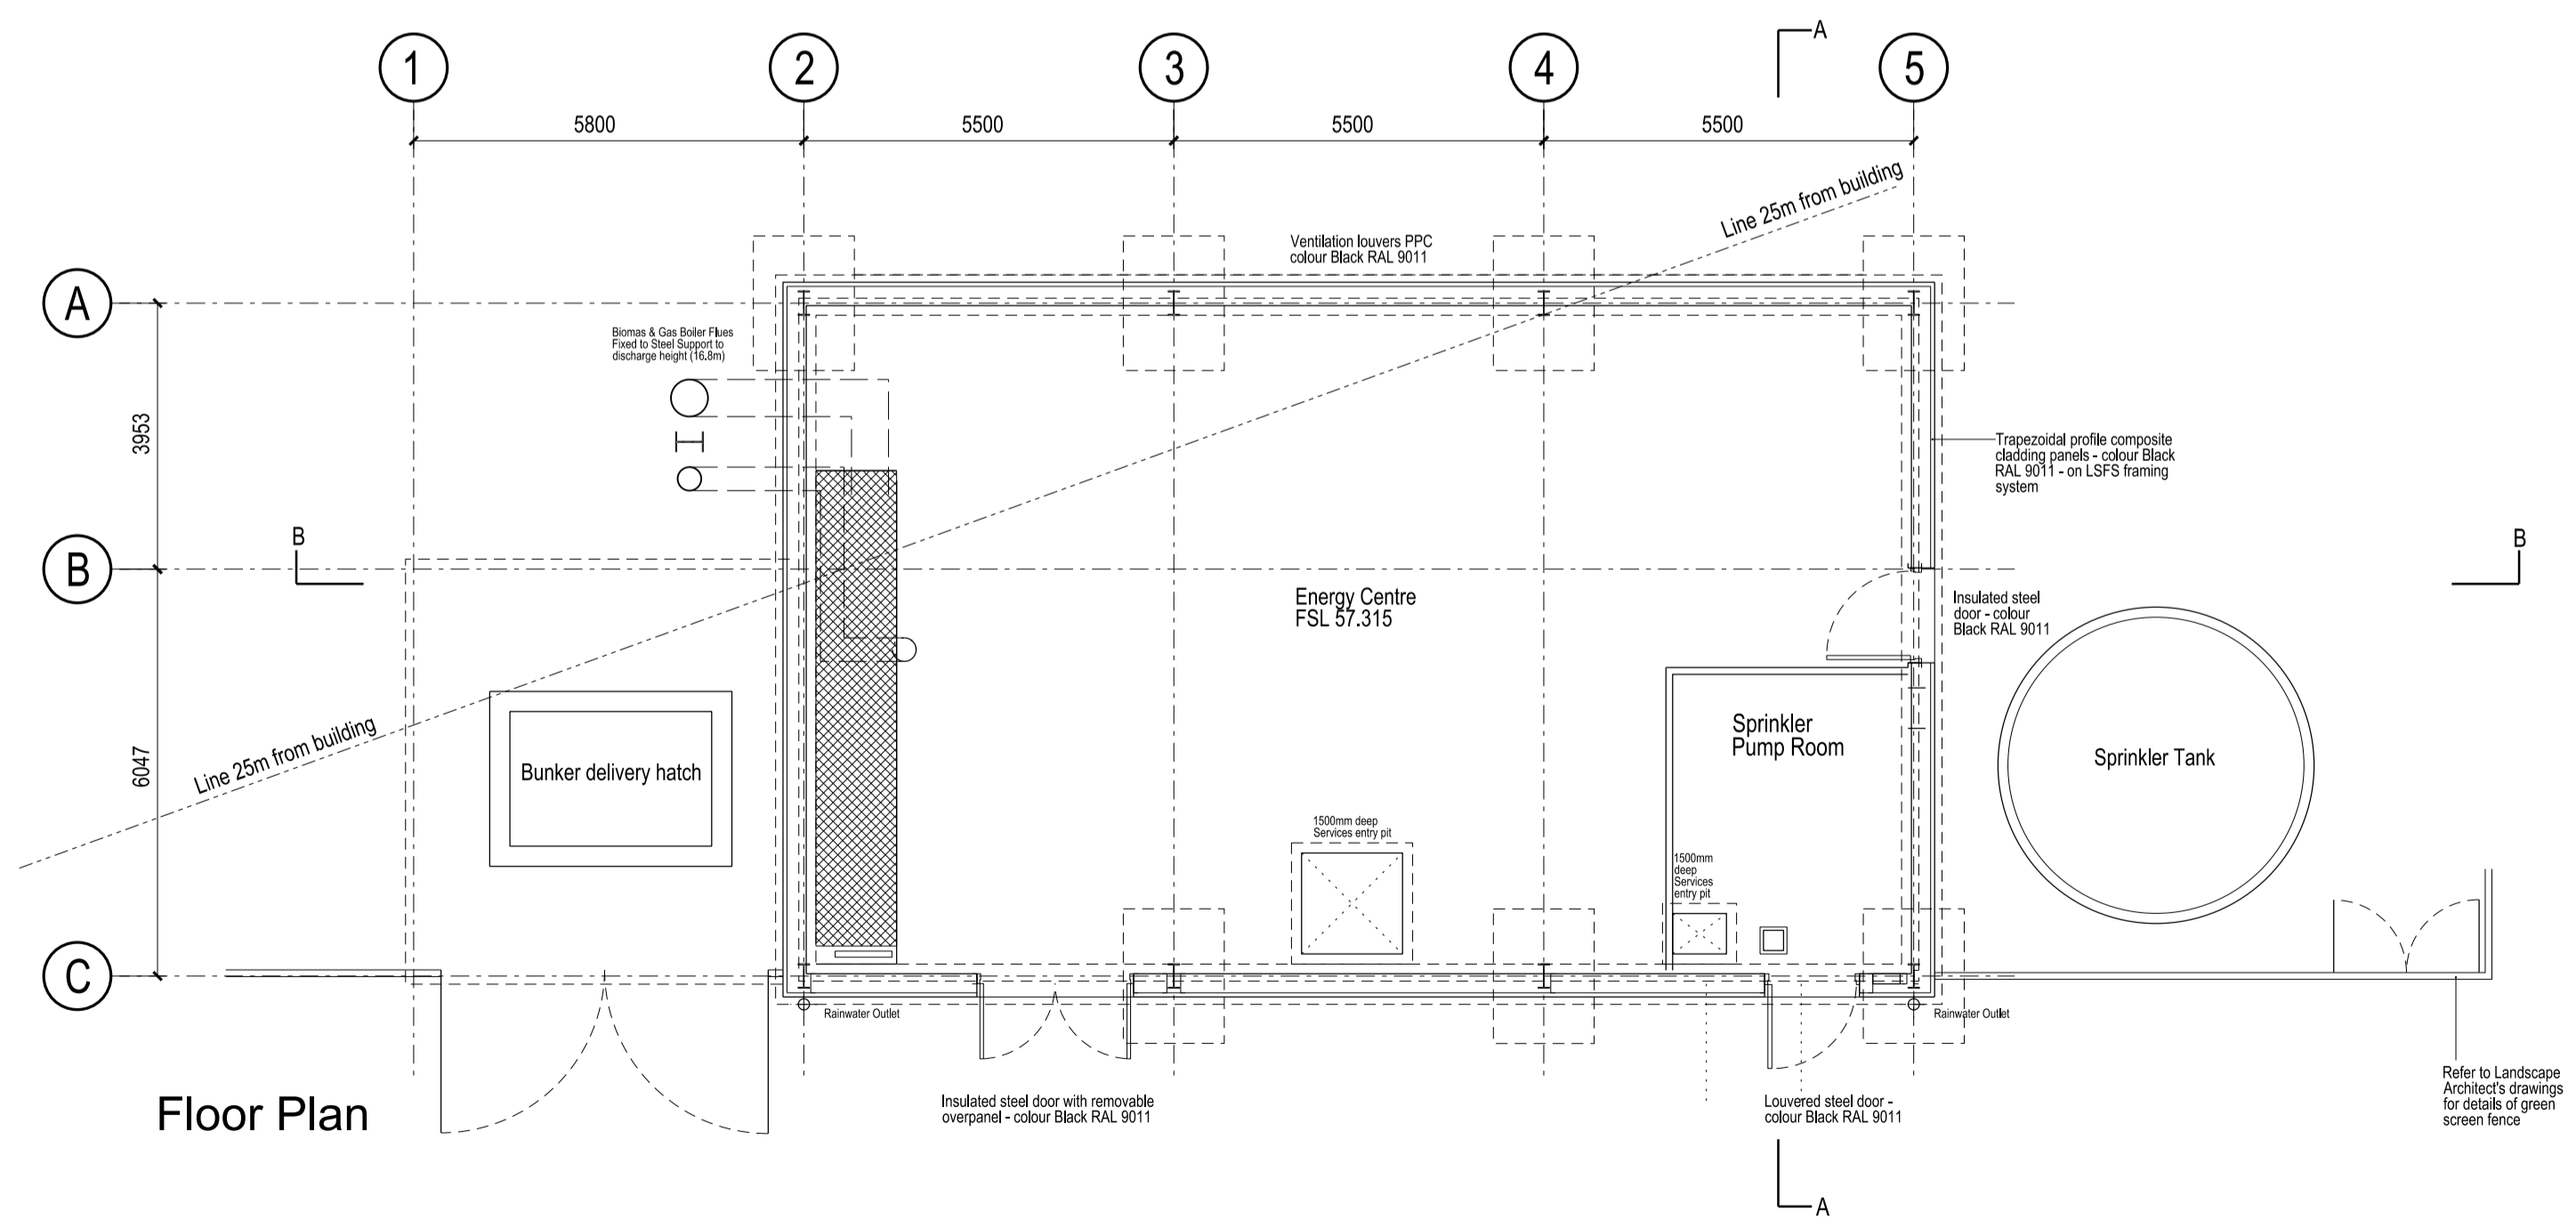

Floor Plan

PL01 Issued for Planning	MPW	JGE	24/05/10
--------------------------	-----	-----	----------

REVISION / DESCRIPTION	DRAWN	CHECKED	DATE



BDP.

1 North Bank
 Sheffield S3 8JY
 United Kingdom
 T +44 (0)114 273 1641
 F +44 (0)114 228 9925
 www.bdp.com

PROJECT TITLE Barnsley BSF Carlton Advanced Learning Centre	
PROJECT NUMBER P2001965	
DRAWING TITLE Energy Centre GA Plan & Roof Plan	SCALE 1:100@A1
DATE 24/05/10	REVISION PL01
DRAWING NO. BP4L_CAR_BDP_DR 04_EC_00_001	