 


DO NOT SCALE



THE COPYRIGHT IN THIS DRAWING IS THE PROPERTY OF AGT AND THE DRAWING MAY NOT BE REPRODUCED IN WHOLE OR IN PART, IN ANY FORM, WHETHER BY PHOTOGRAPH, PHOTOCOPIING OR REPRODUCTION AS A THREE DIMENSIONAL ARTICLE WITHOUT THE WRITTEN PERMISSION OF AGT

SCALE 1/50 @ A1





Notes

- THIS DRAWING TO BE READ IN CONJUNCTION WITH DRAWING: N6009-AGT-2017-DW MCC KIOSK PLANNING APPLICATION SITE PLAN & LOCATION PLAN
- UNLESS OTHERWISE NOTED, ALL DIMENSIONS ARE IN MILLIMETRES AND ALL LEVELS ARE IN METRES.
- PREFABRICATED GRP KIOSK TO BE SUPPLIED WITH OUTWARD OPENING DOORS AS PER YORKSHIRE WATER ASSET STANDARD.
- LOW LEVEL AND HIGH LEVEL VENTS TO BE DESIGNED AND FITTED BY KIOSK SUPPLIER IN ACCORDANCE WITH YORKSHIRE WATER SPECIFICATION AND ASSET STANDARDS.
- SINGLE ACCESS DOOR TO INCLUDE AN INTERNAL PUSH BAR OPENING DEVICE.
- KIOSK TO HAVE EMERGENCY LIGHTING SYSTEM.
- ILLUMINATED GREEN EXIT SIGNS TO BE FITTED INTERNALLY ABOVE DOORS.
- THE GRP KIOSK HAS BEEN DESIGNED IN ACCORDANCE WITH YW STANDARDS AND SPECIFICATIONS COLOUR BS4800 14C39 HOLLY GREEN.

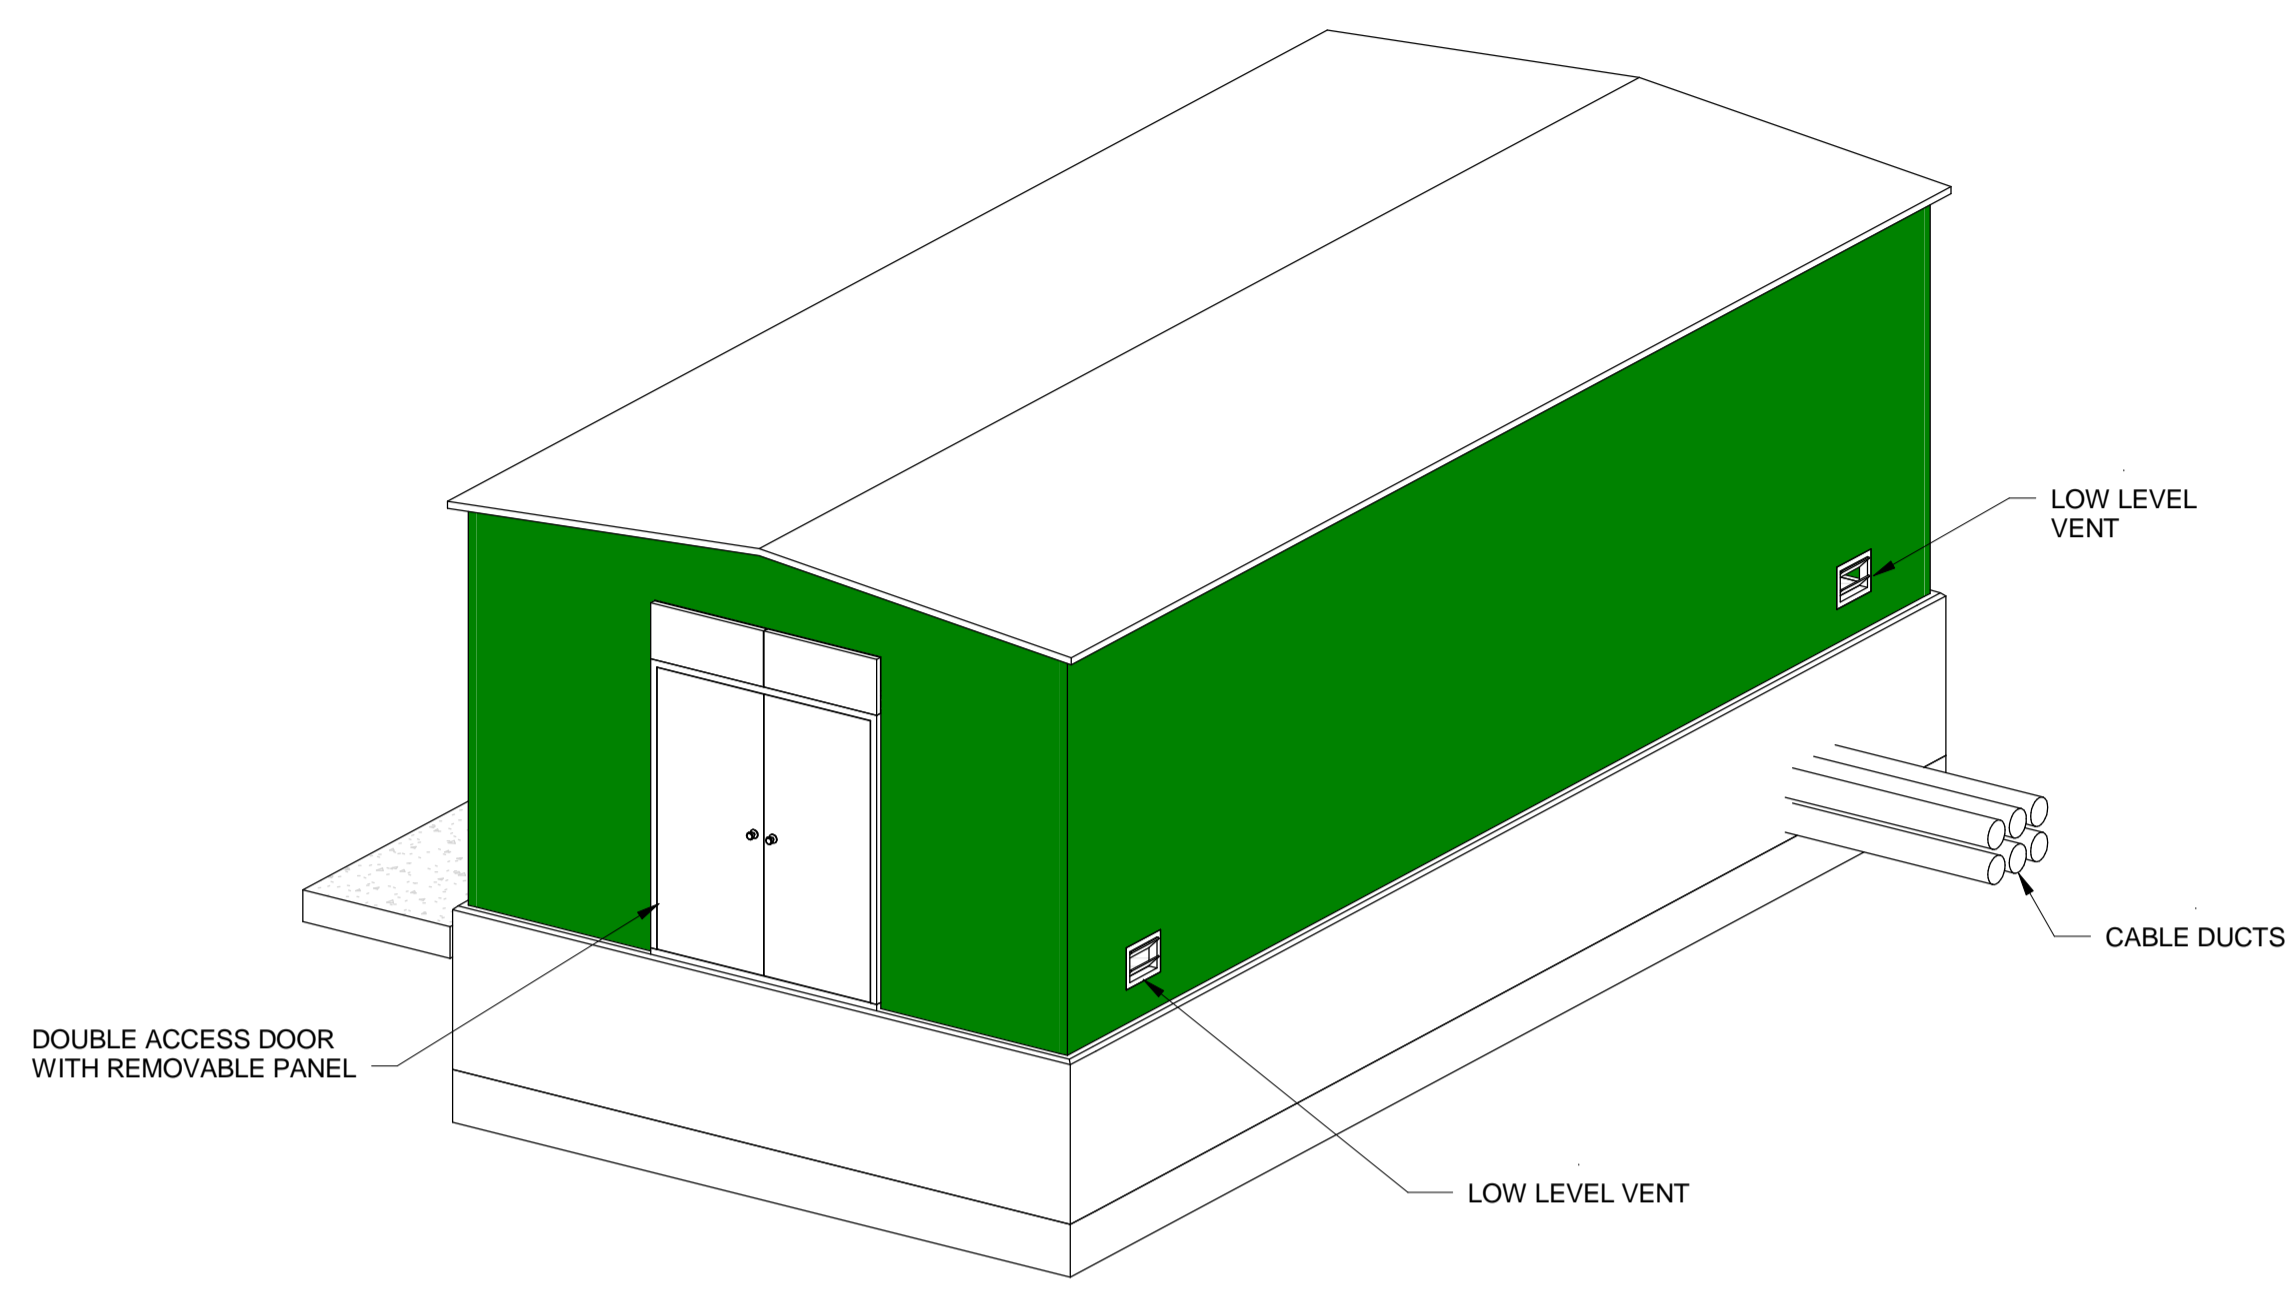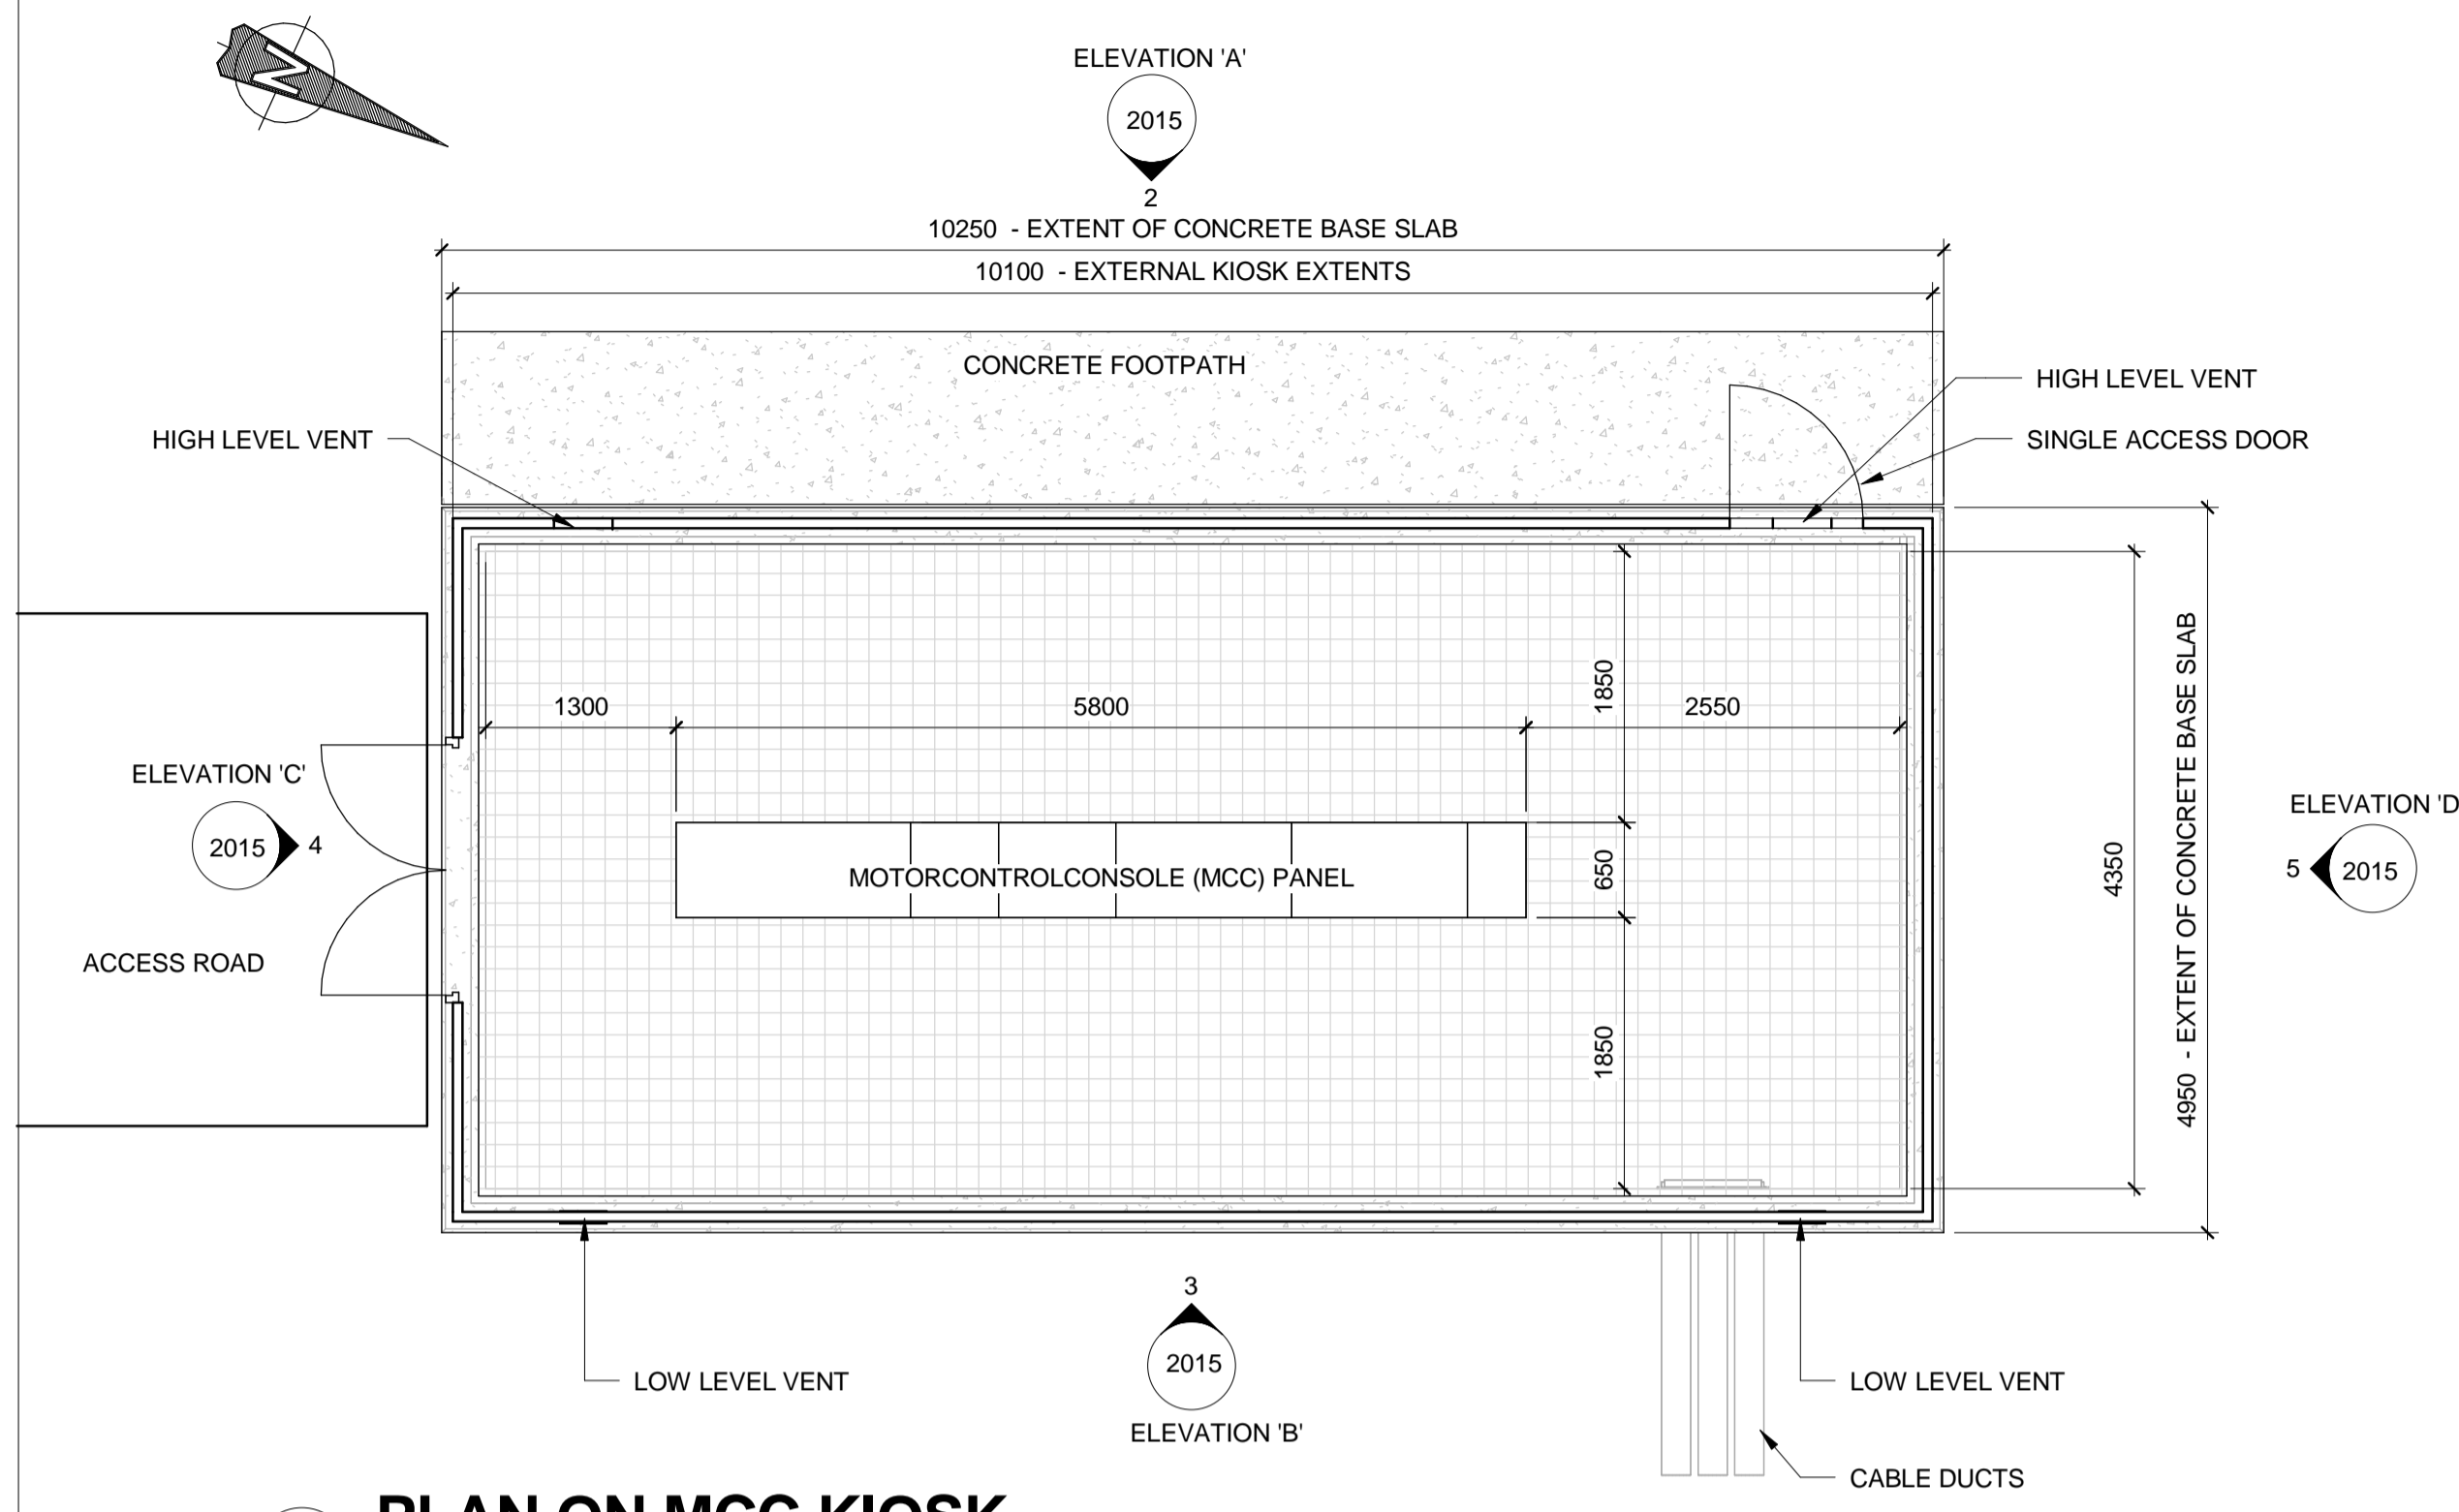



1 PLAN ON MCC KIOSK
1 : 50

6 3D VIEW MCC BUILDING

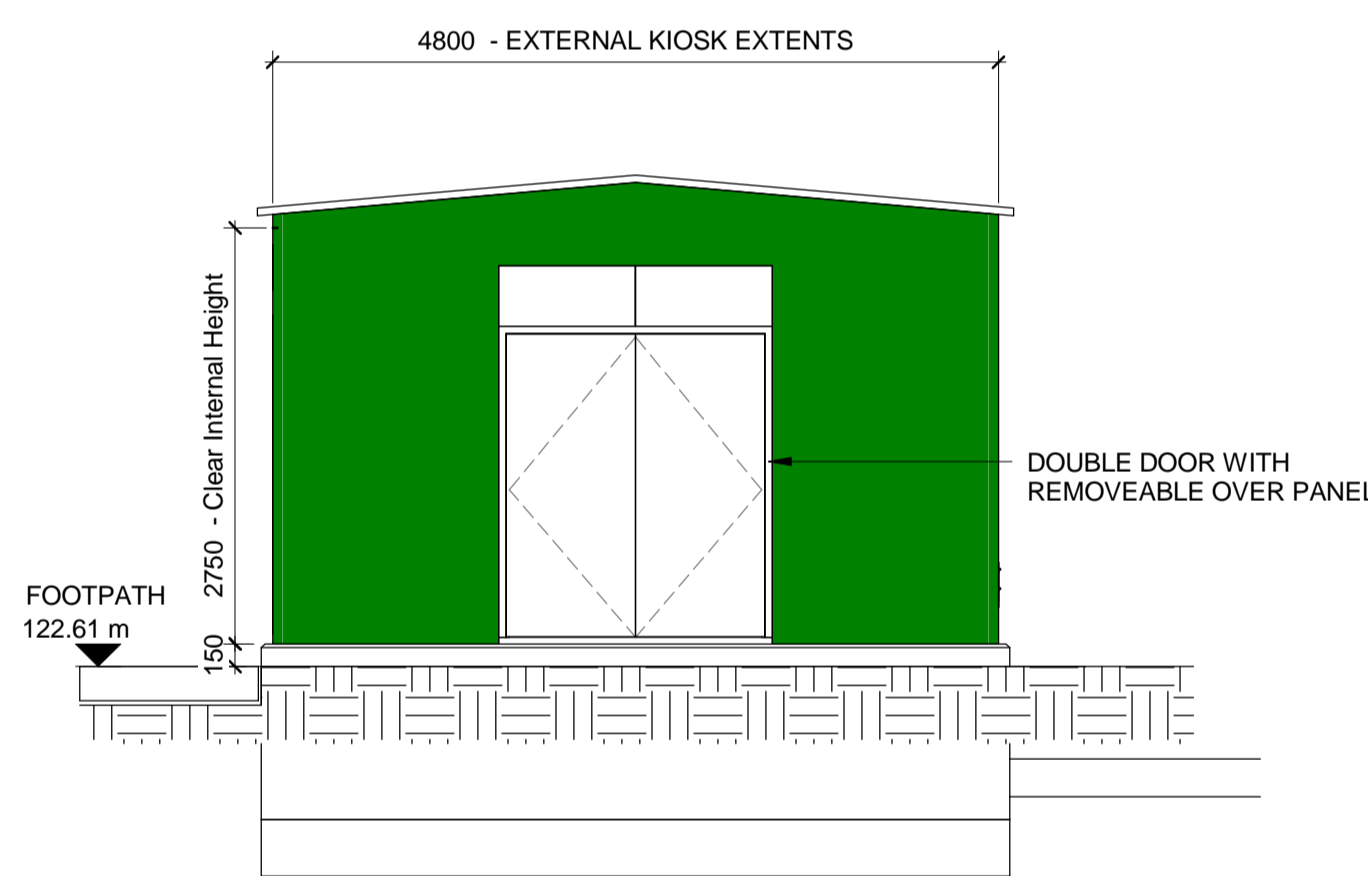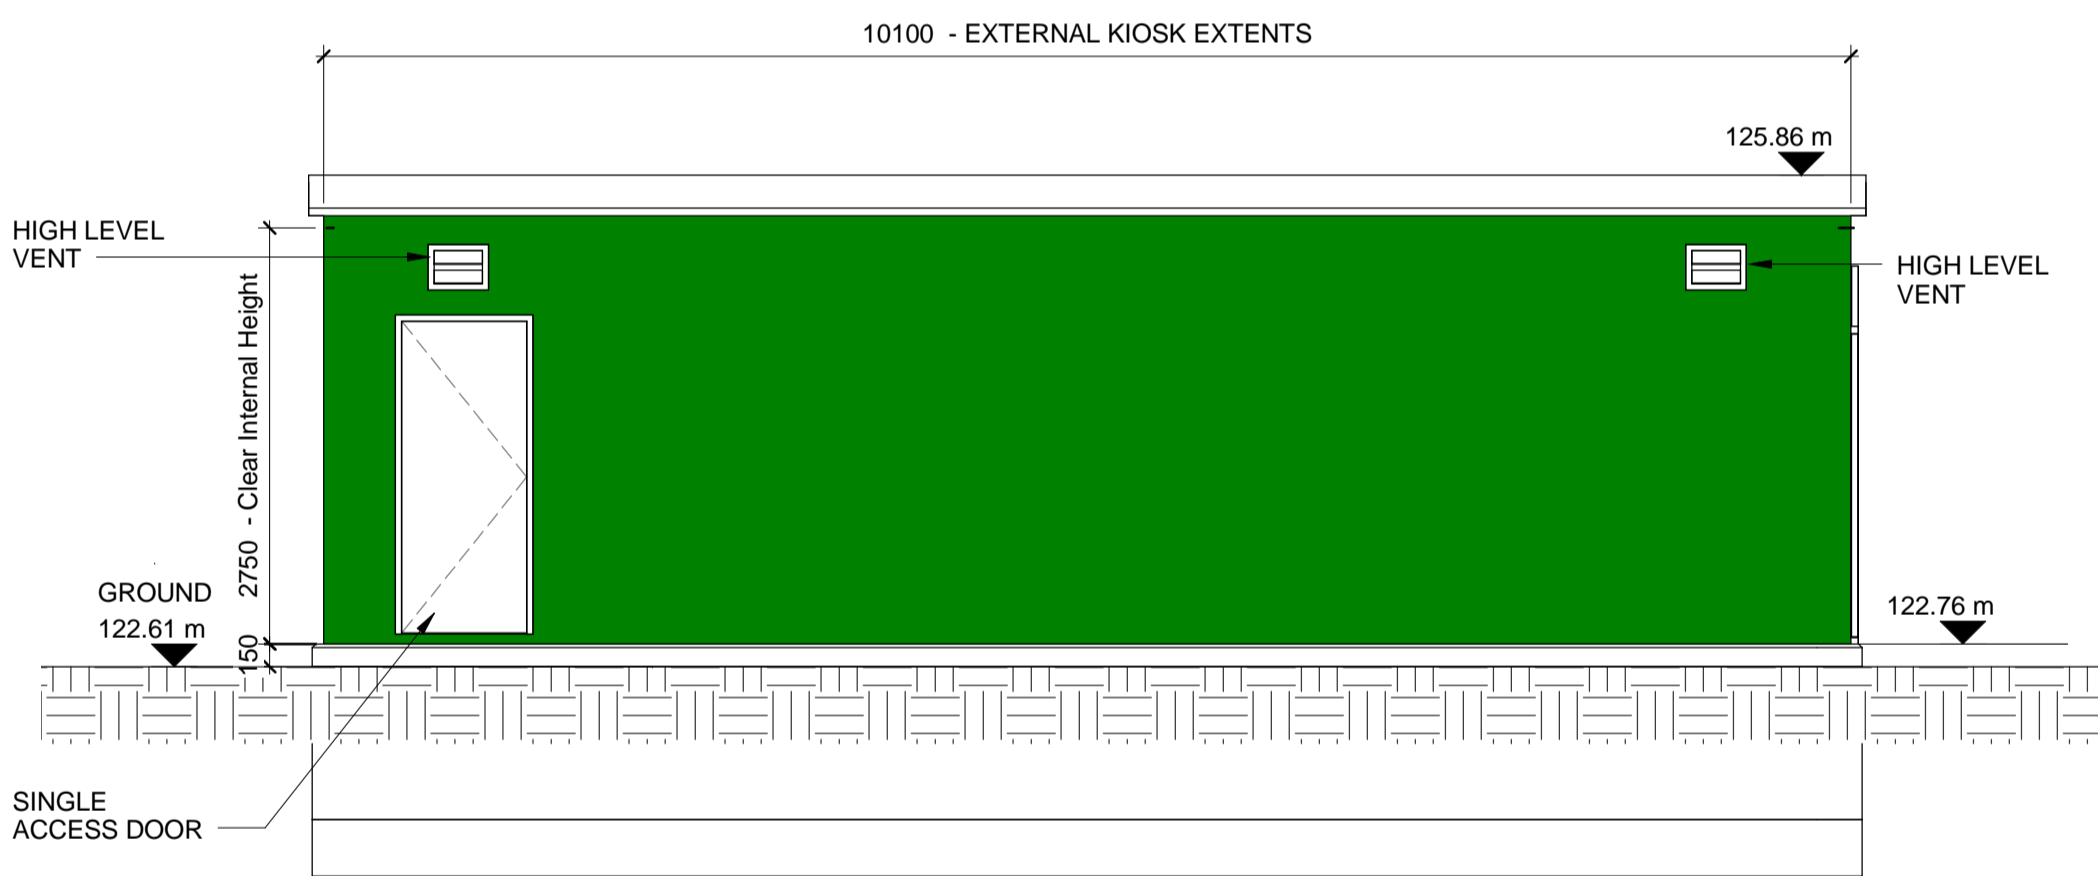

2 ELEVATION 'A'
1 : 50

4 ELEVATION 'C'
1 : 50

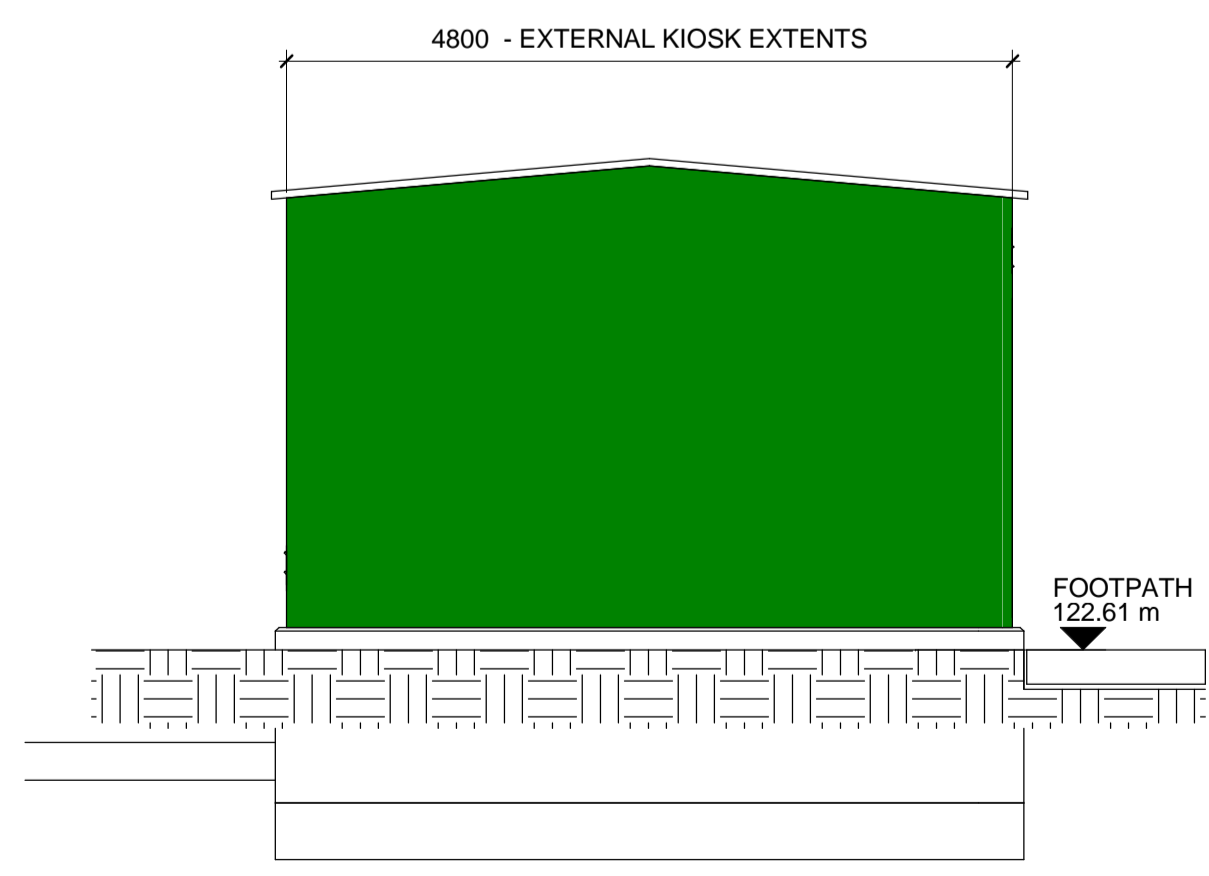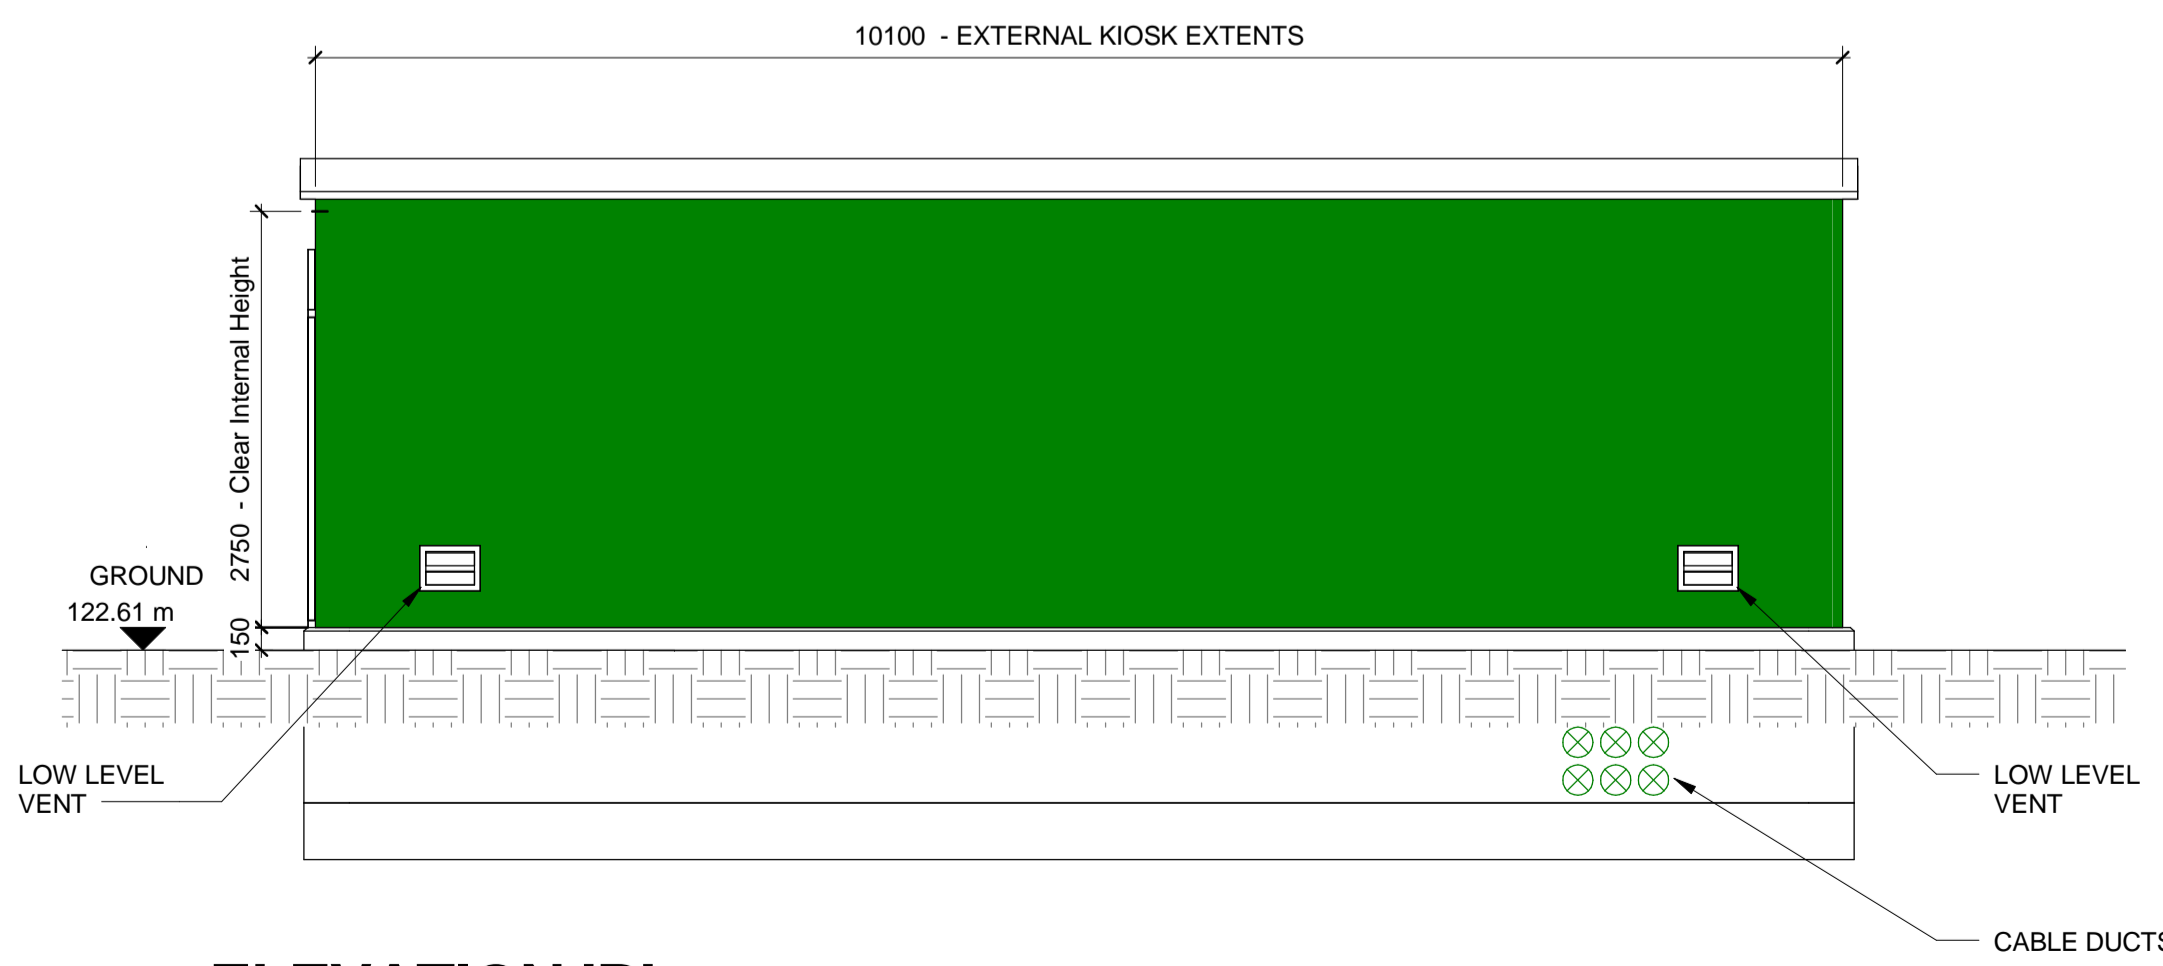

3 ELEVATION 'B'
1 : 50

5 ELEVATION 'D'
1 : 50

A	10-01-2017	APPROVED ISSUE	CI	PA	EH	SJ
1	09-01-2017	PRELIMINARY ISSUE				
REV.	DATE	REVISION DETAILS	DSN	DRN	CHD	APPD

CUSTOMER YORKSHIRE WATER SERVICES LTD

CUSTOMER REFERENCE R1120

PROJECT TANKERSLEY STW

DRAWING TITLE MCC KIOSK PLANNING APPLICATION

PRODUCED BY
AGT
 AECOM & Gallford Try joint venture
 Livingstone House
 Chadwick Street, Leeds,
 West Yorkshire LS10 1LJ
 +44(0)844 8481091 tel
 +44(0)844 2122459 fax
 www.aecom.com

SCALE	DOCUMENT NUMBER	REV
1:50	N6009-AGT-2015-DW	A