


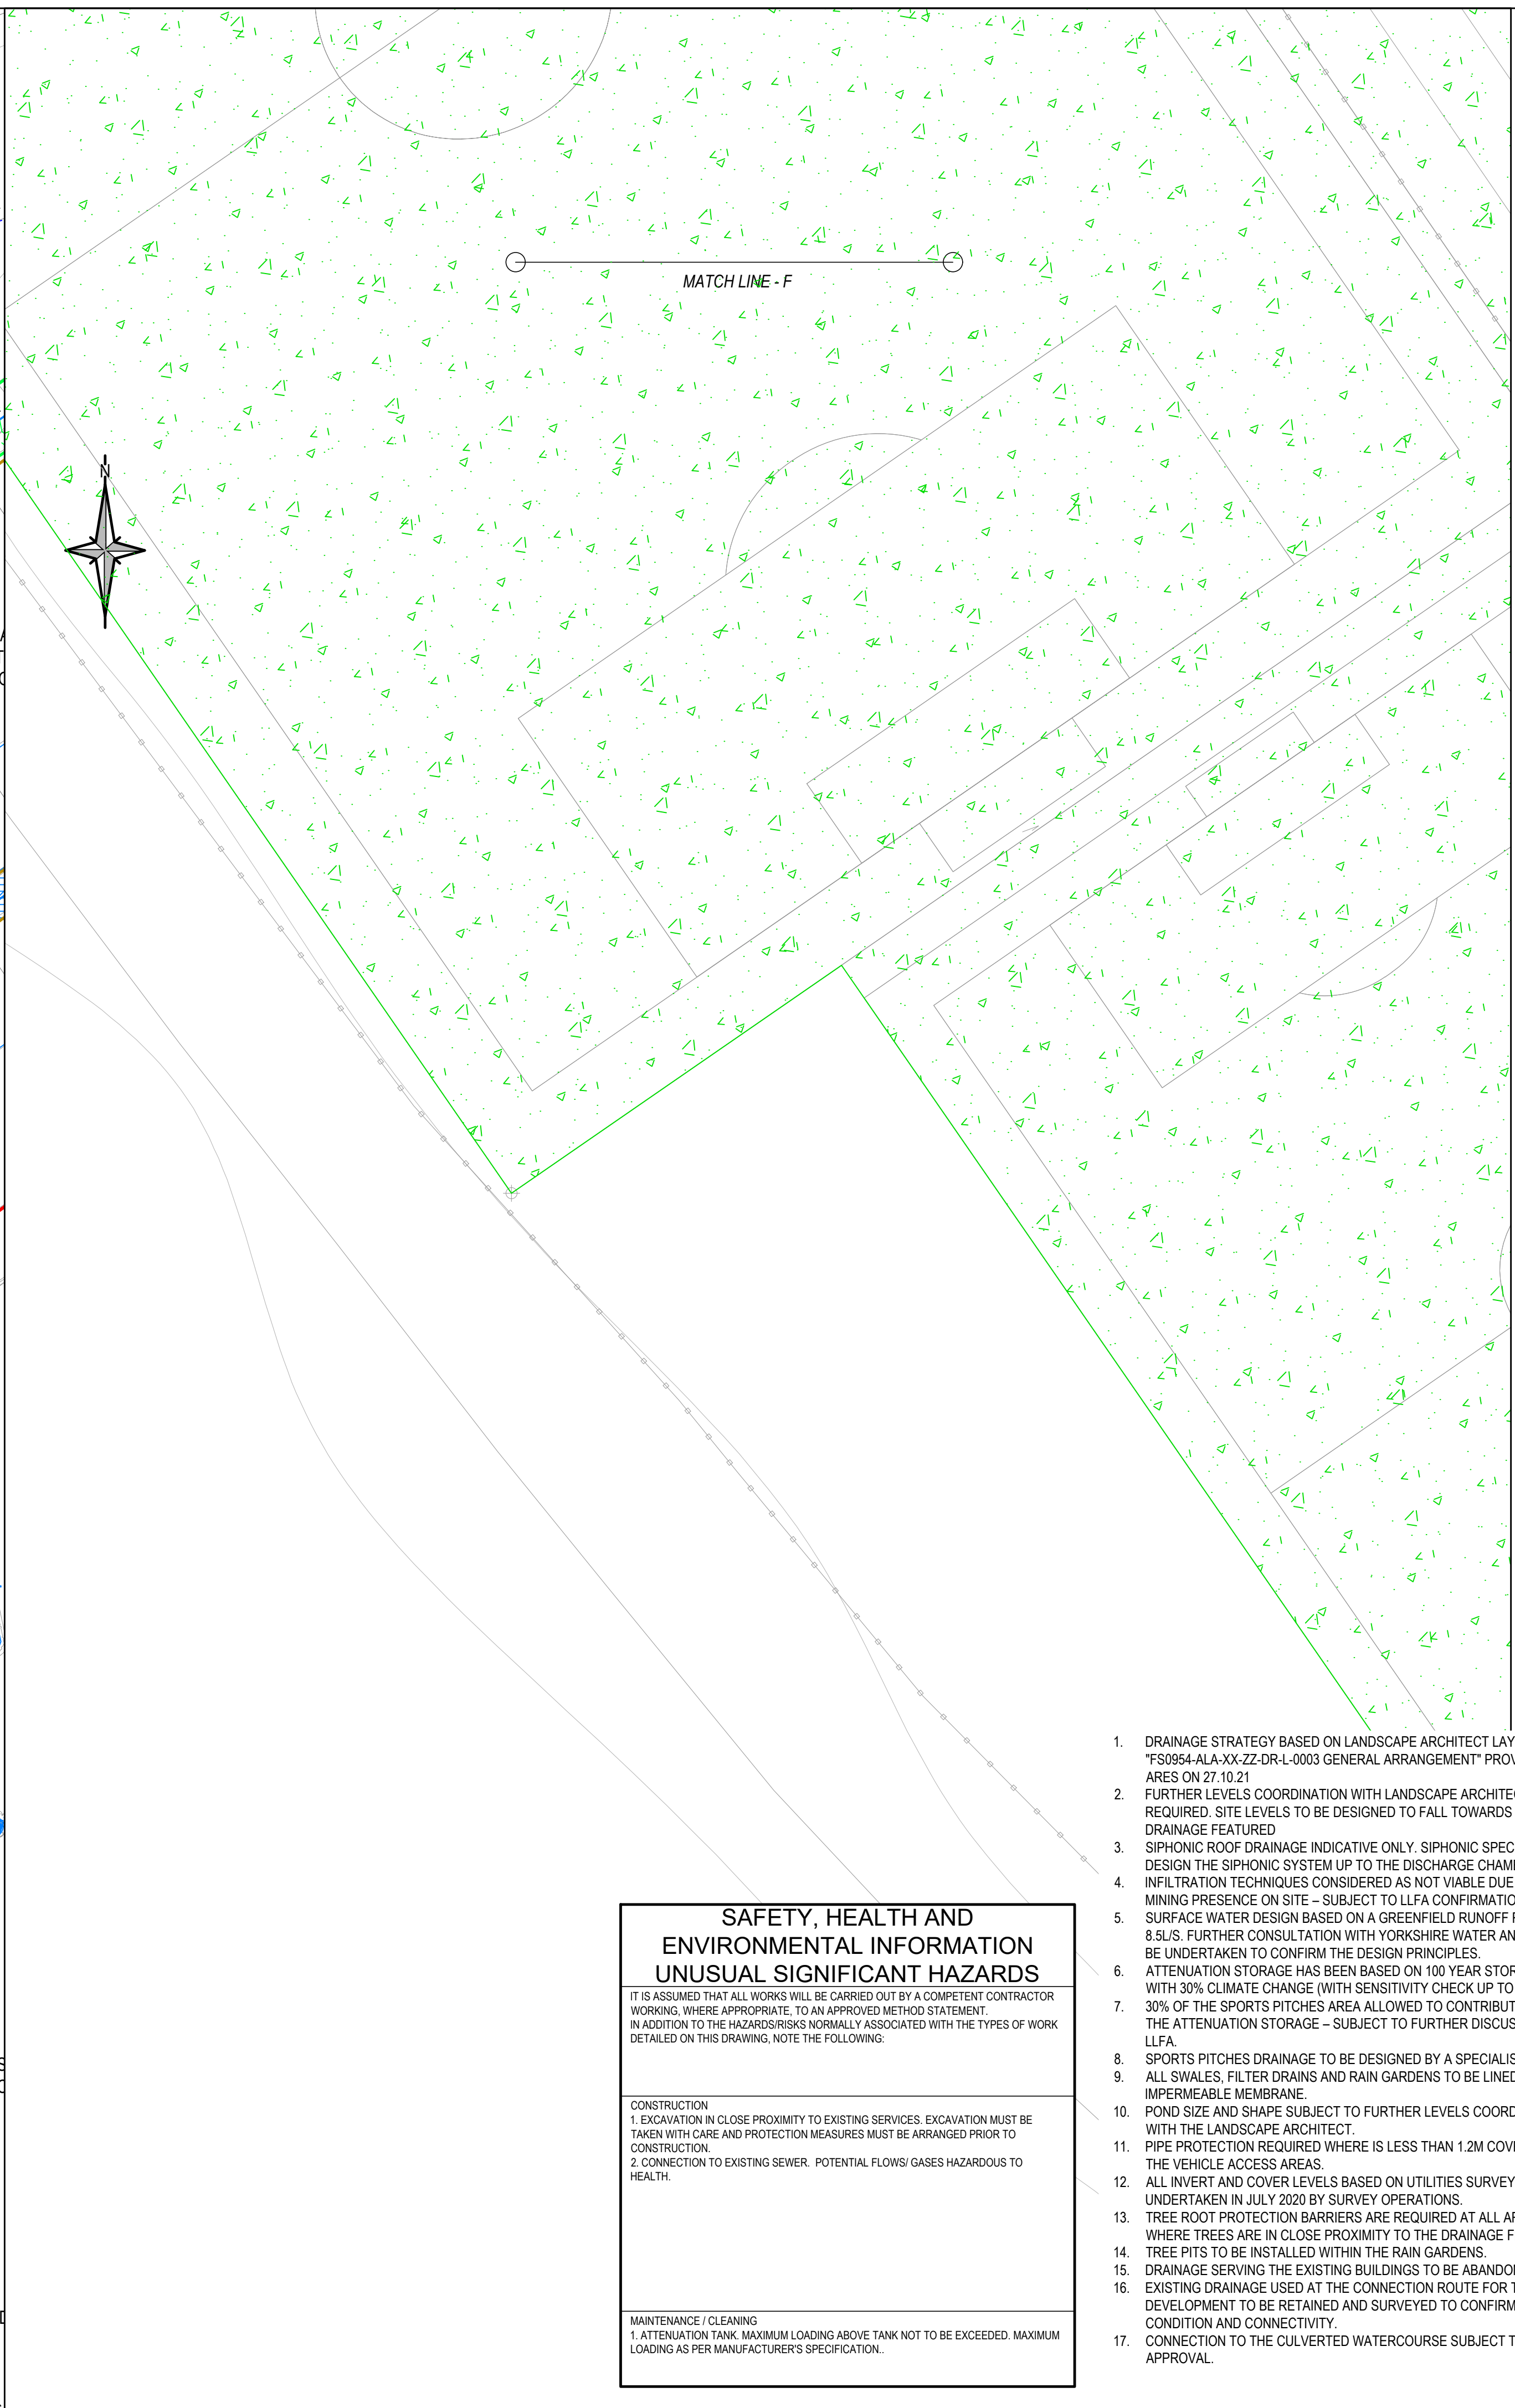

IT IS ASSUMED THAT ALL WORKS WILL BE CARRIED OUT BY A COMPETENT CONTRACTOR WORKING, WHERE APPROPRIATE, TO AN APPROVED METHOD STATEMENT.
IN ADDITION TO THE HAZARDS/RISKS NORMALLY ASSOCIATED WITH THE TYPES OF WORK DETAILED ON THIS DRAWING, NOTE THE FOLLOWING:

CONSTRUCTION

1. EXCAVATION IN CLOSE PROXIMITY TO EXISTING SERVICES. EXCAVATION MUST BE TAKEN WITH CARE AND PROTECTION MEASURES MUST BE ARRANGED PRIOR TO CONSTRUCTION.

2. CONNECTION TO EXISTING SEWER. POTENTIAL FLOW/GASES HAZARDOUS TO HEALTH.

MAINTENANCE / CLEANING

1. ATTENUATION TANK. MAXIMUM LOADING ABOVE TANK NOT TO BE EXCEEDED. MAXIMUM LOADING AS PER MANUFACTURER'S SPECIFICATION.

- ## GENERAL NOTES:
1. THIS DRAWING IS TO BE READ IN CONJUNCTION WITH ALL RELEVANT ARCHITECTS AND ENGINEERS DRAWINGS AND SPECIFICATIONS.
 2. DO NOT SCALE THIS DRAWING. ANY AMBIGUITIES, OMISSIONS AND ERRORS ON DRAWINGS SHALL BE BROUGHT TO THE ENGINEERS ATTENTION IMMEDIATELY. ALL DIMENSIONS MUST BE CHECKED / VERIFIED ON SITE.
 3. ALL DIMENSIONS ARE IN METRES UNLESS NOTED OTHERWISE.
 4. FOR GENERAL NOTES REFER TO CURTINS DRAWING "FS0954-CUR-ZZ-XX-DR-C-9000_GENERAL_INFRASTRUCTURE NOTES"

FS0954-CUR-ZZ-ZZ-DR-C-9000-GENERAL INFRASTRUCTURE NOTES
FS0954-CUR-ZZ-ZZ-DR-C-9200-FOUL WATER DRAINAGE LAYOUT
FS0954-CUR-ZZ-ZZ-DR-C-9201-SURFACE WATER DRAINAGE LAYOUT SHEET 1 OF 5
FS0954-CUR-ZZ-ZZ-DR-C-9202-SURFACE WATER DRAINAGE LAYOUT SHEET 2 OF 5
FS0954-CUR-ZZ-ZZ-DR-C-9203-SURFACE WATER DRAINAGE LAYOUT SHEET 3 OF 5
FS0954-CUR-ZZ-ZZ-DR-C-9204-SURFACE WATER DRAINAGE LAYOUT SHEET 4 OF 5
FS0954-CUR-ZZ-ZZ-DR-C-9206-SURFACE WATER DRAINAGE LAYOUT KEY PLAN
FS0954-CUR-ZZ-ZZ-DR-C-9207-DRAINAGE CONSTRUCTION DETAILS SHEET 1 OF 2
FS0954-CUR-ZZ-ZZ-DR-C-9208-DRAINAGE CONSTRUCTION DETAILS SHEET 2 OF 2

	PROPOSED SURFACE WATER DRAIN
	PROPOSED SIPHONIC PIPE
	FILTER DRAIN WITH PERFORATED PIPE
	RAIN GARDEN
	GATIC SLOT DRAIN
	MONODRAIN WITH INTERNAL SLOPE
	PROPOSED RODDING POINT
	PROPOSED SURFACE WATER GULLY
	ACO SWALE INLET
	CHECK DAMS
	DRAINAGE WEIR/HOLLOW KERB
	PROPOSED SURFACE WATER TANK
	PROPOSED SuDS MUGA / SPORTS PITCH
	PROPOSED CONVEYANCE SWALE
	ATTENUATION POND
	GRASSED SPORTS PITCH - DRAINAGE SUBJECT TO A SPECIALIST DESIGN
	EX. PRIVATE SURFACE WATER SEWER TO BE RETAINED

P04	PLANNING ISSUE	26.11.21	JW	AS
P03	UPDATED TO SUIT LATEST SITE LAYOUT AND CONTRACTORS COMMENTS	27.10.21	AS	AS
P02	DRAFT CP ISSUE	15.10.21	JW	AS
P01	ISSUED FOR COSTING	13.10.21	JW	AS
Rev:	Description:	Date:	By:	Chkd:



Project:

TRINITY ACADEMY, BARNESLEY

Project No:	Size:	Date:	Drawn By:	Designed By:	Checked By:		
079532	A1	13.10.21	JW	JW	AS		
	Scale: 1:200						
Project Code:	Originator:	Volume:	Level:	Type:	Role:	Category / Number:	Rev:

FS0954 - CUR - ZZ - ZZ - DR - C - 9205 - P04