


LOCATION PLAN


SCALE 1:2500

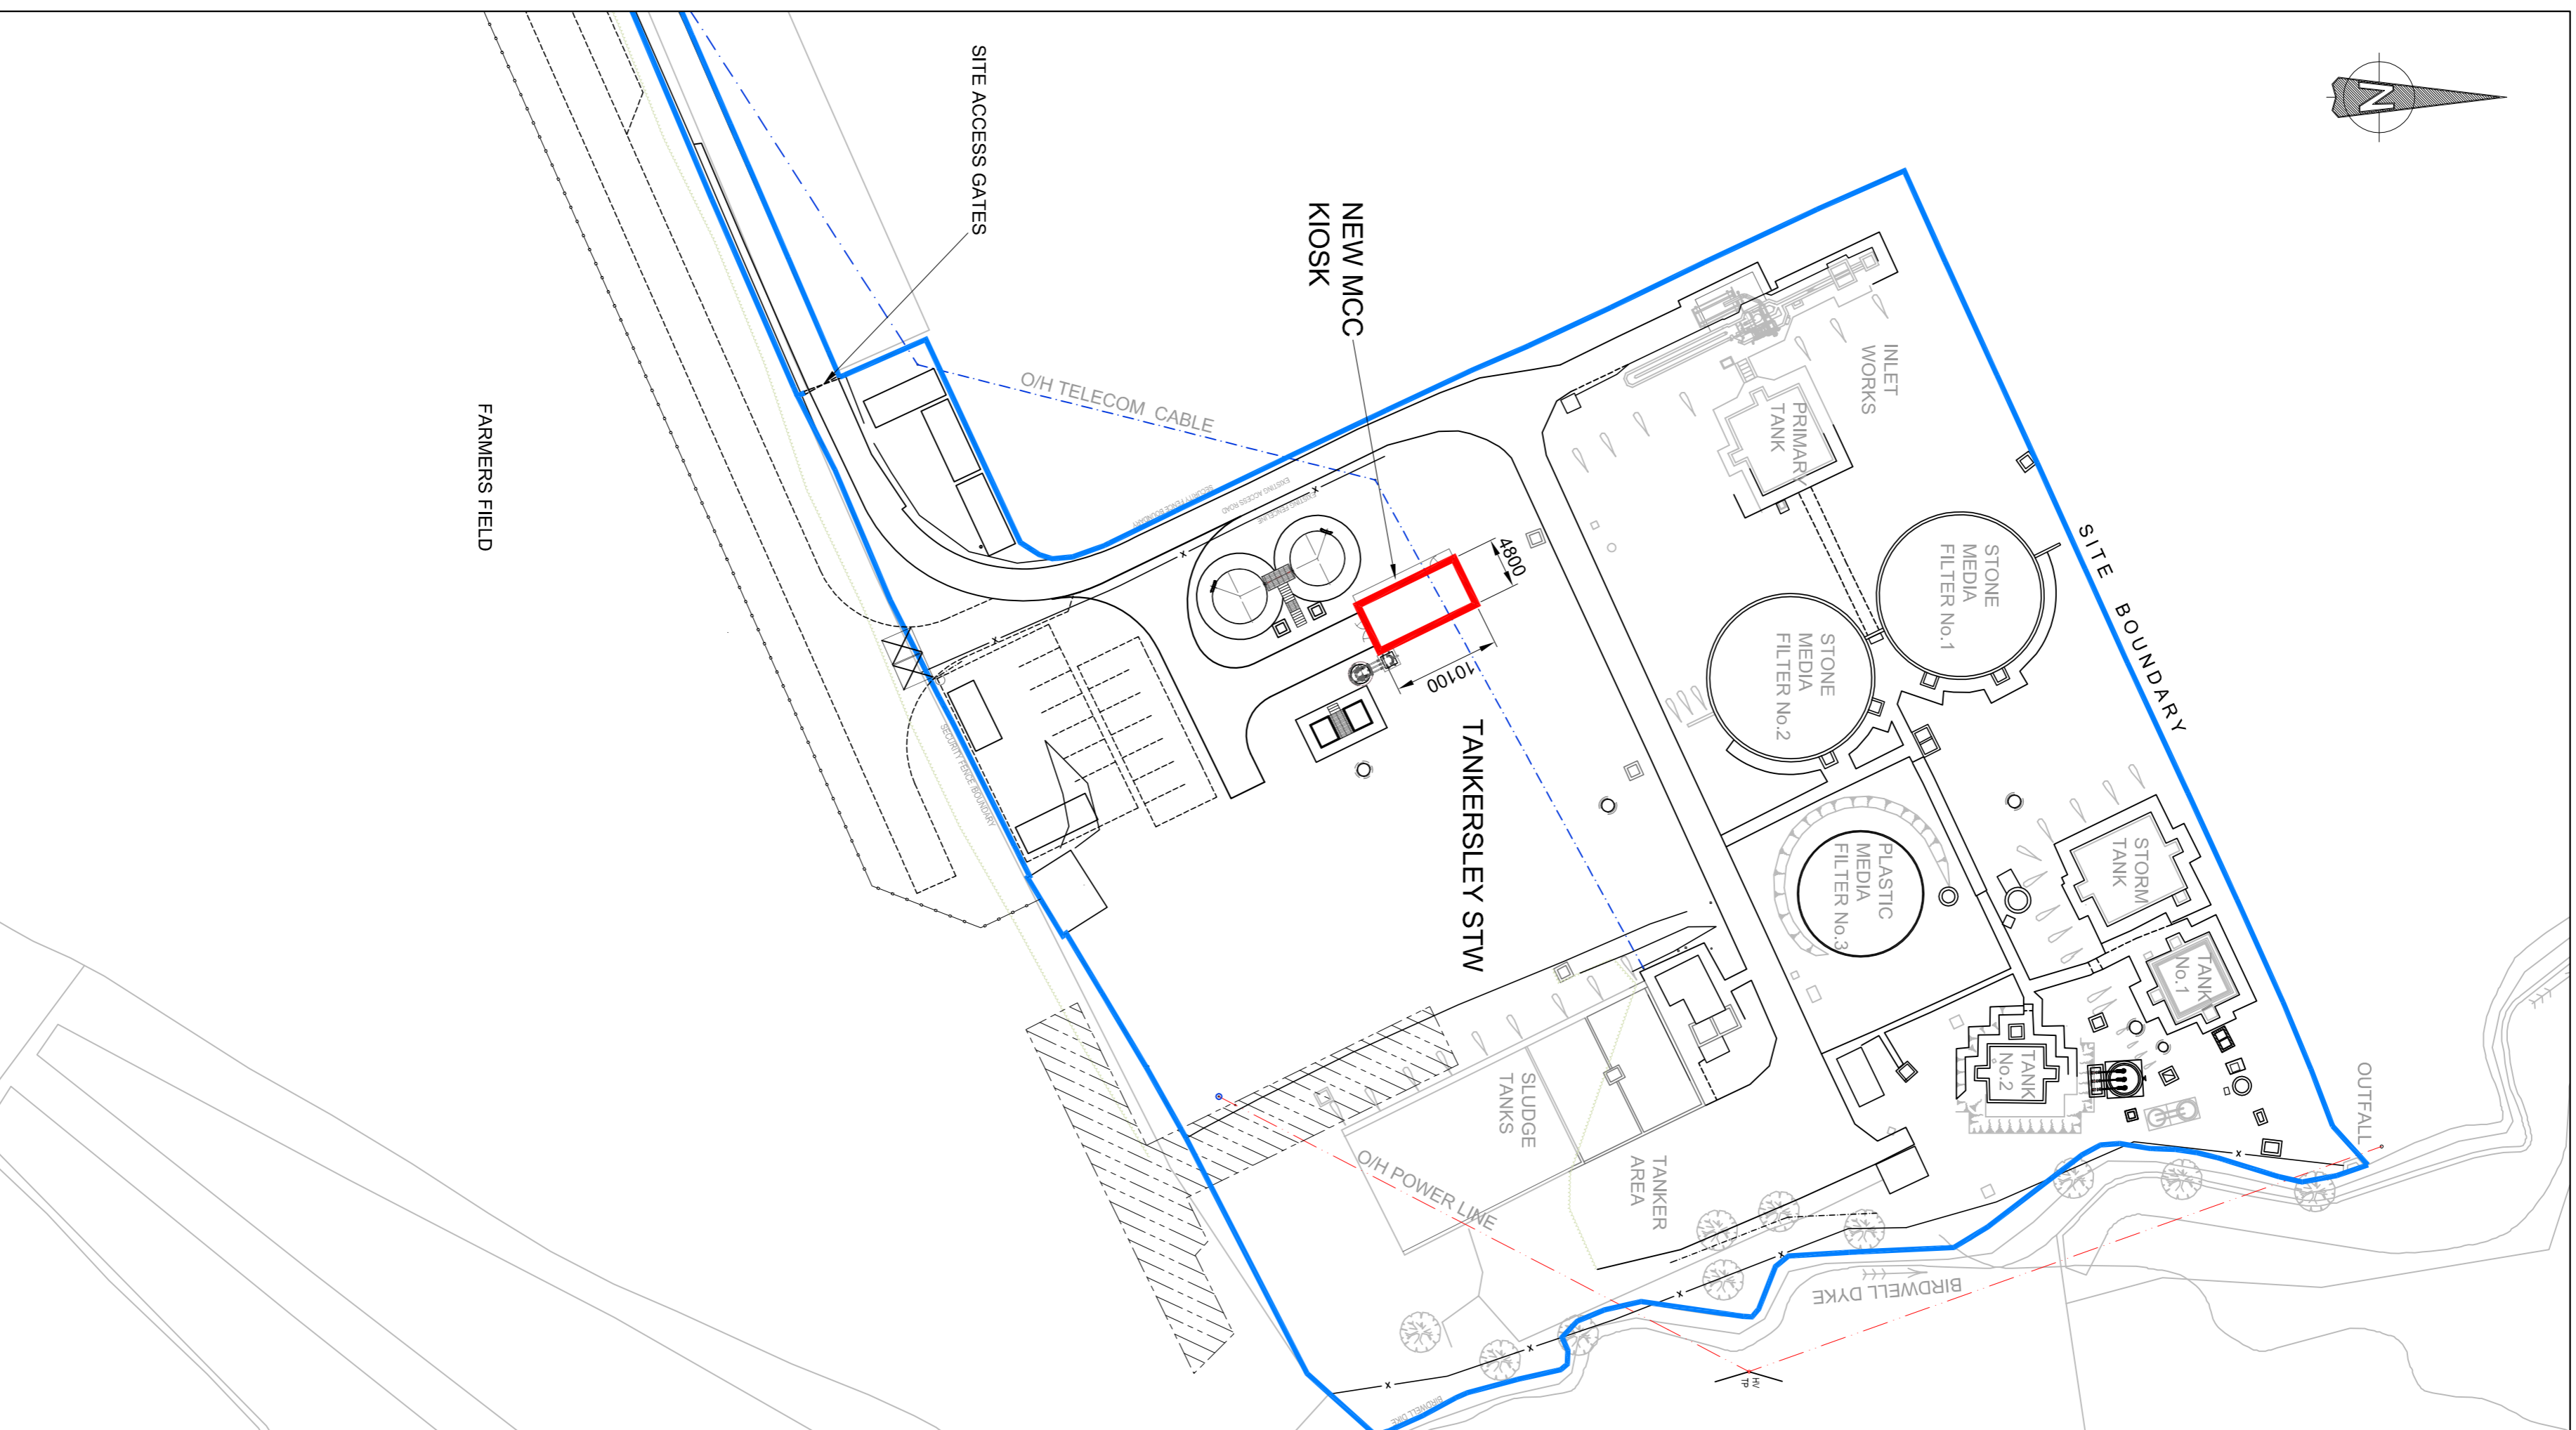

SITE PLAN

SCALE 1:500

THE COPYRIGHT IN THIS DRAWING IS THE PROPERTY OF AGT AND THE DRAWING MAY NOT BE REPRODUCED OR COPIED IN ANY FORM, WHETHER BY PHOTOGRAPHY OR ANY OTHER MEANS, WITHOUT THE WRITTEN PERMISSION OF AGT

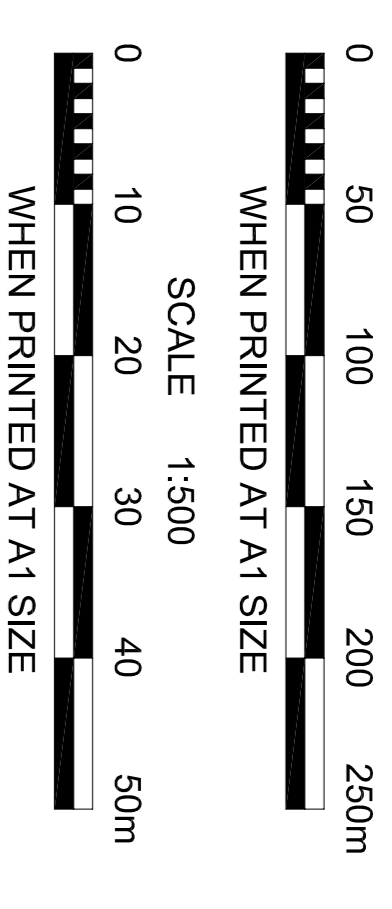

Notes

1. THIS DRAWING TO BE READ IN CONJUNCTION WITH DRAWING: N6009-AGT-2015-DW MCC KIOSK PLANNING APPLICATION
2. ALL LEVELS ARE IN METRES ABOVE ORDNANCE DATUM.
3. ALL DIMENSIONS ARE IN MILLIMETRES UNLESS STATED OTHERWISE.
4. GRP KIOSK COLOUR BS4800 14C39 HOLLY GREEN.

Key

- YORKSHIRE WATER SITE BOUNDARY
- NEW MCC KIOSK LOCATION

REV	DATE	REVISION DETAILS	DSN	DRN	CHD	APPD
A	1/00/2017	APPROVED ISSUE	CI	PA8	EH	SJ
1	09/01/2017	PRELIMINARY UNCHECKED	RAB	PA8		

CUSTOMER YORKSHIRE WATER SERVICES LTD

CUSTOMER REFERENCE R1120

PROJECT TANKERSLEY STW

DRAWING TITLE
MCC KIOSK
PLANNING APPLICATION
SITE PLAN & LOCATION PLAN

PRODUCED BY
AGT
LEADS
WEST YORKSHIRE, S10 1U
TEL: (+44) 0844 8481091
FAX: (+44) 0113 212459

SCALE AS SHOWN DOCUMENT NUMBER N6009-AGT-2017-DW REV A