

- NOTES:**
- THESE NOTES ARE INTENDED TO AUGMENT DRAWINGS AND SPECIFICATIONS. WHERE CONFLICT OF REQUIREMENTS EXIST THE ORDER OF PRECEDENCE SHALL BE AS SHOWN IN THE SPECIFICATION. OTHERWISE THE STRICTEST PROVISION SHALL GOVERN.
  - THIS DRAWING IS TO BE READ IN CONJUNCTION WITH ALL OTHER RELEVANT ENGINEERS AND ARCHITECTS DRAWINGS.
  - DRAWINGS NOT TO BE SCALED. ALL DIMENSIONS TO BE CHECKED ON SITE BY THE CONTRACTOR. ANY DISCREPANCIES TO BE NOTIFIED TO THE ENGINEER AND FURTHER INSTRUCTIONS OBTAINED BEFORE WORK IS COMMENCED.
  - LEVELS AT THE TIME OF AN EXISTING ROAD CONSTRUCTION TO BE CONFIRMED. ANY DISCREPANCIES TO BE NOTIFIED TO THE ENGINEER.
  - ALL WORKS TO BE IN ACCORDANCE WITH THE LOCAL HIGHWAY AUTHORITY'S CONSTRUCTION GUIDE.
  - THE WORKS WILL BE ADAPTED BY THE HIGHWAY AUTHORITY. THE DEVELOPER AND/OR PRINCIPAL CONTRACTOR MUST THEREFORE ENSURE THAT THE WORKS COMPLY BOTH WITH THE SPECIFICATION AND THE DRAWINGS WHICH ARE SUBJECT TO INSPECTION AND APPROVAL BY THE RELEVANT AUTHORITY.
  - WHERE REQUIRED BY THE LOCAL HIGHWAY AUTHORITY, THE CONTRACTOR SHALL NOTIFY THE APPROPRIATE AUTHORITY PRIOR TO COMMENCEMENT OF EACH STAGE OF THE WORK FOR THEIR REPRESENTATIVE TO CARRY OUT INSPECTION TO ENSURE COMPLIANCE WITH THEIR SPECIFICATION AND APPROVED DETAILS. IF ANY SUCH REQUESTS OR INSTRUCTIONS CONFLICT WITH THE SPECIFICATION THE CONTRACTOR SHALL IMMEDIATELY NOTIFY THE ENGINEER.
  - ALL MATERIAL WITHIN 450mm OF THE FINISHED CARRIAGEWAY SURFACE SHALL BE NON-FROST SUSCEPTIBLE AS REQUIRED BY S.I.W. SERIES 800 CLAUSE 801.
  - GENERALLY ALL WORKS TO BE UNDERTAKEN IN ACCORDANCE WITH THE MANUAL OF CONTRACT DOCUMENTS FOR HIGHWAY WORKS - VOLUME 1 - SPECIFICATION FOR HIGHWAY WORKS (S.H.W).
  - CLAUSES SHOWN ON THE DRAWING REFER TO CLAUSES IN THE UK GOVERNMENT'S MANUAL OF CONTRACT DOCUMENTS FOR HIGHWAY WORKS, VOLUME 1 SPECIFICATION OF HIGHWAY WORKS.
  - THE CONTRACTOR IS RESPONSIBLE FOR ACQUIRING UP TO DATE SERVICE INFORMATION AND SHALL TAKE ALL NECESSARY MEASURES TO IDENTIFY AND LOCATE EXISTING UNDERGROUND SERVICES INCLUDING ANY PRIVATE SUPPLIES, AND IMPLEMENT APPROPRIATE CONTROL MEASURES BEFORE UNDERTAKING ANY EXCAVATIONS.
  - SAFE DIGGING PRACTICES MUST BE USED WHEN ESTABLISHING THE ACTUAL POSITION OF MAINS PIPES, SERVICES AND OTHER APPARATUS ON SITE BEFORE ANY MECHANICAL PLANT IS USED.
  - CBRS TO BE TAKEN ON ROAD FORMATION, AT 20m INTERVALS USING 600mm DIAMETER PLATE. RESULTS OF TESTS TO BE PRESENTED TO BMBC ENGINEER TO REVIEW.
  - ANY TREES WITHIN 3.66m OF THE PROSPECTIVELY ADAPTABLE HIGHWAY WILL REQUIRE A ROOT BARRIER - SEE CONSTRUCTION ENGINEER TO REVIEW.
  - CCTV OF HIGHWAY DRAINAGE TO BE PROVIDED TO BMBC FOR REVIEW PRIOR TO A PART 1 CERTIFICATE AND PRIOR TO FINAL SURFACING.

THIS INFORMATION ON THIS DRAWING IS FOR APPROVAL PURPOSES ONLY. NO CONSTRUCTION WORKS ARE TO BE UNDERTAKEN UNTIL WRITTEN APPROVAL IS RECEIVED FROM LOCAL HIGHWAYS AUTHORITY.

THIS DRAWING IS TO BE READ IN CONJUNCTION WITH THE FOLLOWING DRAWING REFERENCE 25027;

**SECTION 278**

3400 - SECTION 278 - LEGAL BOUNDARY
3401 - SECTION 278 - PROPOSED GENERAL ARRANGEMENT
3402 - SECTION 278 - PROPOSED CONTOURS AND SECTIONS
3403 - SECTION 278 - PROPOSED DRAINAGE
3404 - SECTION 278 - VISIBILITY SPLAYS
3405 - SECTION 278 - HIGHWAY CONSTRUCTION DETAILS
3406 - SECTION 278 - VEHICLE TRACKING
3407 - SECTION 278 - PROPOSED TRAFFIC SIGNS AND ROAD MARKINGS

**SAFETY, HEALTH AND ENVIRONMENTAL INFORMATION**

IN ADDITION TO THE HAZARDS/RISKS NORMALLY ASSOCIATED WITH THE TYPES OF WORK SET OUT IN THIS DRAWING, NOTE THE FOLLOWING SIGNIFICANT RESIDUAL RISKS

Rev	Description	By	Date	Chk'd	Auth
S4	FOR APPROVAL		10.04.26	CK	
S4	FOR APPROVAL		14.08.25	CK	
S4	FOR APPROVAL		25.07.25	RSL	
Start	Purpose of Issue				

P03	UPDATED FOLLOWING COMMENTS	WD	10.04.26	CK	CK
P02	UPDATED NOTES	TH	14.08.25	CK	CK
P01	FIRST ISSUE	WD	25.07.25	CK	RSL

**LYNAS ENGINEERS**


Lynas Engineers  
Cargo Fleet Offices  
Middlesbrough Road  
Middlesbrough  
TS6 6XH  
Tel: +44 (0)1642 720280  
www.lynasesengineers.com  
Copyright © Lynas Engineers Limited (2020)

**AVANT homes**

**GREAT HOUGHTON BARNLSLEY**

**SECTION 278 - HIGHWAY CONSTRUCTION DETAILS**

Sheet	Original Scale	Design/Drawn	Checked	Authorised
A0	AS SHOWN	OK	CK	RSL
Status	Drawing Number	Date	Date	Date
S4	25027-LE-ZZ-ZZ-DR-D-3505	25.07.25	25.07.25	25.07.25
Rev				
S4				P03

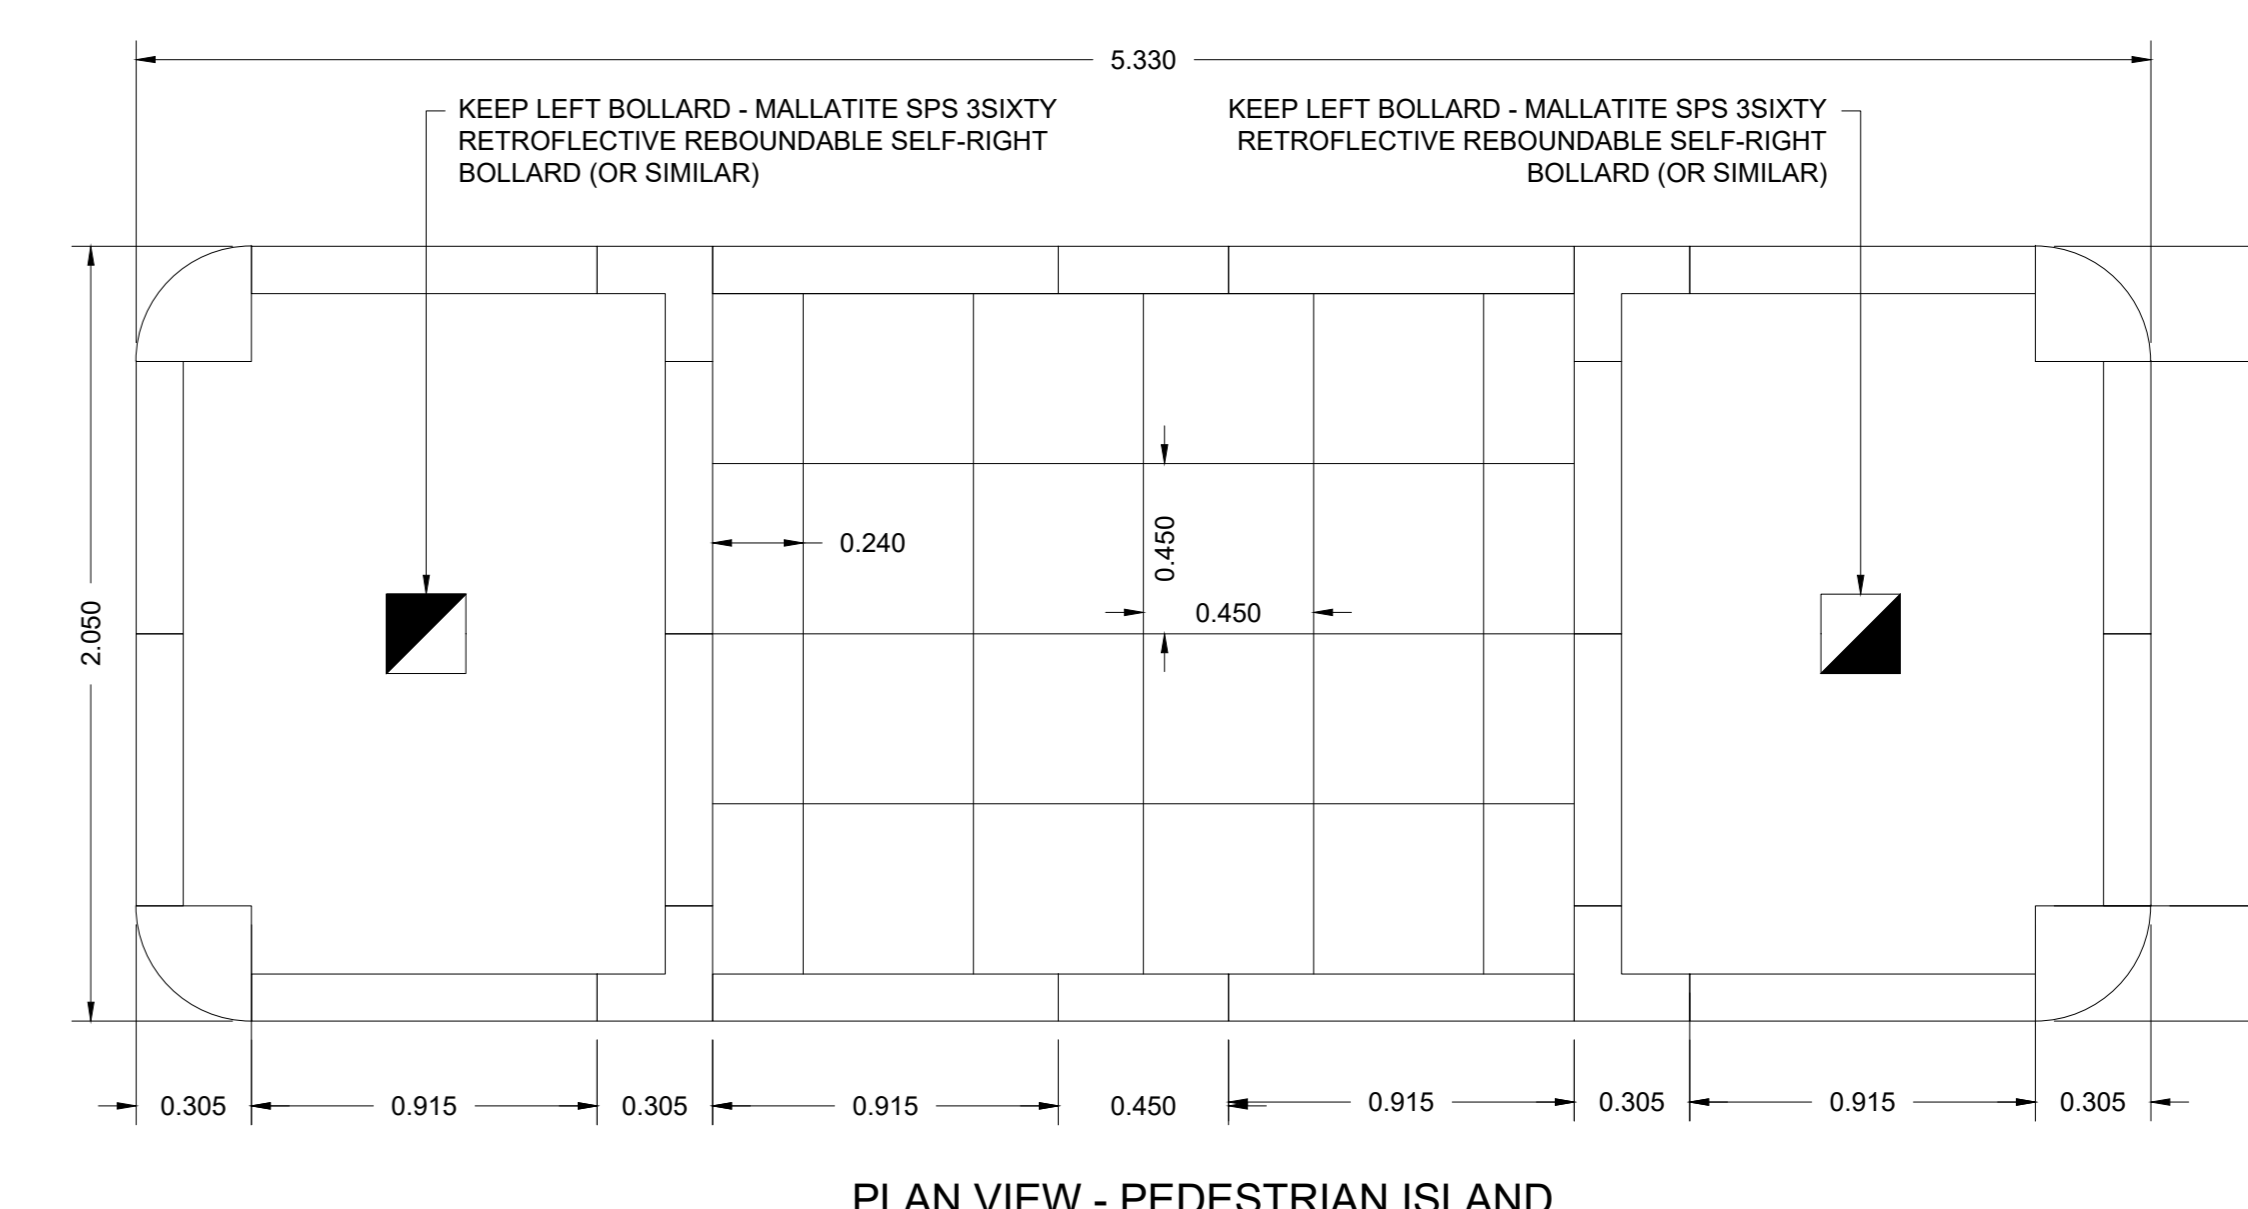

**A0 DO NOT SCALE**