


LONDON  
LEEDS  
CARDIFF  
GLASGOW  
ABERYSTWYTH  
NEWTOWN  
MANCHESTER  
LOUGHBOROUGH

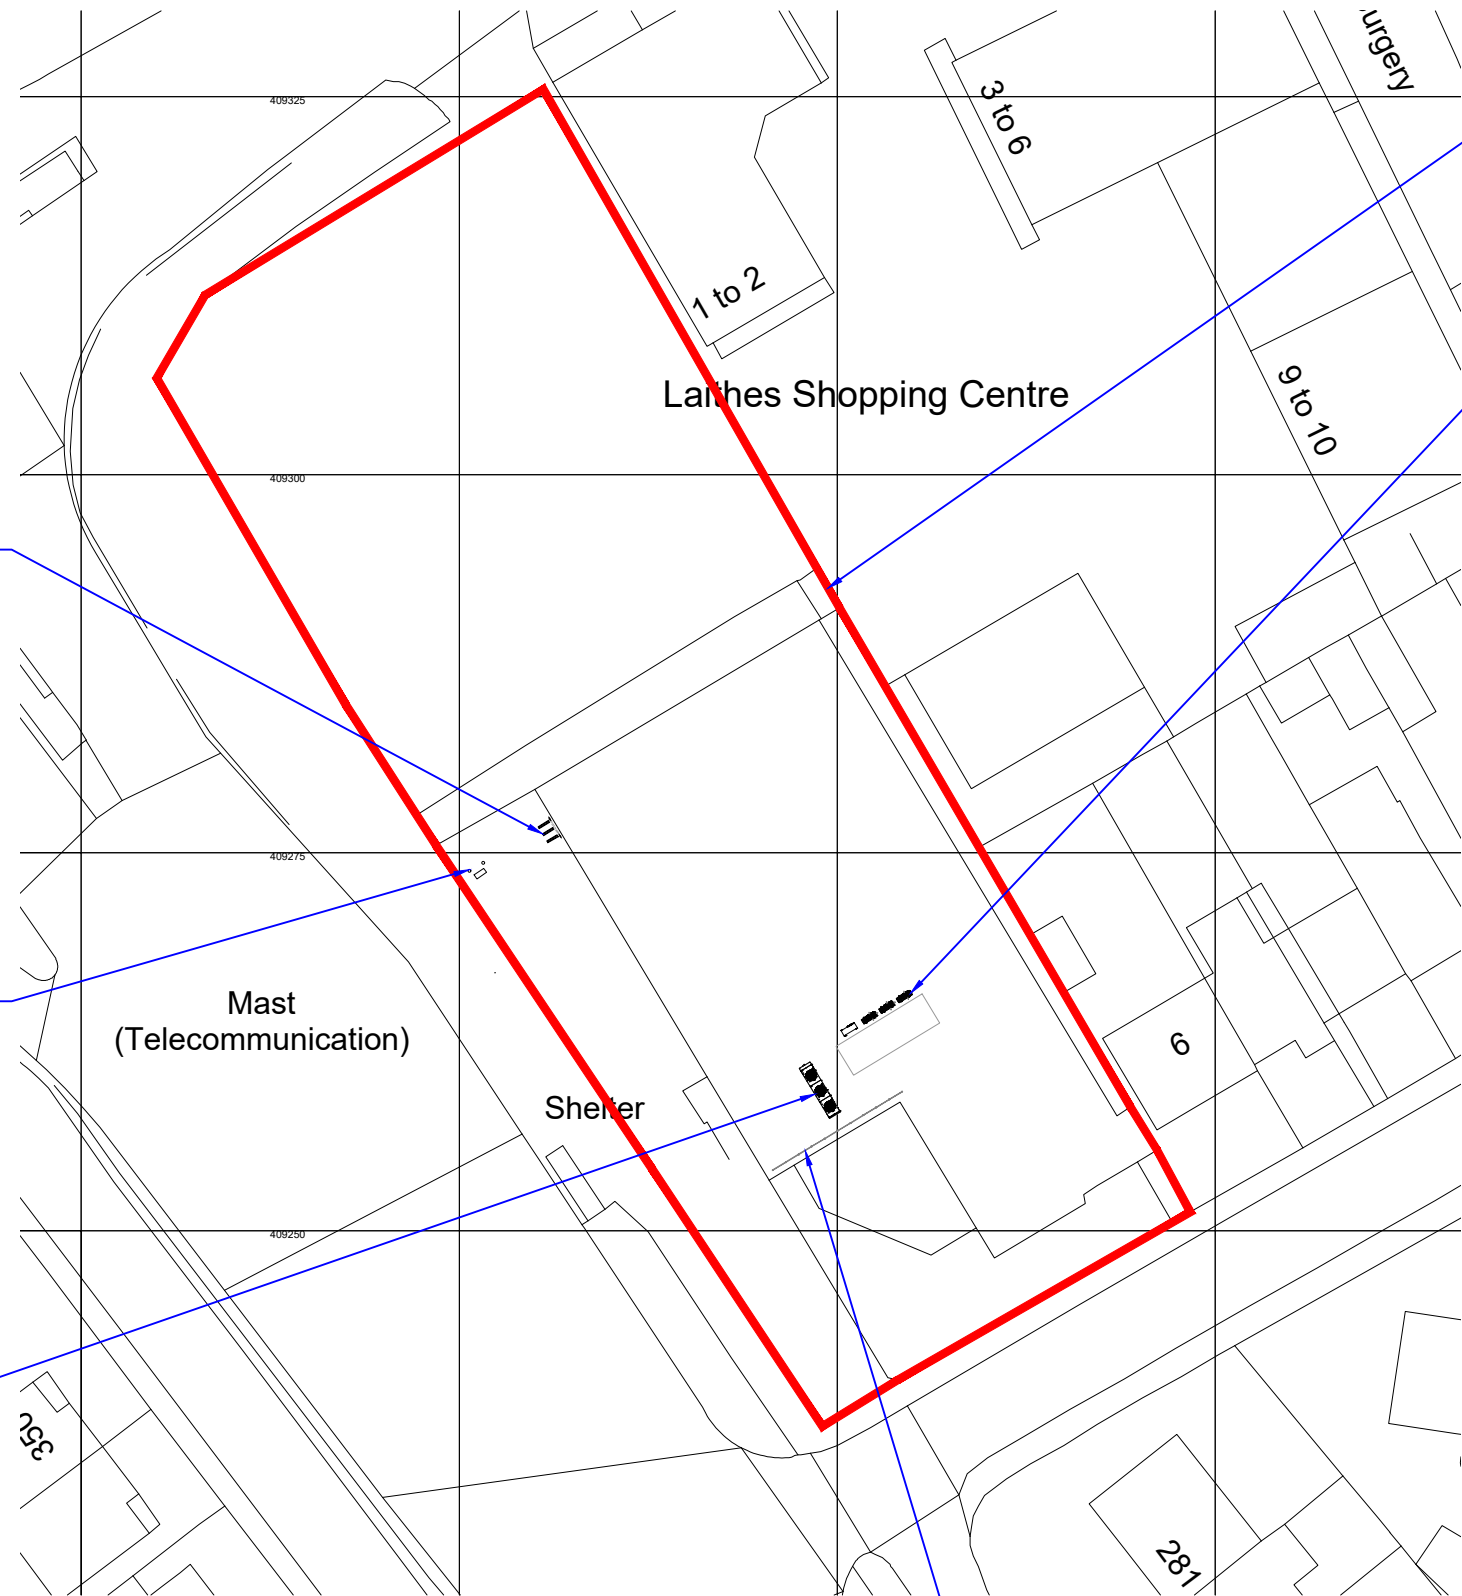

3 no. new stainless steel cycle bays bolted down to ground.

Fit 2 no. new Bollards to protect new Totem (signage application by others)

1 no. new Gas Cooler to be situated in rear yard on level base. See Space Engineering drawing CR3 for plant spec.

Fit security roller bars to top of fencing up to adjacent building line.

3 no. new AC units to be situated on flat roof on level base to replace existing plant. See Space Engineering drawing CR3 for plant spec.

Install new Key klamp edge protection to 1100mm high adjacent to new plant.

1 PROPOSED SITE PLAN  
1:500

REV	DATE	DESCRIPTION	DR	CH

**PLANNING ISSUE**

**darntonB3**  
ARCHITECTURE

LEEDS  
The Coach House, Monk Fryston Hall, Monk Fryston, Leeds, LS25 5DU.  
T: 01977 681 001 www.darntonb3.com

CLIENT  
TCG

PROJECT  
Co operative Group  
New Lodge

DRAWING  
Proposed Site Plan

SCALE @ A3	DRAWN	CHECKED
1:500	sn	-

CREATION DATE	REVISION
06.12.19	-

DARNTONB3 DRAWING NO.  
13795 - DB3 - B01 - 00 - DR - A - 90002  
PROJECT NO - COMPANY - ZONE - LEVEL - TYPE - ROLE - NUMBER

© COPYRIGHT: ALL RIGHTS RESERVED.  
THIS DRAWING IS TO BE READ IN CONJUNCTION WITH ALL OTHER RELEVANT DRAWINGS PREPARED BY CONSULTANTS AND SUB-CONTRACTORS.  
THIS DRAWING MUST NOT BE USED FOR CONSTRUCTION UNLESS ISSUED FOR CONSTRUCTION.  
REPORT ANY DISCREPANCIES TO THE ARCHITECT OR REPRESENTATIVES THEREOF.  
DARNTONB3 LTD WORK TO A MANAGEMENT SYSTEM WHICH IS APPROVED TO ISO-9001 BY LQA - CERTIFICATE NUMBER LQA-0947162