


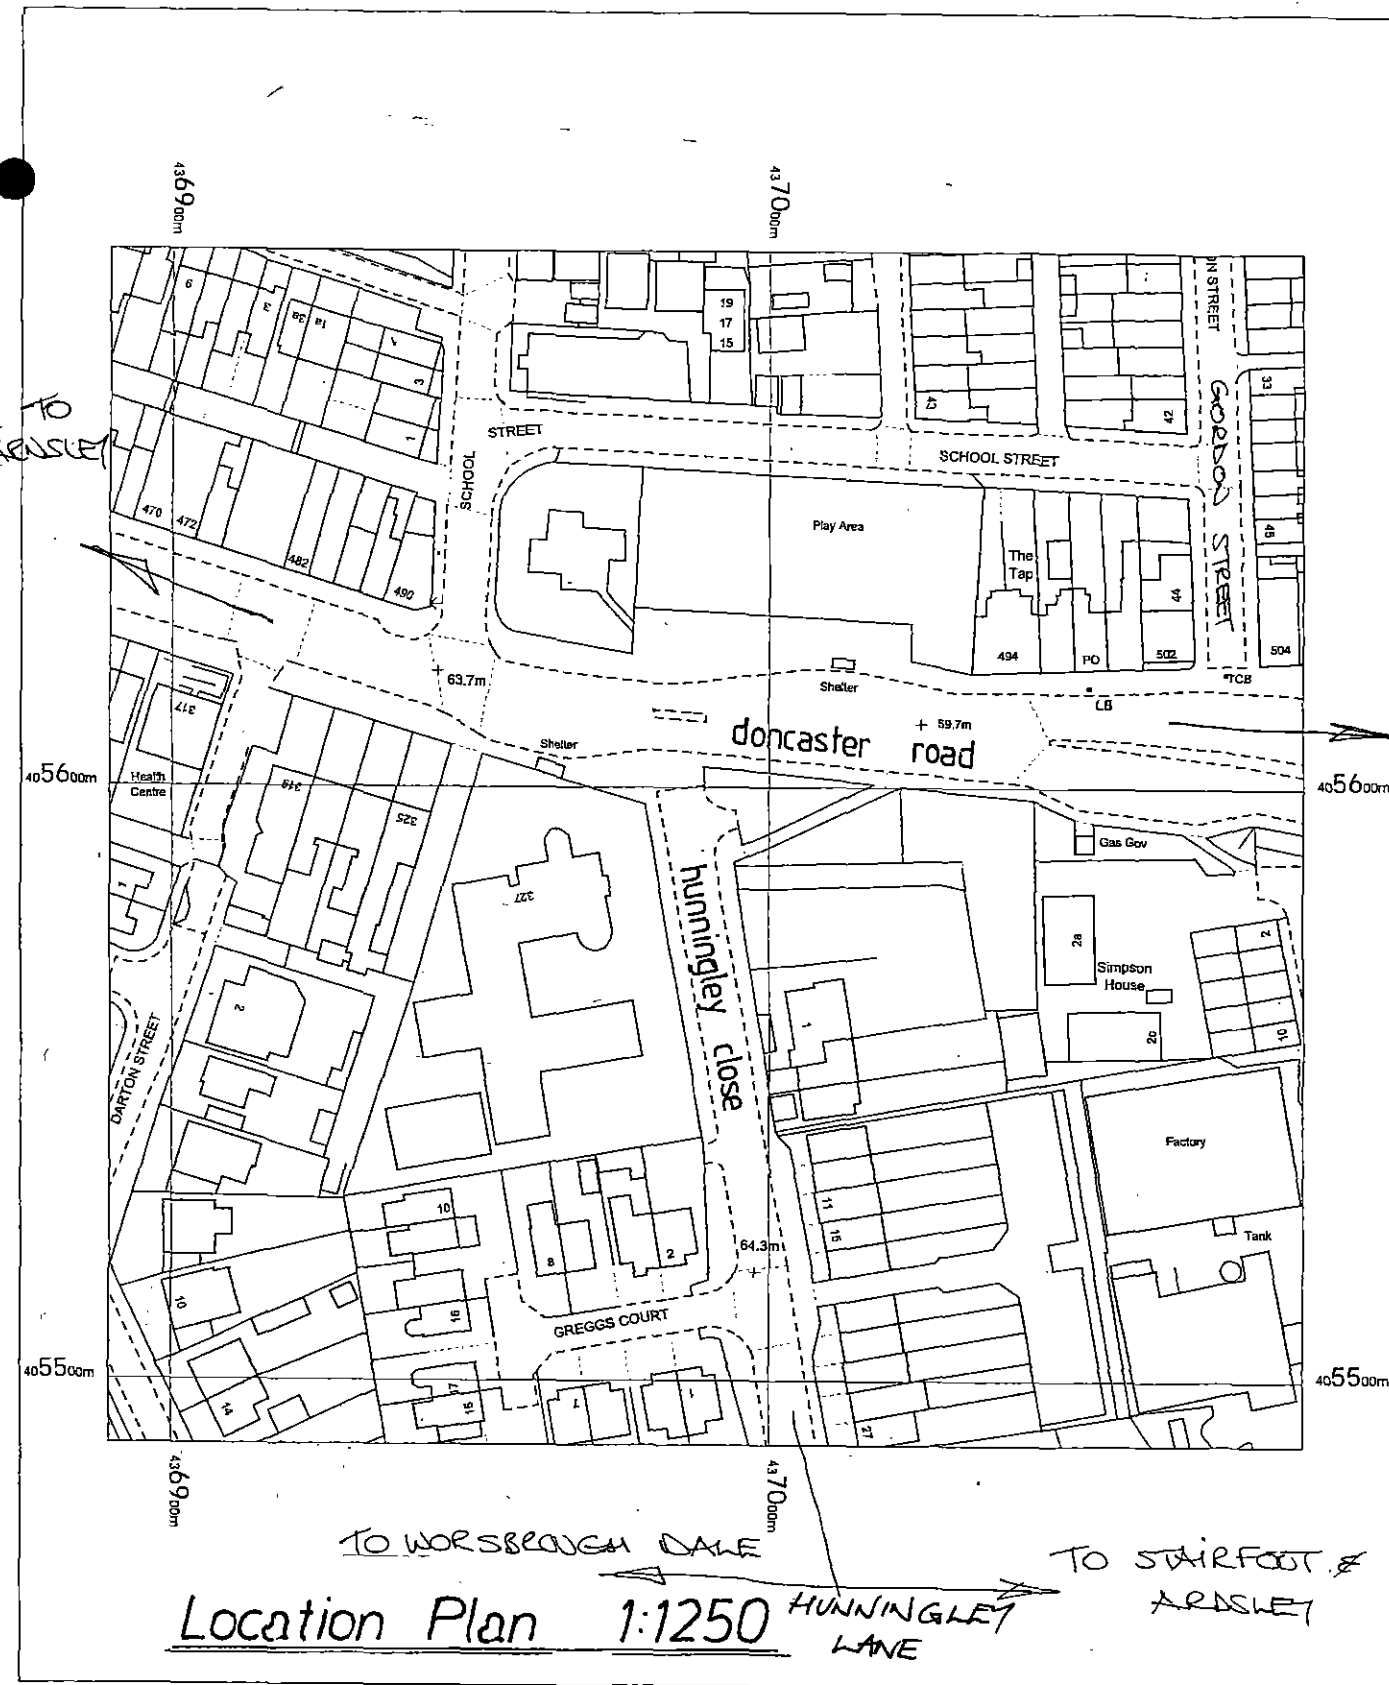

347 Doncaster Road,
And Land
Stairfoot,
Barnsley
S70 3PH

OS MasterMap 1250/2500/10000 scale
Thursday, March 20, 2025, ID: BW1-01213336
www.blackwellmapping.co.uk


1:1250 scale print at A4, Centre: 436989 E, 405589 N

©Crown Copyright Ordnance Survey. Licence no.
100041041




BLACKWELL'S
www.blackwellmapping.co.uk

TEL: 0114 268 7658
maps.sheffield@blackwell.co.uk


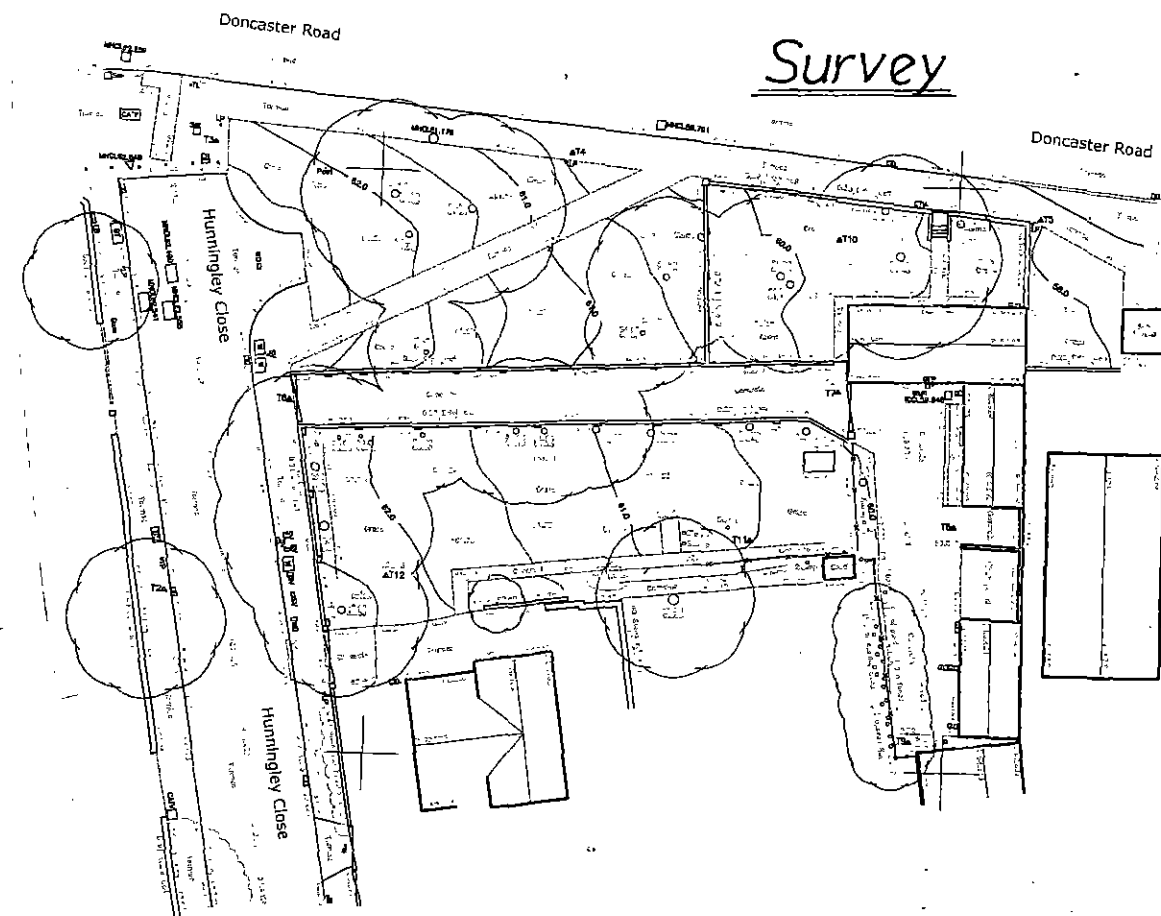


Scale 1:500

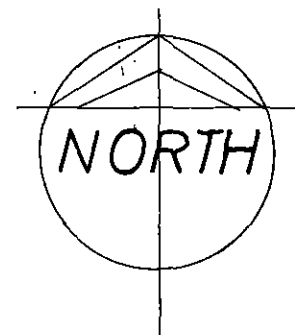

Garry Greetham Associates Residential Design Consultant Westwood House 18 Carr Lane Tannersley Barnsley S75 3BE Tel 07786062364	
PROJECT Residential Development	
CLIENT Mr. Dave Gill	
TITLE Location & Survey Layouts	
ADDRESS off Huntingley Close, Stairfoot, Barnsley. S70 3PH	
DRAWN BY 999	
SCALE scales @ A3 DATE Mar 25	
DRAWING NO 514-01	
Member of the Chartered Institute of Architectural Technologists	

Rev	Notes	Date

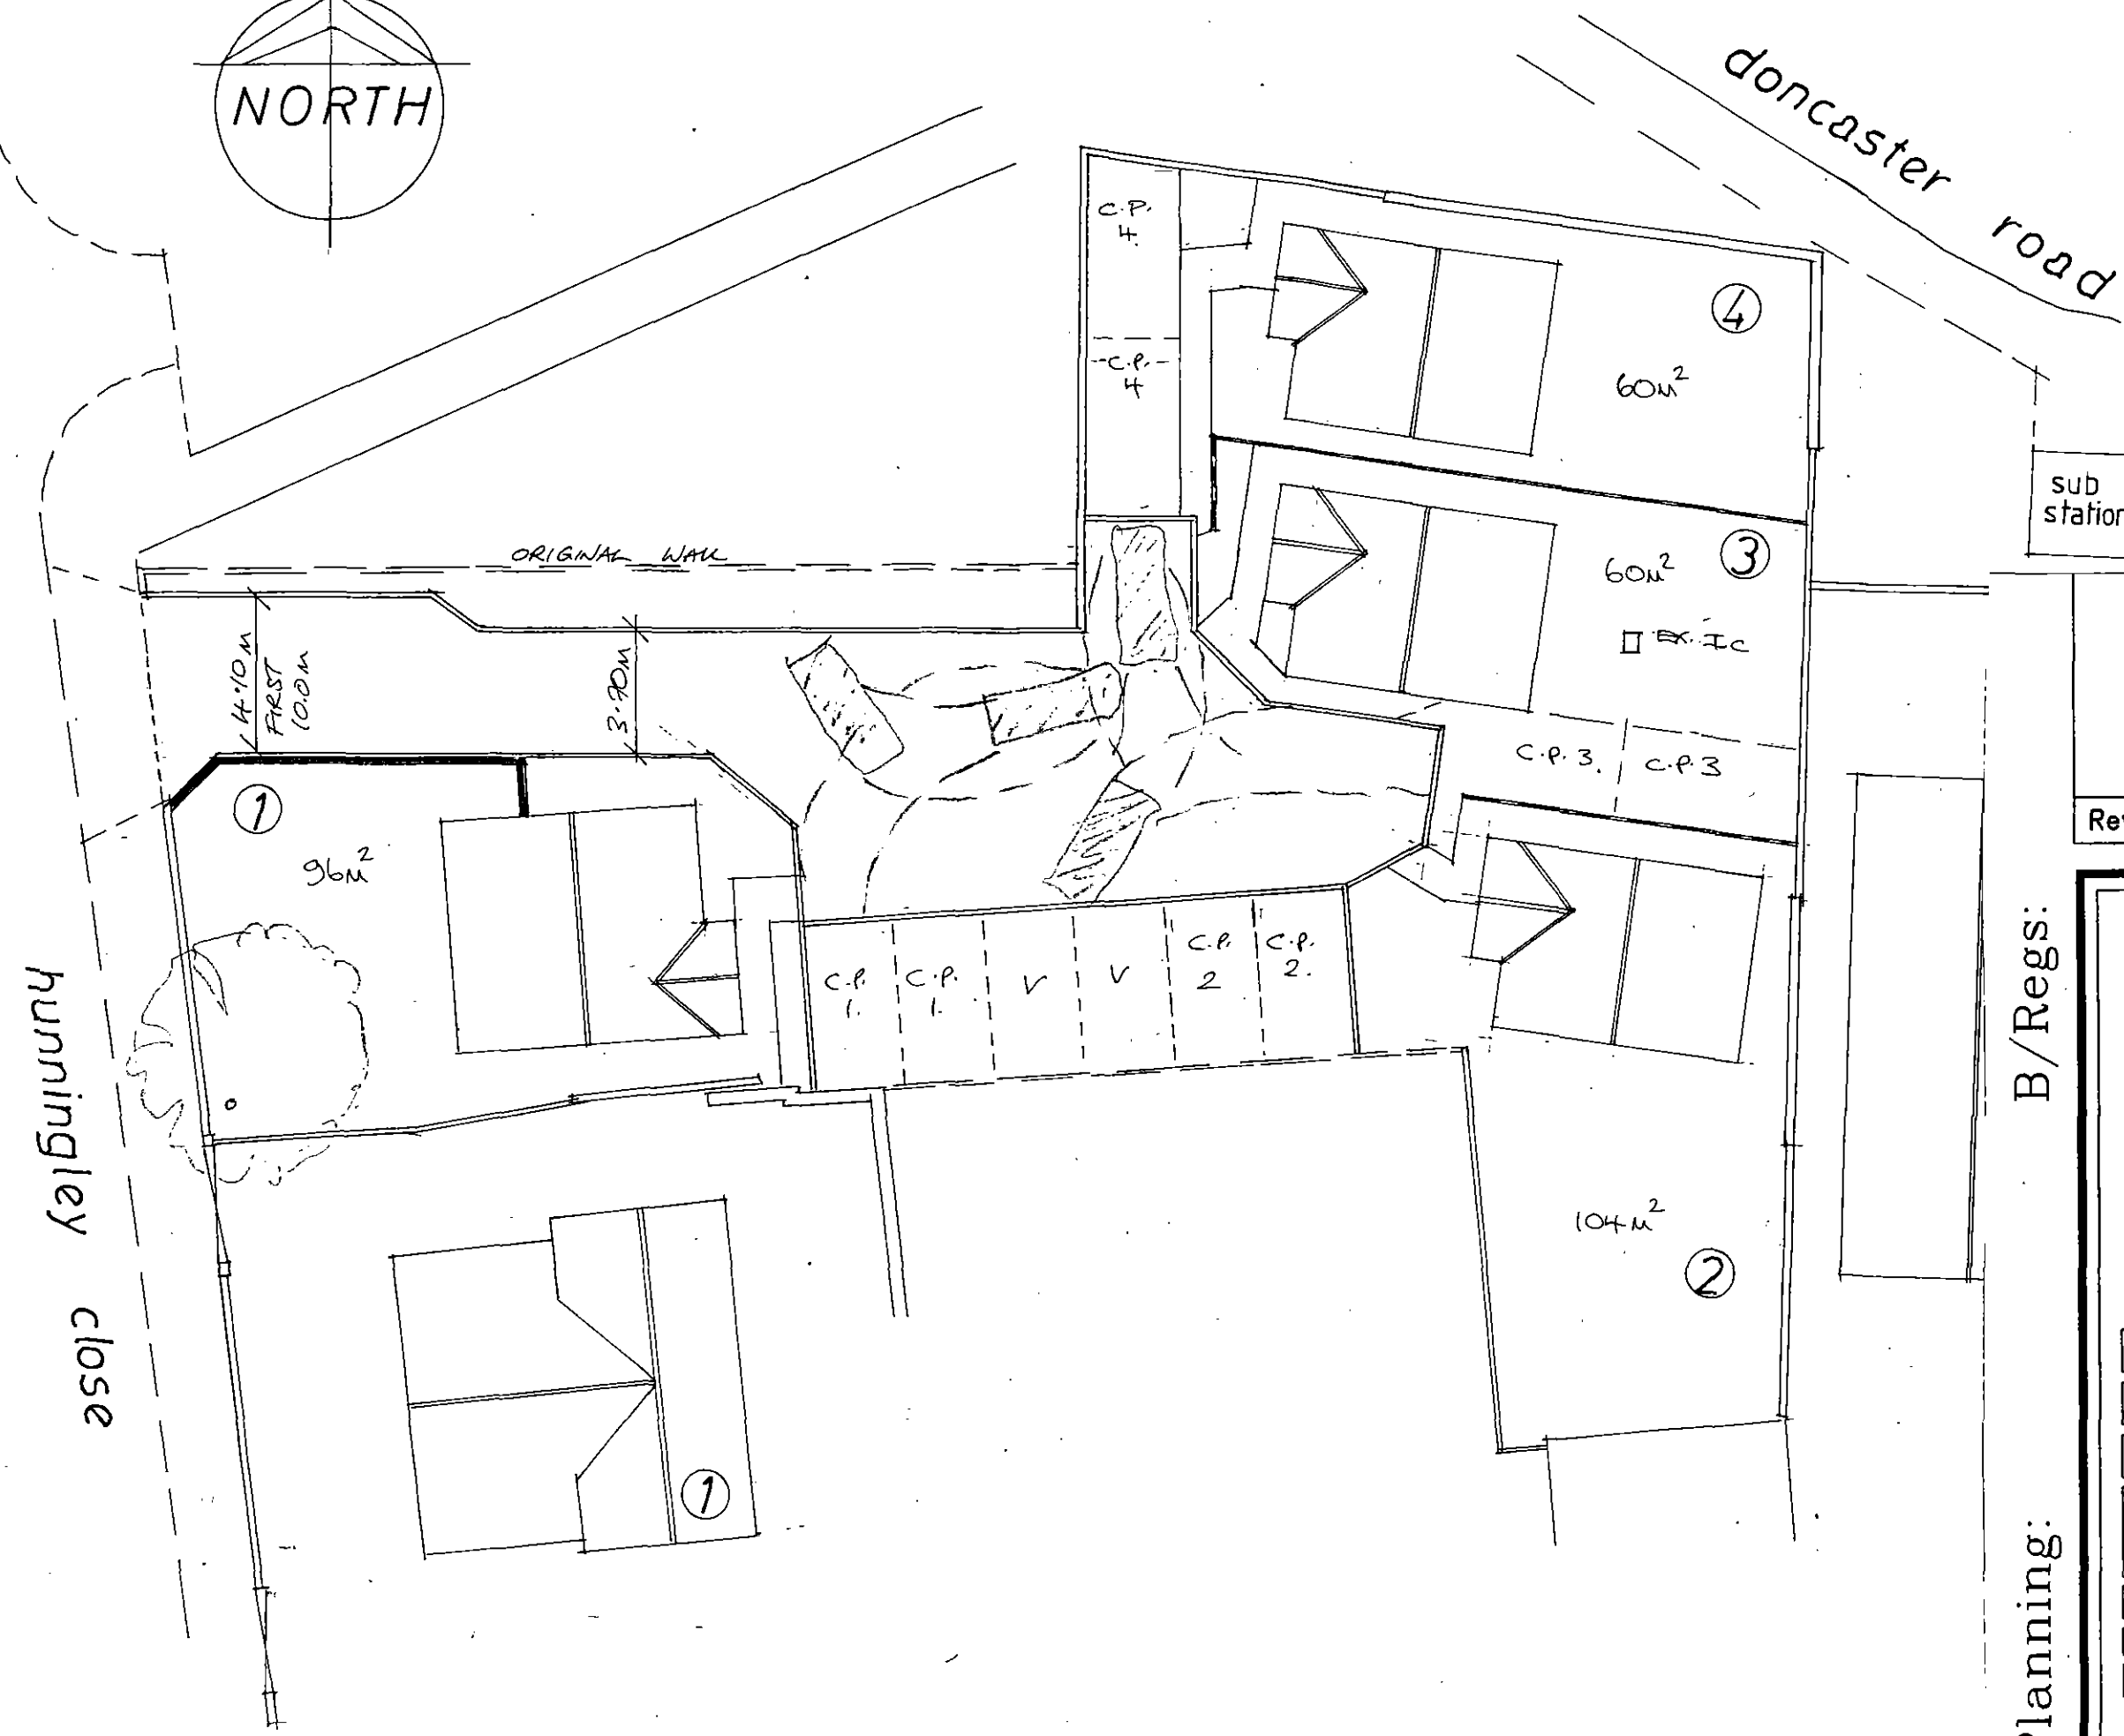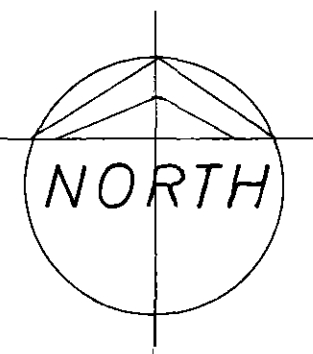


sub station

Rev	Notes	Date

Planning: B/Regs:

Garry Greetham Associates
Residential Design Consultant
Westwood House
18 Carr Lane
Tankersley
Barnsley S75 3BE
Tel 07786062364

PROJECT	Residential Development
CLIENT	Mr. Dave Gill
TITLE	Site Layout
ADDRESS	off Huningley Close, Stairfoot, Barnsley. S70 3PH
DRAWN BY	ggg
SCALE	1:200 @ A3 DATE Mar 25
DRAWING No	514-02 REV
Member of the Chartered Institute of Architectural Technologists	

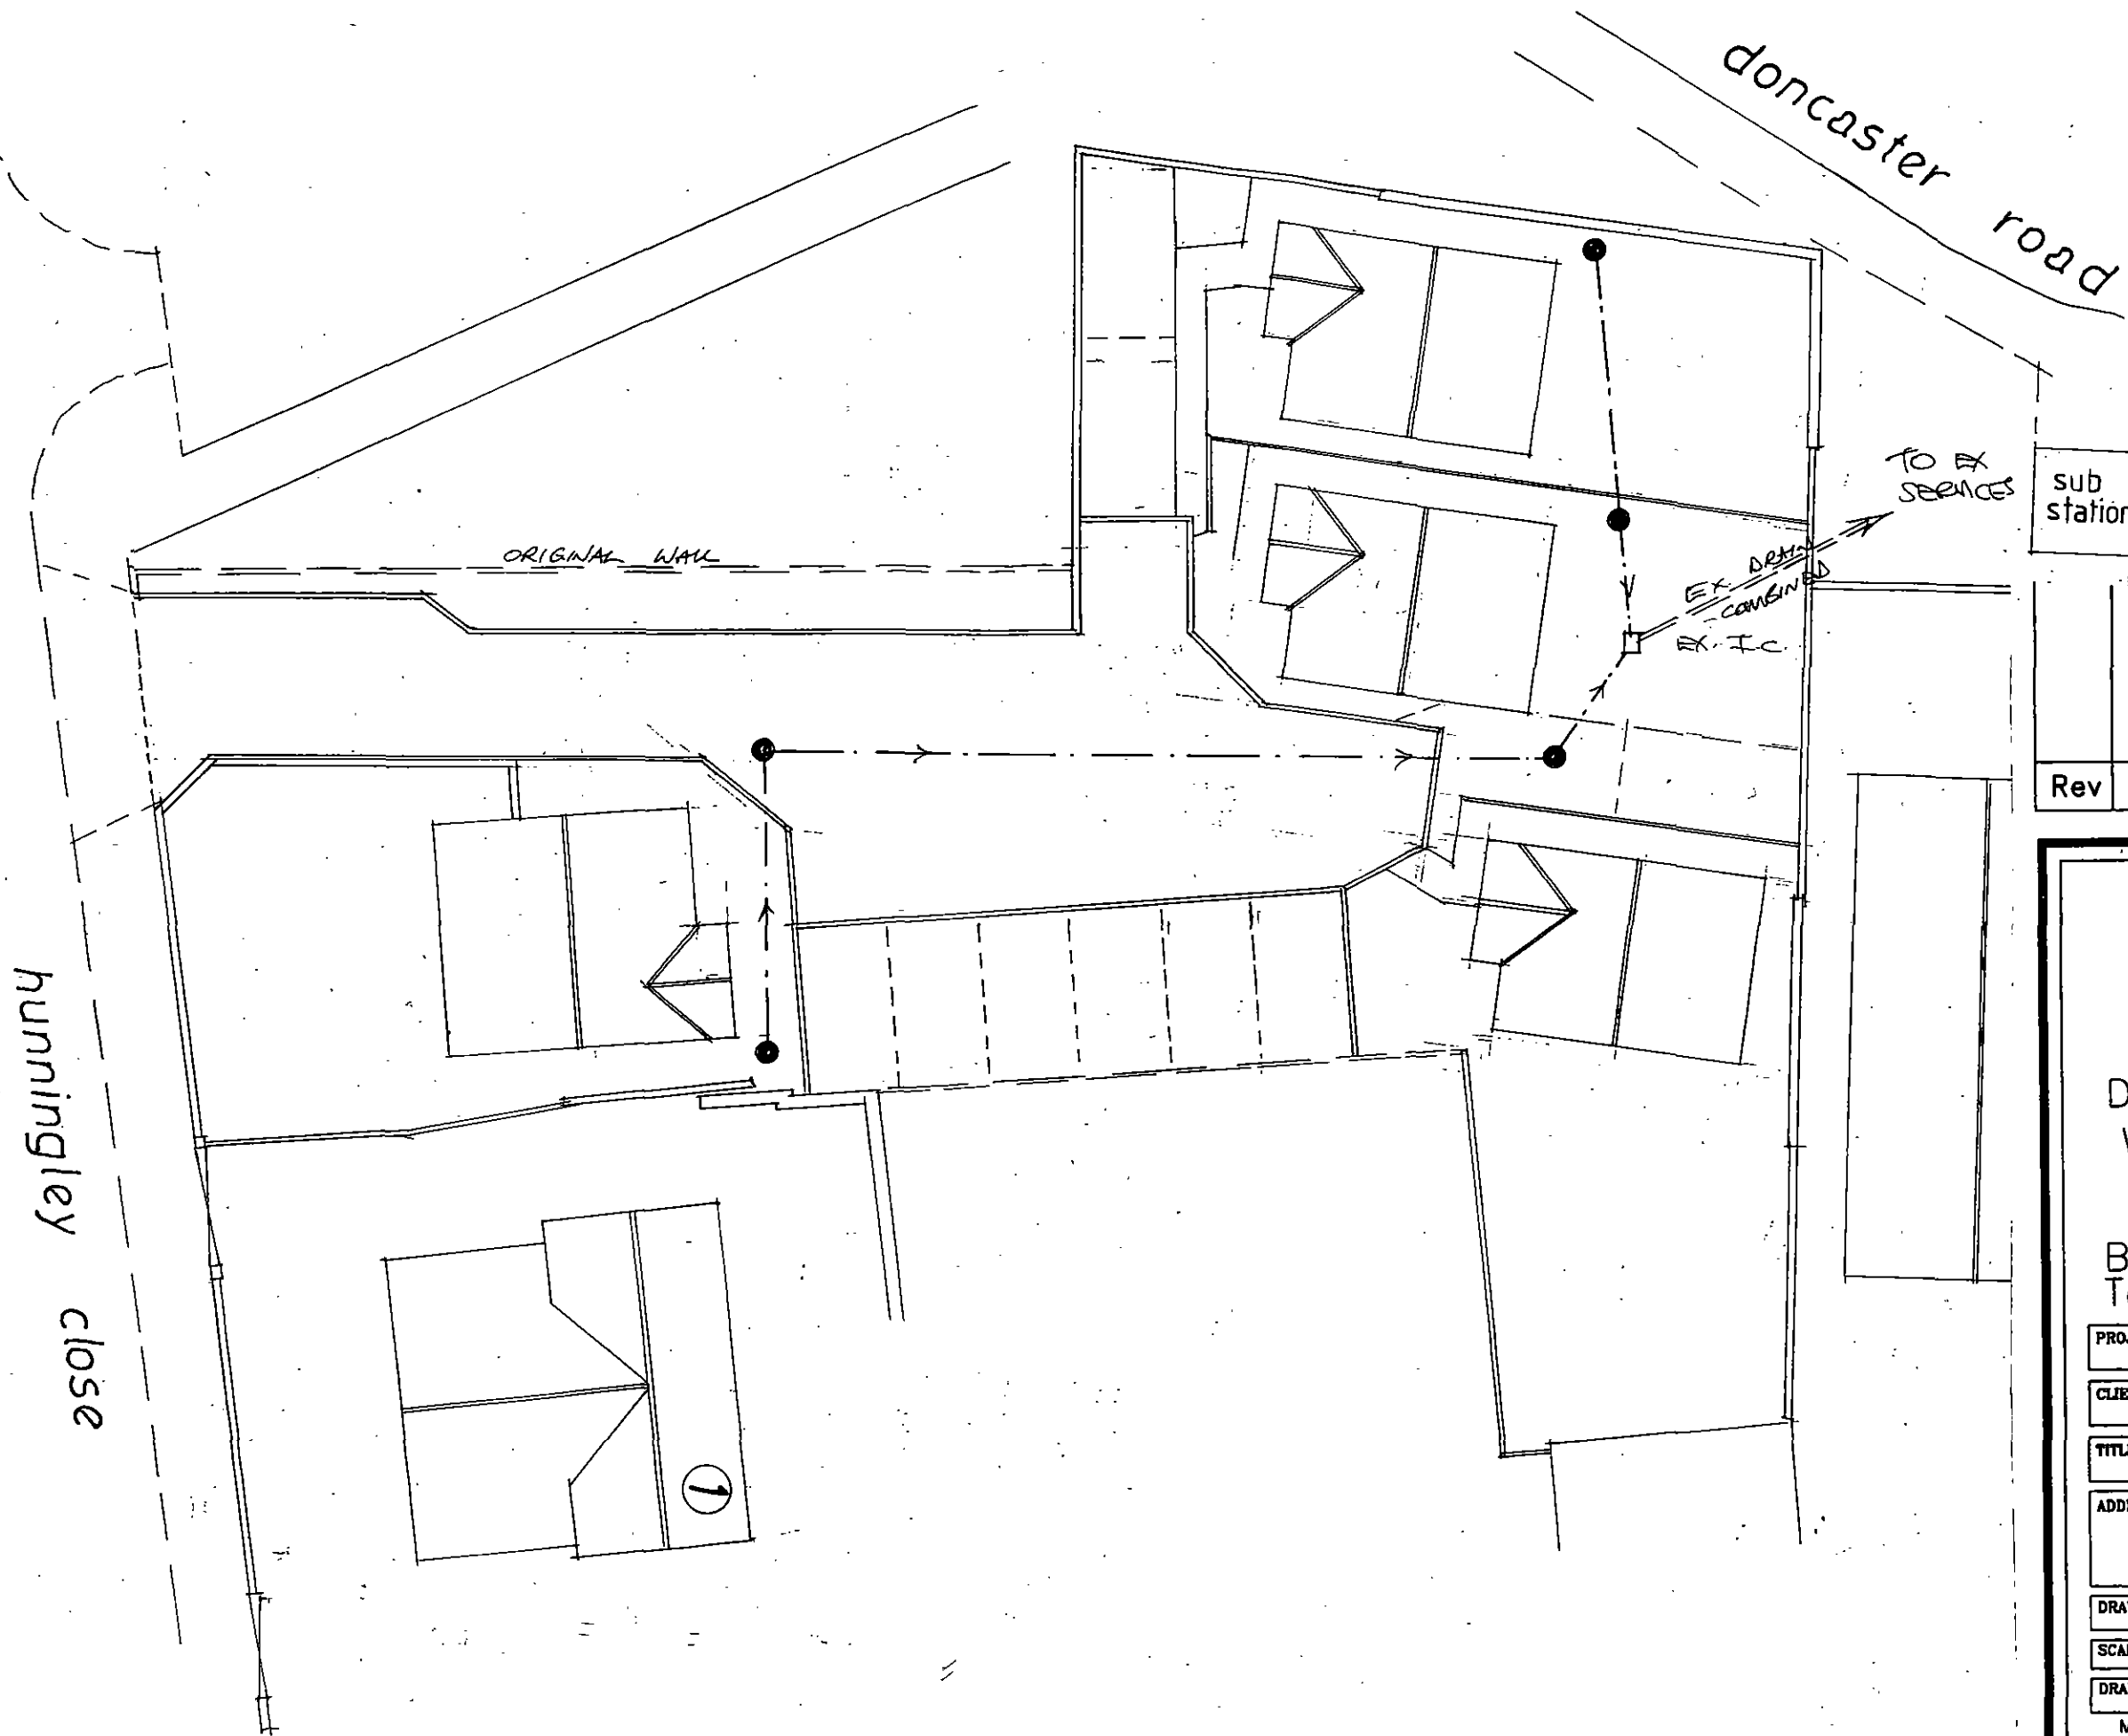

Rev	Notes	Date

Garry Greetham Associates
 Residential Design Consultant
 Westwood House
 18 Carr Lane
 Tankersley
 Barnsley S75 3BE
 Tel 07786062364

PROJECT Residential Development

CLIENT Mr. Dave Gill

TITLE Drainage Layout


ADDRESS off Huningley Close,
Stairfoot,
Barnsley. S70 3PH

DRAWN BY ggg


SCALE 1:200 @ A3 DATE Mar 25

DRAWING No 514-03 REV


Member of the Chartered Institute
of Architectural Technologists

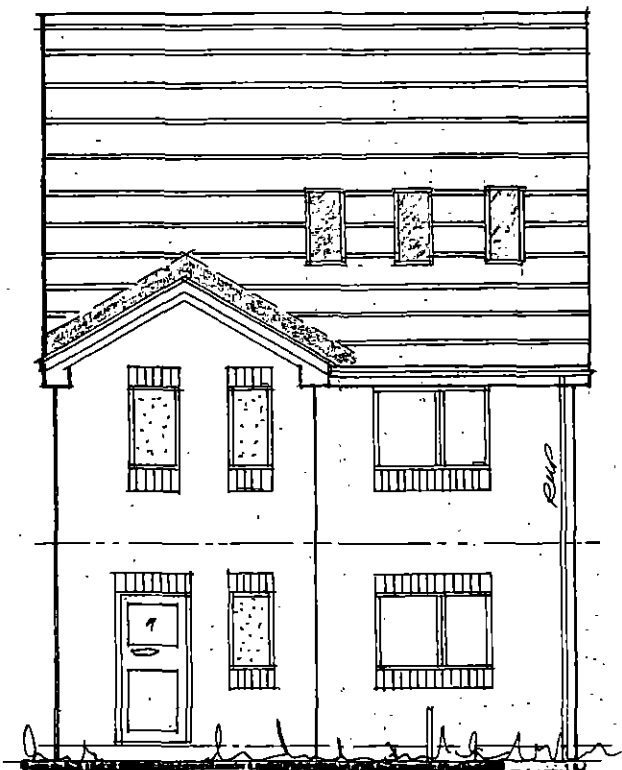


Front

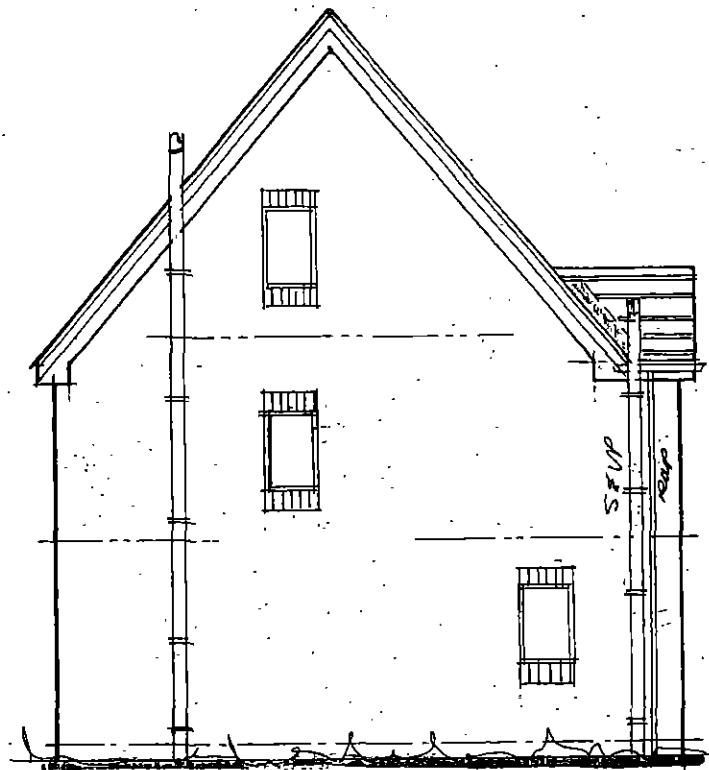

Side

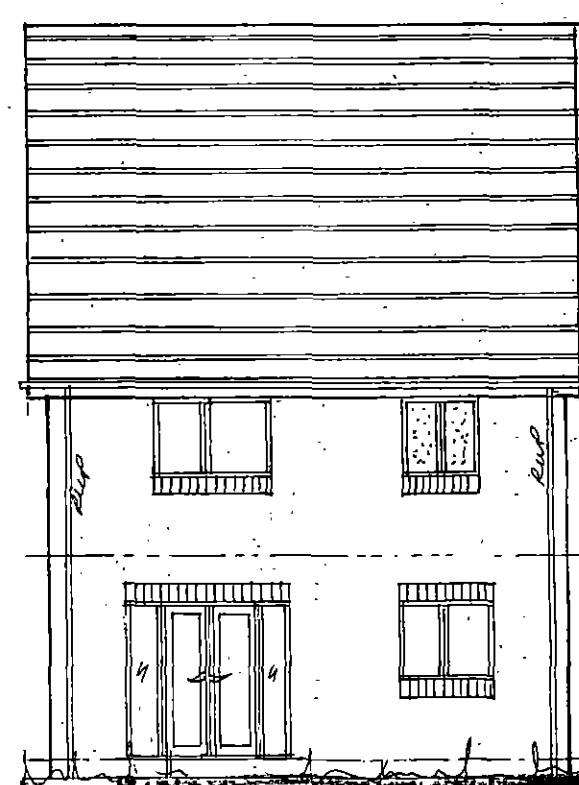

Rear

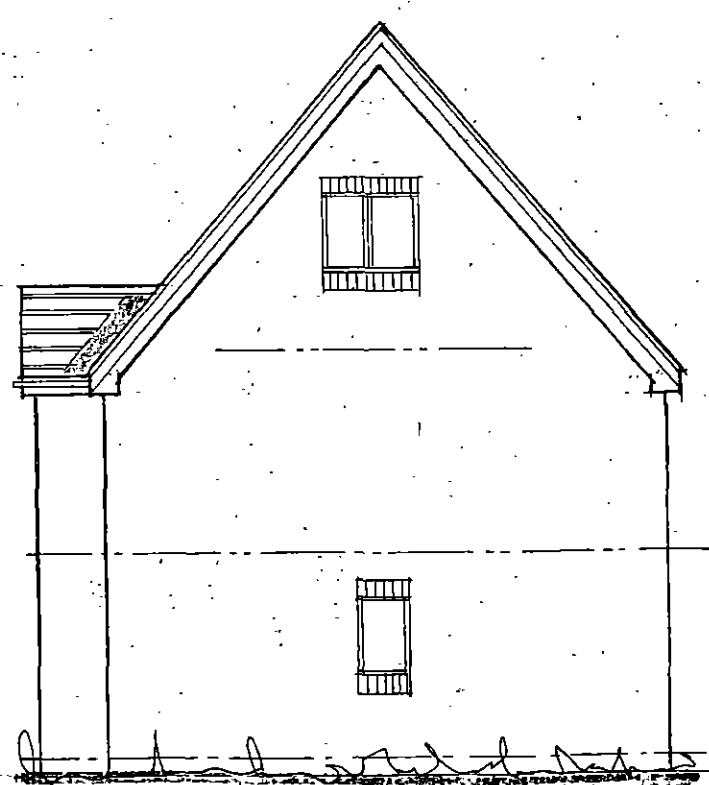


Side

Rev	Notes	Date

Garry Greetham Associates
 Residential Design Consultant
 Westwood House
 18 Carr Lane
 Tankersley
 Barnsley S75 3BE
 Tel 07786062364

PROJECT	Residential Development	
CLIENT	Mr. Dave Gill	
TITLE	Plot 1 Elevations	
ADDRESS	off Hunningley Close, Stairfoot. Barnsley. S70 3PH	
DRAWN BY	ggg	
SCALE	1:100 @ A3	DATE Mar 25
DRAWING No	514-04	REV

Member of the Chartered Institute
 of Architectural Technologists

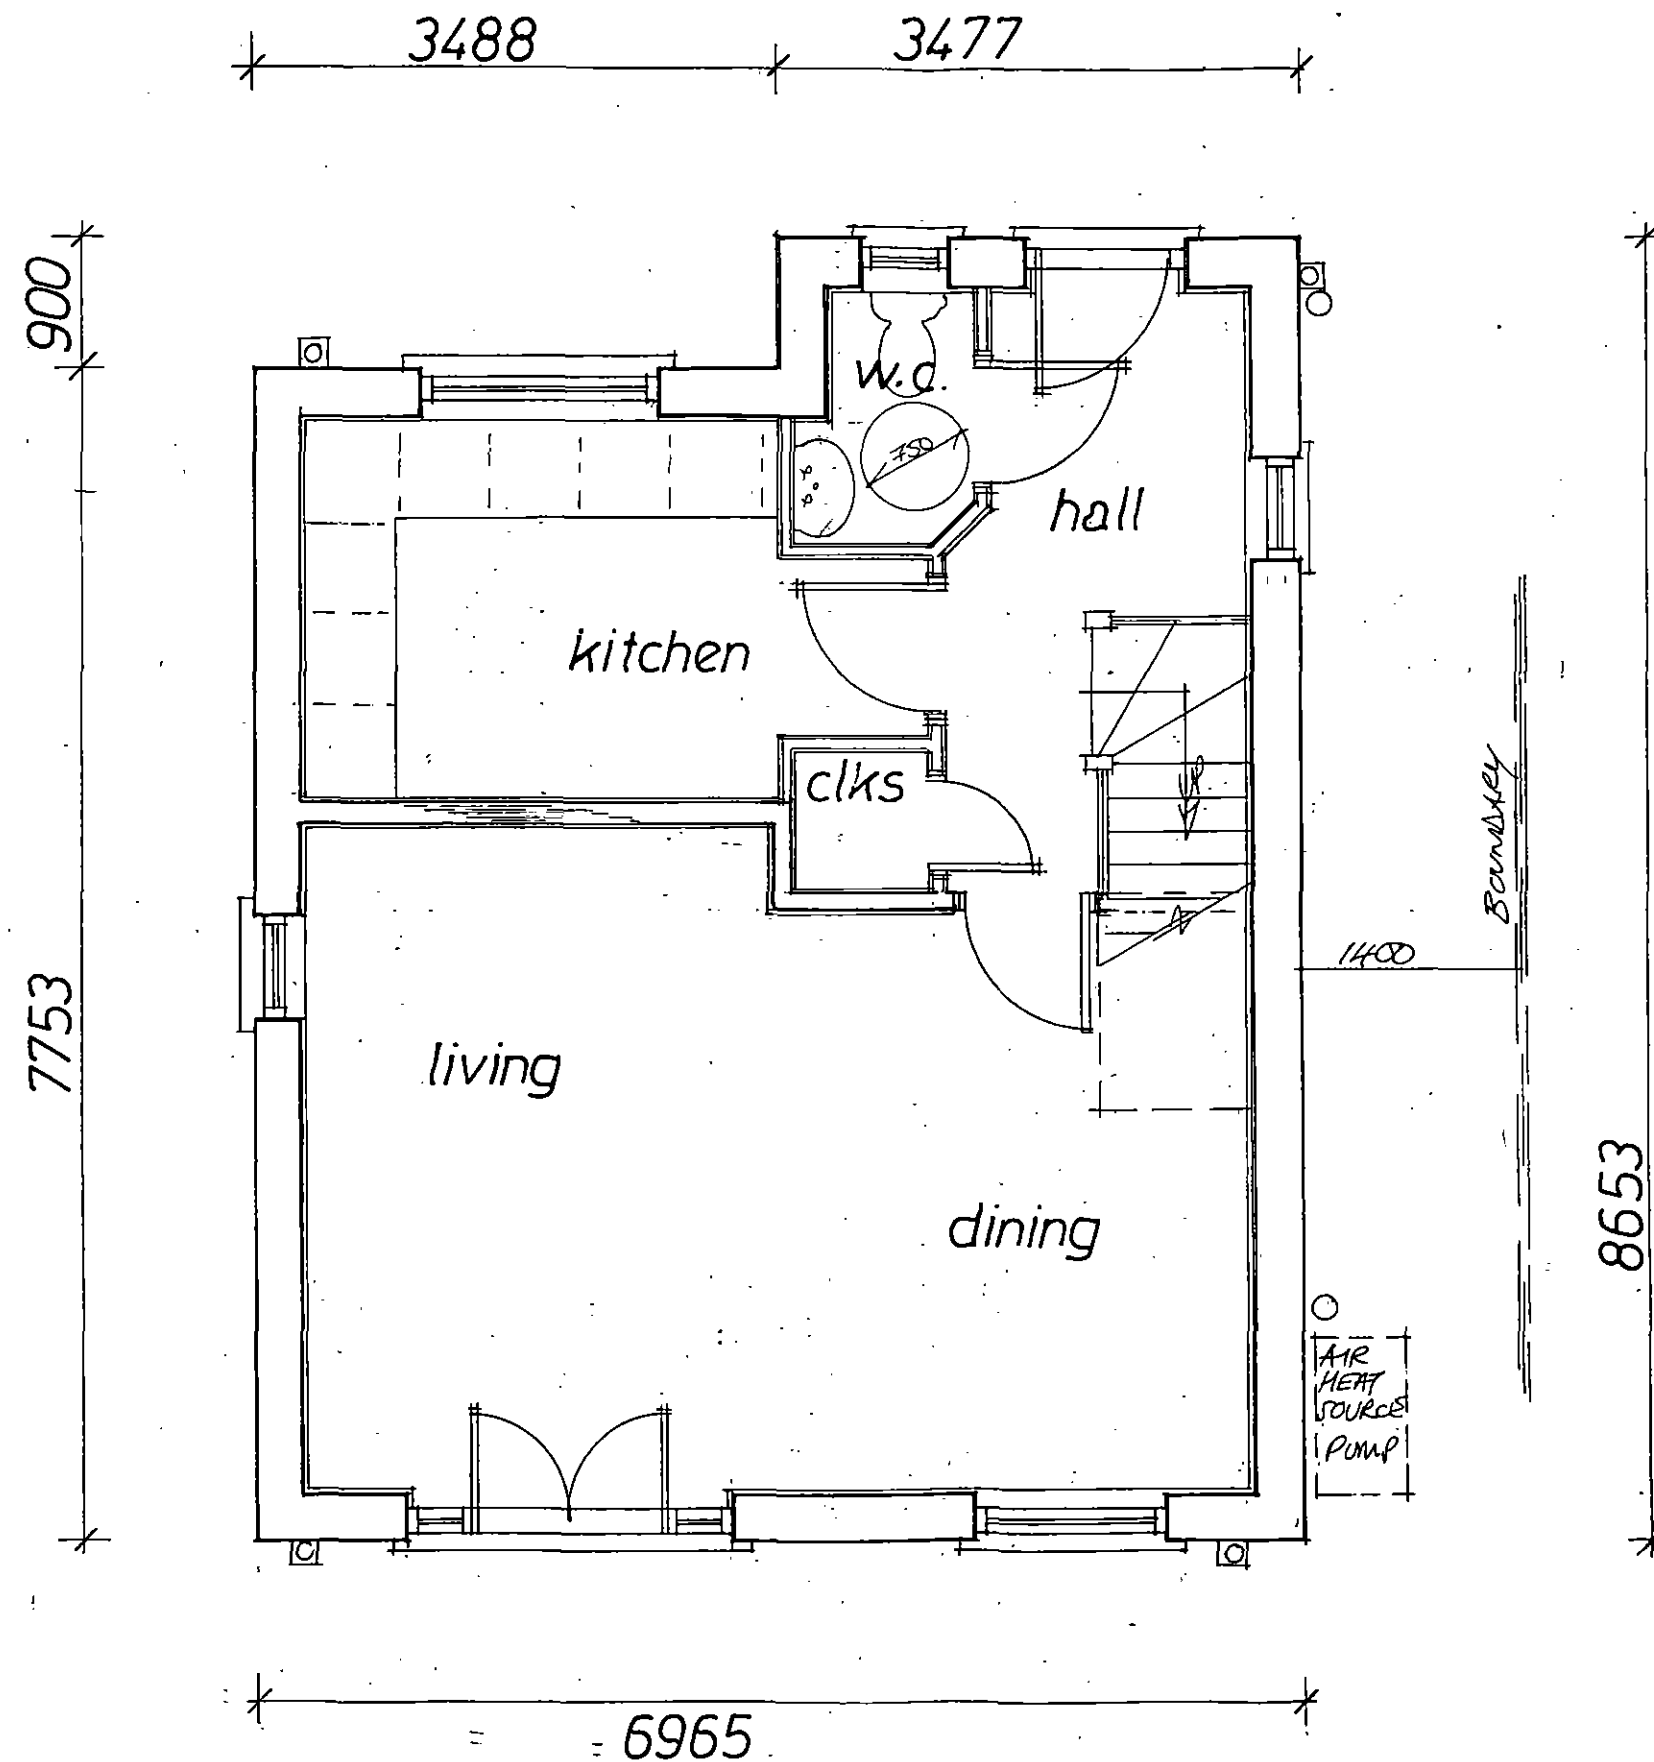

Rev	Notes	Date

Garry Greetham Associates
 Residential Design Consultant
 Westwood House
 18 Carr Lane
 Tankersley
 Barnsley S75 3BE
 Tel 07786062364

PROJECT Residential Development

CLIENT Mr. Dave Gill

TITLE Plot 1 Ground Floor Layout


ADDRESS off Hunningley Close,
 Stairfoot,
 Barnsley. S70 3PH

DRAWN BY ggg

SCALE 1:50 @ A3 **DATE** Mar 25

DRAWING No 514-05 **REV**

Member of the Chartered Institute
 of Architectural Technologists

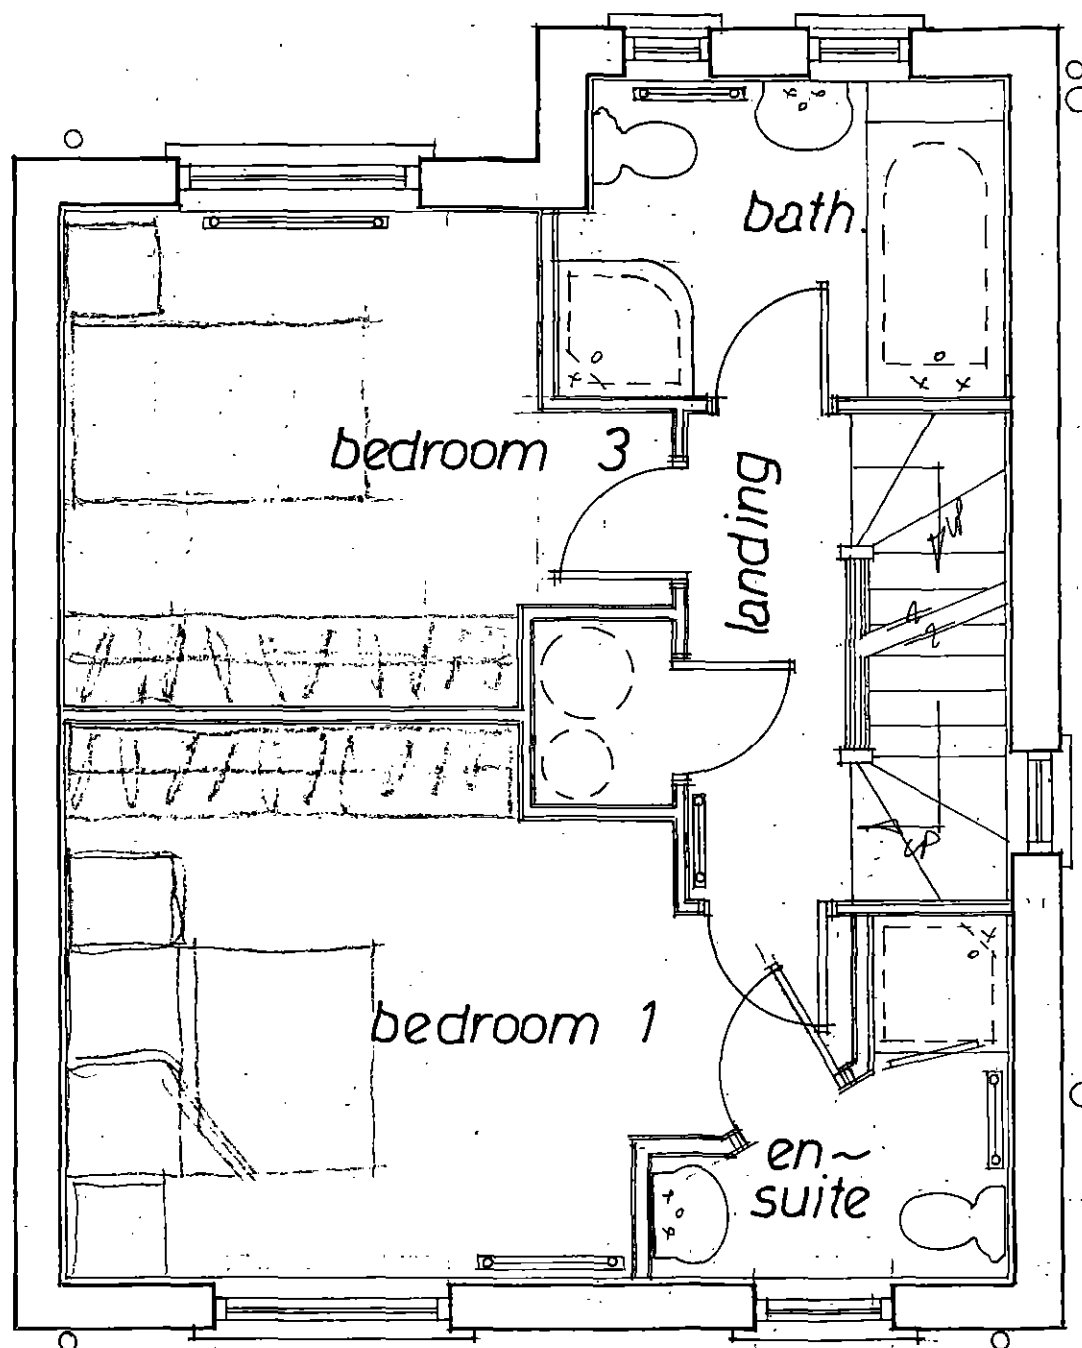

Rev	Notes	Date

Garry Greetham Associates

Residential Design Consultant

Westwood House

18 Carr Lane

Tankersley

Barnsley S75 3BE

Tel 07786062364

PROJECT Residential Development

CLIENT Mr. Dave Gill

TITLE Plot 1 First Floor Layout


ADDRESS off Hunningley Close,
Stairfoot,
Barnsley. S70 3PH

DRAWN BY ggg

SCALE 1:50 @ A3 DATE Mar 25

DRAWING No 514-06 REV

Member of the Chartered Institute
of Architectural Technologists

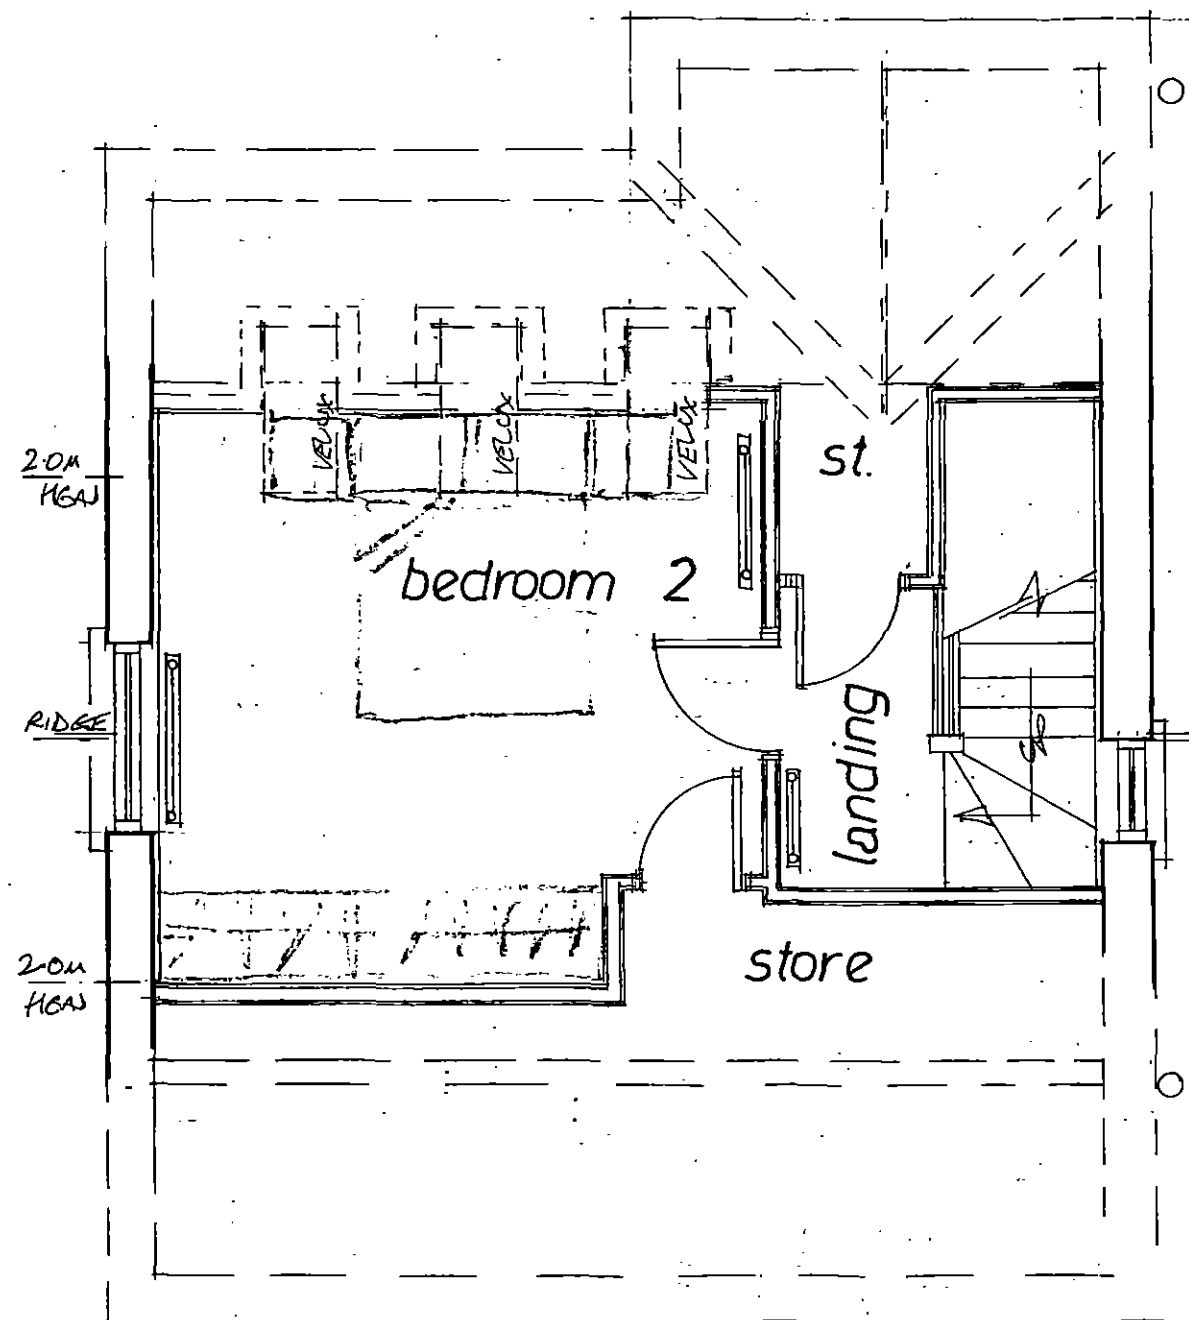


Rev	Notes	Date


Garry Greetham Associates
 Residential Design Consultant
 Westwood House
 18 Carr Lane
 Tankersley
 Barnsley S75 3BE
 Tel 07786062364

PROJECT	Residential Development
CLIENT	Mr. Dave Gill
TITLE	Plot 1 Second Floor Layout
ADDRESS	off Hunningley Close, Stairfoot, Barnsley. S70 3PH
DRAWN BY	ggg
SCALE	1:50 @ A3 DATE Mar 25
DRAWING No	514-07 REV


Member of the Chartered Institute of Architectural Technologists

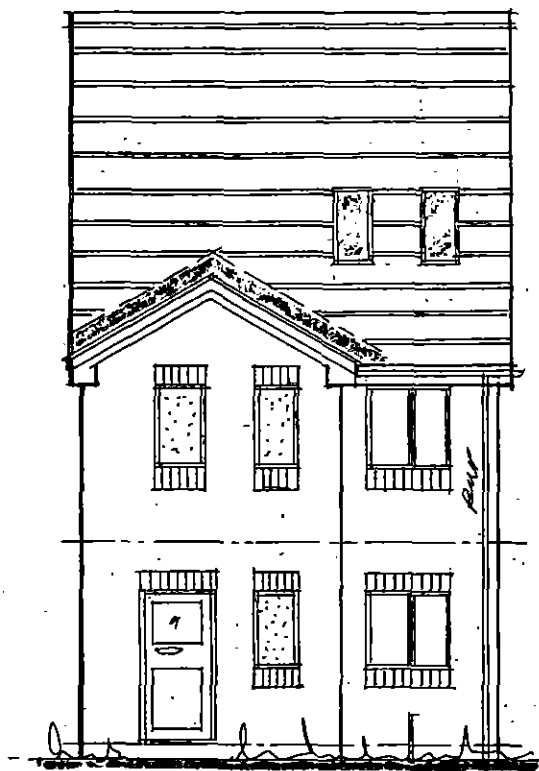


Front

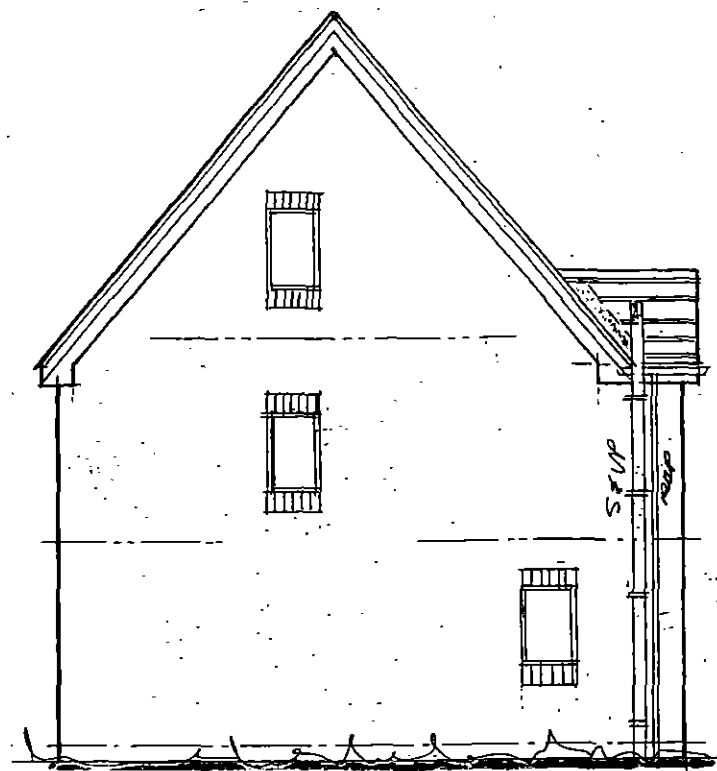

Side

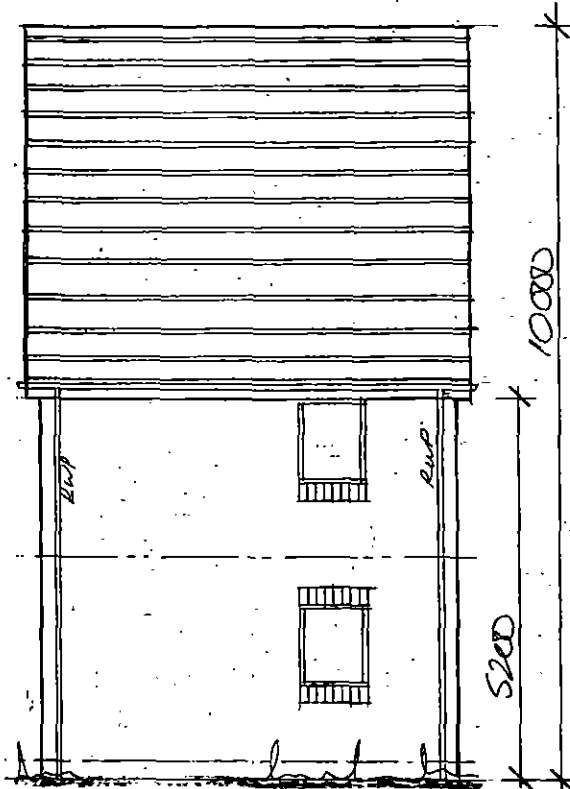

Rear

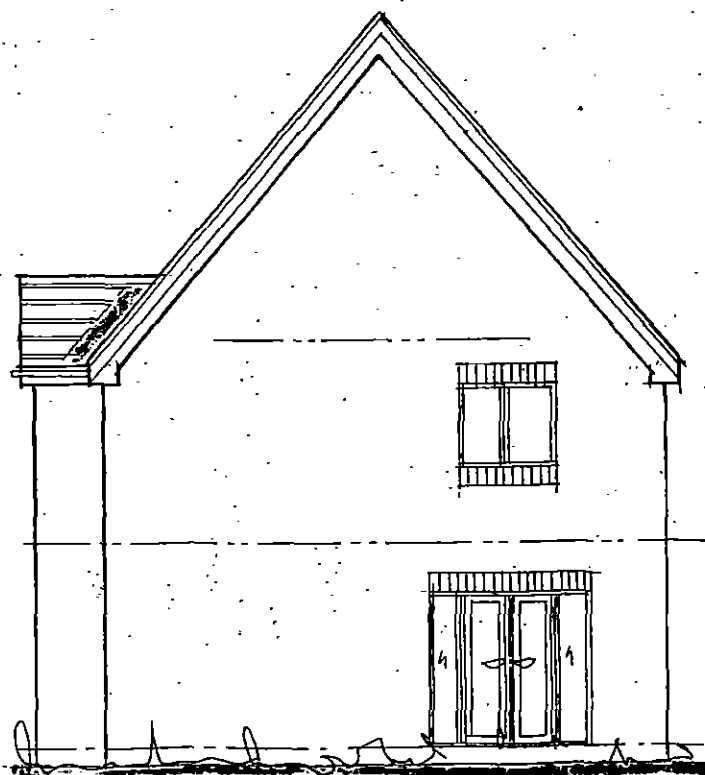

Side

Rev	Notes	Date

**Garry
Greetham
Associates**

Residential
Design Consultant

Westwood House
18 Carr Lane
Tankersley

Barnsley S75 3BE
Tel 07786062364

PROJECT Residential Development

CLIENT Mr. Dave Gill

TITLE Plot 2 Elevations


ADDRESS off Hunningley Close,
Stairfoot,
Barnsley. S70 3PH

DRAWN BY ggg

SCALE 1:100 @ A3 DATE Mar 25

DRAWING No 514-08 REV

Member of the Chartered Institute
of Architectural Technologists

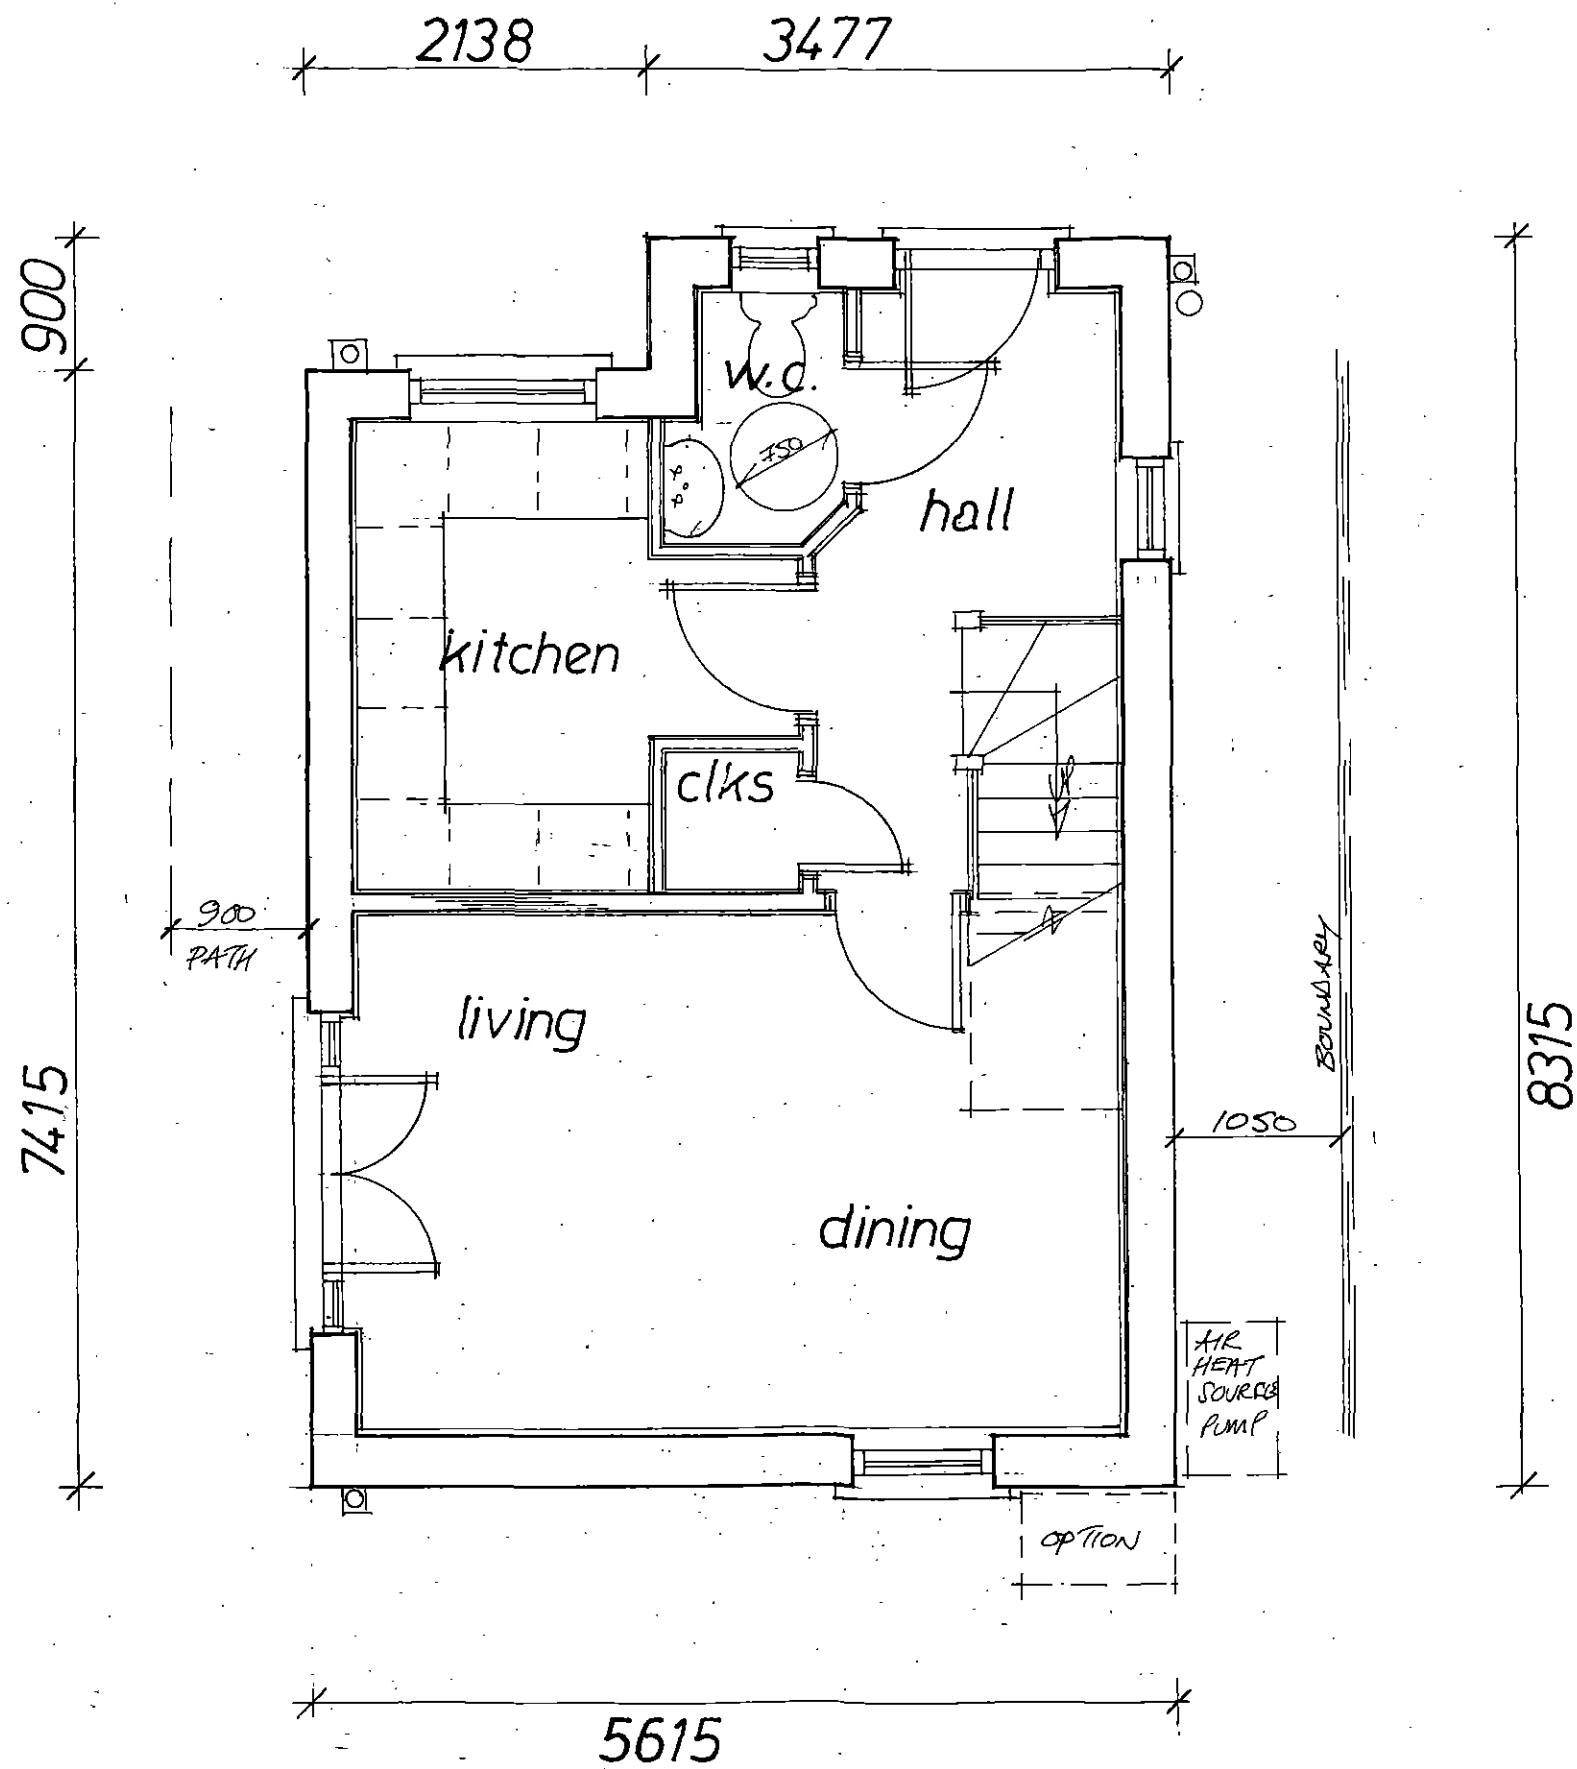

Rev	Notes	Date

Garry Greetham Associates

Residential
Design Consultant
Westwood House
18 Carr Lane
Tankersley
Barnsley S75 3BE
Tel 07786062364

PROJECT Residential Development

CLIENT Mr. Dave Gill

TITLE Plot 2 Ground Floor Layout


ADDRESS off Hunningley Close,
Stairfoot,
Barnsley. S70 3PH

DRAWN BY ggg

SCALE 1:50 @ A3 DATE Mar 25

DRAWING No 514-09 REV

Member of the Chartered Institute
of Architectural Technologists

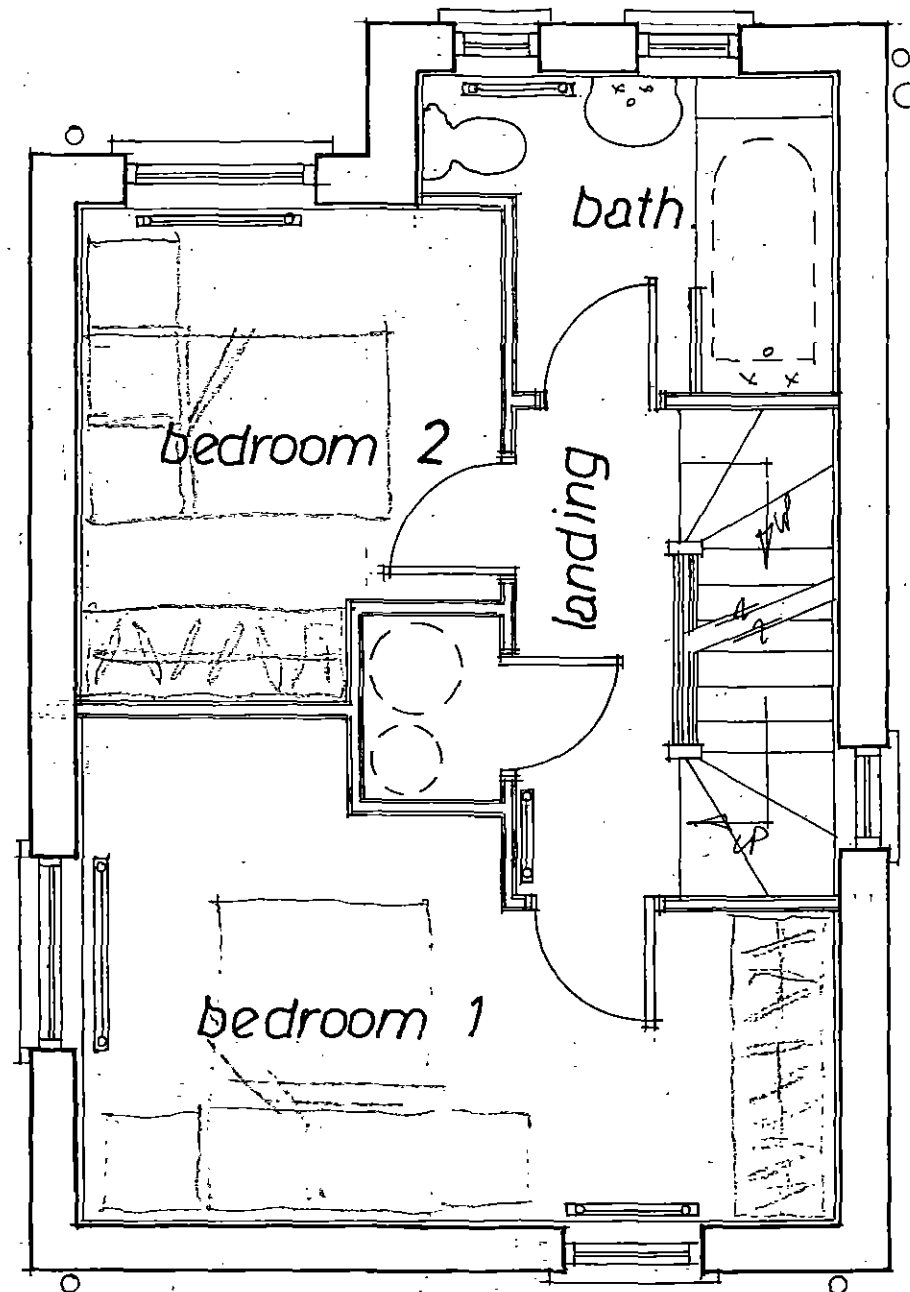

Rev	Notes	Date

Garry Greetham Associates
 Residential Design Consultant
 Westwood House
 18 Carr Lane
 Tankersley
 Barnsley S75 3BE
 Tel 07786062364

PROJECT Residential Development

CLIENT Mr. Dave Gill

TITLE Plot 2 First Floor Layout


ADDRESS off Hunningley Close,
 Stairfoot.
 Barnsley. S70 3PH

DRAWN BY ggg

SCALE 1:50 @ A3 DATE Mar 25

DRAWING No 514-10 REV

Member of the Chartered Institute of Architectural Technologists

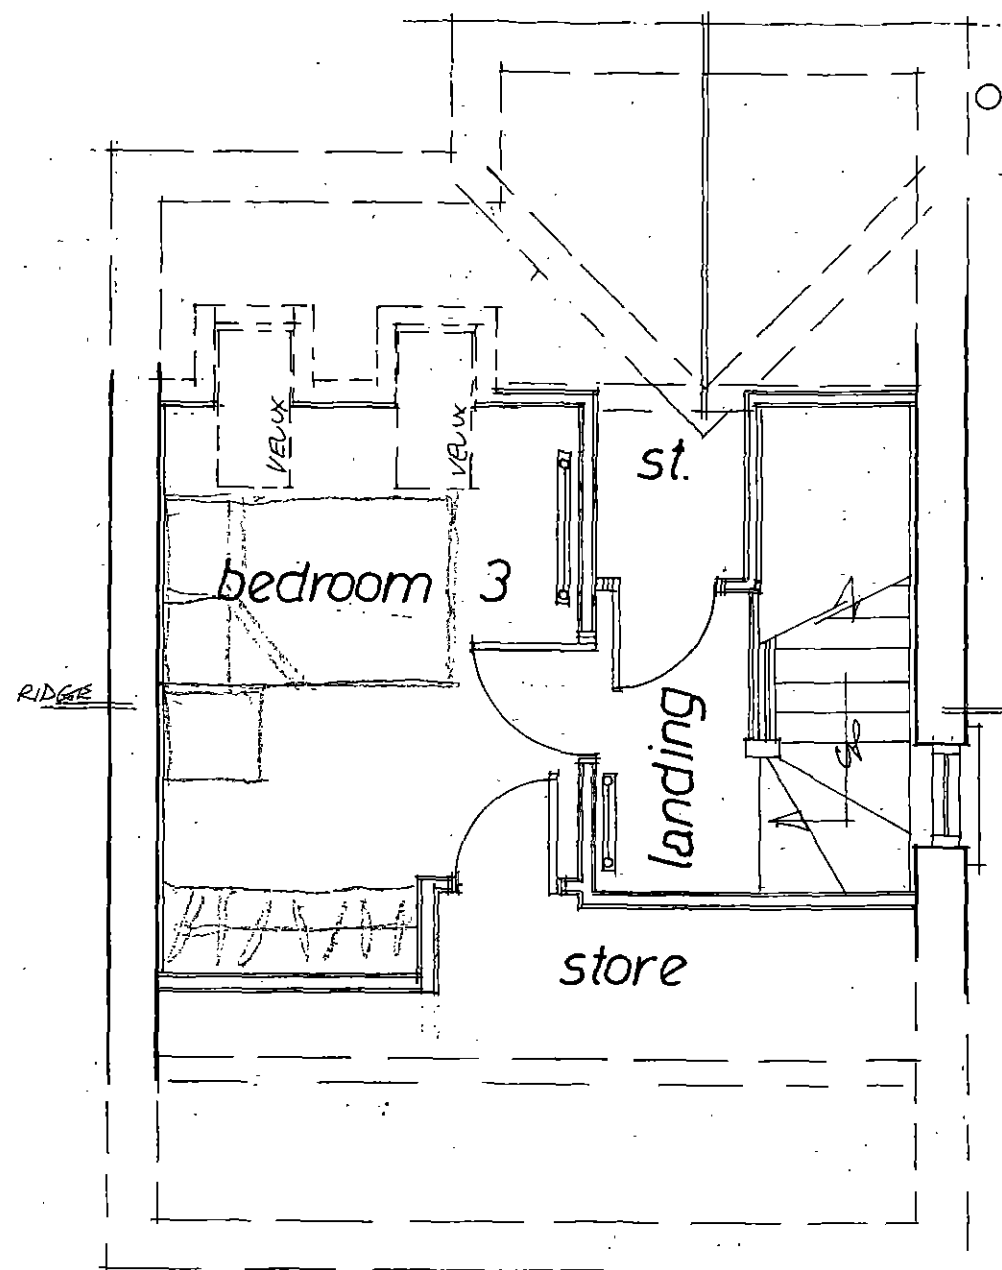

Rev	Notes	Date

**Garry
Greetham
Associates**

Residential
Design Consultant
Westwood House
18 Carr Lane
Tankersley
Barnsley S75 3BE
Tel 07786062364

PROJECT Residential Development

CLIENT Mr. Dave Gill

TITLE Plot 2 Second Floor Layout

ADDRESS off Hunningley Close,
Stairfoot,
Barnsley. S70 3PH

DRAWN BY ggg


SCALE 1:50 @ A3 **DATE** Mar 25

DRAWING No 514-11 **REV**


Member of the Chartered Institute
of Architectural Technologists




Front

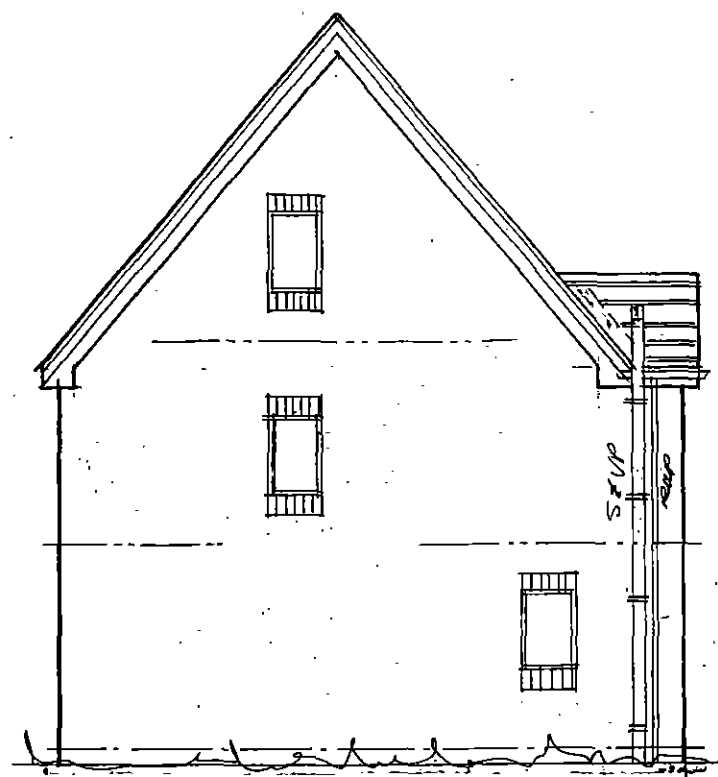

Side

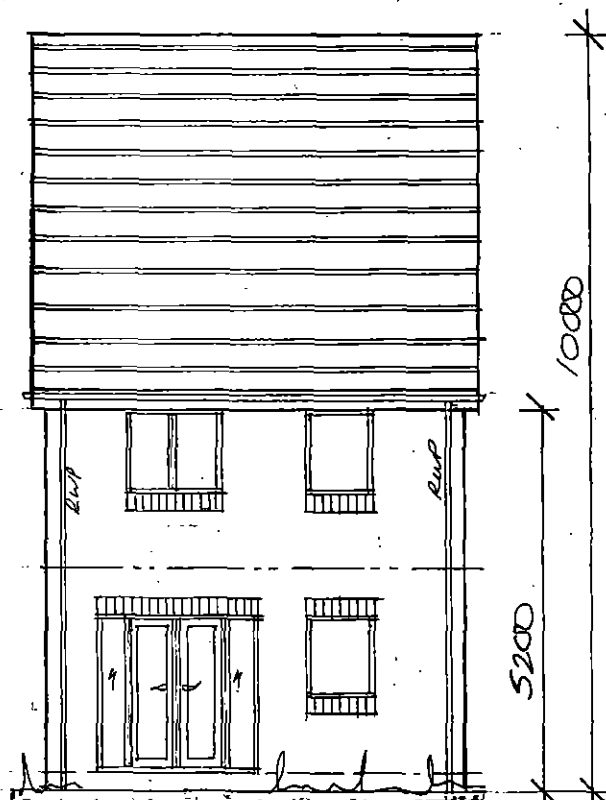

Rear

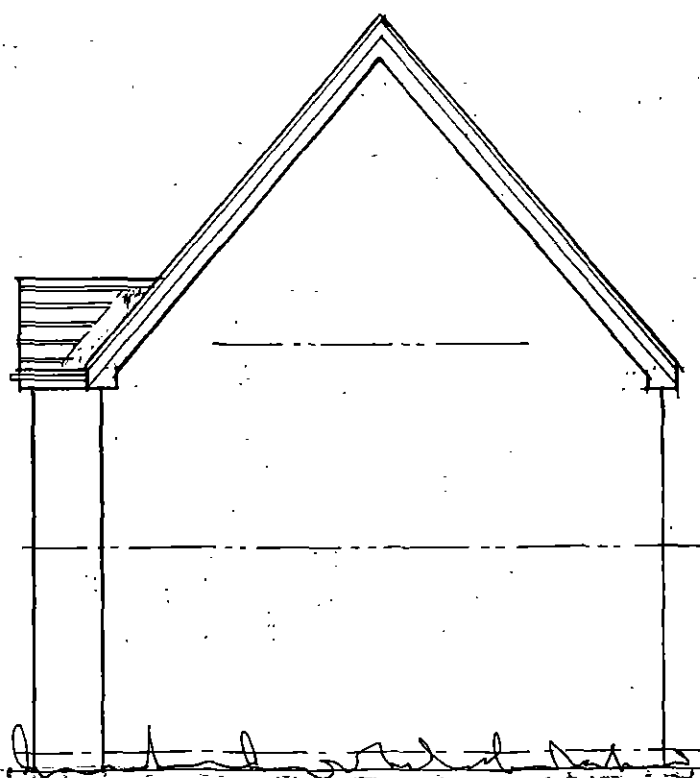

Side

Rev	Notes	Date

Garry Greetham Associates
 Residential Design Consultant
 Westwood House
 18 Carr Lane
 Tankersley
 Barnsley S75 3BE
 Tel 07786062364

PROJECT Residential Development

CLIENT Mr. Dave Gill

TITLE Plots 3 & 4 Elevations


ADDRESS off Hunningley Close,
 Stairfoot,
 Barnsley. S70 3PH

DRAWN BY ggg

SCALE 1:100 @ A3 DATE Mar 25

DRAWING No 514-12 REV

Member of the Chartered Institute
 of Architectural Technologists

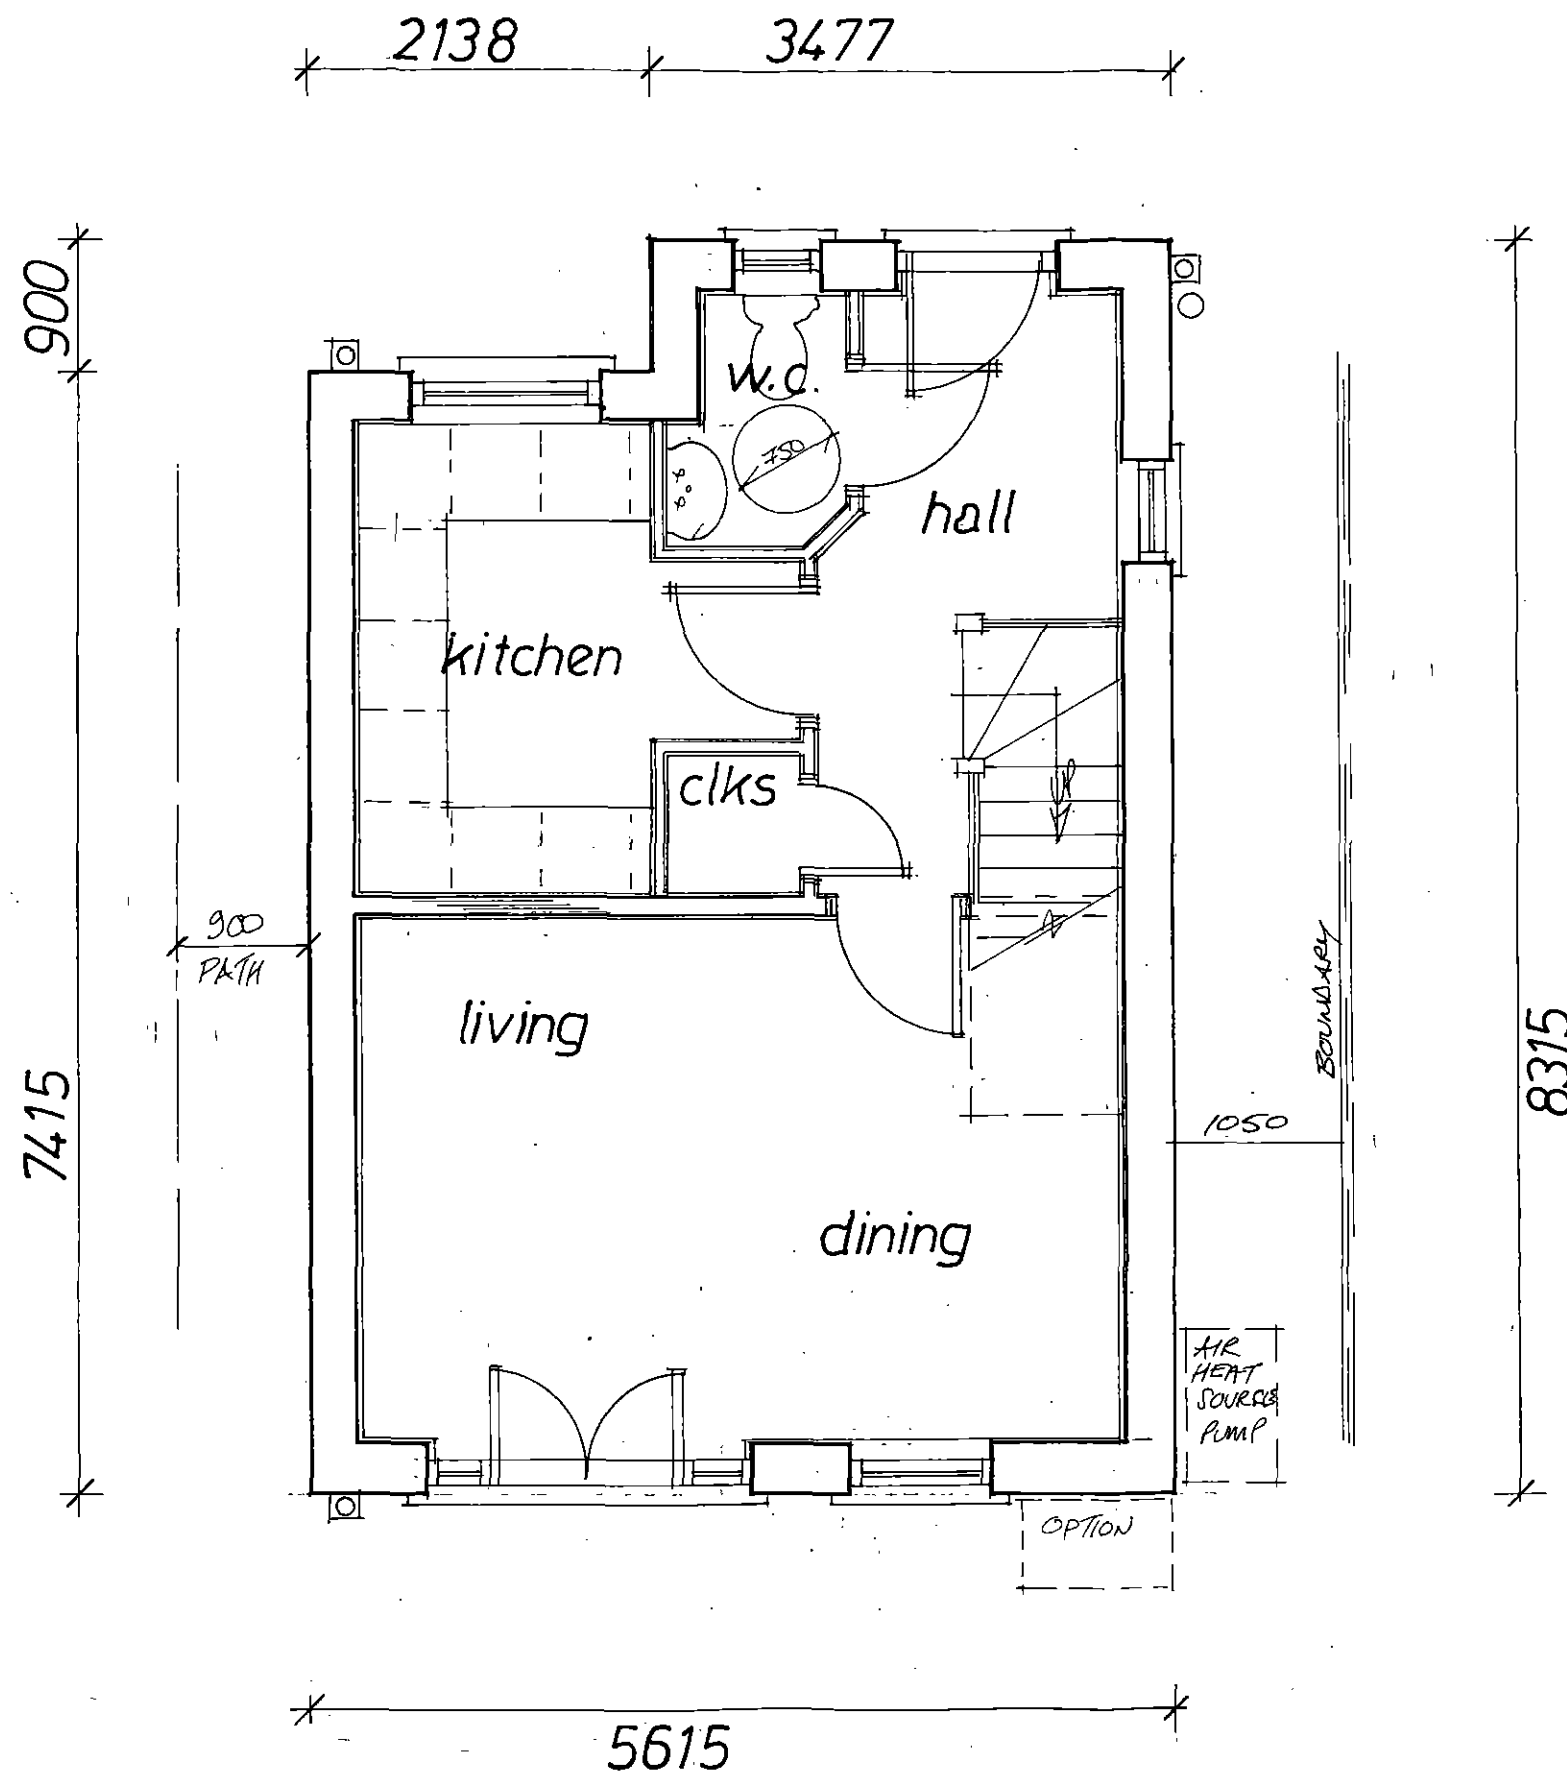


Rev	Notes	Date

Garry Greetham Associates

Residential Design Consultant
 Westwood House
 18 Carr Lane
 Tankersley
 Barnsley S75 3BE
 Tel 07786062364

PROJECT	Residential Development
CLIENT	Mr. Dave Gill
TITLE	Plots 3 & 4 G. F. Layout
ADDRESS	off Hunningley Close, Stairfoot, Barnsley. S70 3PH
DRAWN BY	ggg
SCALE	1:50 @ A3 DATE Mar 25
DRAWING No	514-13 REV

Member of the Chartered Institute of Architectural Technologists

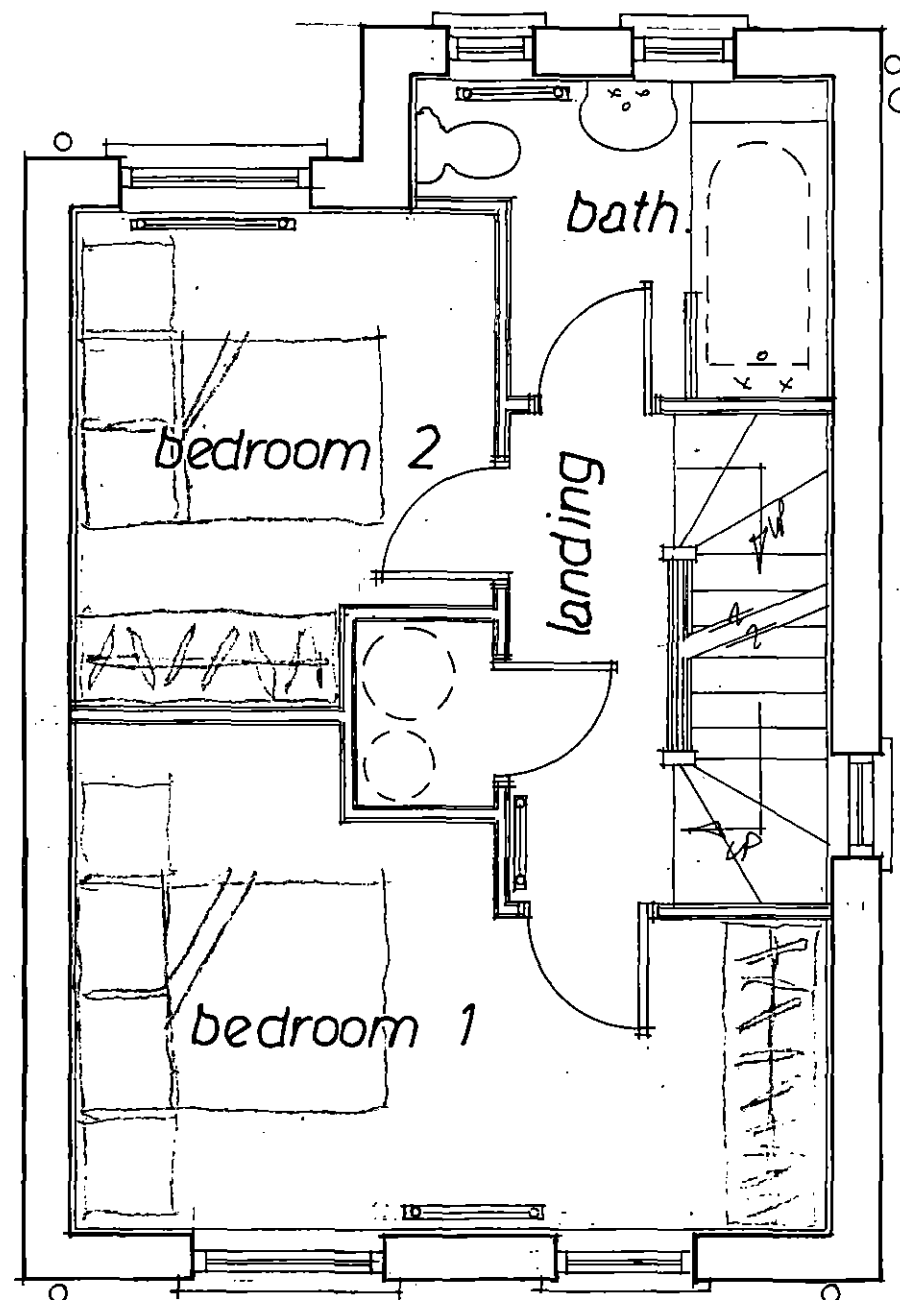

Rev	Notes	Date

Garry Greetham Associates

Residential
Design Consultant
Westwood House
18 Carr Lane
Tankersley
Barnsley S75 3BE
Tel 07786062364

PROJECT Residential Development

CLIENT Mr. Dave Gill

TITLE Plots 3 & 4 F. F. Layout


ADDRESS off Hunningley Close,
Stairfoot,
Barnsley. S70 3PH

DRAWN BY ggg

SCALE 1:50 @ A3 **DATE** Mar 25

DRAWING No 514-14 **REV**

Member of the Chartered Institute
of Architectural Technologists

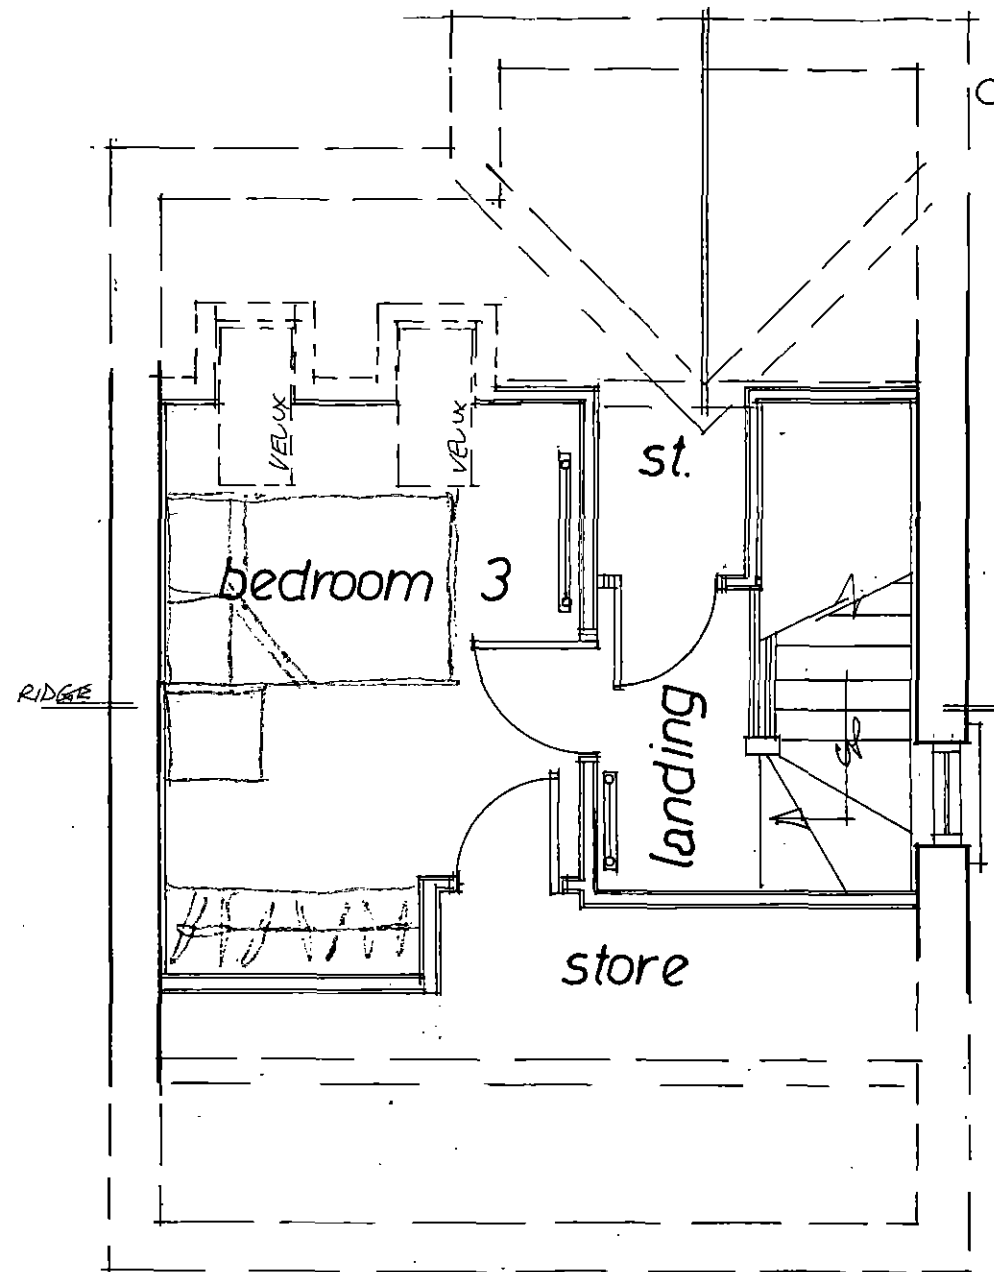

Rev	Notes	Date

Garry Greetham Associates
 Residential Design Consultant
 Westwood House
 18 Carr Lane
 Tankersley
 Barnsley S75 3BE
 Tel 07786062364

PROJECT	Residential Development	
CLIENT	Mr. Dave Gill	
TITLE	Plots 3 & 4 S. F. Layout	
ADDRESS	off Hunningley Close, Stairfoot, Barnsley. S703PH	
DRAWN BY	ggg	
SCALE	1:50 @ A3	DATE Mar 25
DRAWING No	514-15	REV

Member of the Chartered Institute of Architectural Technologists