




* Any plants found not to be in accordance with the specification above after post completion site inspection will be replaceable at contractors expense in accordance with substitutions paragraph of specification on drawing.

** Contractor to ensure numbers on plant schedules match numbers on drawing before placing order for plants.



- March - October: 20 litres to be poured into irrigation pipe two times per week (40 litres in total)

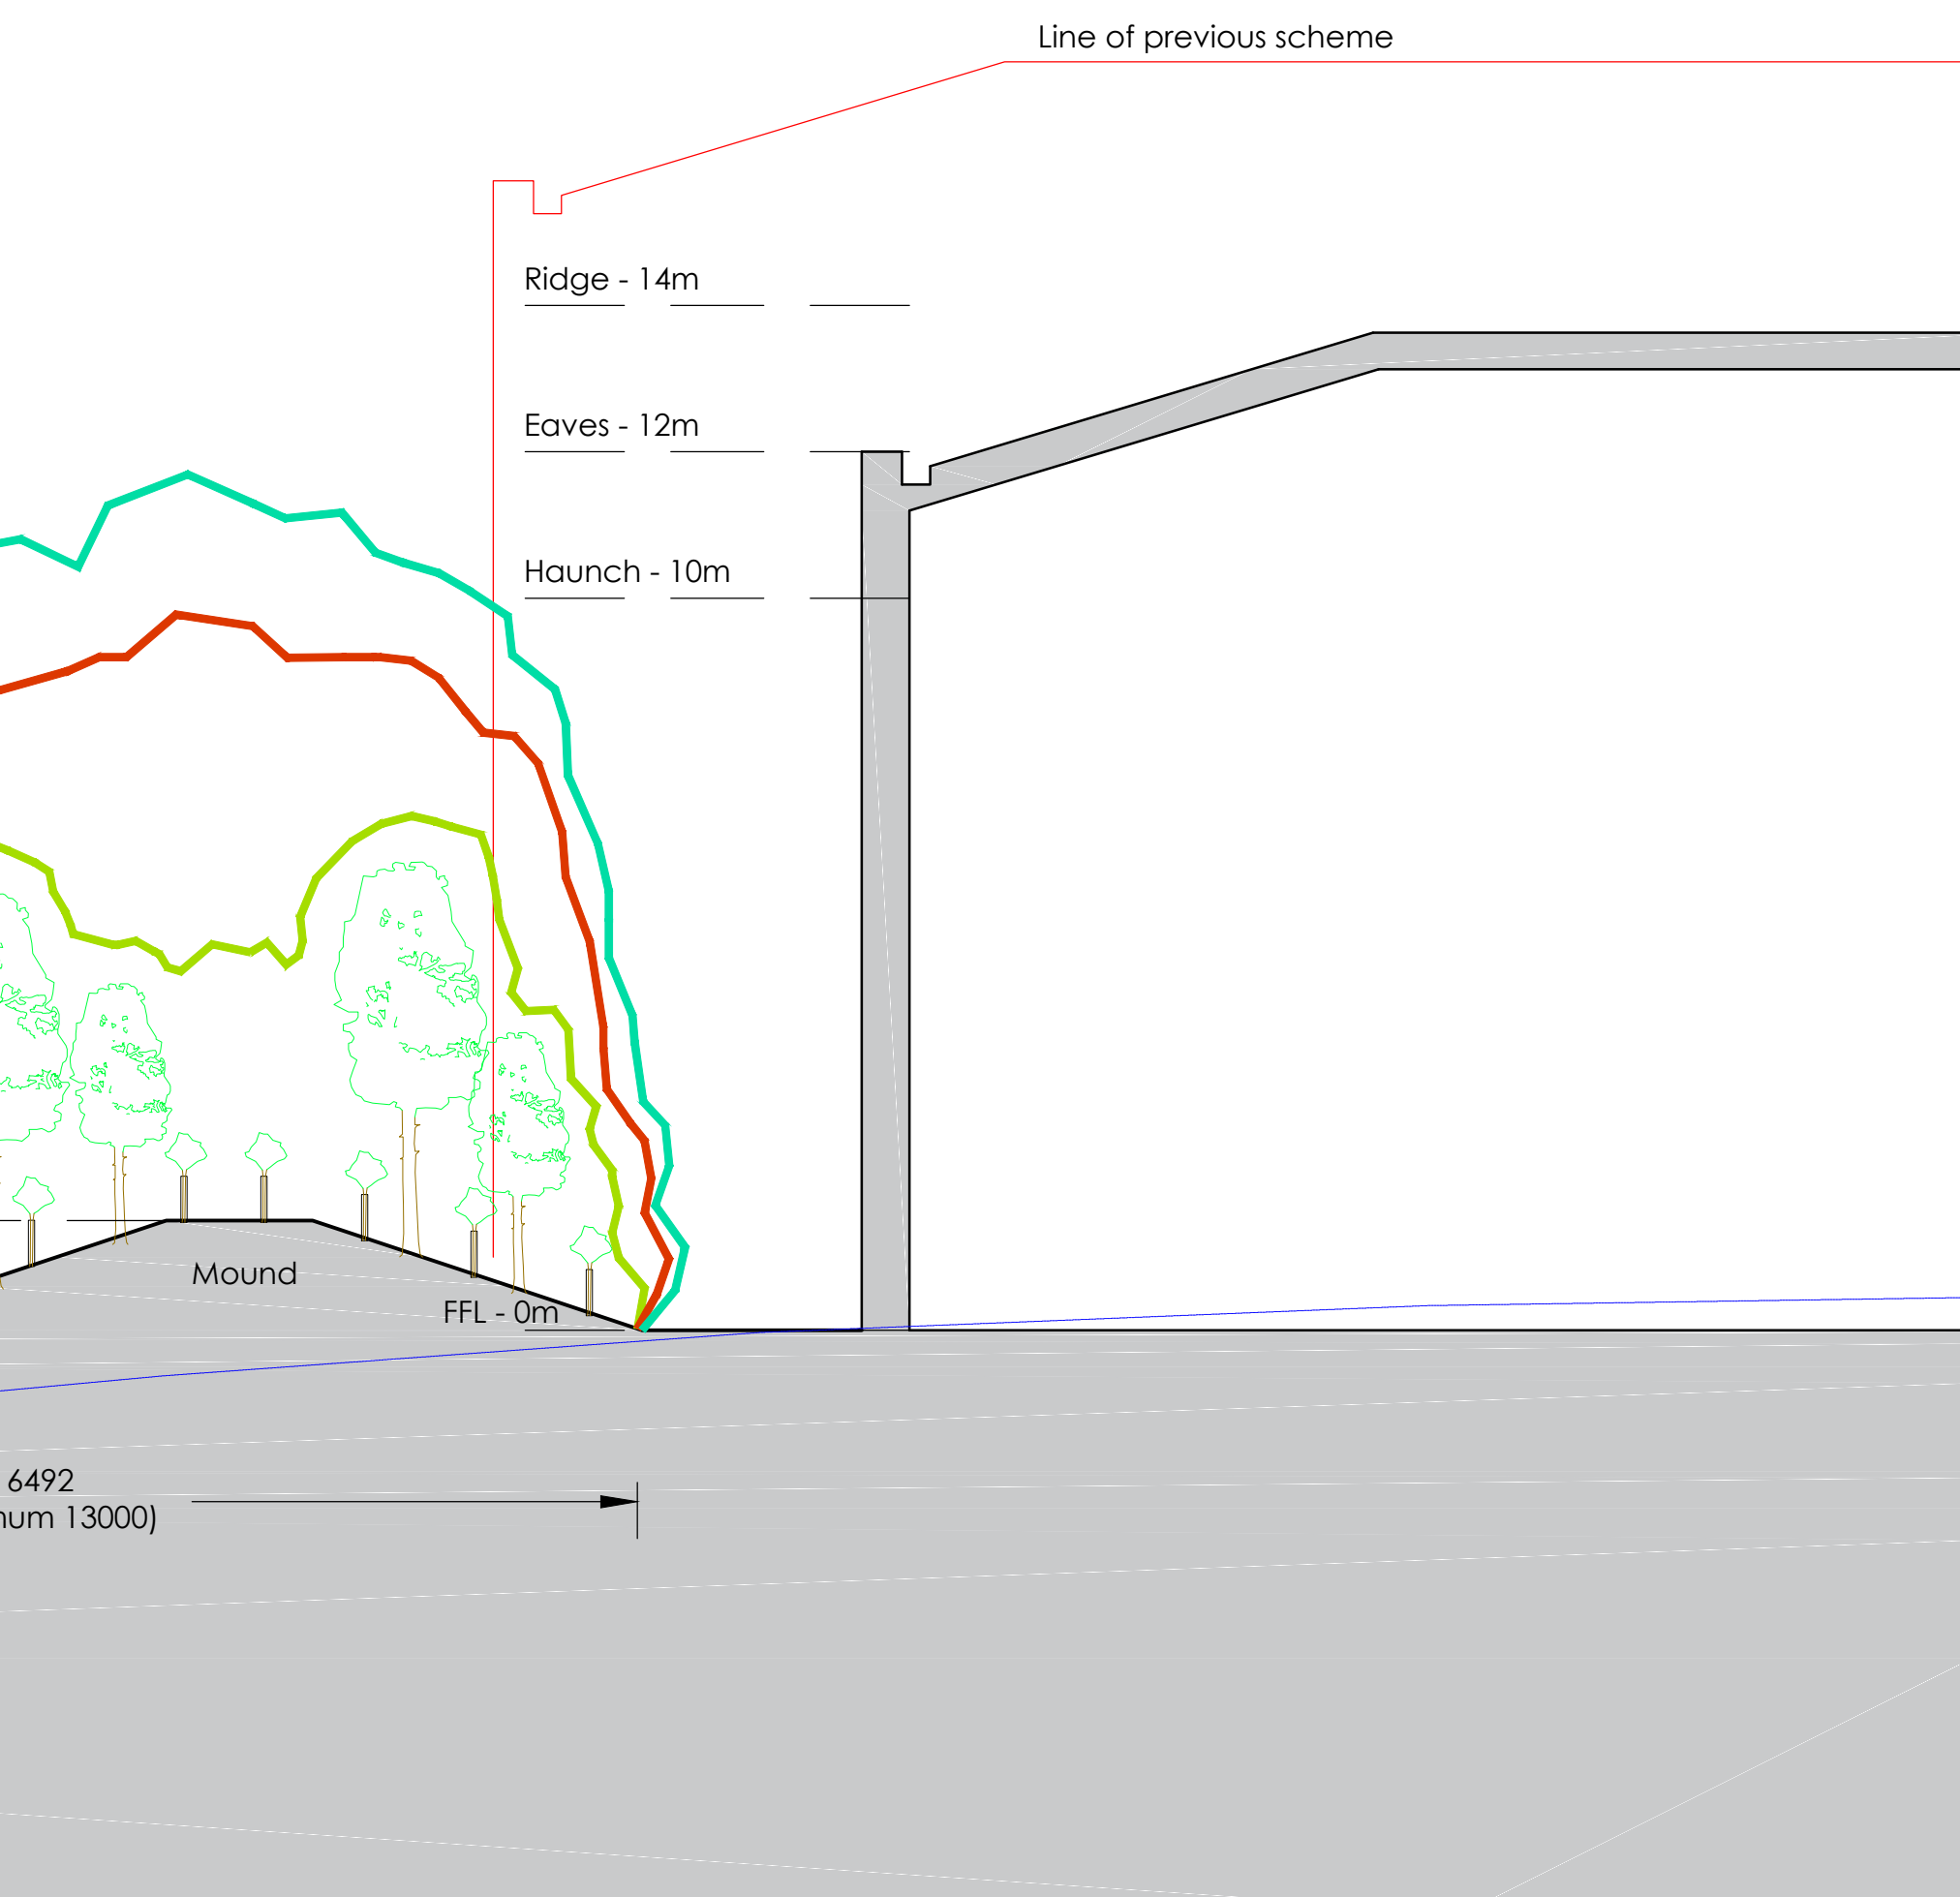

All proposed tree locations are subject to co-ordination with drainage layout and subject to modification depending on the location of underground services and utilities. Drainage engineer to co-ordinate services layout in conjunction with the landscape plan to avoid conflict as much as possible. Allowance to be made at tender stage for the possible requirement for roof barriers once the drainage layout is confirmed. CA to be informed immediately once this is available.

Project Title PROPOSED INDUSTRIAL DEVELOPMENT Capital Park Junction 37 M1 Higham Lane Bramley	23/08/2019 10:01 note added on per LPA comments PA1 AS Revisions Drawings
Client STERLING CAPITOL PLC	Drawing Title LANDSCAPE PLAN
Scale DRAFT FOR COMMENT	Job/DWG No. V111138A L01
Drawn By DW	 design concepts
Drawn By DW	LANDSCAPE DESIGNERS 4 ST JOHNS NORTH, WAKEFIELD, WF1 3QA, TEL 01924 330306 info@vectorfx.co.uk
Checked By AS	Date 07/19