


SITE LOCATION



 
Reproduced by permission of Ordnance Survey on behalf of the Controller of Her Majesty's Stationary Office
All rights reserved. © Crown Copyright licence no. 100062043

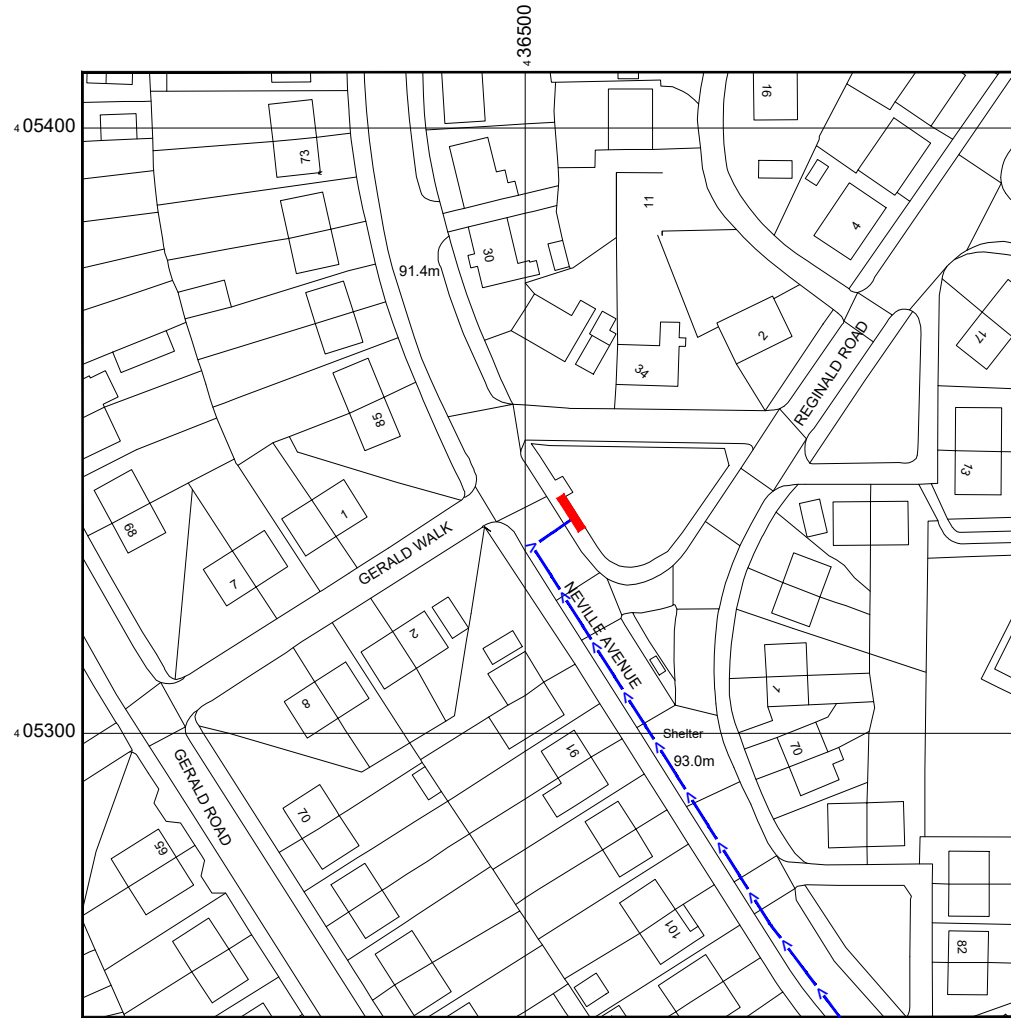


Reproduced by permission of Ordnance Survey on behalf of the Controller of Her Majesty's Stationary Office
All rights reserved. © Crown Copyright licence no. 100062043

NGR E: 436507 N: 405340

SITE AREA PLAN



SITE LOCATION PLAN

 

SITE PHOTOGRAPH



GOOGLE MAPS QR CODE

GOOGLE MAPS - <https://goo.gl/maps/NvsfFYTngCh2nmUK7>

GOOGLE STREETVIEW - <https://goo.gl/maps/t6Hqab3BgT8PHYgYA>

NOTES:

1. ALL DIMENSIONS IN MM UNLESS OTHERWISE NOTED.

DIRECTIONS TO SITE:

Head north on M1. At junction 36, take the A61 exit to Barnsley (South). At the roundabout, take the 3rd exit onto A61. Continue straight to stay on A61. At Birdwell Roundabout, take the 1st exit onto Sheffield Rd/A61. Turn right onto West St/B6100. Turn left onto Birk Ave. Turn right onto Neville Ave. Follow Neville Ave and site location is on the right hand side.

Site Provider's Property Boundary:



Access Route To Site:



Access Route:



Master: M002	MBNL / EE:	Project: 3UK DNSW	Purpose of Issue: Planning	Issue: B
Date: 26/06/2023	Drawn: CDN	Revision / Upgrade Description: Pole type changed to Phase 9		
Checked: DH	Approved: SD			
Master: M001	MBNL / EE:	Project: 3UK DNSW	Purpose of Issue: Planning	Issue: A
Date: 03/04/2023	Drawn: CDN	Revision / Upgrade Description: First Issue - Site nomination dated: TBC		
Checked: DH	Approved: SD			

CK Hutchison Networks (UK) Limited

Green Park
450 Longwater Avenue
Reading
RG30 3UR

Design Consultant & Principal Contractor:



WHP Telecoms
Unit 1 Maple Park,
Low Fields Avenue, Leeds
LS12 6HH

Tel: 01133023550
e-mail: info@whptelecoms.com

Site Name: NEVILLE AVENUE STREETWORKS

Site ID: BAR22944

Address: NEVILLE AVENUE, KENDRAY, BARNSELY, SOUTH YORKSHIRE MAYORAL COMBINED AUTHORITY, ENGLAND, S70 3HD


Title: 002 SITE LOCATION PLAN

Project: 3UK DNSW

Purpose of Issue: PLANNING

EE Cell ID: 95770	MBNL Cell ID: BAR162	Cell ID: S1408
-------------------	----------------------	----------------

Master Drawing No: BAR22944_M002	Issue: B
----------------------------------	----------

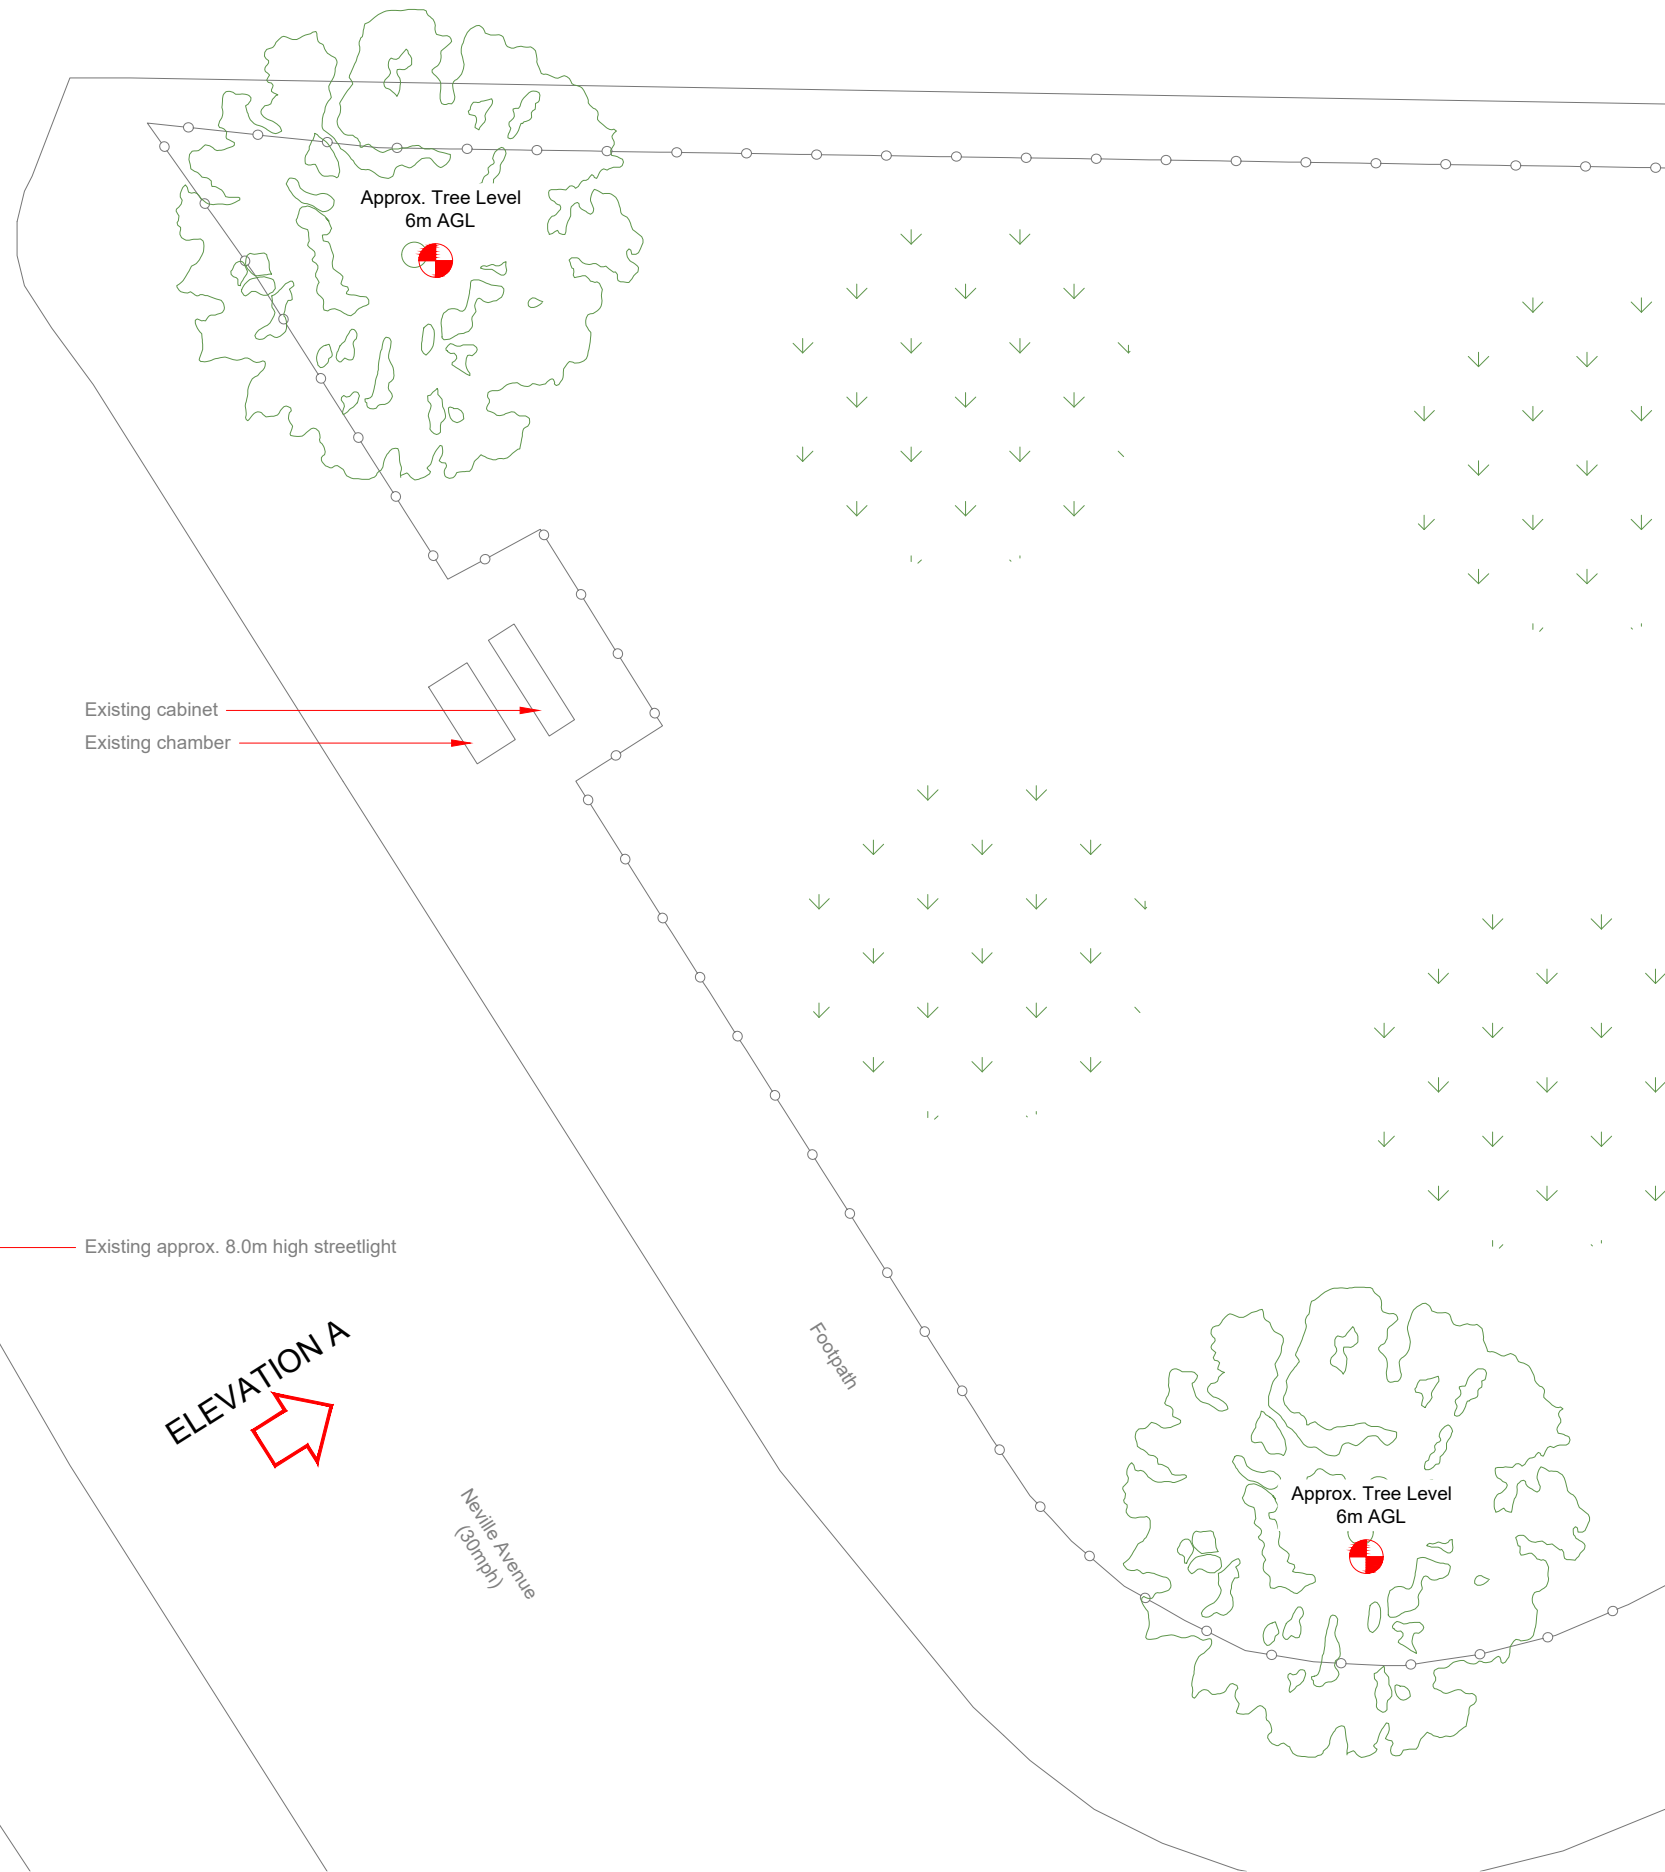


Existing cabinet
Existing chamber

Existing approx. 8.0m high streetlight

ELEVATION A

 EXISTING SITE PLAN



NOTES:

- ALL DIMENSIONS IN MM UNLESS OTHERWISE NOTED.

Master:	MBNL / EE:	Project:	Purpose of Issue:	Issue:
M002	MBNL	3UK DNSW	Planning	B
Date:	26/06/2023	Revision / Upgrade Description:		
Drawn:	CDN	Pole type changed to Phase 9		
Checked:	DH			
Approved:	SD			
Master:	MBNL / EE:	Project:	Purpose of Issue:	Issue:
M001	MBNL	3UK DNSW	Planning	A
Date:	03/04/2023	Revision / Upgrade Description:		
Drawn:	CDN	First Issue - Site nomination dated: TBC		
Checked:	DH			
Approved:	SD			

CK Hutchison Networks (UK) Limited

Green Park
450 Longwater Avenue
Reading
RG30 3UR

Design Consultant & Principal Contractor:



WHP Telecoms
Unit 1 Maple Park,
Low Fields Avenue, Leeds
LS12 6HH

Tel: 01133023550
e-mail: info@whptelecoms.com

Site Name: **NEVILLE AVENUE STREETWORKS**

Site ID: **BAR22944**

Address:
**NEVILLE AVENUE, KENDRAY, BARNSELY,
SOUTH YORKSHIRE MAYORAL
COMBINED AUTHORITY, ENGLAND,
S70 3HD**

Title: **100 EXISTING SITE PLAN**

Project: **3UK DNSW**

Purpose of Issue: **PLANNING**

EE Cell ID:	MBNL Cell ID:	Cell ID:
95770	BAR162	S1408

Master Drawing No:	Issue:
BAR22944_M002	B

NOTES:

1. ALL DIMENSIONS IN MM UNLESS OTHERWISE NOTED.

Master:	MBNL / EE:	Project:	Purpose of Issue:	Issue:
M002	MBNL	3UK DNSW	Planning	B
Date:	26/06/2023	Revision / Upgrade Description:		
Drawn:	CDN	Pole type changed to Phase 9		
Checked:	DH			
Approved:	SD			
Master:	MBNL / EE:	Project:	Purpose of Issue:	Issue:
M001	MBNL	3UK DNSW	Planning	A
Date:	03/04/2023	Revision / Upgrade Description:		
Drawn:	CDN	First Issue - Site nomination dated: TBC		
Checked:	DH			
Approved:	SD			

**CK Hutchison
Networks (UK)
Limited**

Green Park
450 Longwater Avenue
Reading
RG30 3UR

Design Consultant & Principal Contractor:



WHP Telecoms
Unit 1 Maple Park,
Low Fields Avenue, Leeds
LS12 6HH

Tel: 01133023550
e-mail: info@whptelecoms.com

Site Name:
NEVILLE AVENUE STREETWORKS

Site ID:
BAR22944

Address:
**NEVILLE AVENUE, KENDRAY, BARNESLEY,
SOUTH YORKSHIRE MAYORAL
COMBINED AUTHORITY, ENGLAND,
S70 3HD**


Title:
150 EXISTING ELEVATION A

Project:
3UK DNSW


Purpose of Issue:
PLANNING

EE Cell ID: 95770	MBNL Cell ID: BAR162	Cell ID: S1408
-----------------------------	--------------------------------	--------------------------

Master Drawing No: BAR22944_M002	Issue: B
--	--------------------

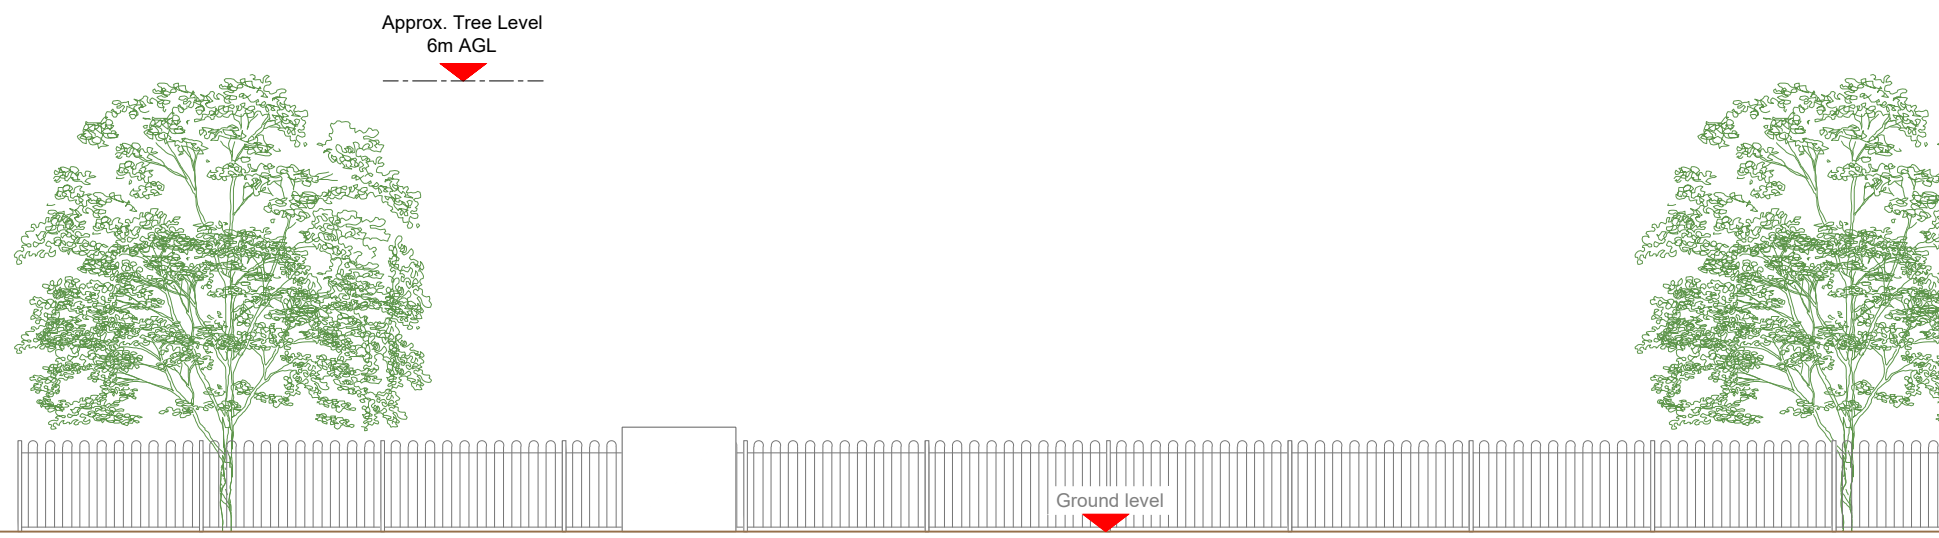

EXISTING ELEVATION A

 


100mm
50mm
10mm




Antenna Aperture ID	Proposed 4G/5G Bearing
A1	40°
B1	160°
C1	280°
A2	40°
B2	160°
C2	280°

NOTES:
1. ALL DIMENSIONS IN MM UNLESS OTHERWISE NOTED.

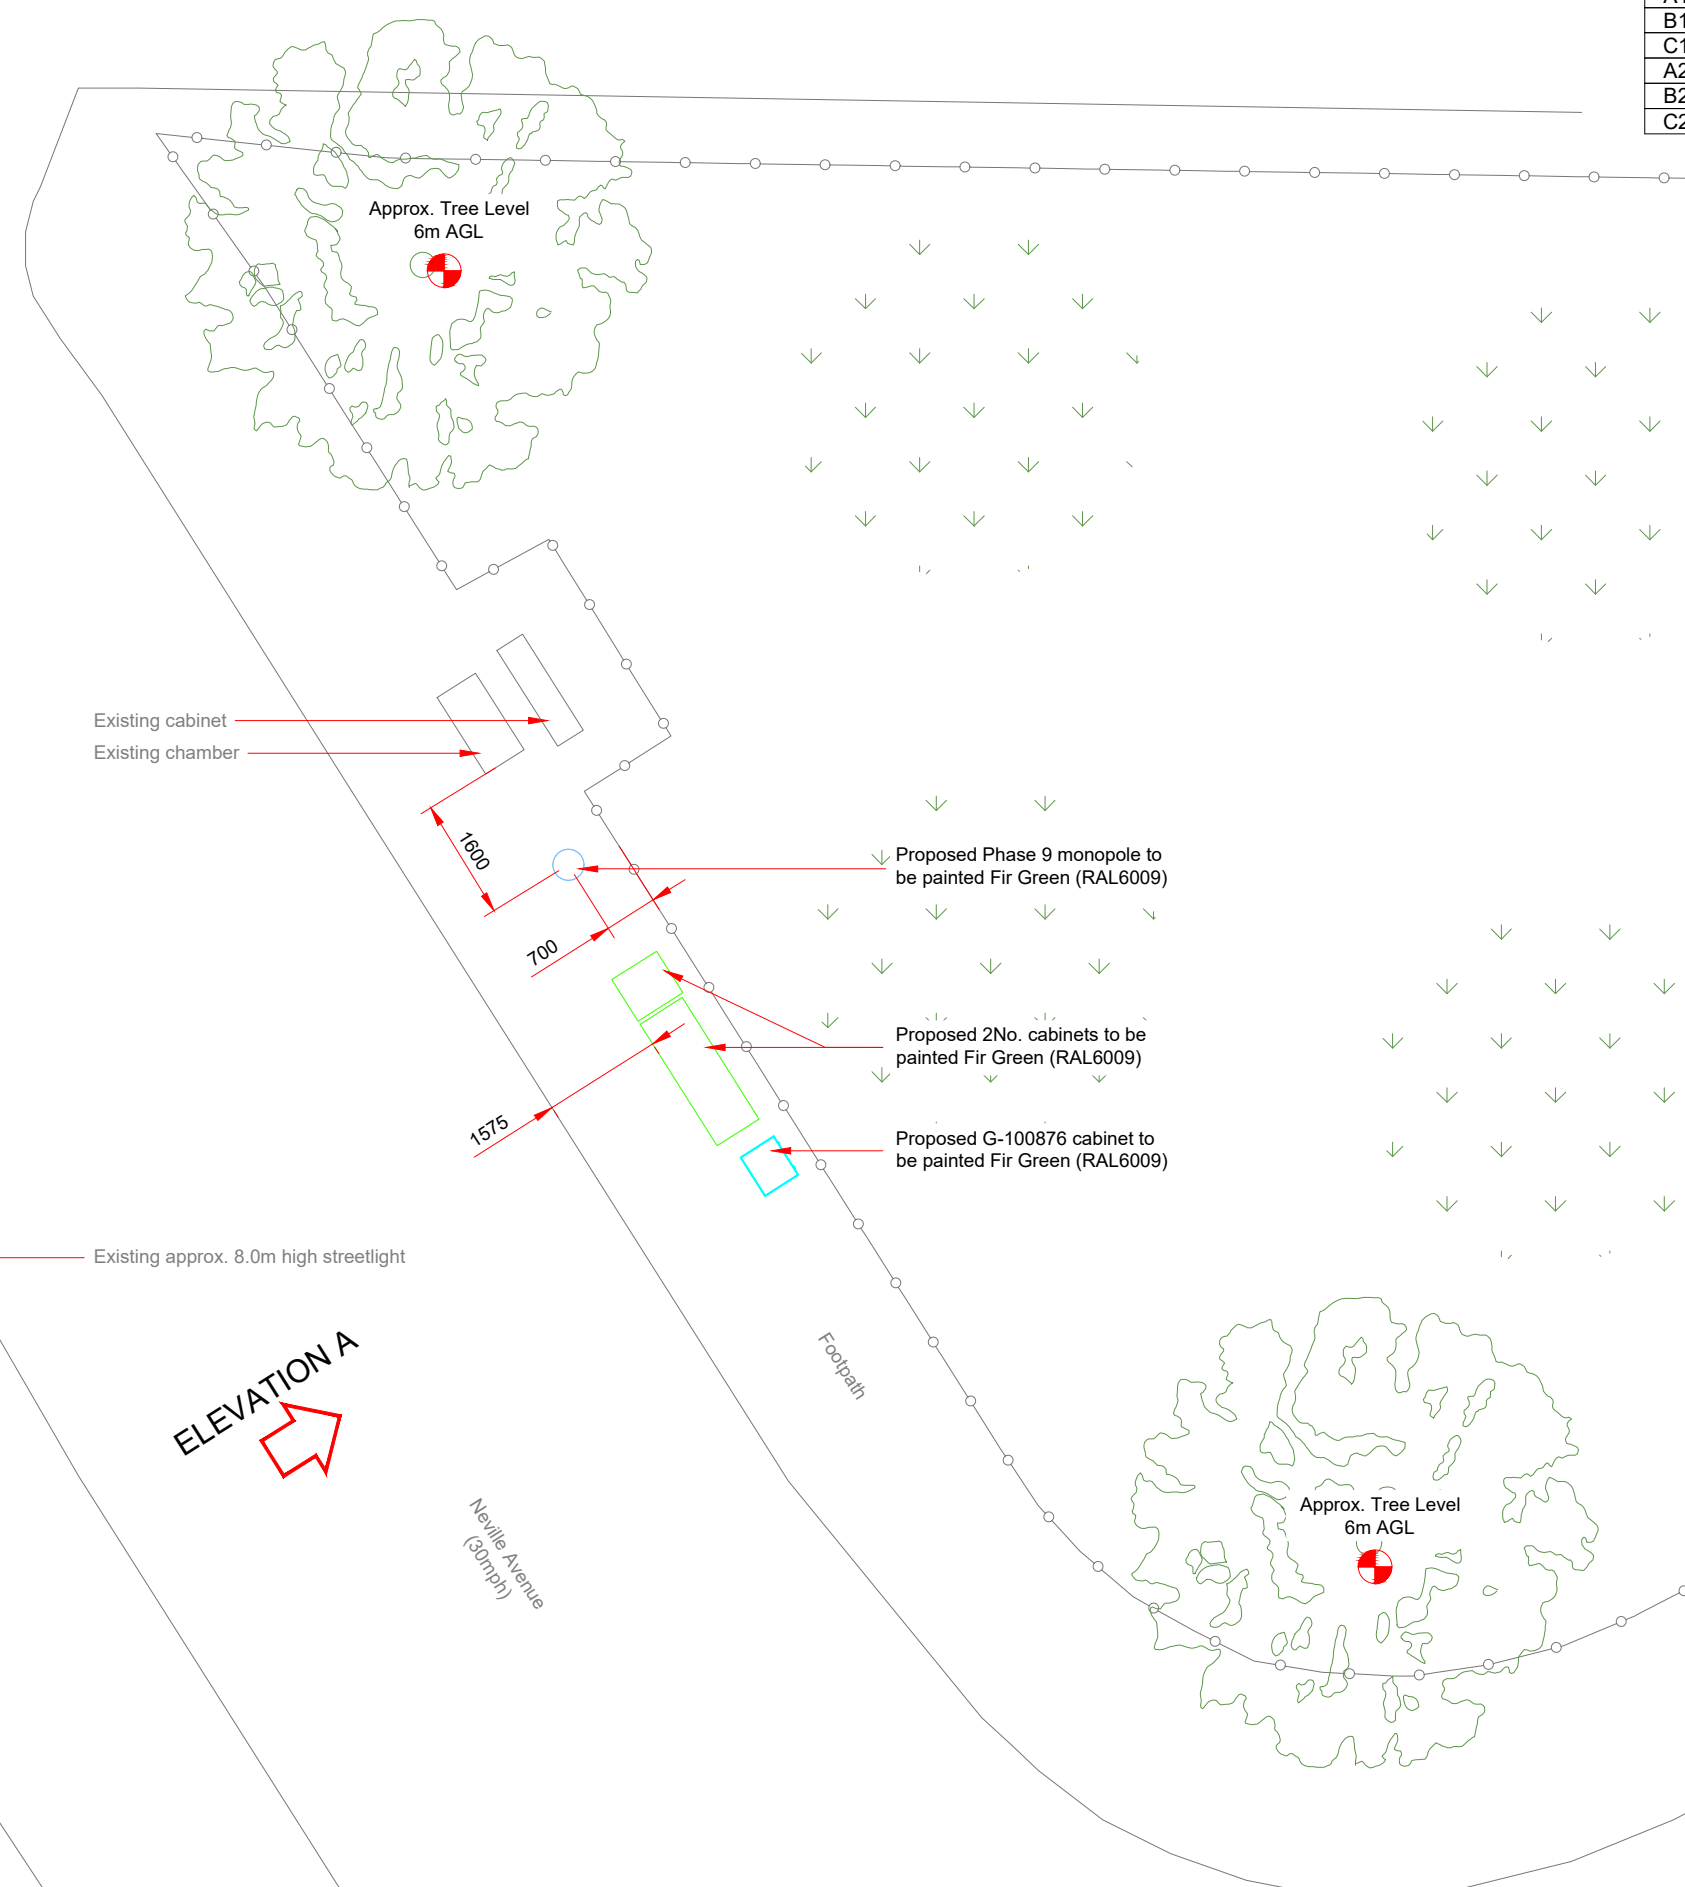

100mm
50mm
10mm

 

Master	MBNL / EE	Project	Purpose of Issue	Issue
M002	MBNL	3UK DNSW	Planning	B
Date: 26/06/2023		Revision / Upgrade Description: Pole type changed to Phase 9		
Drawn: CDN		Checked: DH		
Approved: SD				
Master	MBNL / EE	Project	Purpose of Issue	Issue
M001	MBNL	3UK DNSW	Planning	A
Date: 03/04/2023		Revision / Upgrade Description: First Issue - Site nomination dated: TBC		
Drawn: CDN		Checked: DH		
Approved: SD				

CK Hutchison Networks (UK) Limited
Green Park
450 Longwater Avenue
Reading
RG30 3UR

Design Consultant & Principal Contractor:
 **WHP Telecoms**
Unit 1 Maple Park,
Low Fields Avenue, Leeds
LS12 6HH
Tel: 01133023550
e-mail: info@whptelecoms.com

Site Name: **NEVILLE AVENUE STREETWORKS**

Site ID: **BAR22944**

Address: **NEVILLE AVENUE, KENDRAY, BARNSELY, SOUTH YORKSHIRE MAYORAL COMBINED AUTHORITY, ENGLAND, S70 3HD**

Title: **210 PROPOSED SITE PLAN**

Project: **3UK DNSW**

Purpose of Issue: **PLANNING**

EE Cell ID: 95770	MBNL Cell ID: BAR162	Cell ID: S1408
-----------------------------	--------------------------------	--------------------------


Master Drawing No: **BAR22944_M002** Issue: **B**




Antenna Aperture ID	Proposed 4G/5G Bearing
A1	40°
B1	160°
C1	280°
A2	40°
B2	160°
C2	280°

NOTES:

- ALL DIMENSIONS IN MM UNLESS OTHERWISE NOTED.

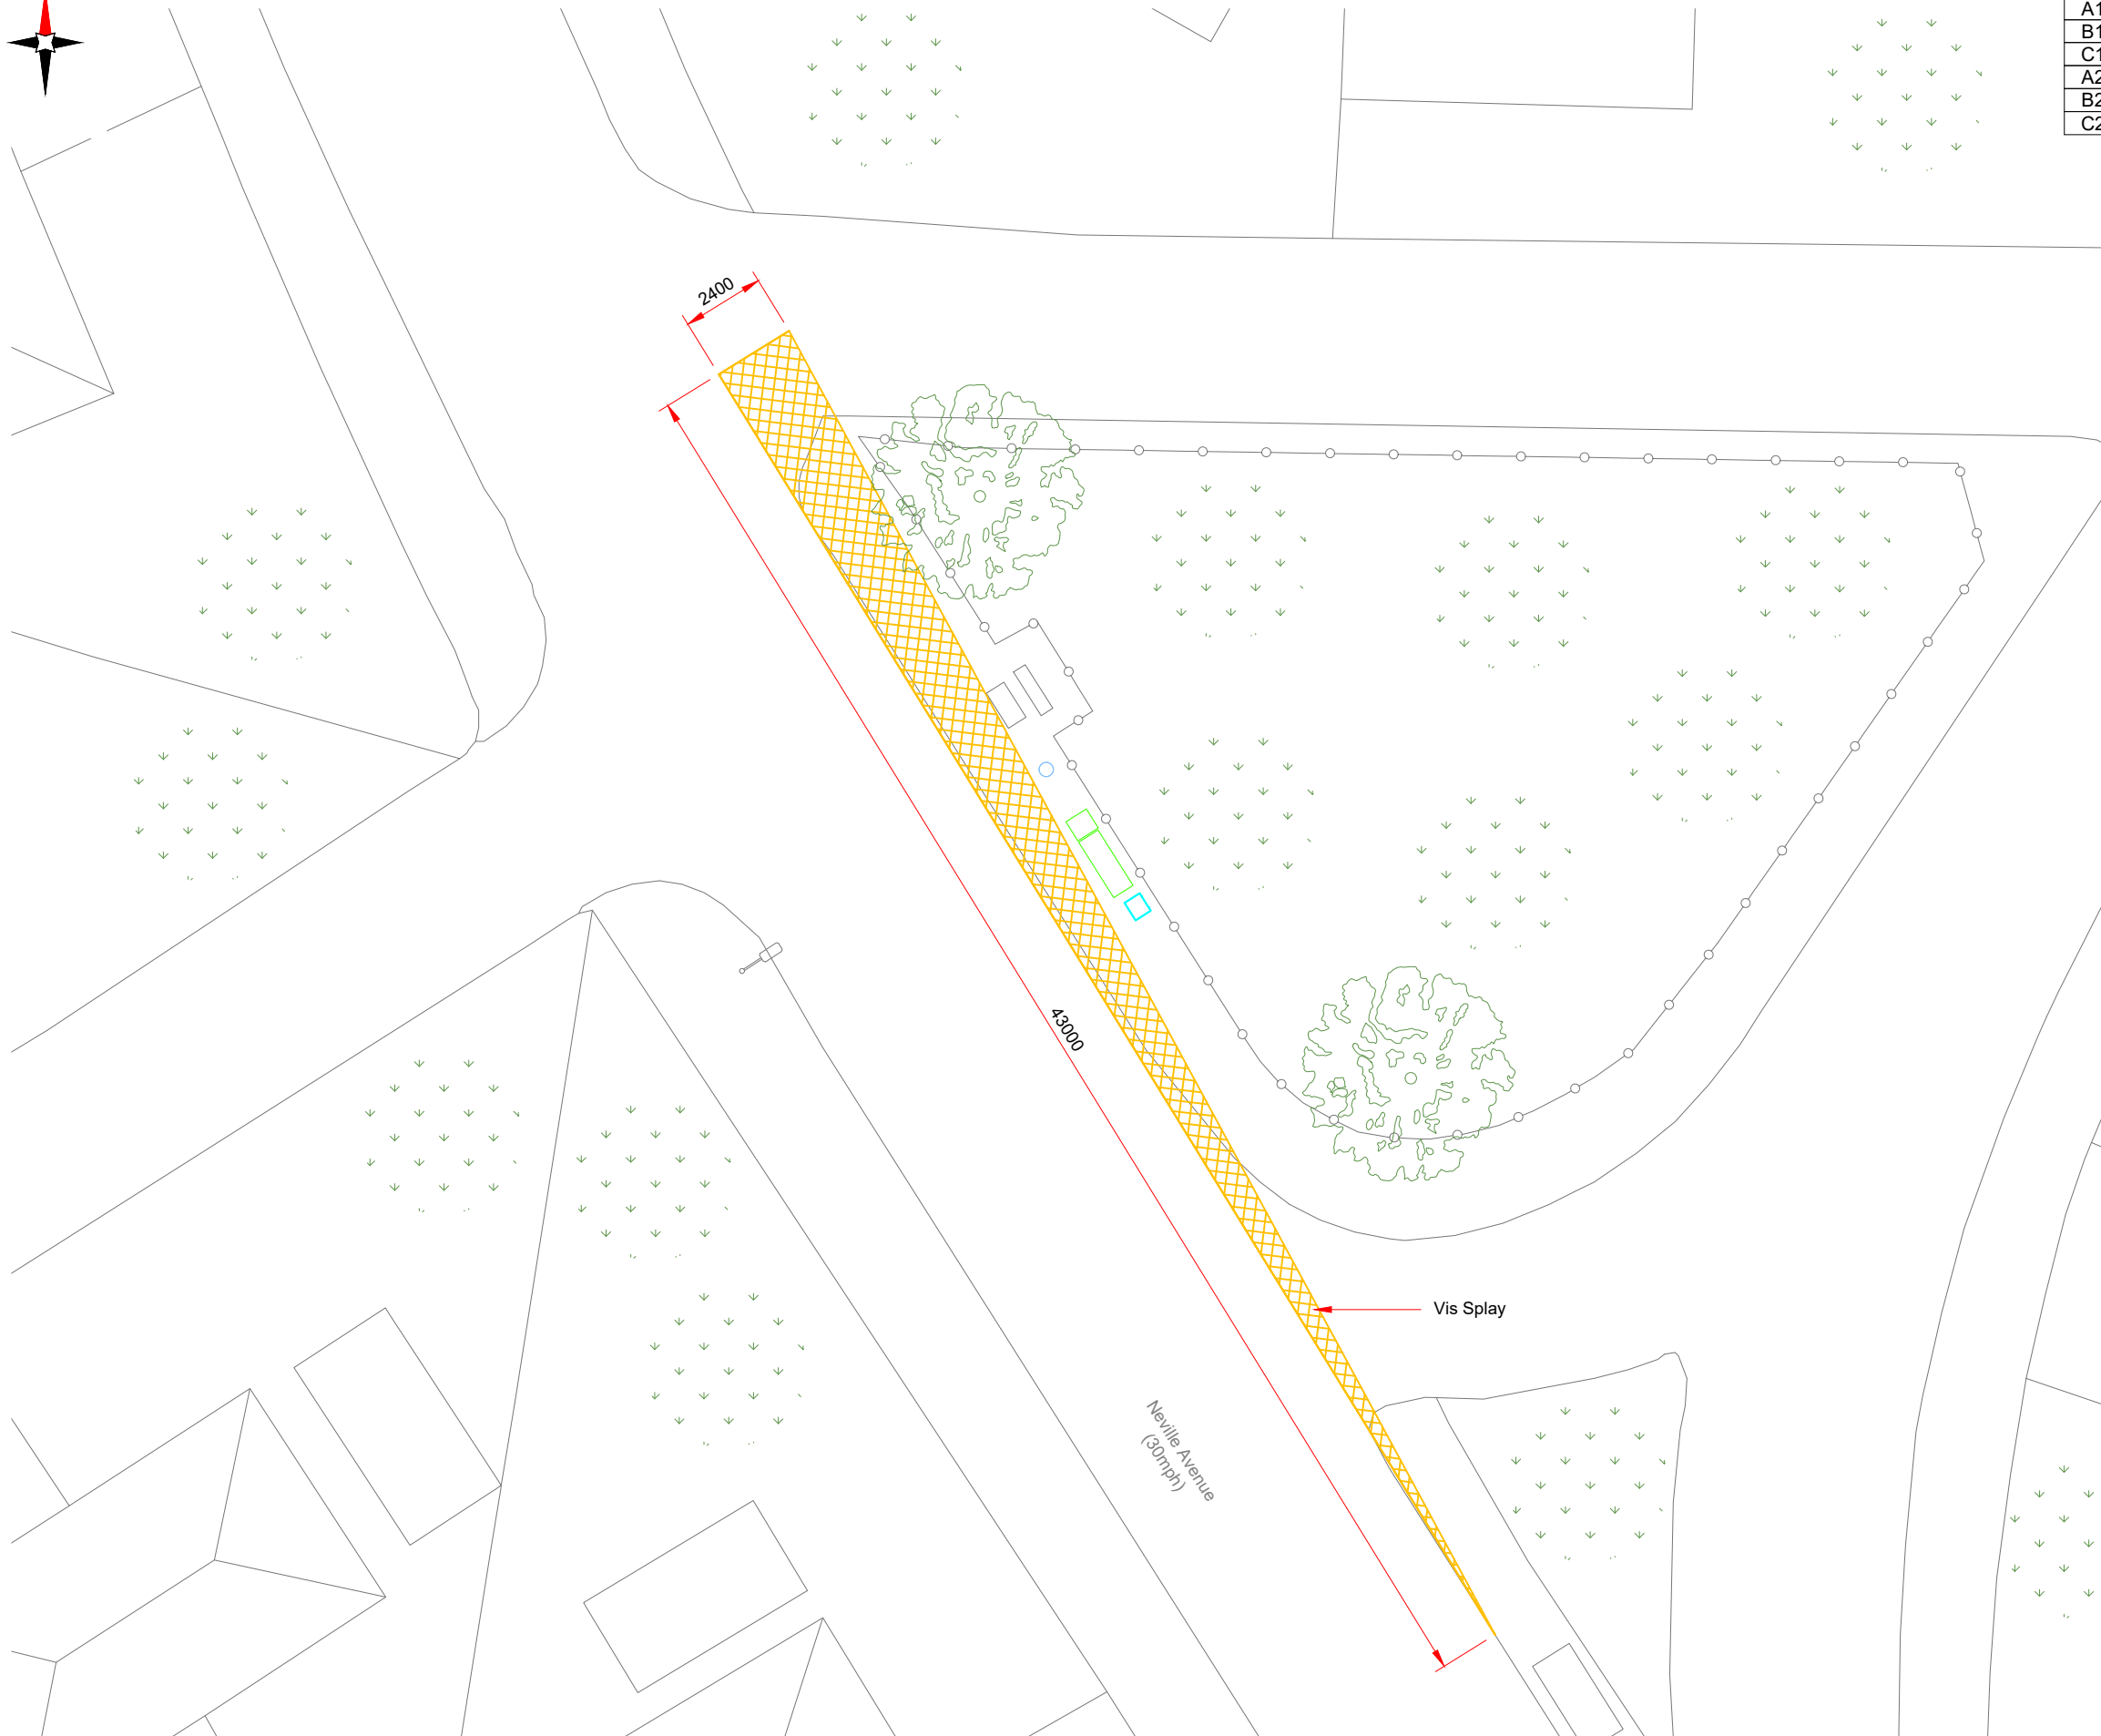

VIS SPLAY PLAN

 

Master: M002	MBNL / EE:	Project: 3UK DNSW	Purpose of Issue: Planning	Issue: B
Date: 26/06/2023	Revision / Upgrade Description: Pole type changed to Phase 9			
Drawn: CDN	Checked: DH			
Approved: SD				
Master: M001	MBNL / EE:	Project: 3UK DNSW	Purpose of Issue: Planning	Issue: A
Date: 03/04/2023	Revision / Upgrade Description: First Issue - Site nomination dated: TBC			
Drawn: CDN	Checked: DH			
Approved: SD				

CK Hutchison Networks (UK) Limited

Green Park
450 Longwater Avenue
Reading
RG30 3UR

Design Consultant & Principal Contractor:



WHP Telecoms
Unit 1 Maple Park,
Low Fields Avenue, Leeds
LS12 6HH

Tel: 01133023550
e-mail: info@whptelecoms.com

Site Name: **NEVILLE AVENUE STREETWORKS**

Site ID: **BAR22944**

Address: **NEVILLE AVENUE, KENDRAY, BARNSELY, SOUTH YORKSHIRE MAYORAL COMBINED AUTHORITY, ENGLAND, S70 3HD**

Title: **211 VIS SPLAY PLAN**

Project: **3UK DNSW**


Purpose of Issue: **PLANNING**

EE Cell ID: 95770	MBNL Cell ID: BAR162	Cell ID: S1408
--------------------------	-----------------------------	-----------------------

Master Drawing No: BAR22944_M002	Issue: B
---	-----------------

Antenna Aperture ID	Proposed 4G/5G Bearing
A1	40°
B1	160°
C1	280°
A2	40°
B2	160°
C2	280°

NOTES:
1. ALL DIMENSIONS IN MM UNLESS OTHERWISE NOTED.

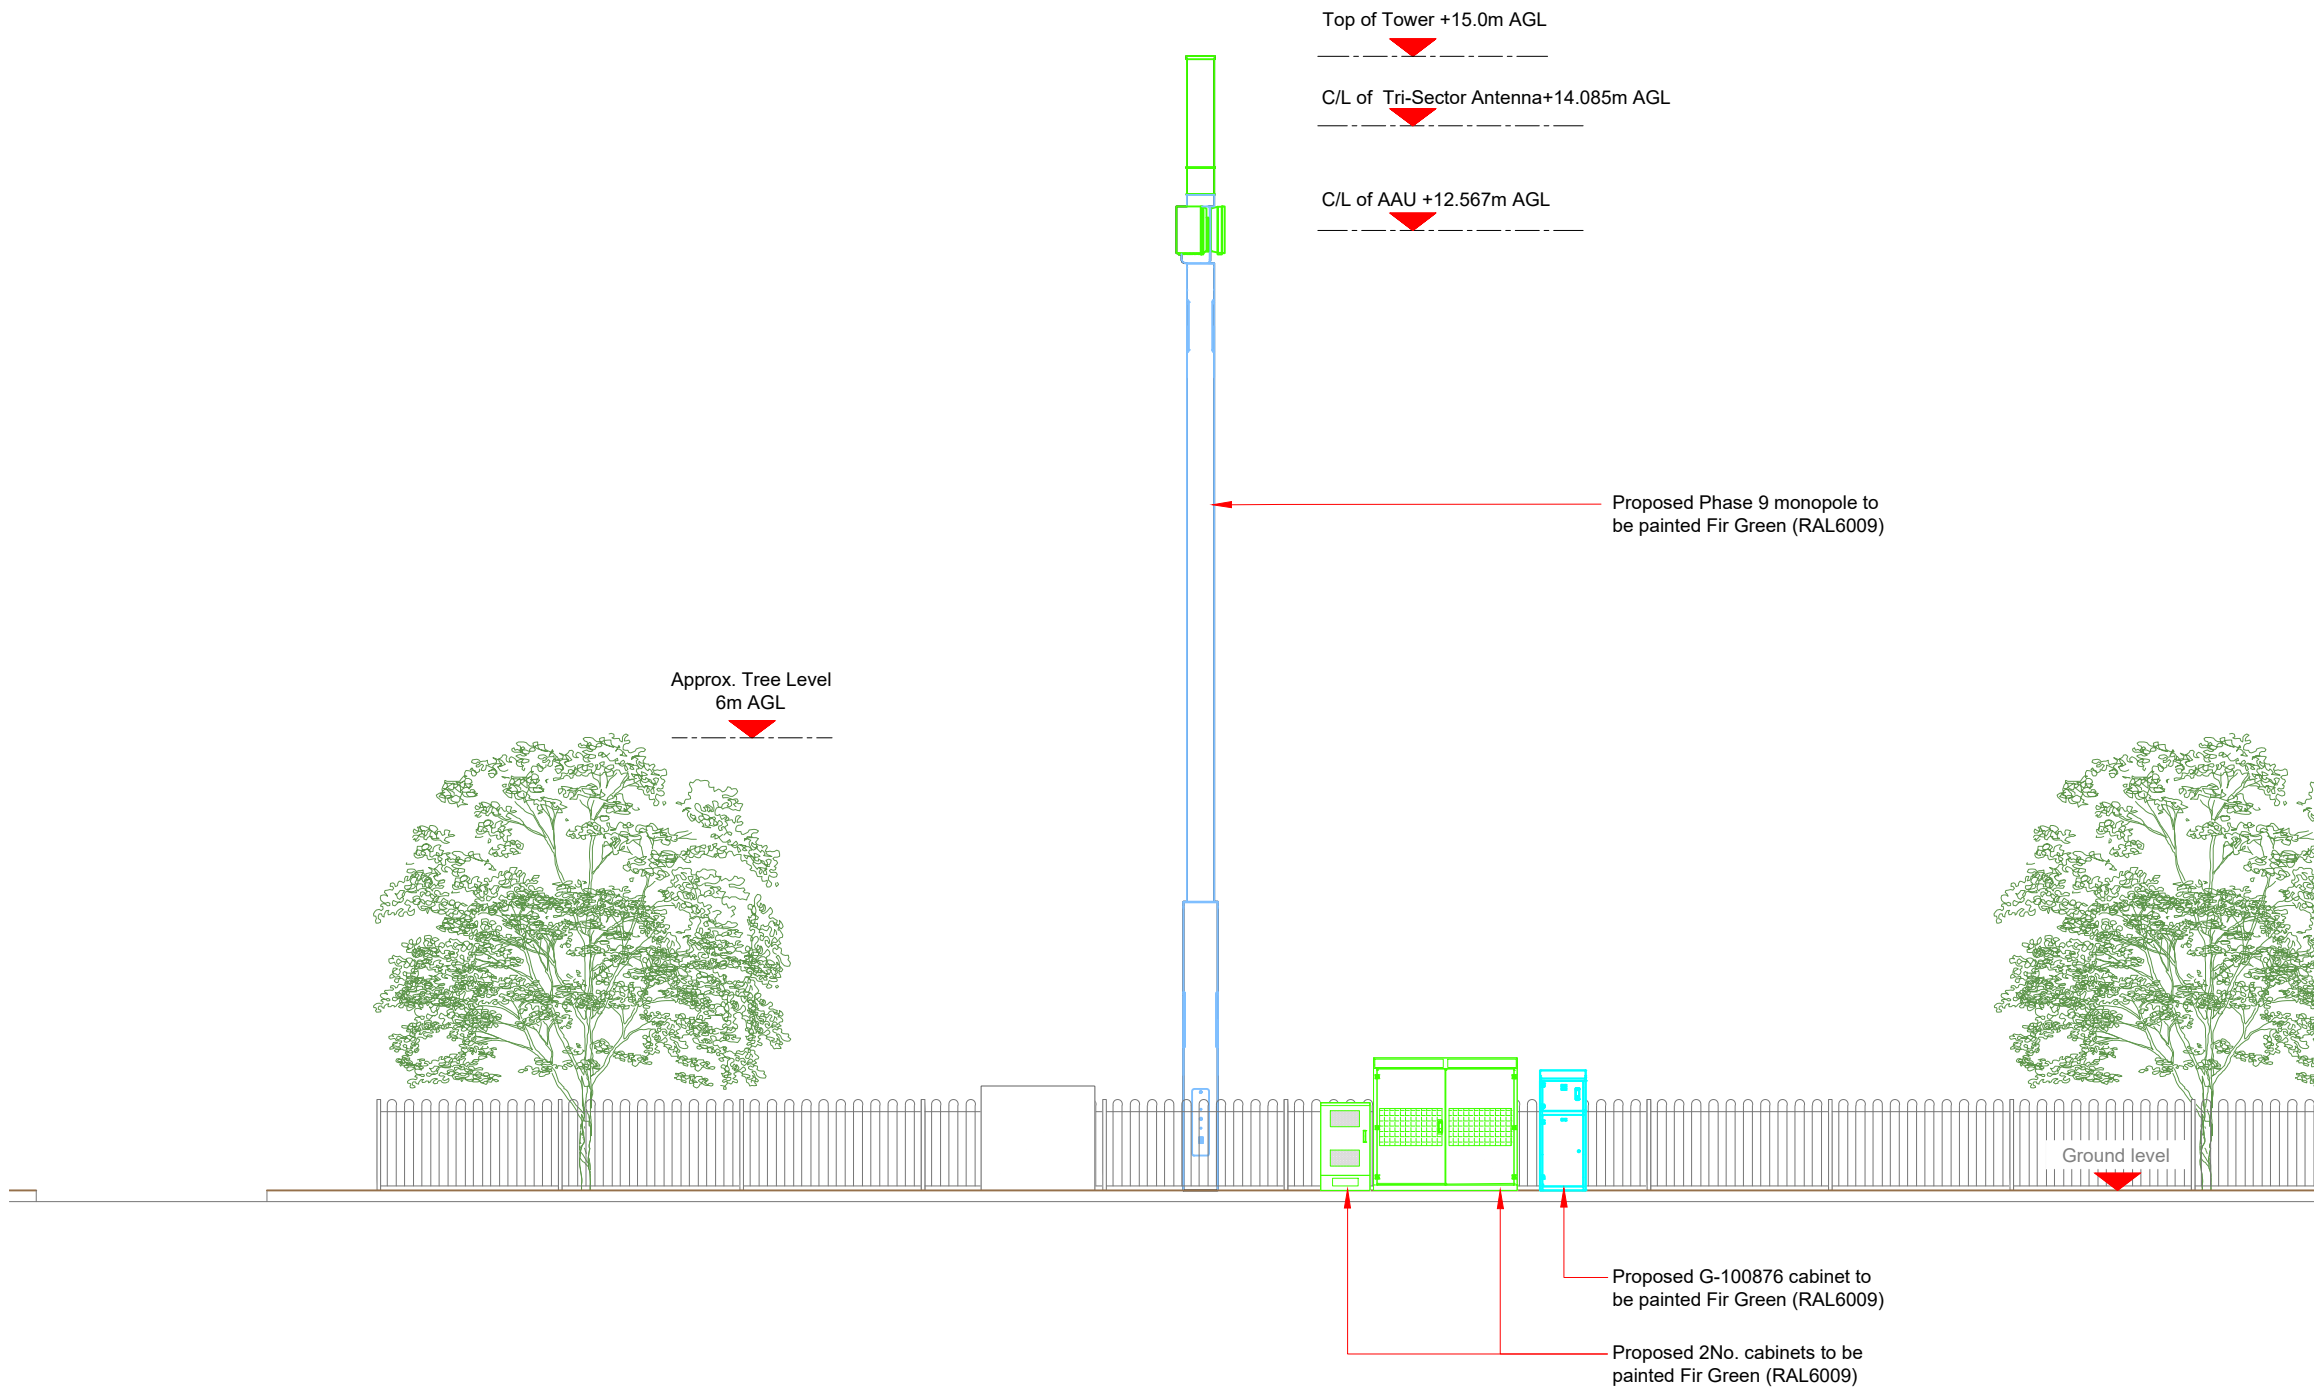


Proposed Phase 9 monopole to be painted Fir Green (RAL6009)

Proposed G-100876 cabinet to be painted Fir Green (RAL6009)

Proposed 2No. cabinets to be painted Fir Green (RAL6009)

 100mm
50mm
10mm




Master	MBNL / EE	Project	Purpose of Issue	Issue
M002	MBNL	3UK DNSW	Planning	B
Date: 26/06/2023		Revision / Upgrade Description: Pole type changed to Phase 9		
Drawn: CDN		Checked: DH		
Approved: SD				
M001	MBNL	3UK DNSW	Planning	A
Date: 03/04/2023		Revision / Upgrade Description: First Issue - Site nomination dated: TBC		
Drawn: CDN		Checked: DH		
Approved: SD				

CK Hutchison Networks (UK) Limited

Green Park
450 Longwater Avenue
Reading
RG30 3UR

Design Consultant & Principal Contractor:



WHP Telecoms
Unit 1 Maple Park,
Low Fields Avenue, Leeds
LS12 6HH
Tel: 01133023550
e-mail: info@whptelecoms.com

Site Name: **NEVILLE AVENUE STREETWORKS**

Site ID: **BAR22944**

Address: **NEVILLE AVENUE, KENDRAY, BARNSELY, SOUTH YORKSHIRE MAYORAL COMBINED AUTHORITY, ENGLAND, S70 3HD**

Title: **260 PROPOSED ELEVATION**

Project: **3UK DNSW**

Purpose of Issue: **PLANNING**

EE Cell ID:	MBNL Cell ID:	Cell ID:
95770	BAR162	S1408

Master Drawing No: **BAR22944_M002** Issue: **B**