


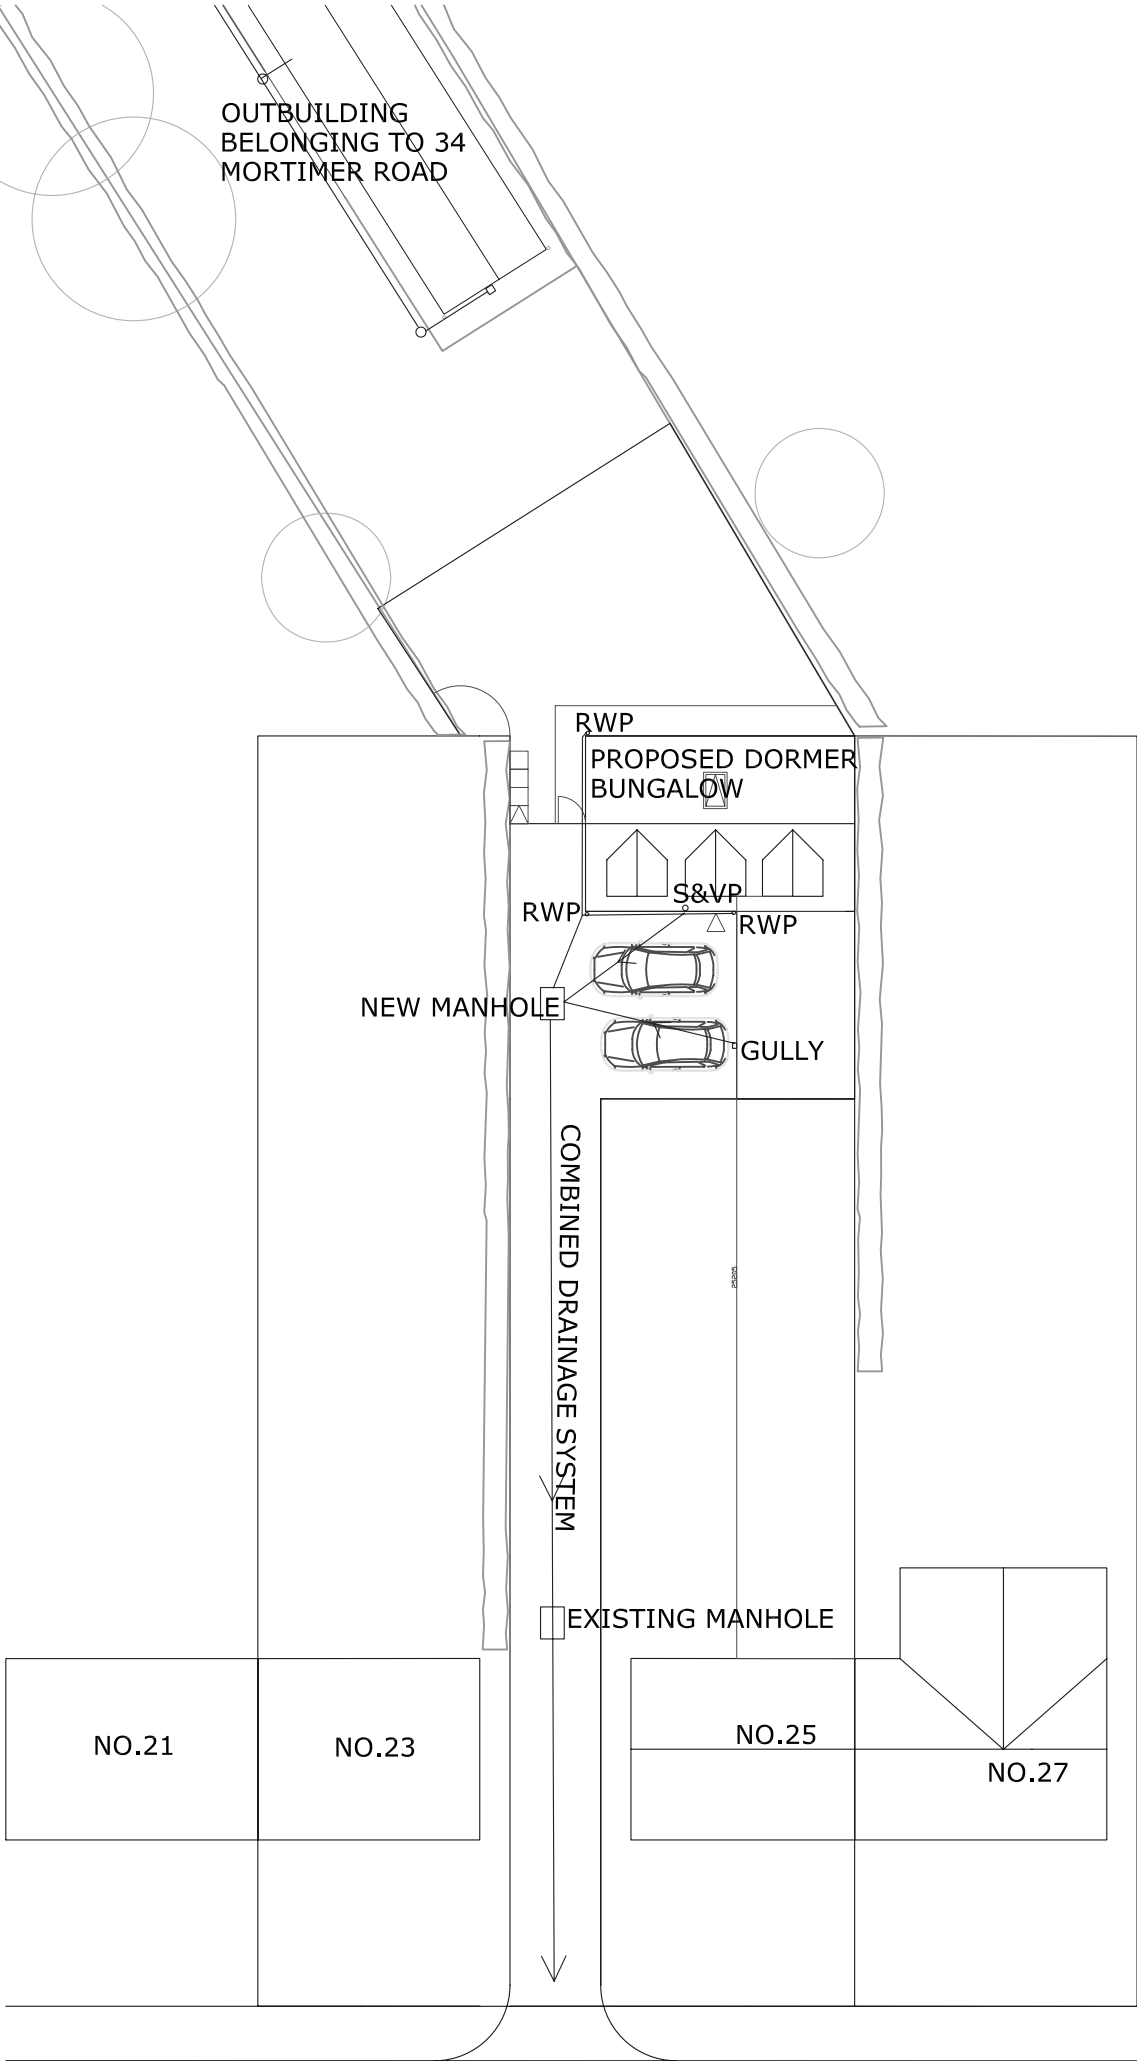

PROPOSED SITE LAYOUT

<u>SITE</u> 23A HACKING AVENUE, CUBLEY	
<u>CLIENT</u> MR S RICHARDSON	
<u>DRAWING TITLE</u> PROPOSED DRAINAGE LAYOUT	
<u>DRAWING NO.</u> 44A/04	<u>SCALE</u> 1:250 @A3
<u>DATE</u> 29/09/2024	<u>REVISION</u> /