


Contractor must verify all dimensions on site before commencing any work or shop drawings. If this drawing exceeds the quantities taken in any way, the building designers are to be informed before the work is initiated.
Only figured dimensions to be taken from this drawing. Do not scale off this drawing.
Drawing based on Ordnance Survey and/or existing record drawings - design and drawing content subject to Site Survey, Structural Survey, Site Investigations, Planning and Statutory Requirements and Approvals.
All drainage layouts are schematic and invert levels must be established prior to construction.

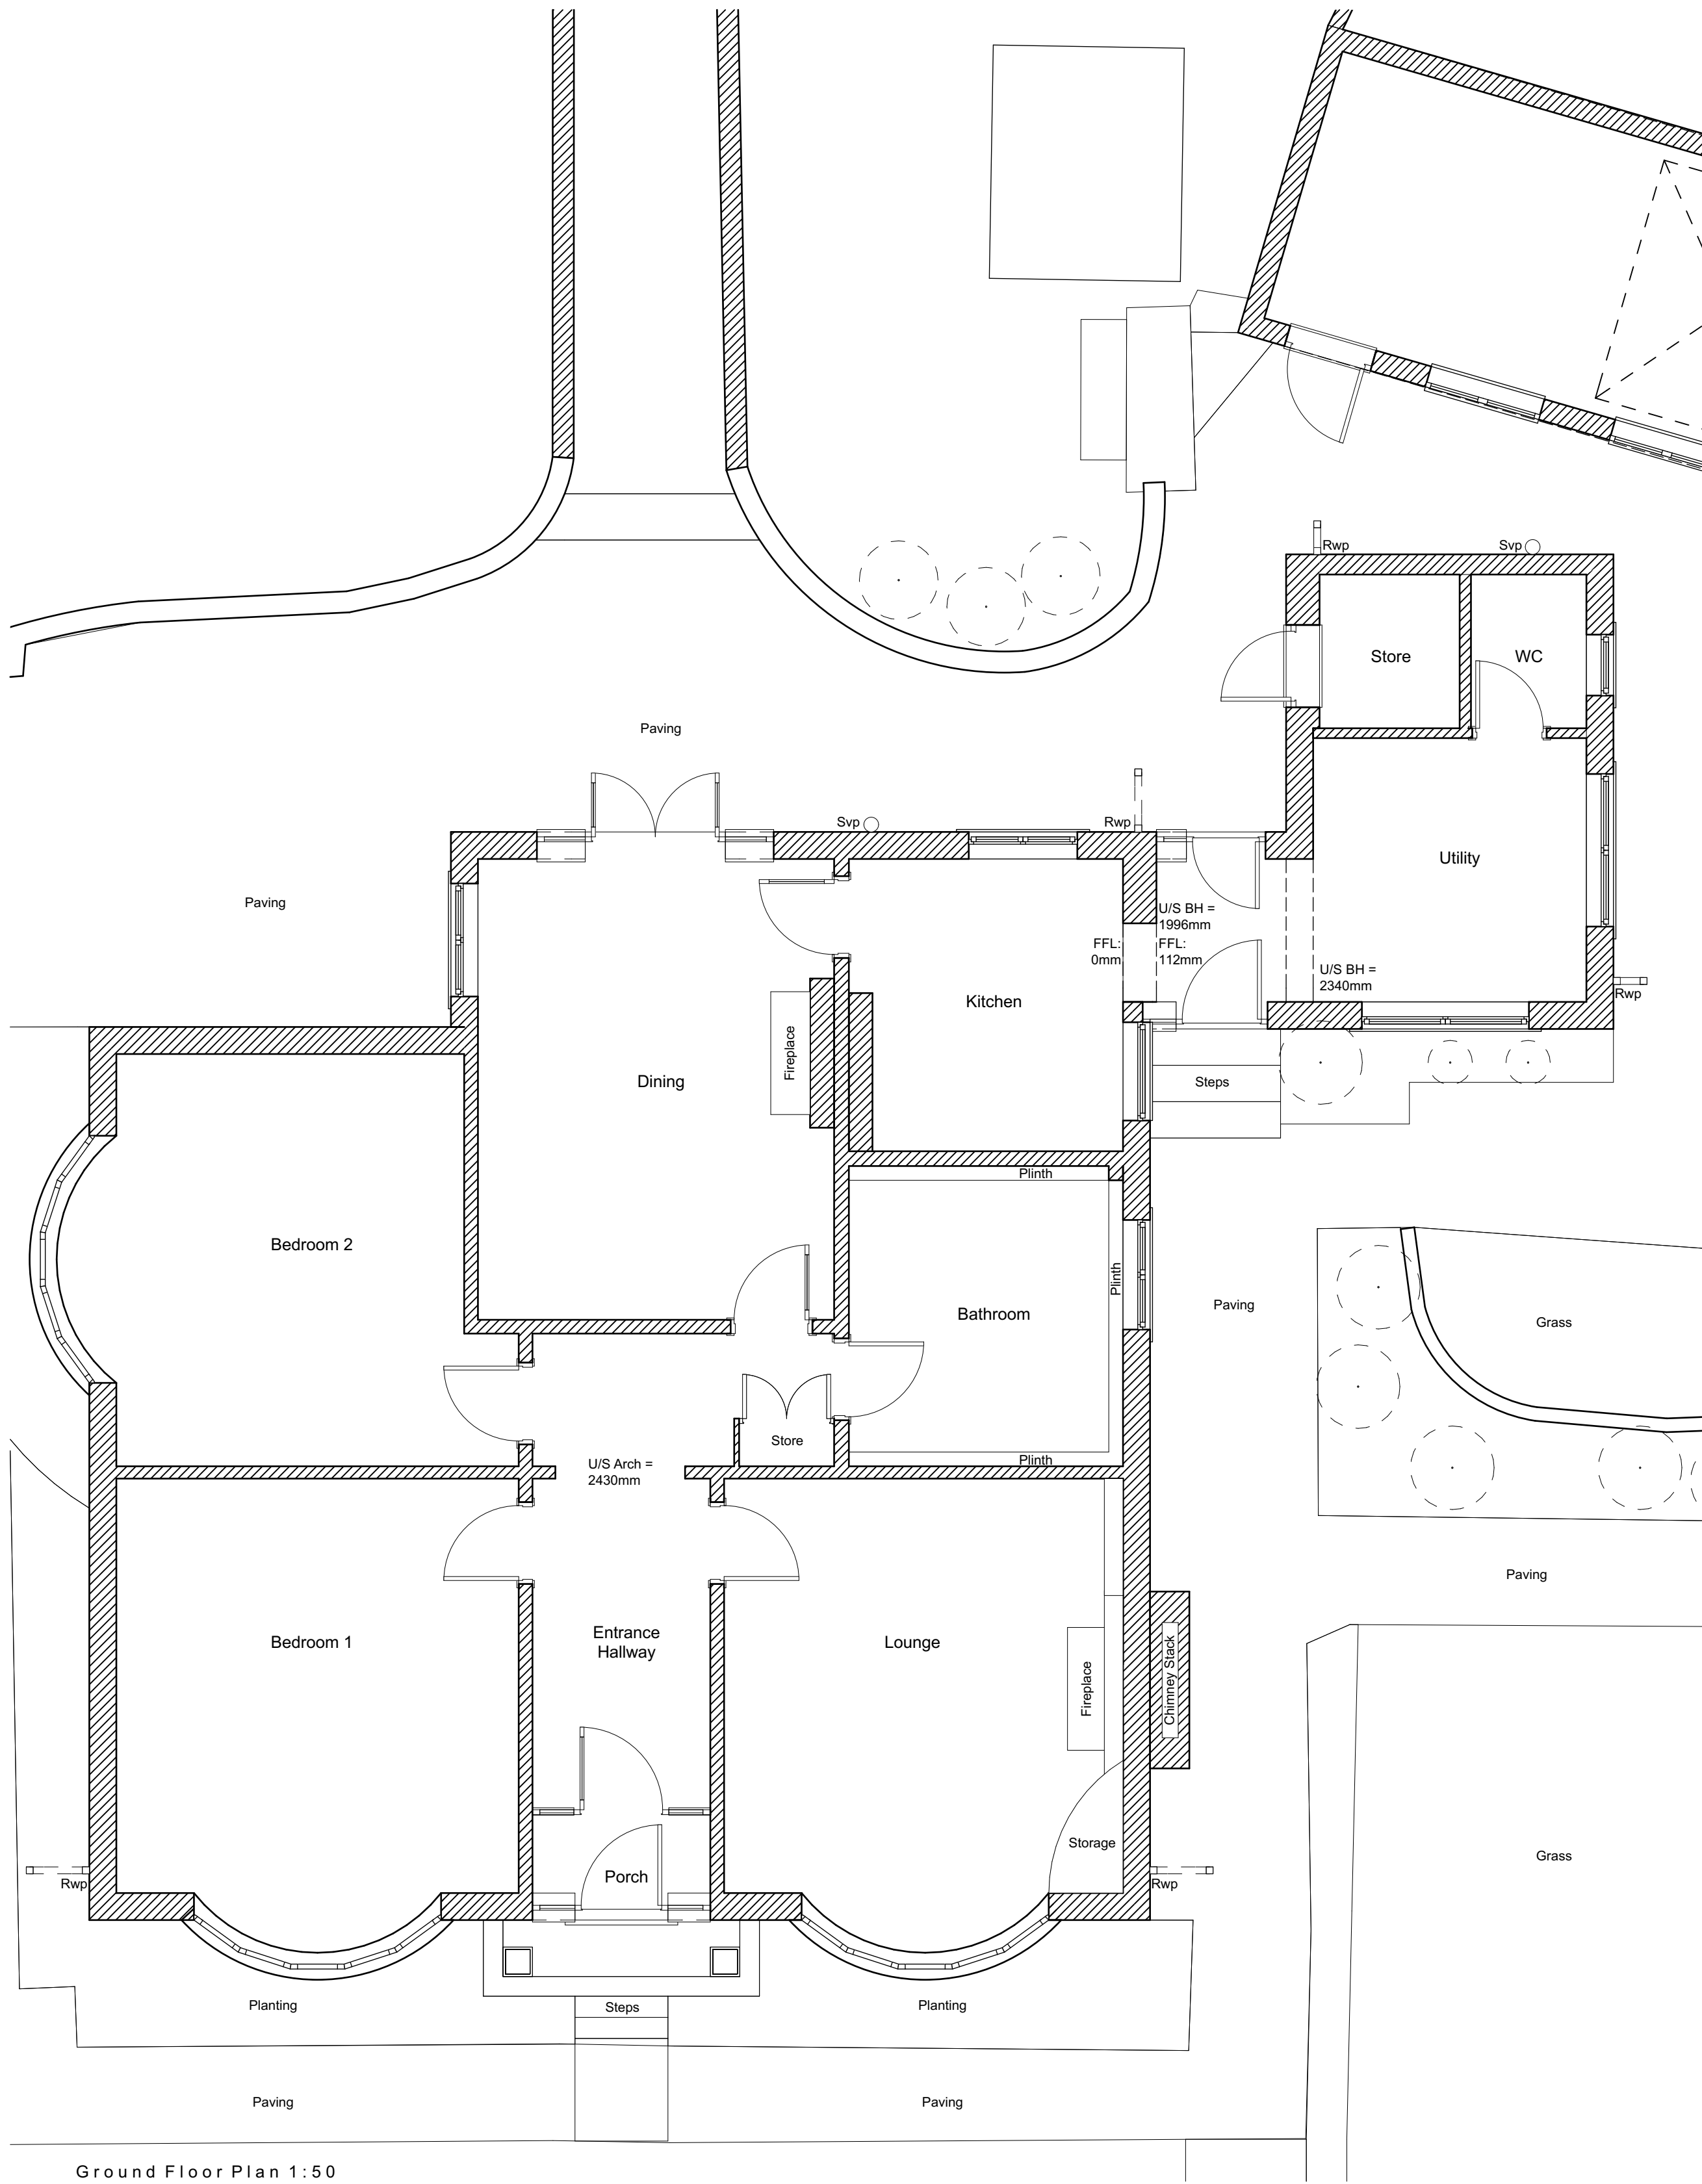

Ground Floor Plan 1:50



Front Elevation 1:100



Side 01 Elevation 1:100



Rear Elevation 1:100



Side 02 Elevation 1:100

Material Key:

1. Stonework.
2. White windows and doors.
3. Light brown door.
4. Black door.
5. White fascia.
6. Grey roof tiles.
7. Buff brickwork.
8. Pebble dashed.

Note:
All black soffits, fascias, gutters and rainwater pipes.

Project Status:	PLANNING ONLY
ita transform architects... Defining problems with beautiful solutions...	
4 Rushmead Court, Ossett, WF5 0NZ tel: 01924 265 080 - fax: 0871 66 11 003 web: www.transformarchitects.co.uk email: info@transformarchitects.co.uk	
Project Address:	13 Woodhouse Road Hoyland Barnsley S74 9AW
Client:	Mr & Mrs Pickles
Drawing Title:	Existing Arrangements A1
Scale:	1:50, 1:100
Date:	06.02.2017
Drawn By:	MNB
Drawing Number:	T894 - PL01
Revision:	Nil