

Notes:
 • This drawing is copyright.
 • Do not scale dimensions from this drawing.
 • This drawing is to be read in conjunction with all other relevant drawings.
 • All discrepancies on this drawing are to be reported to the architect.
 • Do not modify any element of this drawing.
 • Use drawing only for purpose(s) issued.



North Sign / Key Plan



0 2 4 6 8 10m

1:200 Scale

The following external model files are included within this drawing:

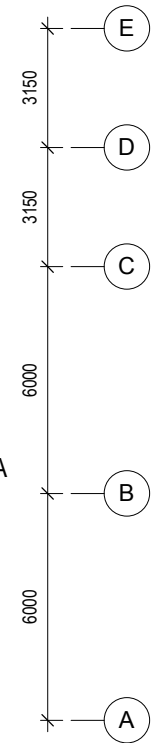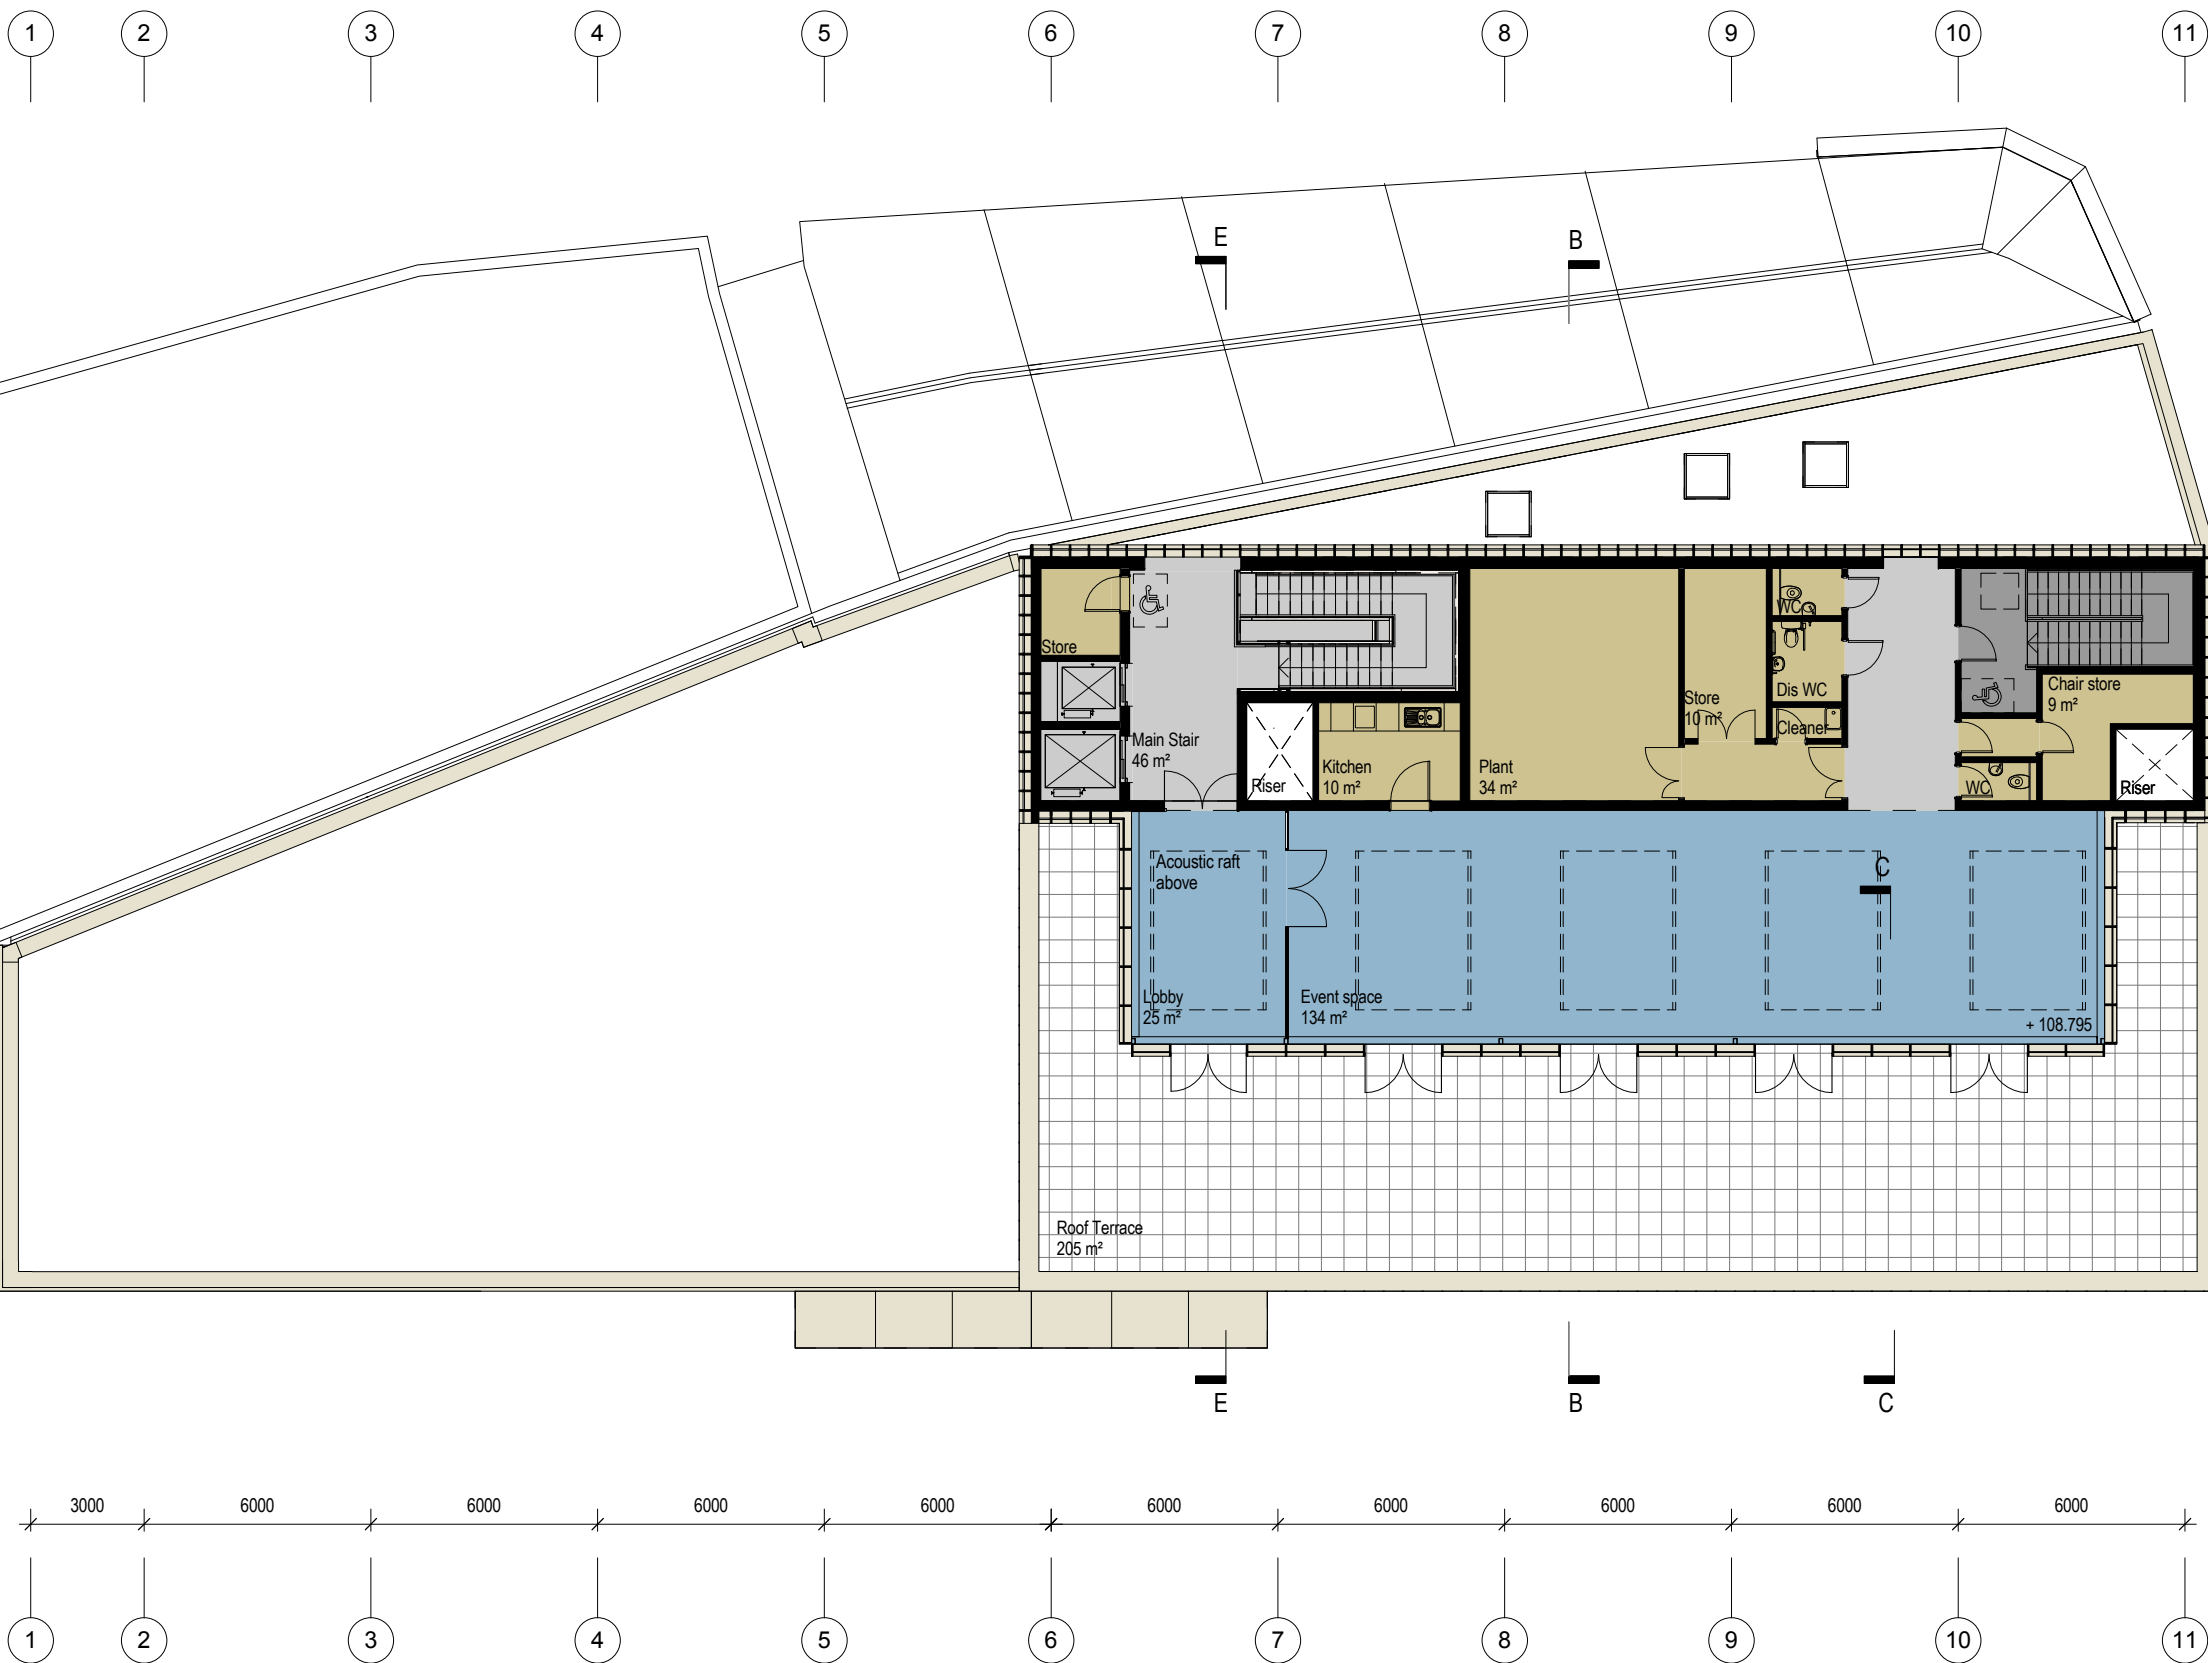

1	16/05/16	Planning Issue		
Rev	Date	Revision Notes	Dn	Rv
Client / Contractor Barnsley Metropolitan Borough Council				

IBI Intelligence Buildings Infrastructure www.ibigroup.com

Project
**BETTER BARNSEY
 NEW PUBLIC LIBRARY**

Drawing Title
Third Floor Plan

Job Number 6742	Drawing Originated Date	PAS 1192 Status Code
Scale@A3 1 : 200	Purpose PLANNING	
Drawing Number BBTC_IBI_LR_A_F100_PL_03	Revision 1	