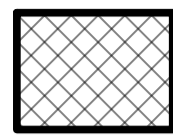
 



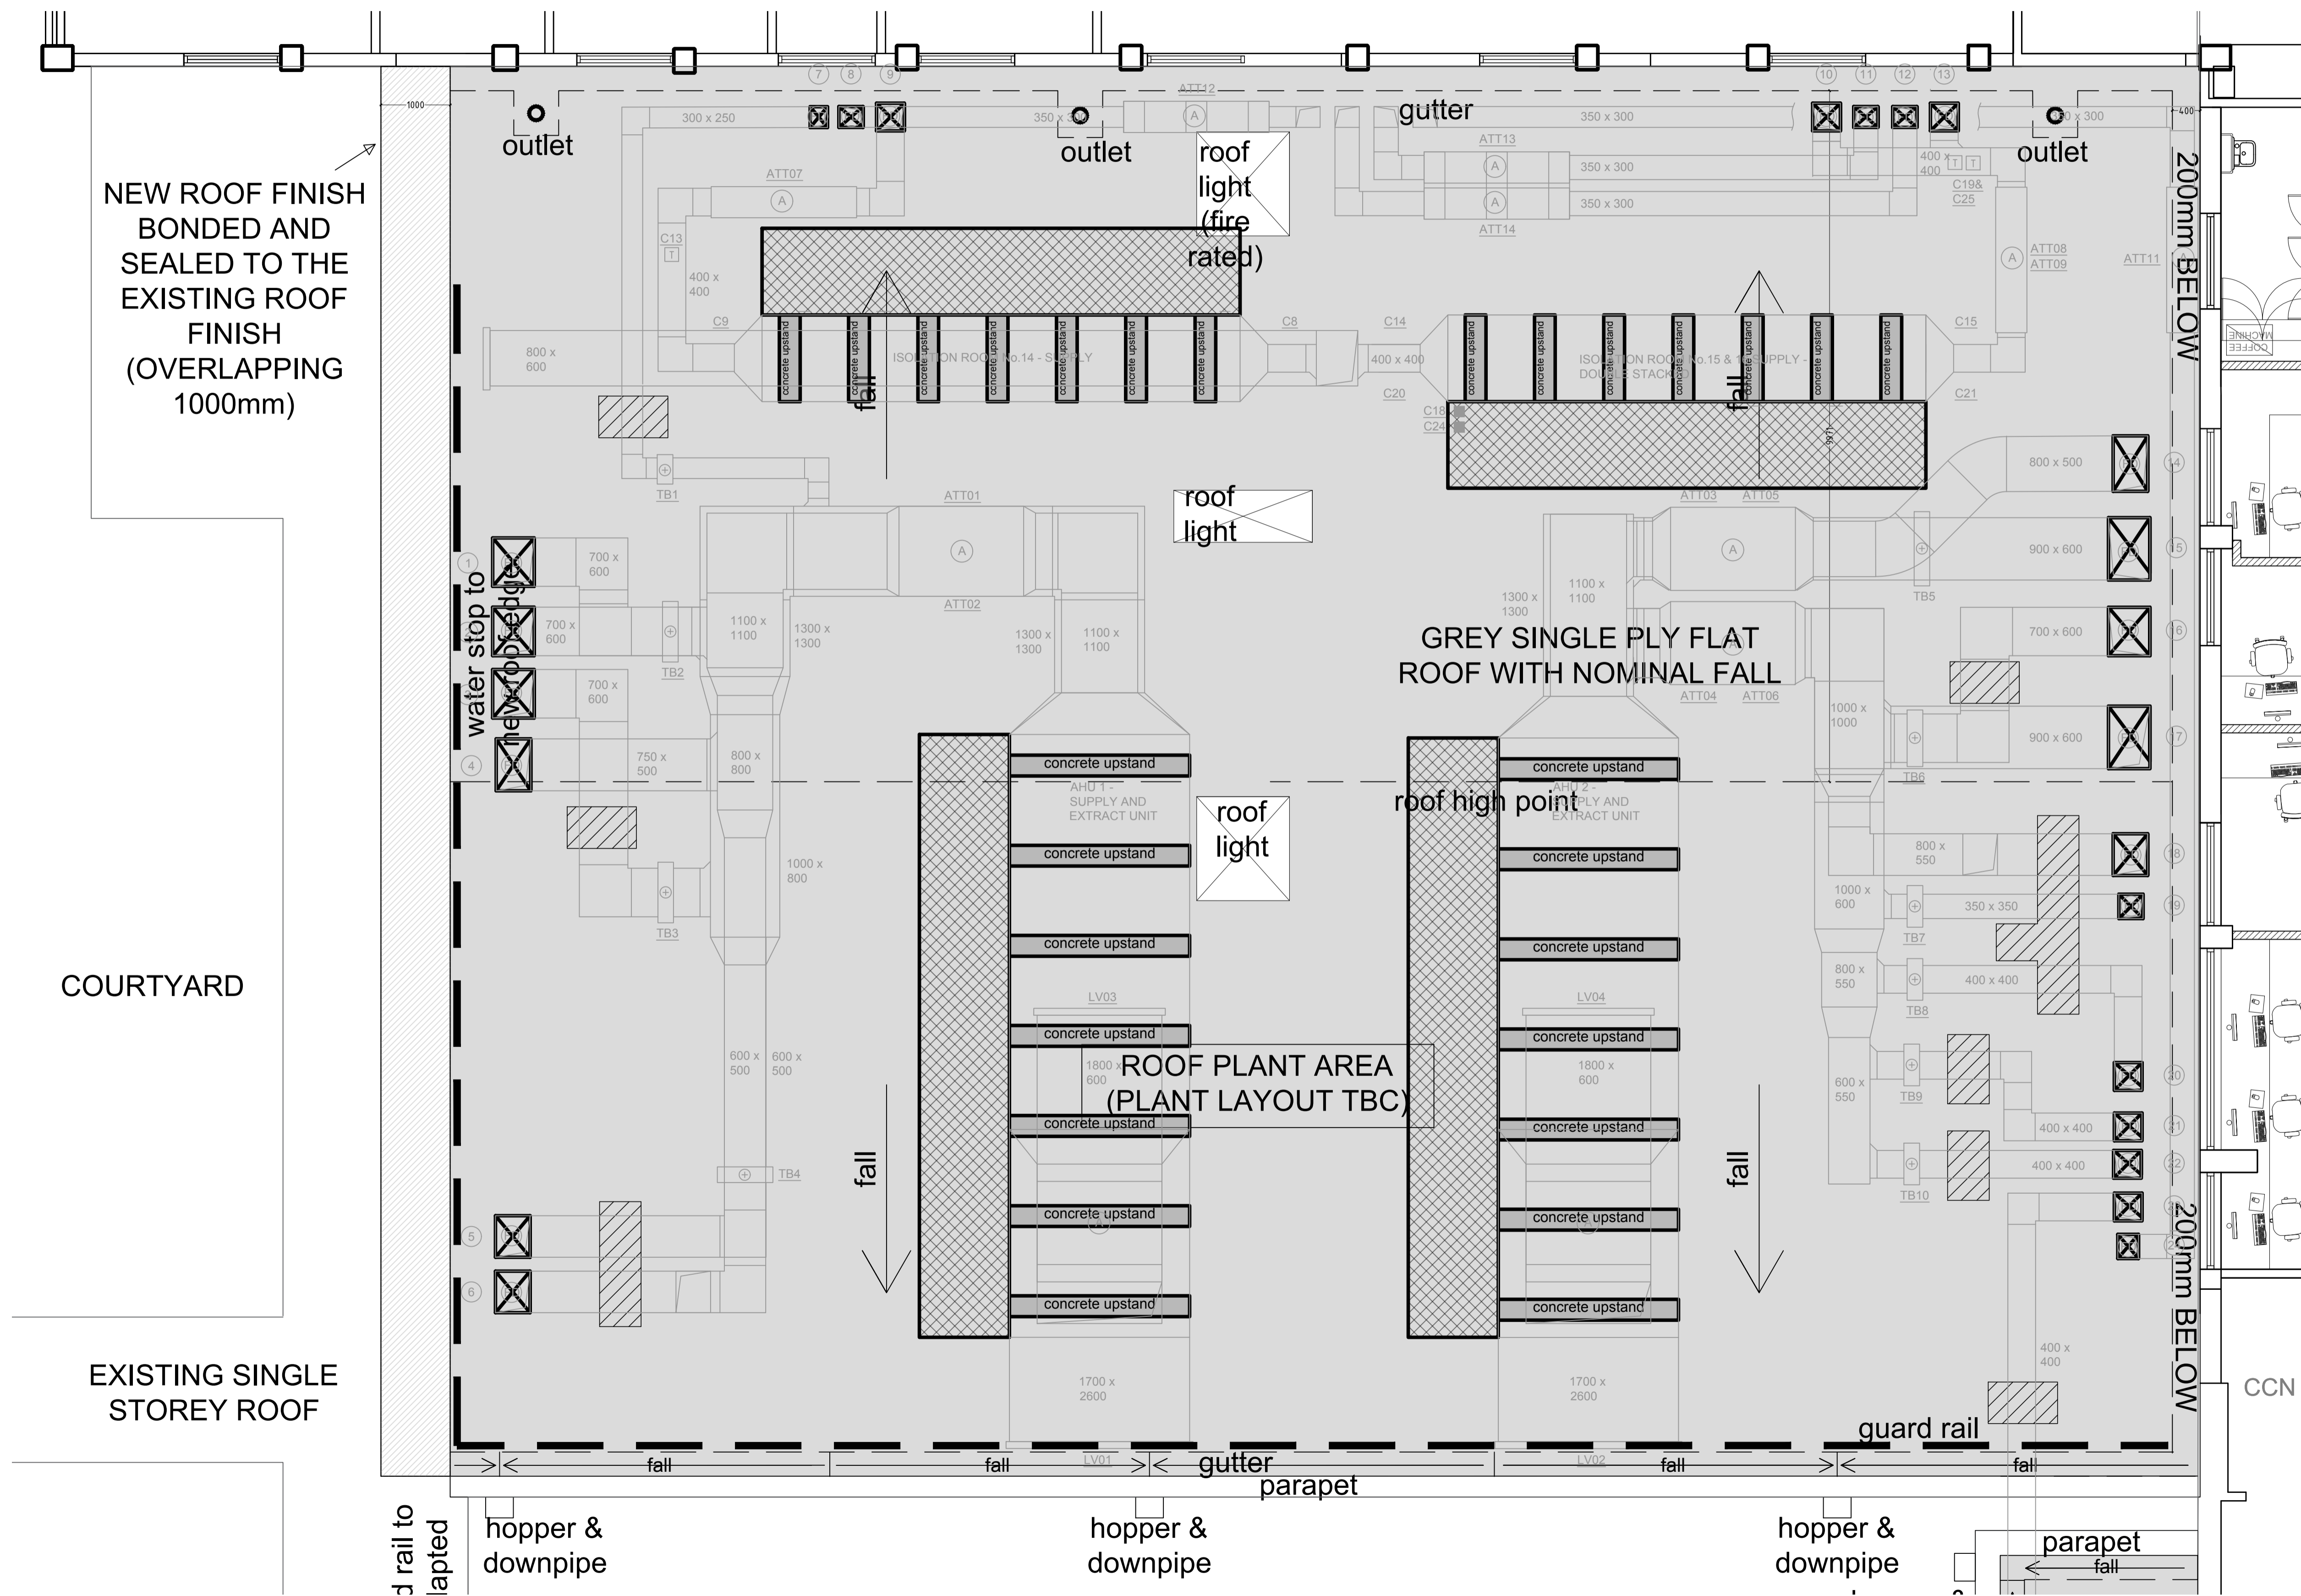
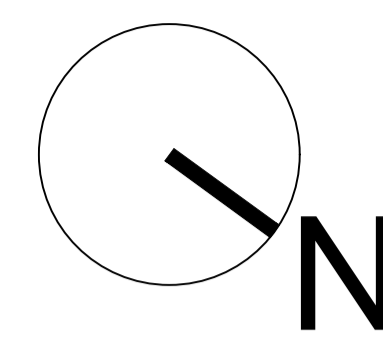
Drawing status

Drawn by DB	Size A1	Scale 1:50
Notes	Status	Rev Date
PRELIMINARY ISSUE	P	-
TENDER ISSUE	T	17/05/2021
FINAL TENDER ISSUE FOLLOWING THE REVIEW	T	20/05/2021

ROOF KEY

-  AHU MAINTENANCE GANTRY
-  DUCT STEPOVERS ROOF MOUNTED
-  ROOF PENETRATION FOR DUCTWORK- POSITIONS TBC

ROOF PLANT SHOWN INDICATIVELY ONLY



Drawing status annotation
P-Preliminary T-Tender D-Design (post preliminary) C-Construction As-As Built

Client

BARNSELY HOSPITAL NHS FOUNDATION TRUST

Project title

CRITICAL CARE UNIT

Project no

170-033

Drawing title

PROPOSED ROOF PLAN SHOWING PROVISION FOR PLANT SUPPORT & PENETRATIONS ETC.

Drawing no

CC(47)-02

Status Revision

T -

PROPOSED ROOF PLAN
1:50