


1. All work to be in accordance with the current Building Regulations
2. Only written dimensions to be used
3. Discrepancies and abnormalities to be reported.
4. If in doubt Ask.



PHASE 2

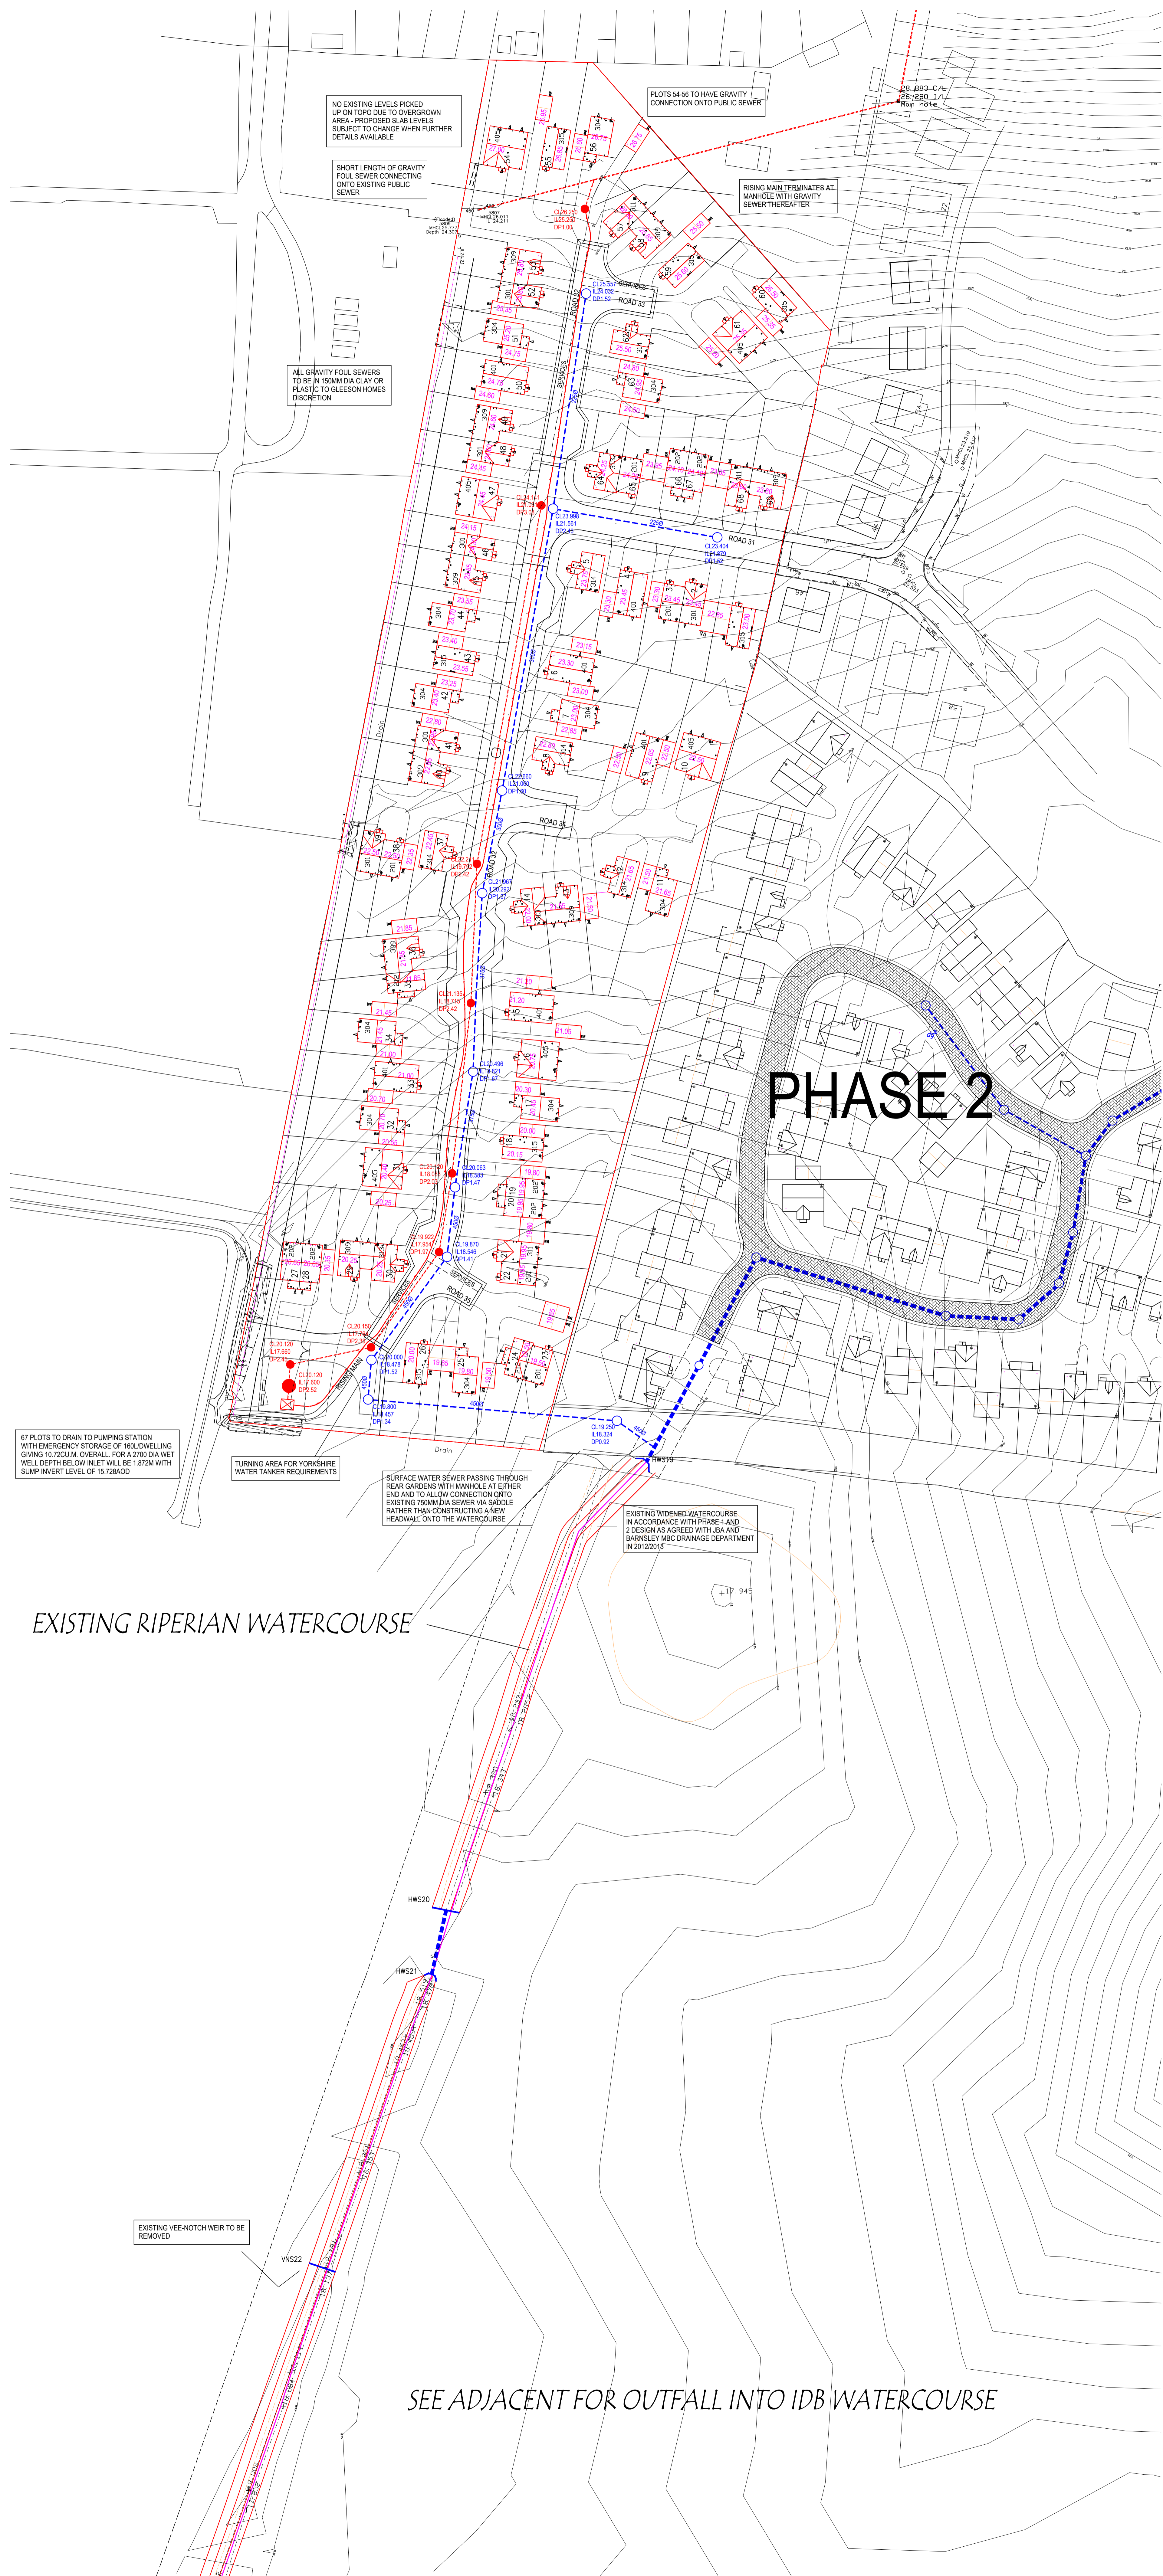

OUTFALL INTO EXISTING RIPERIAN WATERCOURSE

SEE ADJACENT FOR OUTFALL INTO IDB WATERCOURSE

A: 15/12/20 updated to Rev E Planning Layout.
Revisions:

James Eaton Design Ltd
 Design Consultant 1992-2020
 Development • Highways • Drainage
 Stoneycroft, Brackenhill, Ackworth,
 Pontefract, West Yorkshire WF7 7BG
 Tel: 01977 618626 Fax: 01977 625114
 e-mail: james@jameseatondesign.co.uk

AO

Client: **Gleeson Homes**

Site: **Goldthorpe, Phase 3.**

Title: **Drainage Layout (Preliminary)**

Date: Aug 2020 Scales: 1/500 Drawing No.: 20/729/9790A

Copyright © James Eaton Design Limited 2020. All Rights Reserved. Any unauthorised copying or reproduction of this drawing without the consent of the Company will constitute an infringement of copyright.