






Location Plan 1:1250

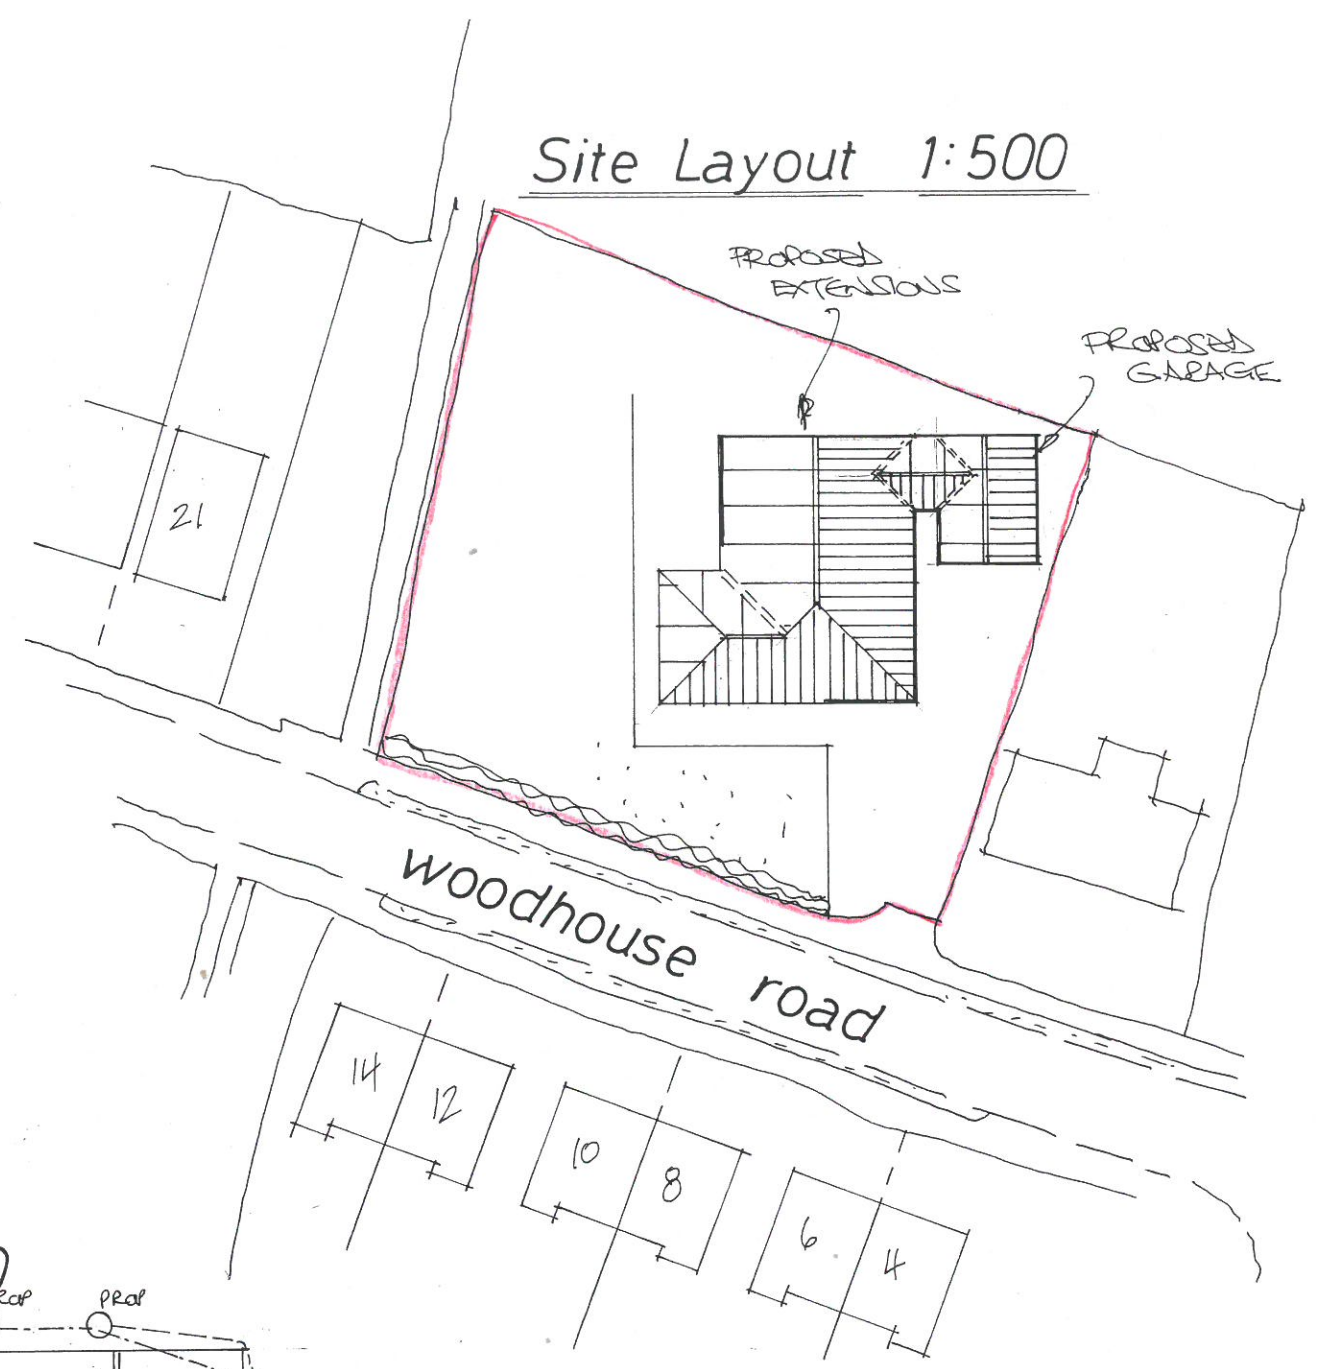

Site Layout 1:500

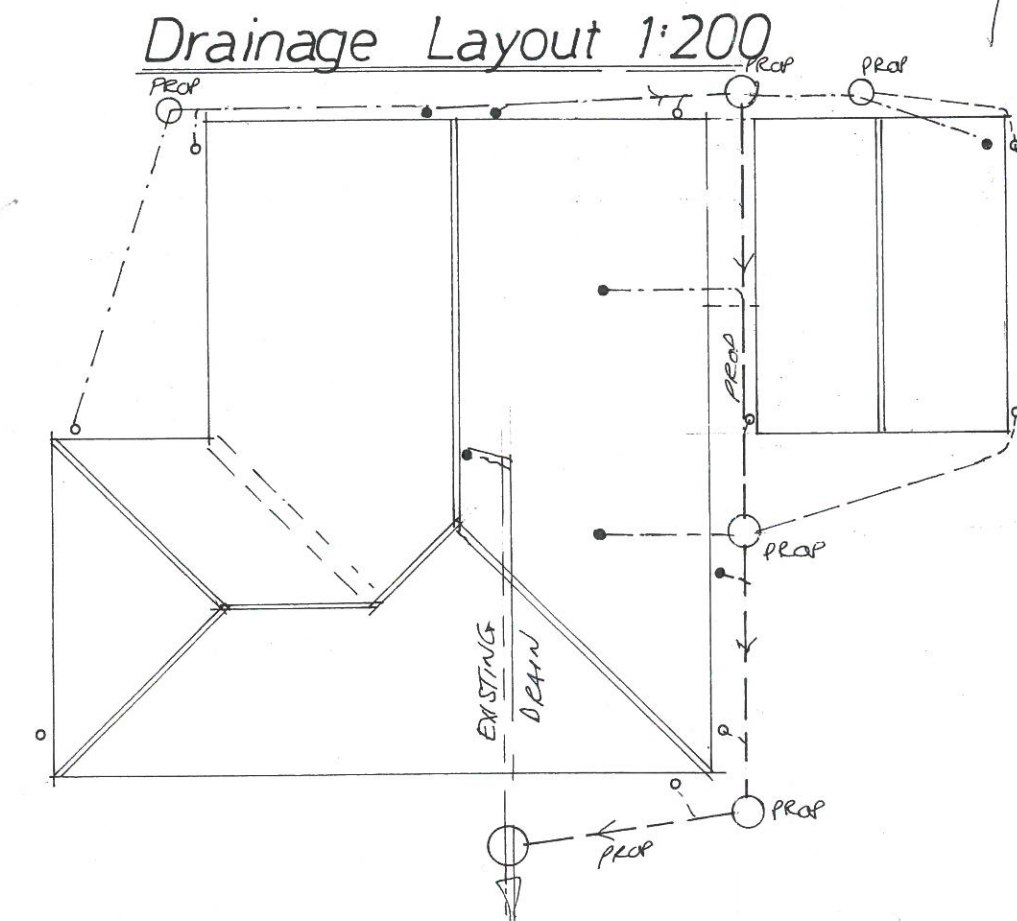

Drainage Layout 1:200

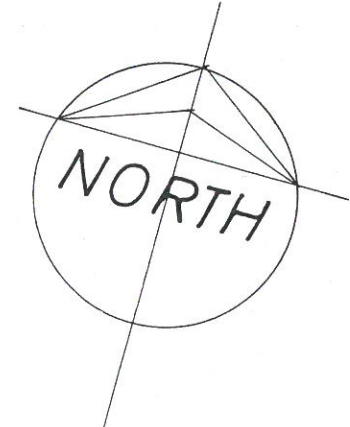

Rev A  
Amended  
16-01-20

Rev	Notes	Date
A	GARAGE ALTERED	01/20

**Garry Greetham Associates**  
Residential Design Consultant  
Westwood House  
18 Carr Lane  
Tankersley  
Barnsley S75 3BE  
Tel(01226)746573

PROJECT Various Extensions  
CLIENT Mr. & Mrs. A. Whelan  
TITLE Site & Location Layouts  
ADDRESS 13 Woodhouse Road,  
off Valley Way, Hoyland,  
Barnsley. S74 9AW  
DRAWN BY ggg  
SCALE as shown DATE Nov 19  
DRAWING No 922-01 REV A  
Member of the Chartered Institute of Architectural Technologists