
 


new
surface
water
drain
new
2.00m
deep
soak
away

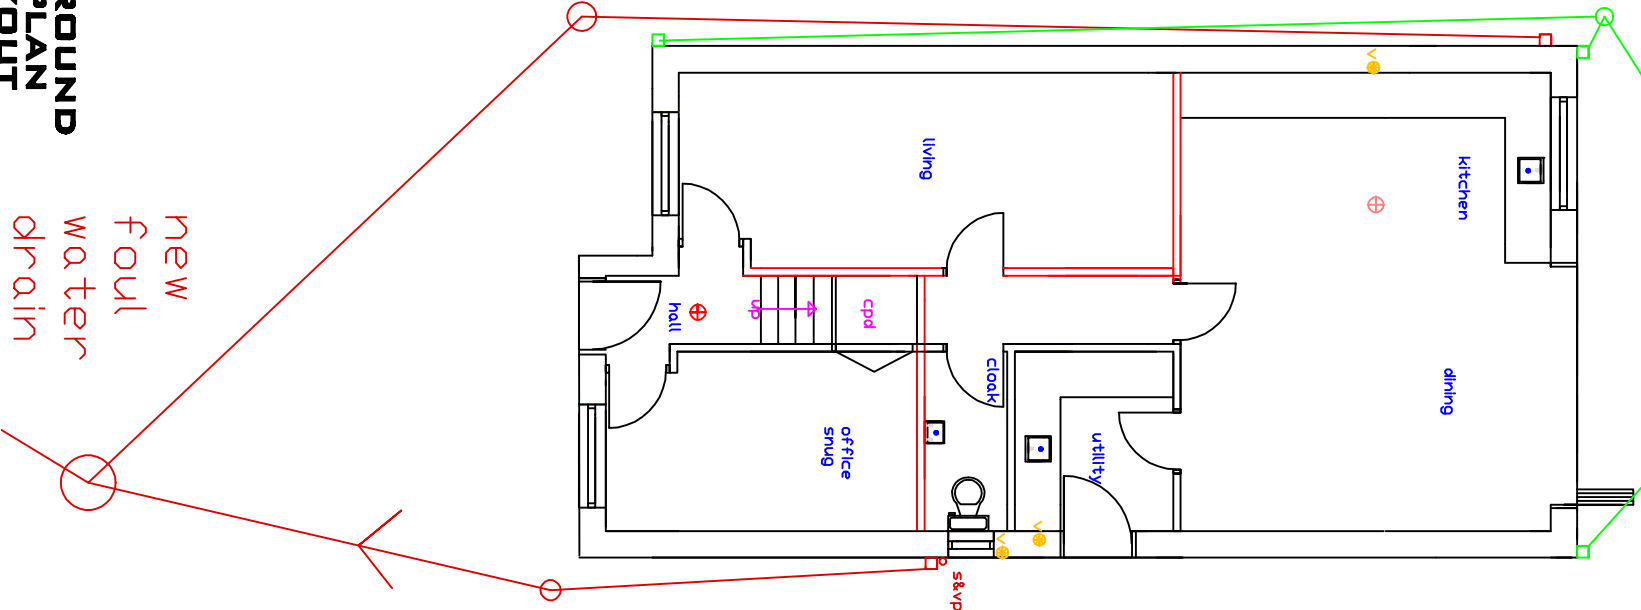

PROPOSED GROUND
DRAINAGE PLAN
FLOOR LAYOUT
1:100



Scale Bar

HEALTH AND SAFETY LEGISLATION 2023

The main Contractor will be required and will be responsible for all the Health and Safety for the duration of the Contract Period of all Trades & Suppliers

DO NOT SCALE OF THIS DRAWING
TAKE ALL DIMENSIONS ON SITE
(builders Note)
Do not start any works until all the approvals have been obtained.
Any discrepancy to be reported to Plans Drawn as soon as possible.

drawn: **DRW**

client: **ASH MERRILL,
LAND ADJACENT TO
87, GRANDE LANE,
BARNLEY
871 5QF,
TEL 07549950215**

drawing title:
**NEW BUILD
3 BEDROOM
DORMER BUNGALOW**

project:
**BARNLEY MET.
BOROUGH COUNCIL.
PLANNING
& BUILDING CONTROL
APPLICATION**

PLANS DRAWN
tel.no
07952934281
07856609593
email
Bawin terbotton
@aol.com
www.Plansforproperty.com
www.Plansdrawn.org

date: **DECEMBER, 2024**
project no. **01 87** drg. no. **14** A3 paper