


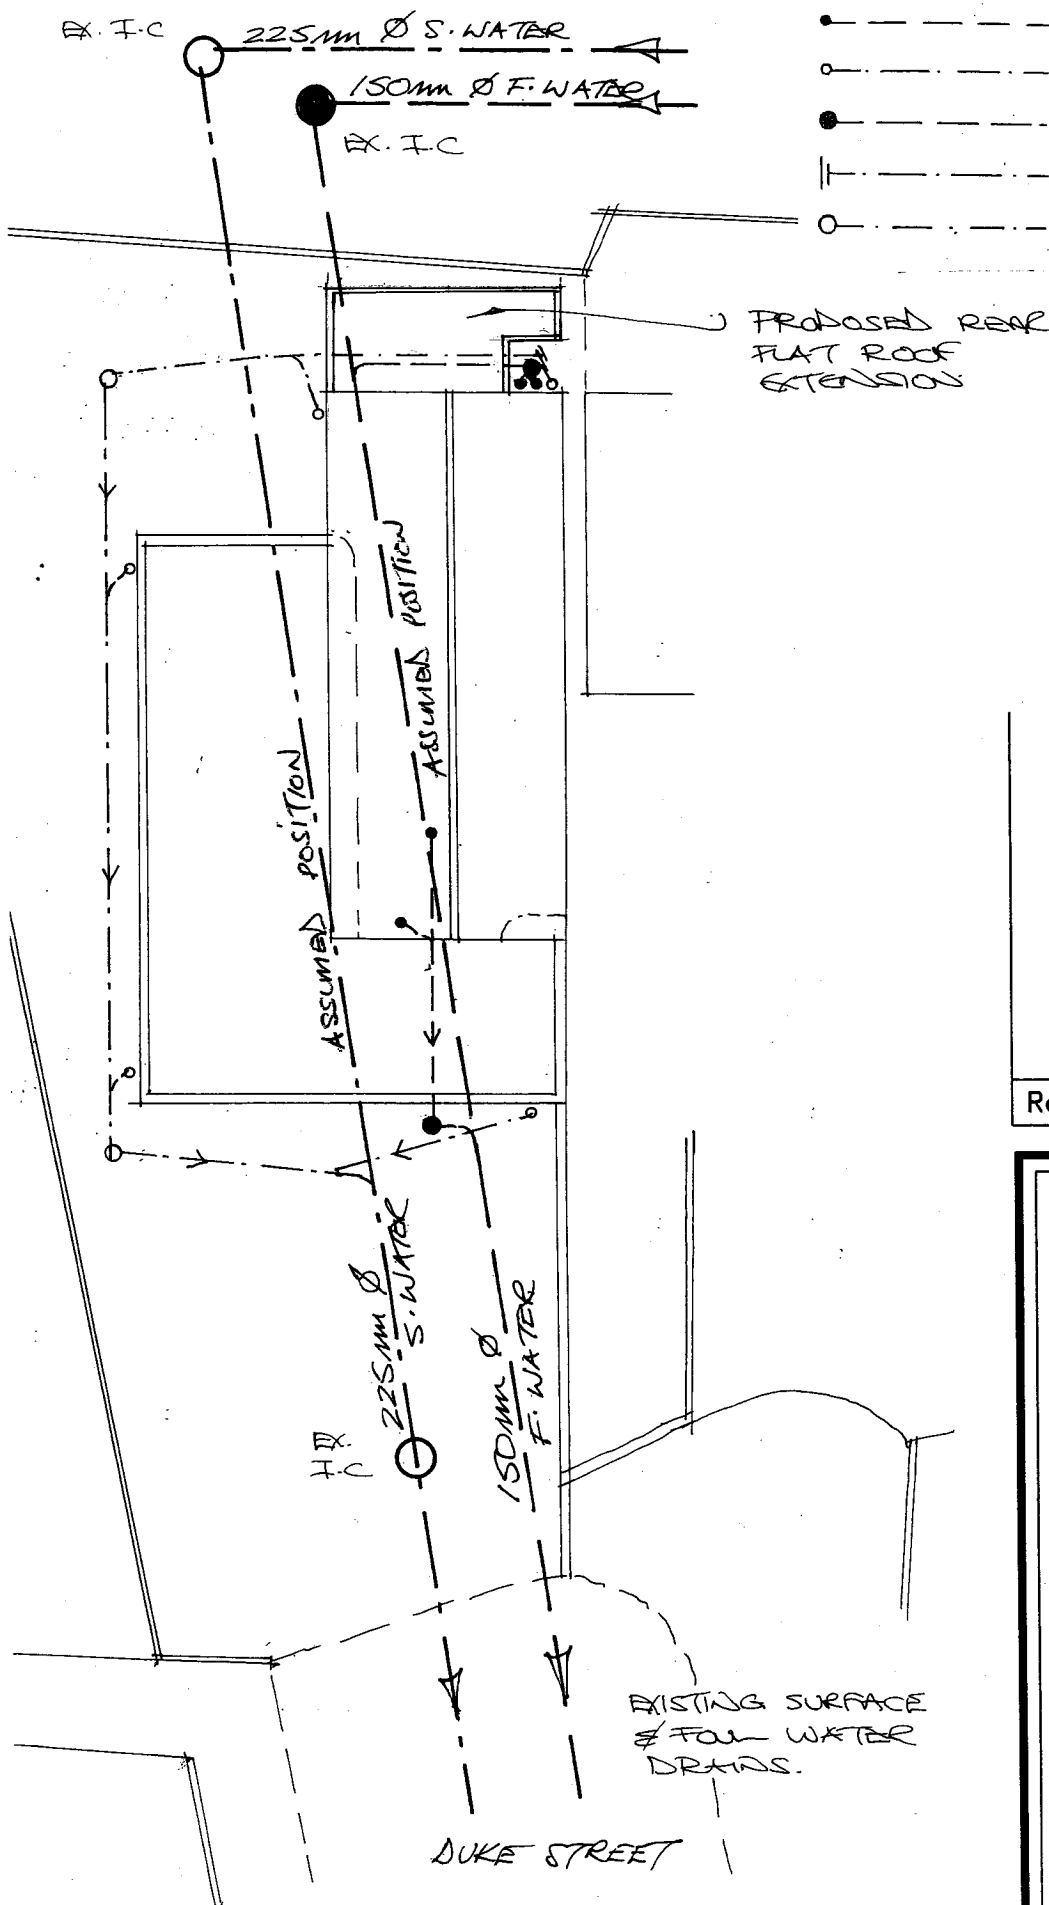

- — — — — — Foul outlet and drain.
- — — — — — Surface water outlet and drain.
- — — — — — F. W. Inspection chamber.
- || — — — — — S. W. Rodding access
- — — — — — S.W. Inspection chamber


Rev	Notes	Date

Garry Greetham Associates
 Residential Design Consultant
 Westwood House
 18 Carr Lane
 Tankersley
 Barnsley S75 3BE
 Tel(01226)746573


PROJECT	Rear Extension
CLIENT	Mrs. Sue Herbert
TITLE	Drainage Layout
ADDRESS	"Rainbow Day Care", Duke Street, Hoyland Barnsley. S74 9QS
DRAWN BY	ggg
SCALE	1:200
DATE	Jun 21
DRAWING No	854-11
REV	

Member of the Chartered Institute
 of Architectural Technologists

Drainage Layout 1:200

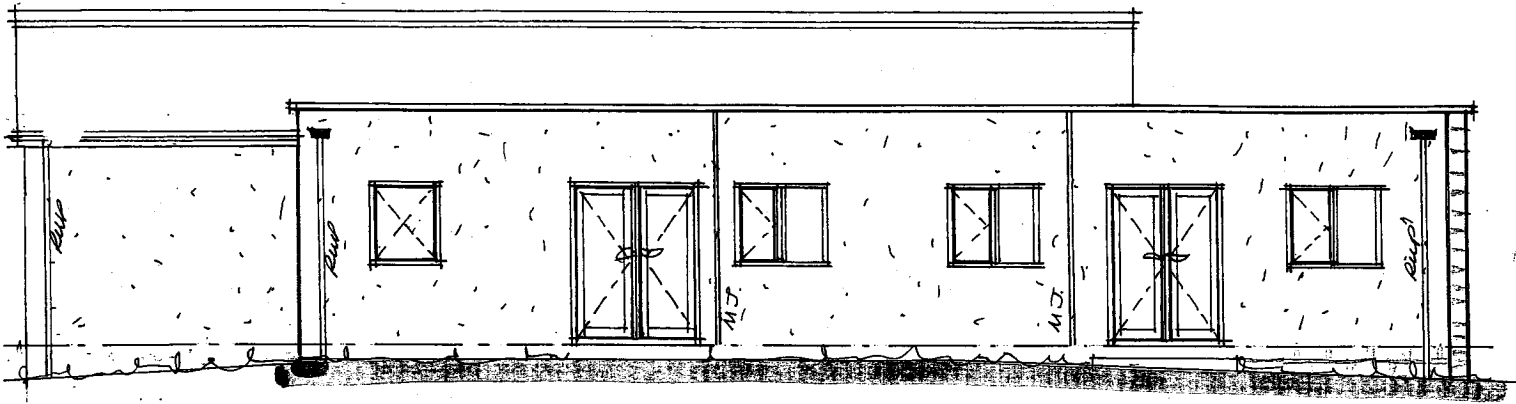


Side

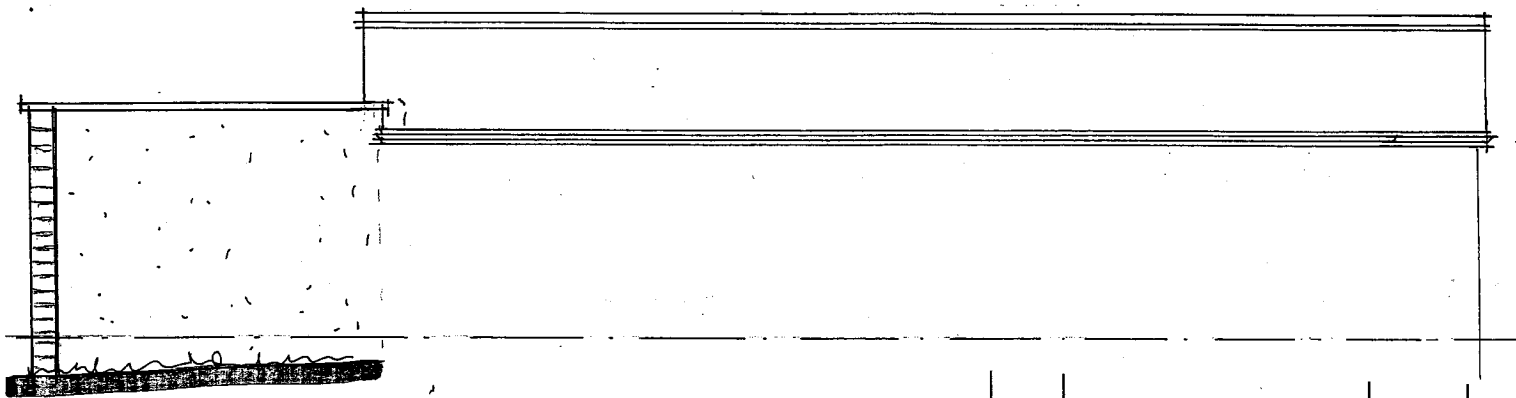


Side

MATCHING NATURAL STONE

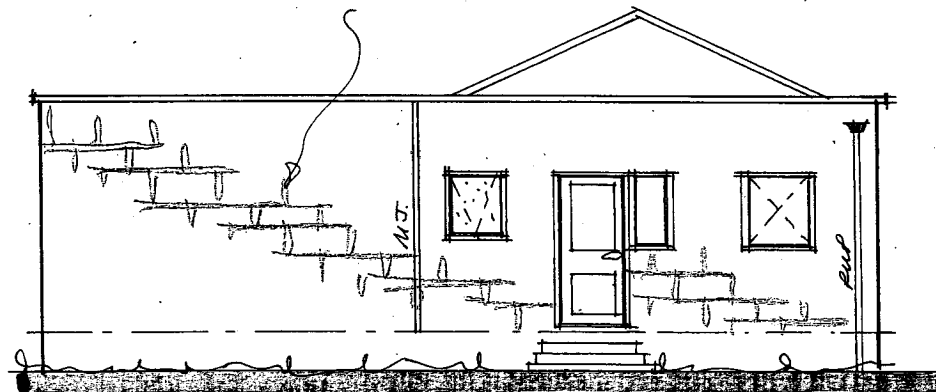

Front

MATCHING SAND &
CEMENT RENDER

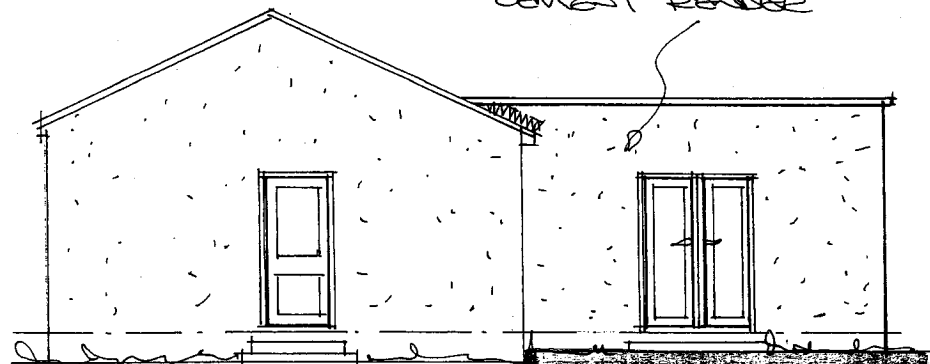

Rear

Rev	Notes	Date

**Garry
Greetham
Associates**
Residential
Design Consultant
Westwood House
18 Carr Lane
Tankersley
Barnsley S75 3BE
Tel(01226)746573

PROJECT	Rear Extension	
CLIENT	Mrs. Sue Herbert	
TITLE	Elevations as Existing	
ADDRESS	"Rainbow Day Care", Duke Street, Hoyland Barnsley. S74 9QS	
DRAWN BY	ggg	
SCALE	1:100	DATE Jun 21
DRAWING No	854-12	REV

Member of the Chartered Institute
of Architectural Technologists


Rev	Notes	Date


**Garry
Greeham
Associates**

Residential
Design Consultant
Westwood House
18 Carr Lane
Tankersley

Barnsley S75 3BE
Tel(01226)746573

PROJECT	Rear Extension
CLIENT	Mrs. Sue Herbert
TITLE	Rear Layout as Existing
ADDRESS	"Rainbow Day Care", Duke Street, Hoyland Barnsley, S74 9QS
DRAWN BY	999
SCALE	1:50
DATE	JUN 21
DRAWING NO	854-13
REV	
Member of Chartered Institute of Architectural Technologists	

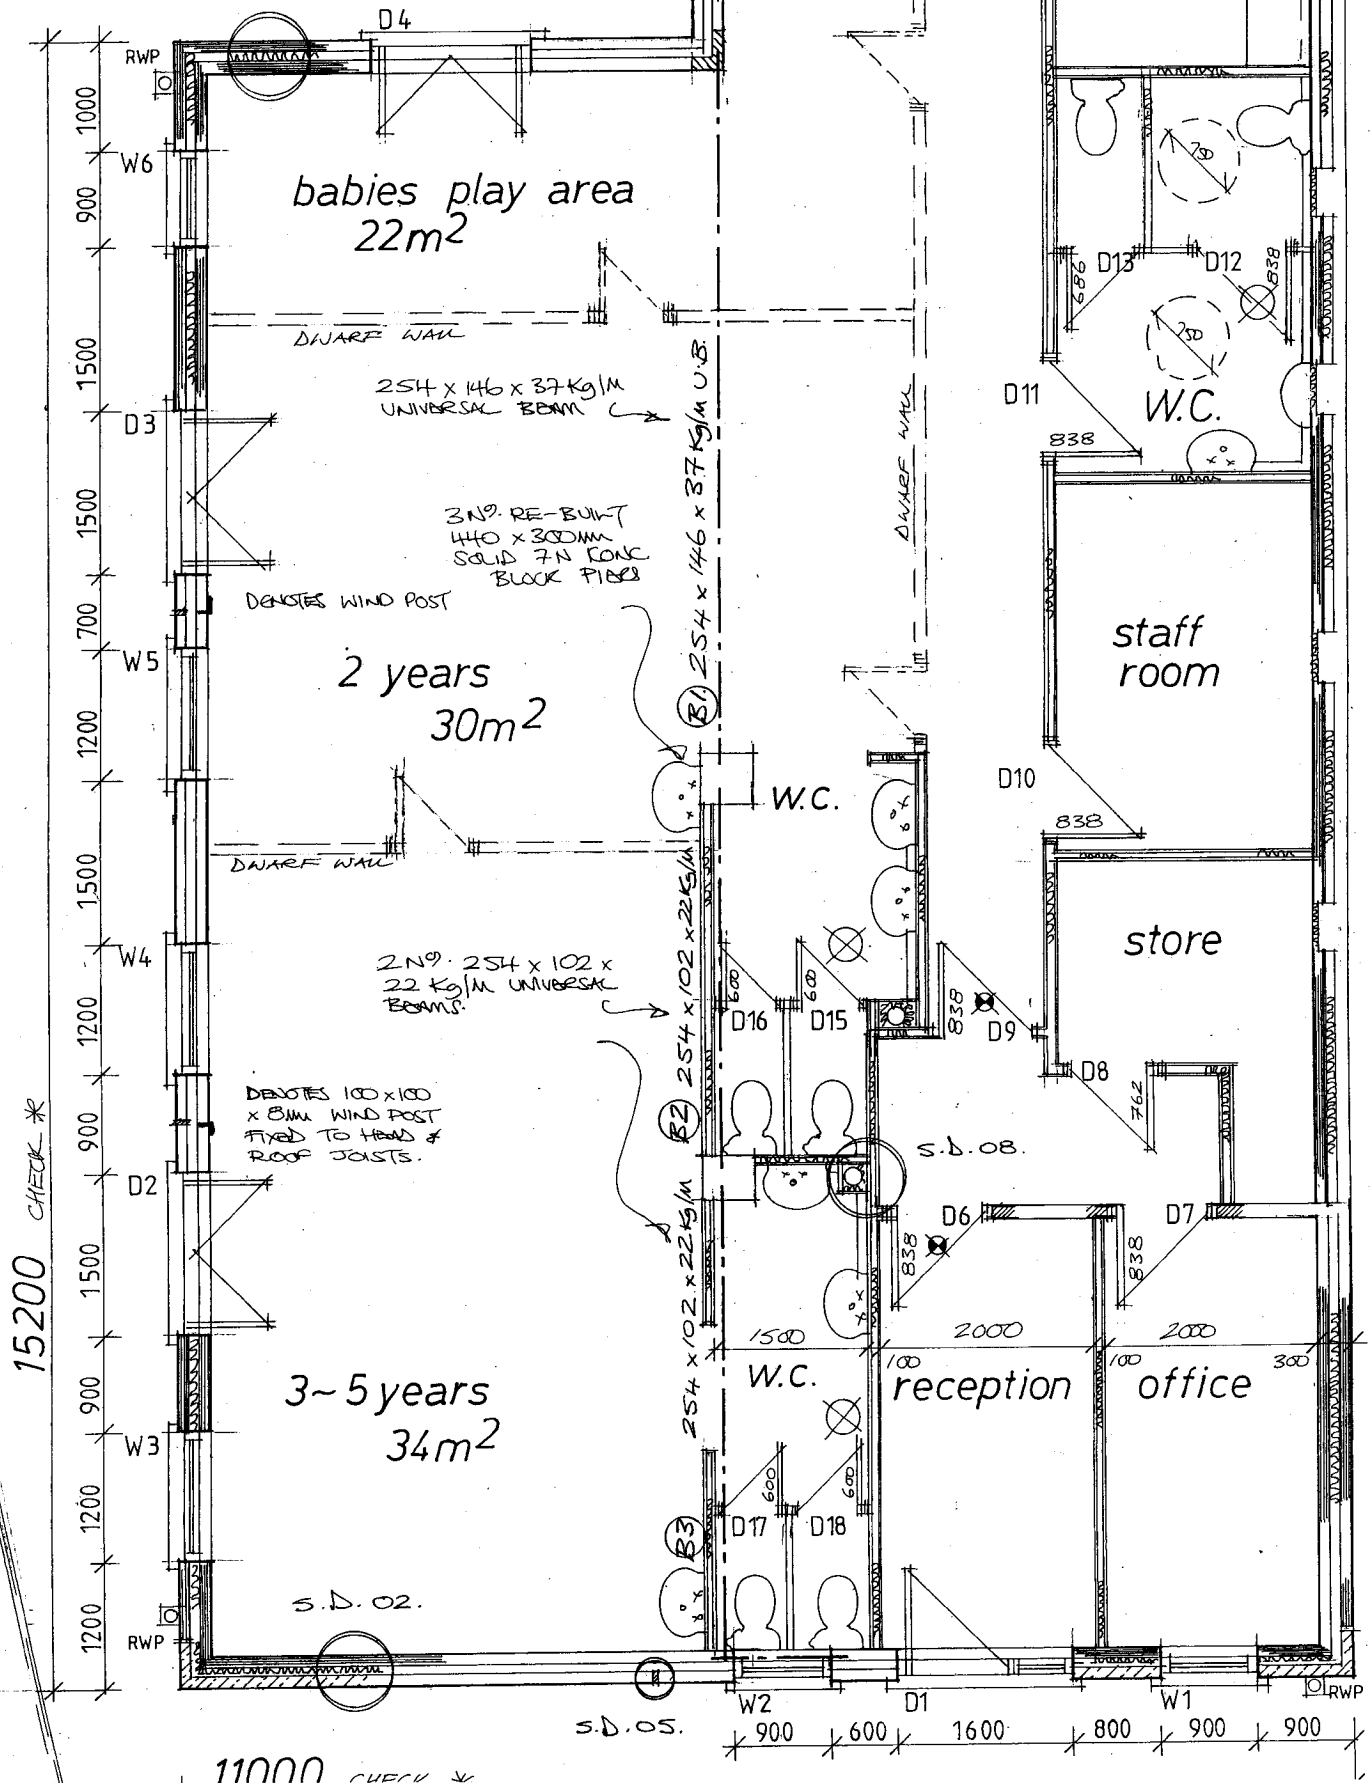


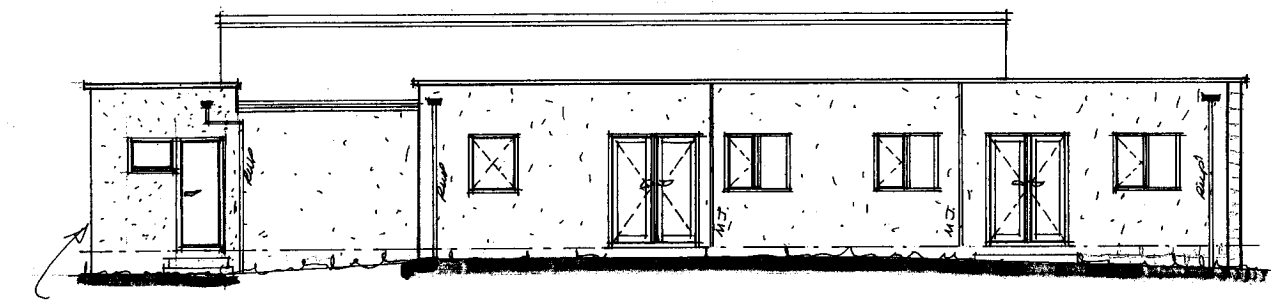

PROPOSED
REAR EXT.

Side

PROPOSED
REAR EXT.

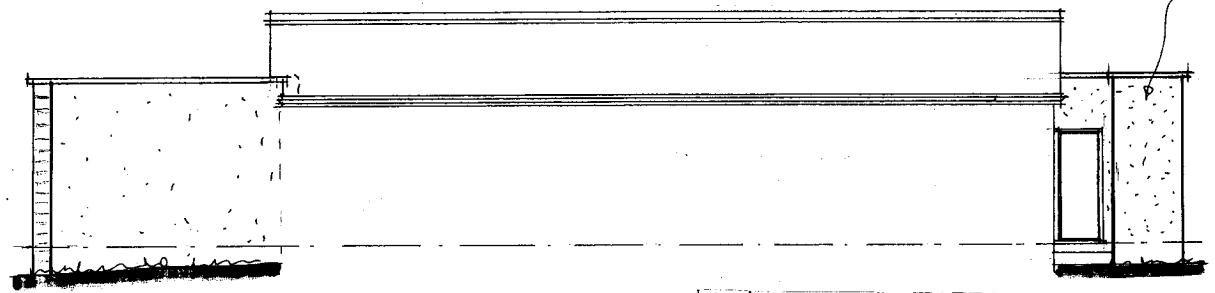


Side



Front

Rev	Notes	Date

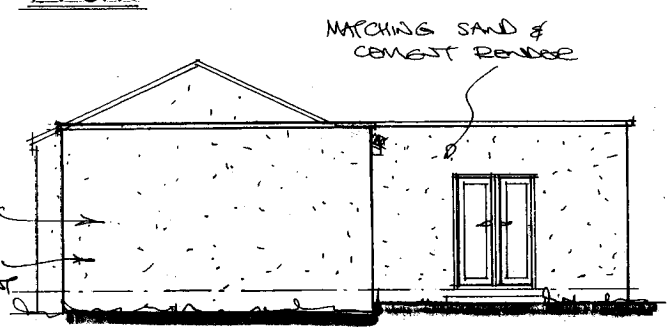


Rear

PROPOSED
REAR EXT.

MATCHING
SAND & CONCRETE
RENDER

Garry Greetham Associates Residential Design Consultant Westwood House 18 Carr Lane Tankersley Barnsley S75 3BE Tel(01226)746573	
PROJECT	Rear Extension
CLIENT	Mrs. Sue Herbert
TITLE	Elevations as Proposed
ADDRESS	"Rainbow Day Care", Duke Street, Hoyland Barnsley. S74 9QS
DRAWN BY	999
SCALE	1:100 DATE Jun 21
DRAWING No	854-14 REV
Member of the Chartered Institute of Architectural Technologists	

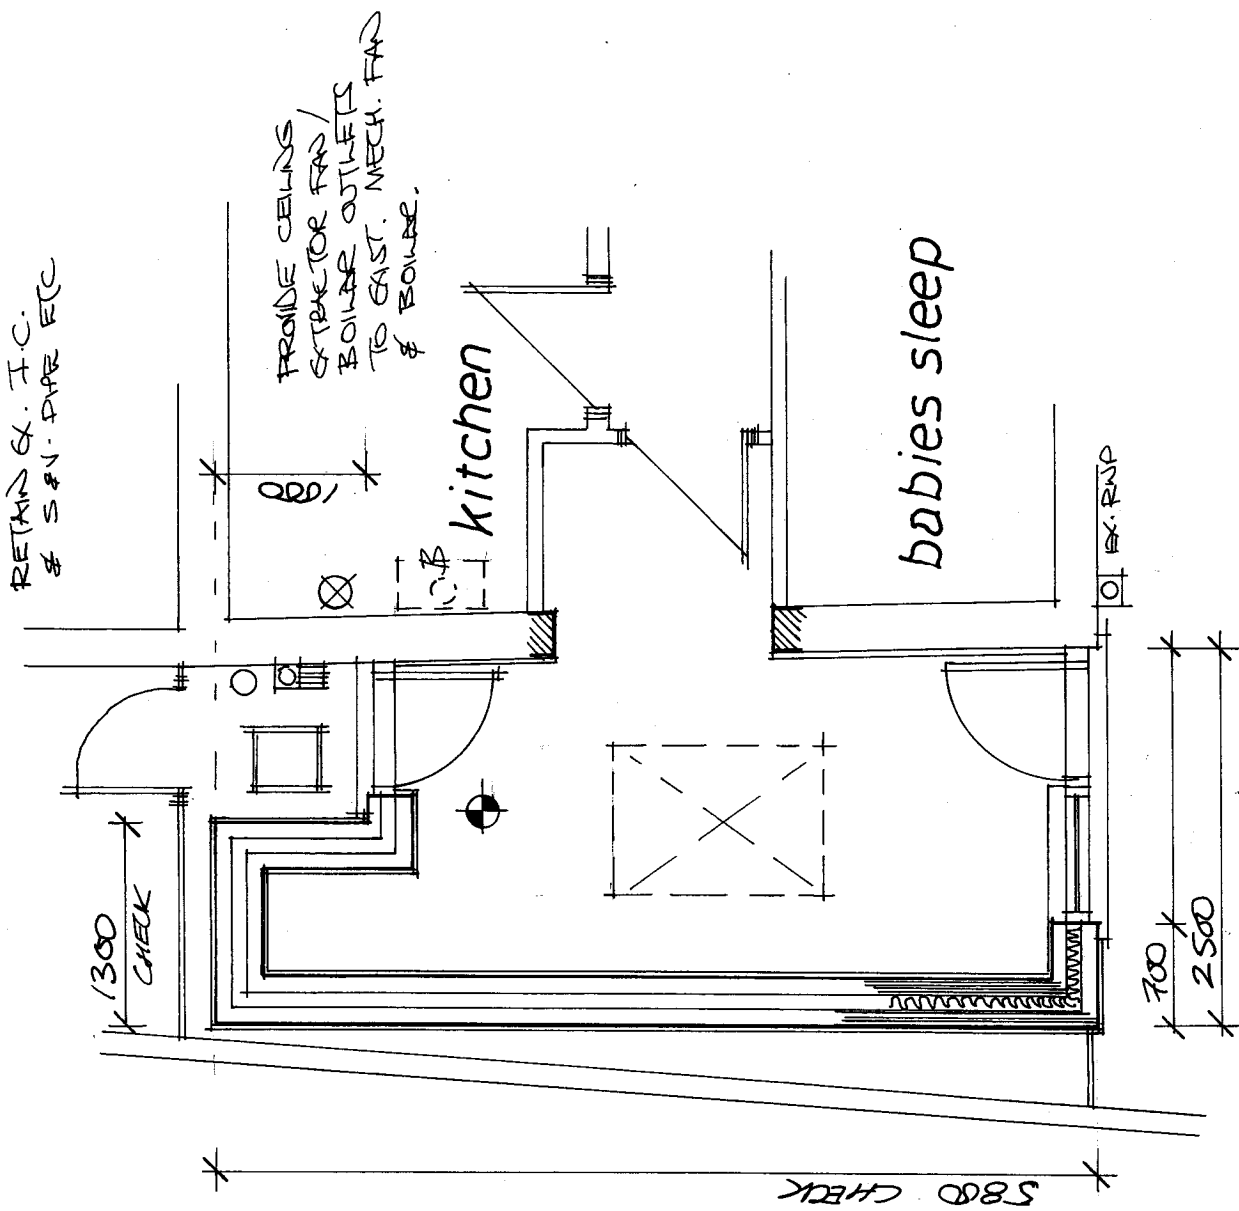

Rev	Notes	Date

Garry Greetham Associates
 Residential Design Consultant
 Westwood House
 18 Carr Lane
 Tankersley
 Barnsley S75 3BE
 Tel(01226)746573

PROJECT	Rear Extension
CLIENT	Mrs. Sue Herbert
TITLE	Rear Layout as Proposed
ADDRESS	"Rainbow Day Care", Duke Street, Hoyland Barnsley. S74 9QS
DRAWN BY	ggg
SCALE	1:50
DATE	JUN 21
DRAWING No	854-15
REV	

Member of the Chartered Institute
 of Architectural Technologists