
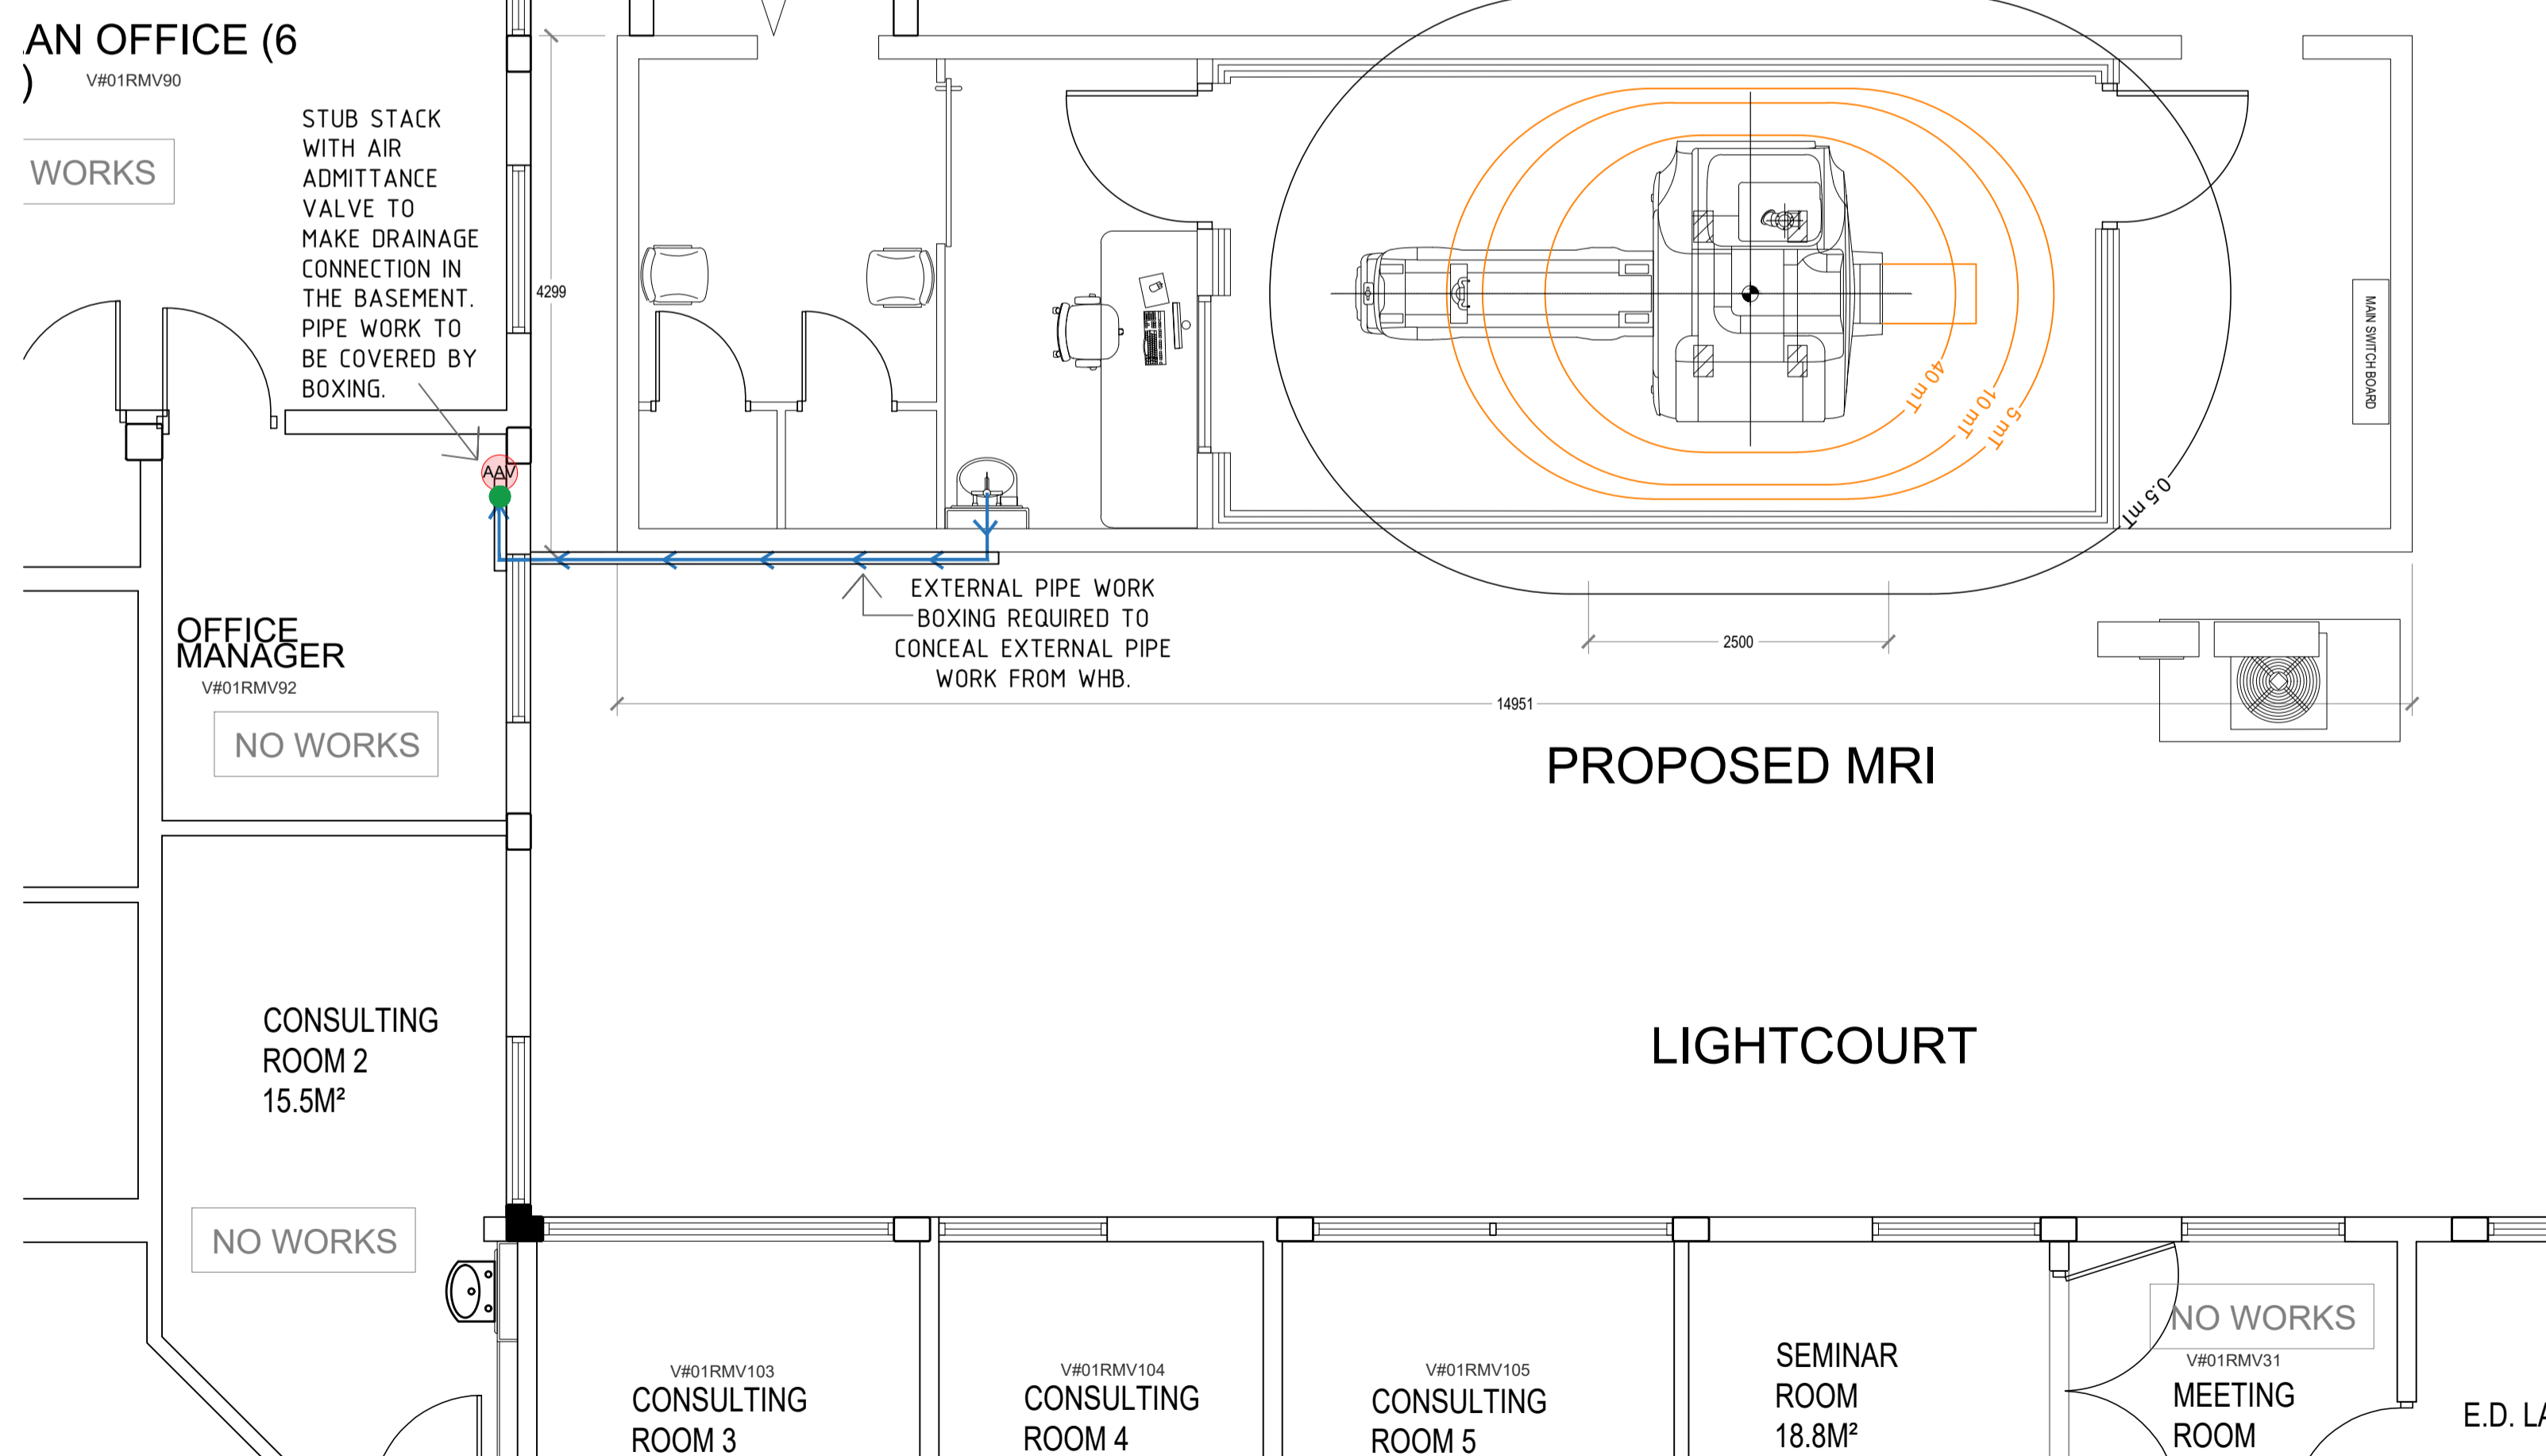
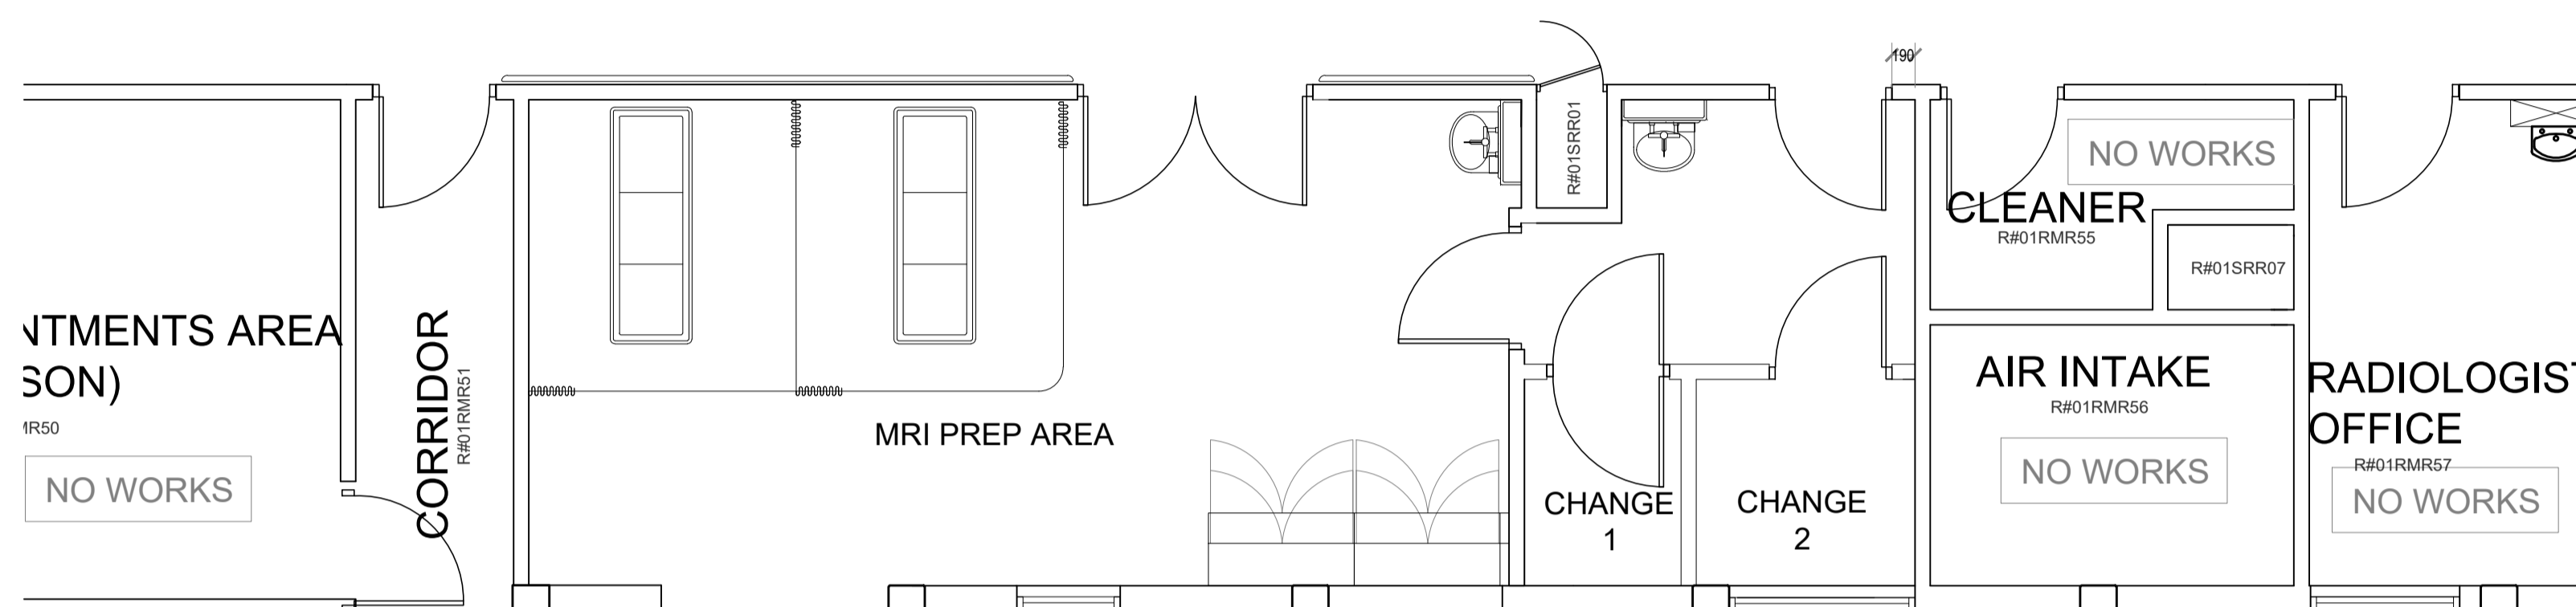


Drawing status

Drawn by AP	Size A1	Scale 1:50
Notes	Status	Rev Date
PRELIMINARY STUDY	P	- 31/03/21

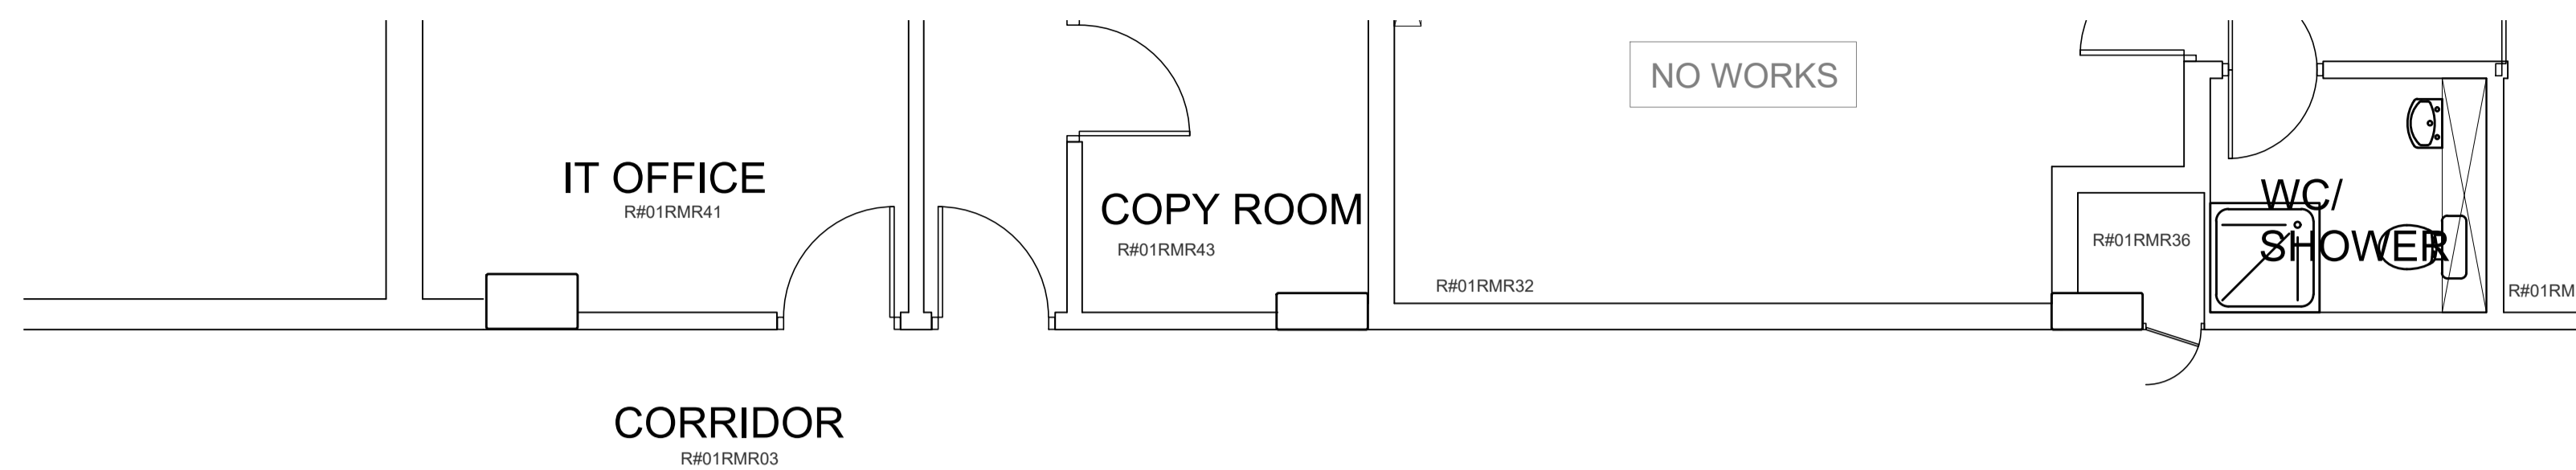

KEY

- DENOTES PROPOSED ABOVE GROUND DRAINAGE
- DENOTES SPOT FOR CORE DRILLING SLAB
- AAV DENOTES STUB STACK WITH AIR ADMITTANCE VALVE

PROPOSED DRAINAGE PLAN
1:50

Drawing status annotation
P-Preliminary T-Tender D-Design (post preliminary) C-Construction As-As Built

Client
BARNSELEY HOSPITAL NHS
FOUNDATION TRUST

Project title
MODULAR MRI

Project no
170/032

Drawing title
PROPOSED MRI
DRAINAGE PLAN

Drawing no	Status	Revision
(52)-01	P	-