

DO NOT SCALE FROM THIS DRAWING. VERIFY ALL DIMENSIONS AND SETTING OUT ON-SITE. NOTIFY ANY DISCREPANCIES TO THE ARCHITECT. FOR STRUCTURAL INFORMATION REFER TO STRUCTURAL ENGINEERS DRAWINGS. FOR M & E INFORMATION, REFER TO M & E ENGINEERS AND SUB-CONTRACTOR'S DRAWINGS. FOR HEALTH & SAFETY INFORMATION, REFER TO HEALTH & SAFETY RISK ASSESSMENTS.

Drainage Key


- Main Foul Water Drainage
- Inspection Chamber
- Gully
- Back Inlet Gully
- Soil Vent Pipe
- Rainwater Pipe

Blue denotes new drainage


Green denotes existing drainage

House built circa. 1979

Note:
Existing RWP to be replaced with new 65mm black circular rainwater pipes and existing guttering to be replaced with new 100mm black Ogee profiled guttering. Refer to above ground drainage notes on drawing no. 03003.

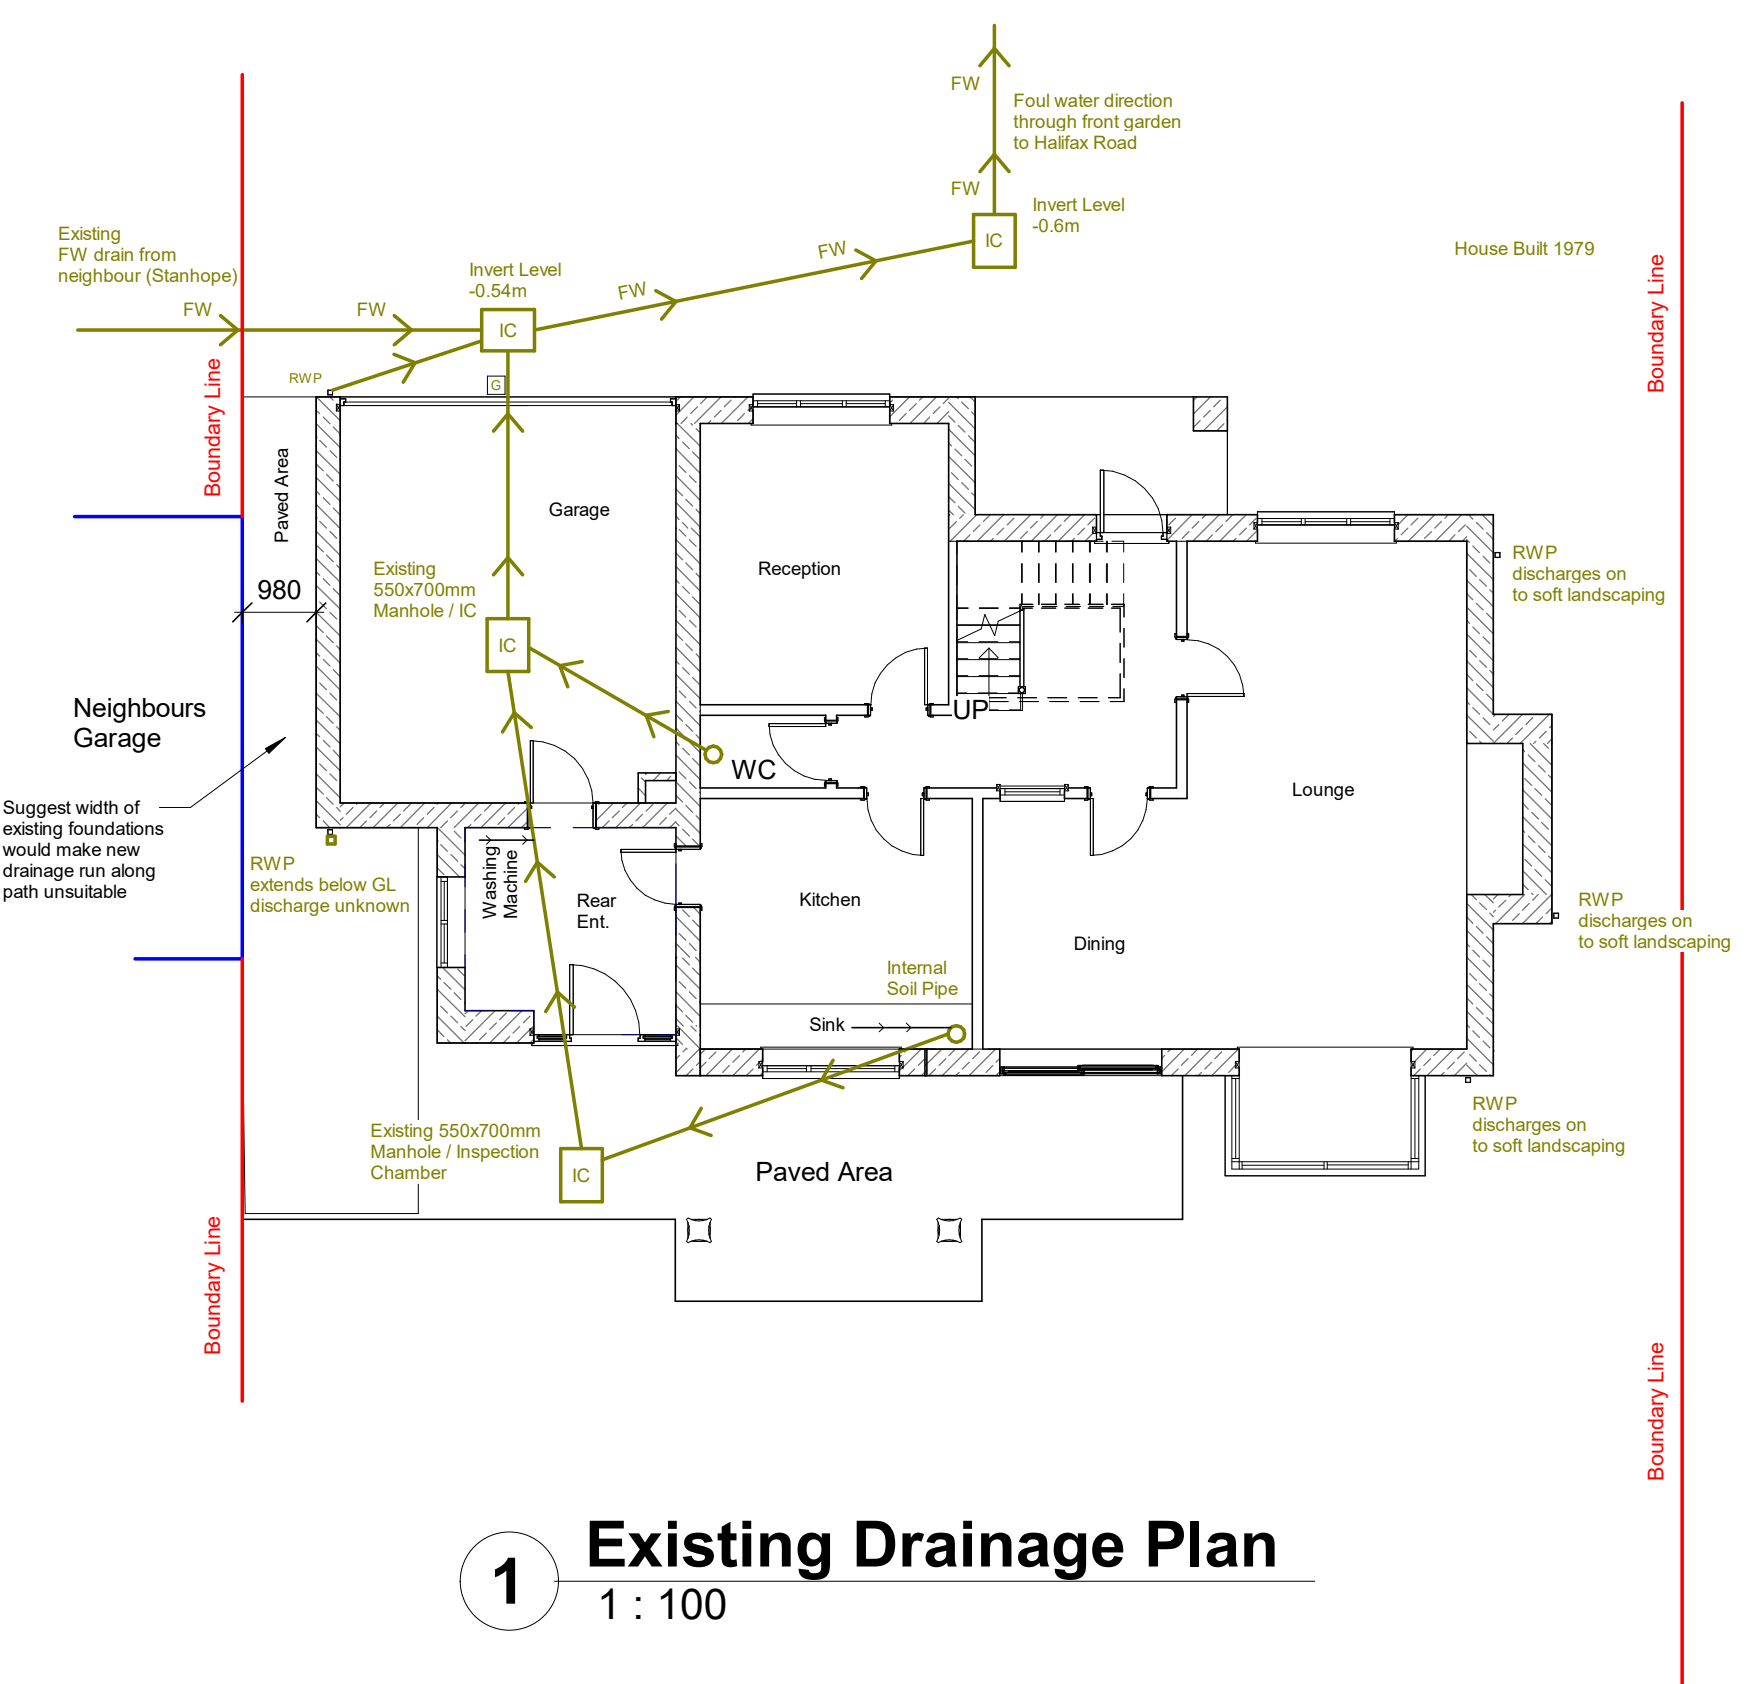

1 Existing Drainage Plan
1 : 100

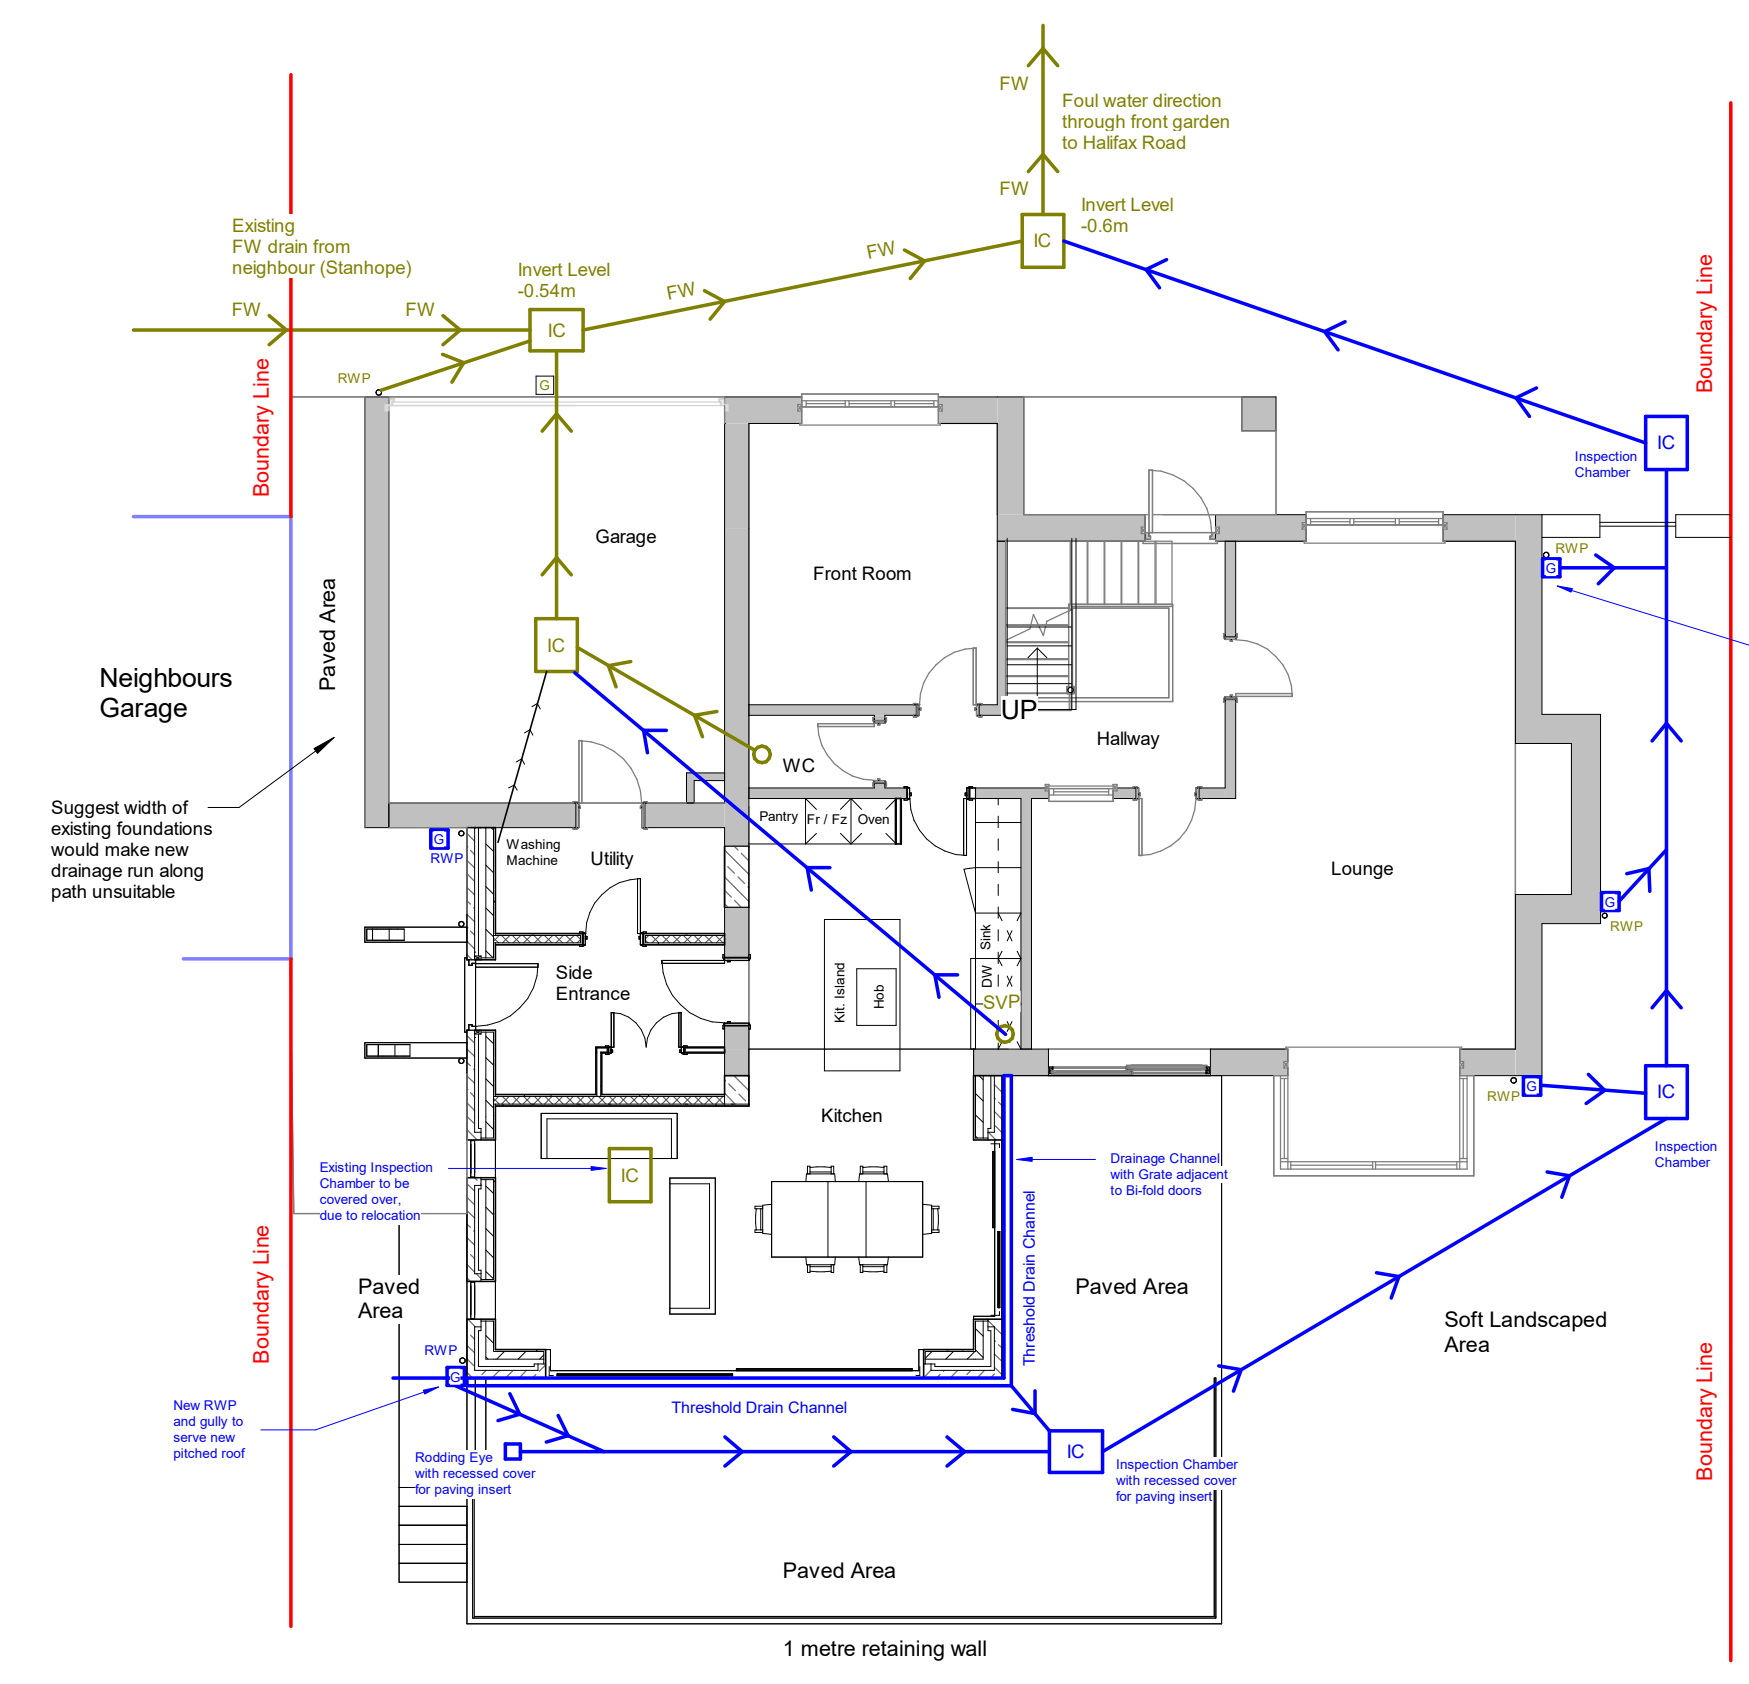

3 Proposed Drainage Plan
1 : 100



1:100 Scale Bar

P02	Drainage plan updated. Issued for Planning.	05.01.26	JB	DH
P01	Issued for Planning Pre-application.	09.08.24	JB	DH
No.	Description	Date	Check	Drawn

Revisions				
-----------	--	--	--	--

S03 - PRELIMINARY

CLIENT
Mr and Mrs Houltby

PROJECT
The Beeches Extension, Thurgoland

TITLE
Existing & Proposed Drainage Plan Layout

DRAWN	CHECKED	DATE	SCALE (@ A1)				
DH	JB	09.08.2024	1:100				
PROJECT NO.	ORIGINATOR	ZONE	LEVEL	TYPE	ROLE	NUMBER	REVISION
24001	MAD	S01	00	DR	A	52001	P02

© COPYRIGHT. ALL RIGHTS RESERVED. THIS DRAWING MUST BE READ IN CONJUNCTION WITH ALL OTHER RELEVANT DRAWINGS AND INFORMATION. ANY DISCREPANCIES MUST BE REPORTED TO MERIDIAN ARCHITECTURE IMMEDIATELY. THIS DRAWING MUST NOT BE USED FOR CONSTRUCTION UNLESS EXPRESSLY ISSUED FOR CONSTRUCTION. DO NOT SCALE OFF THIS DRAWING.