
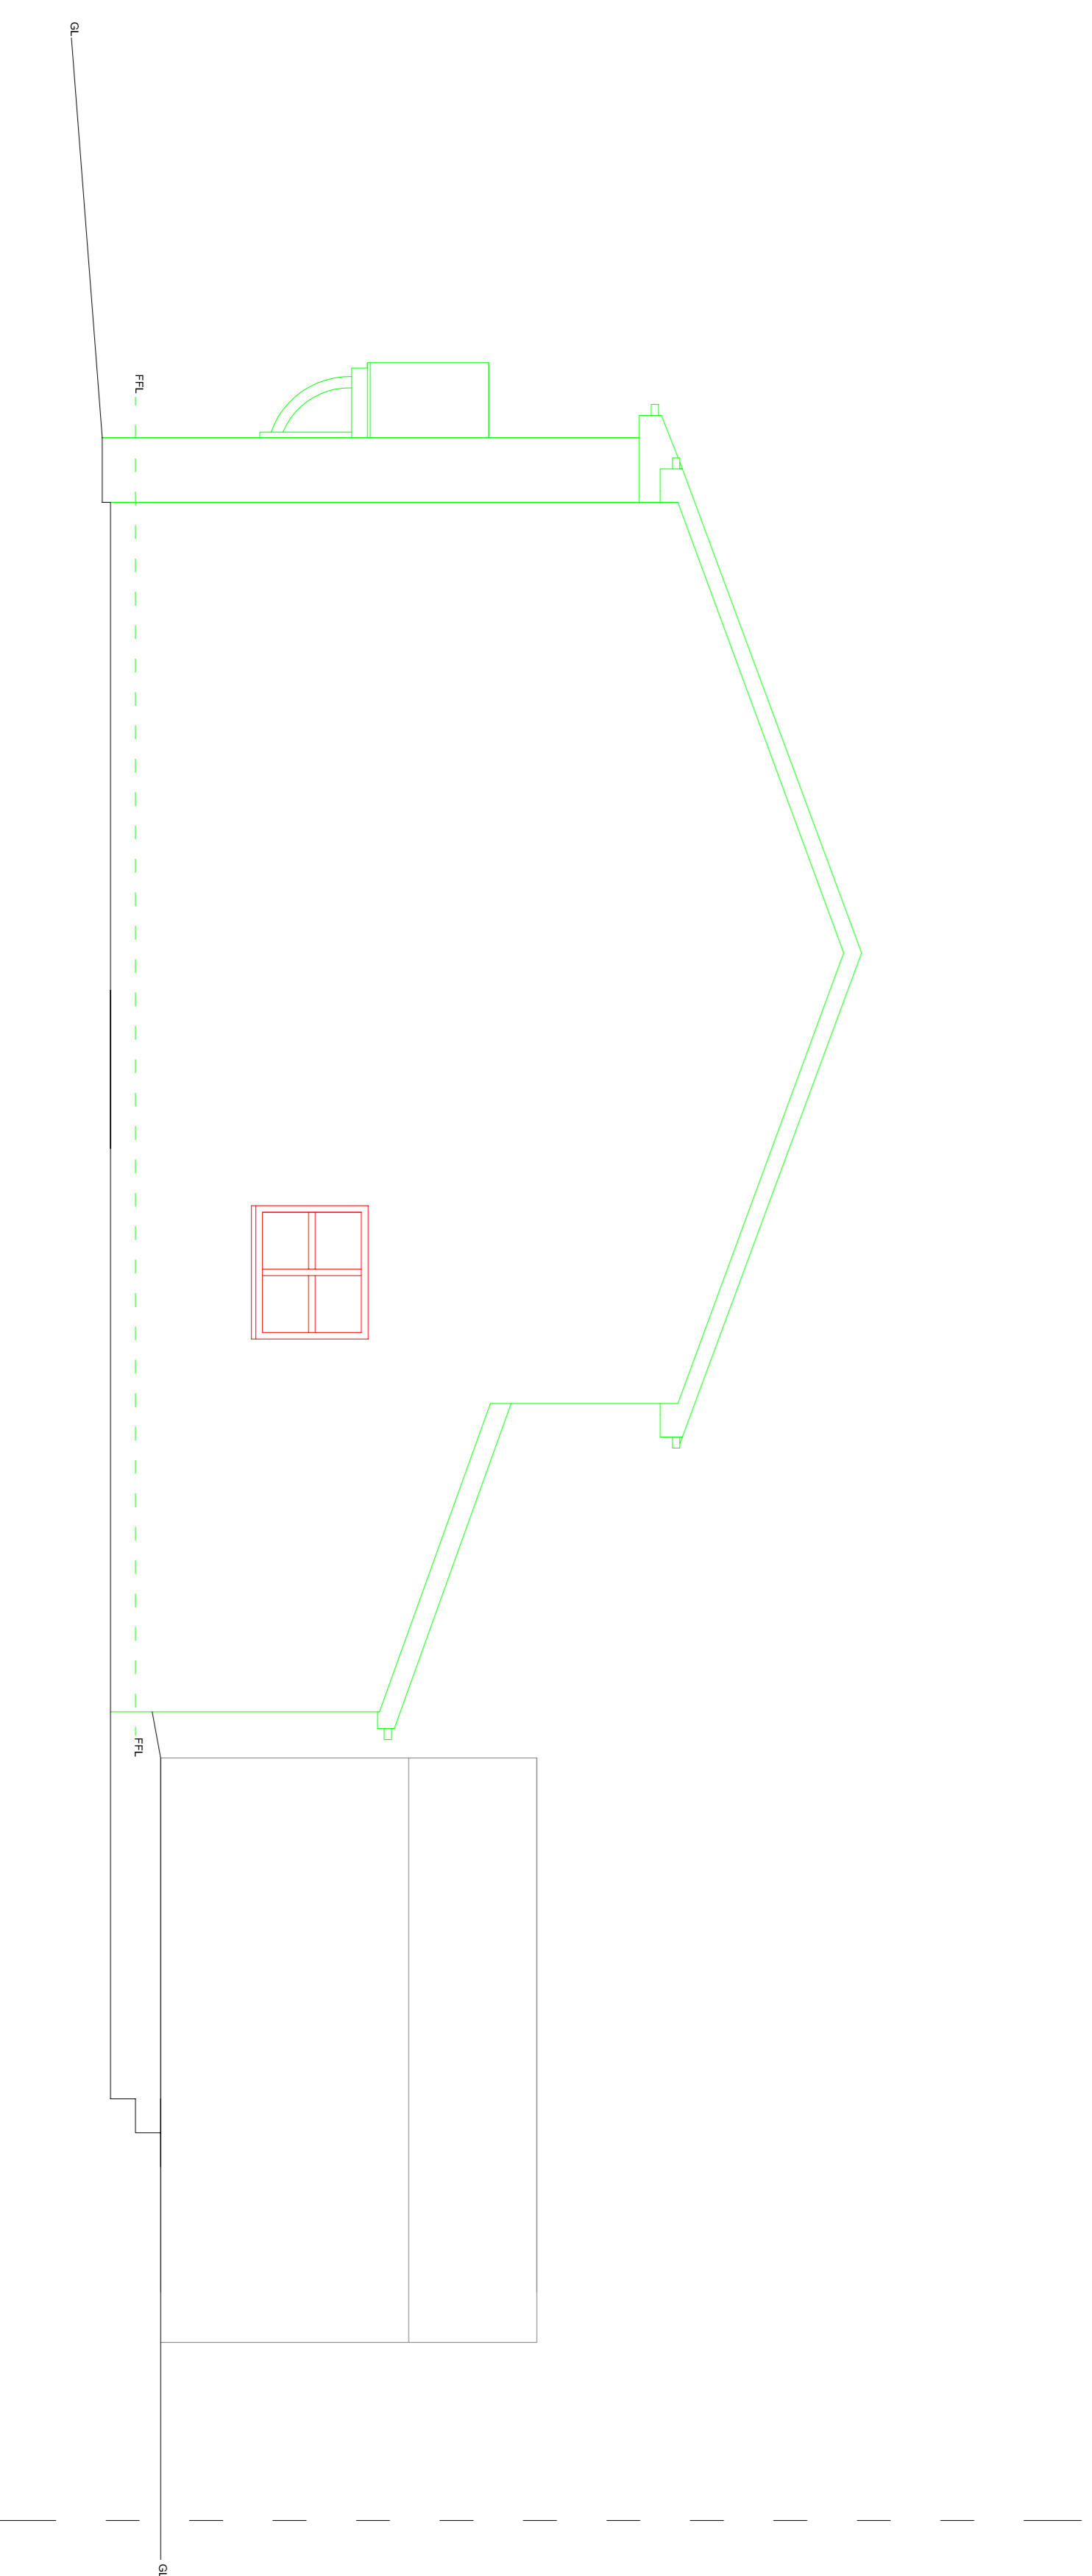
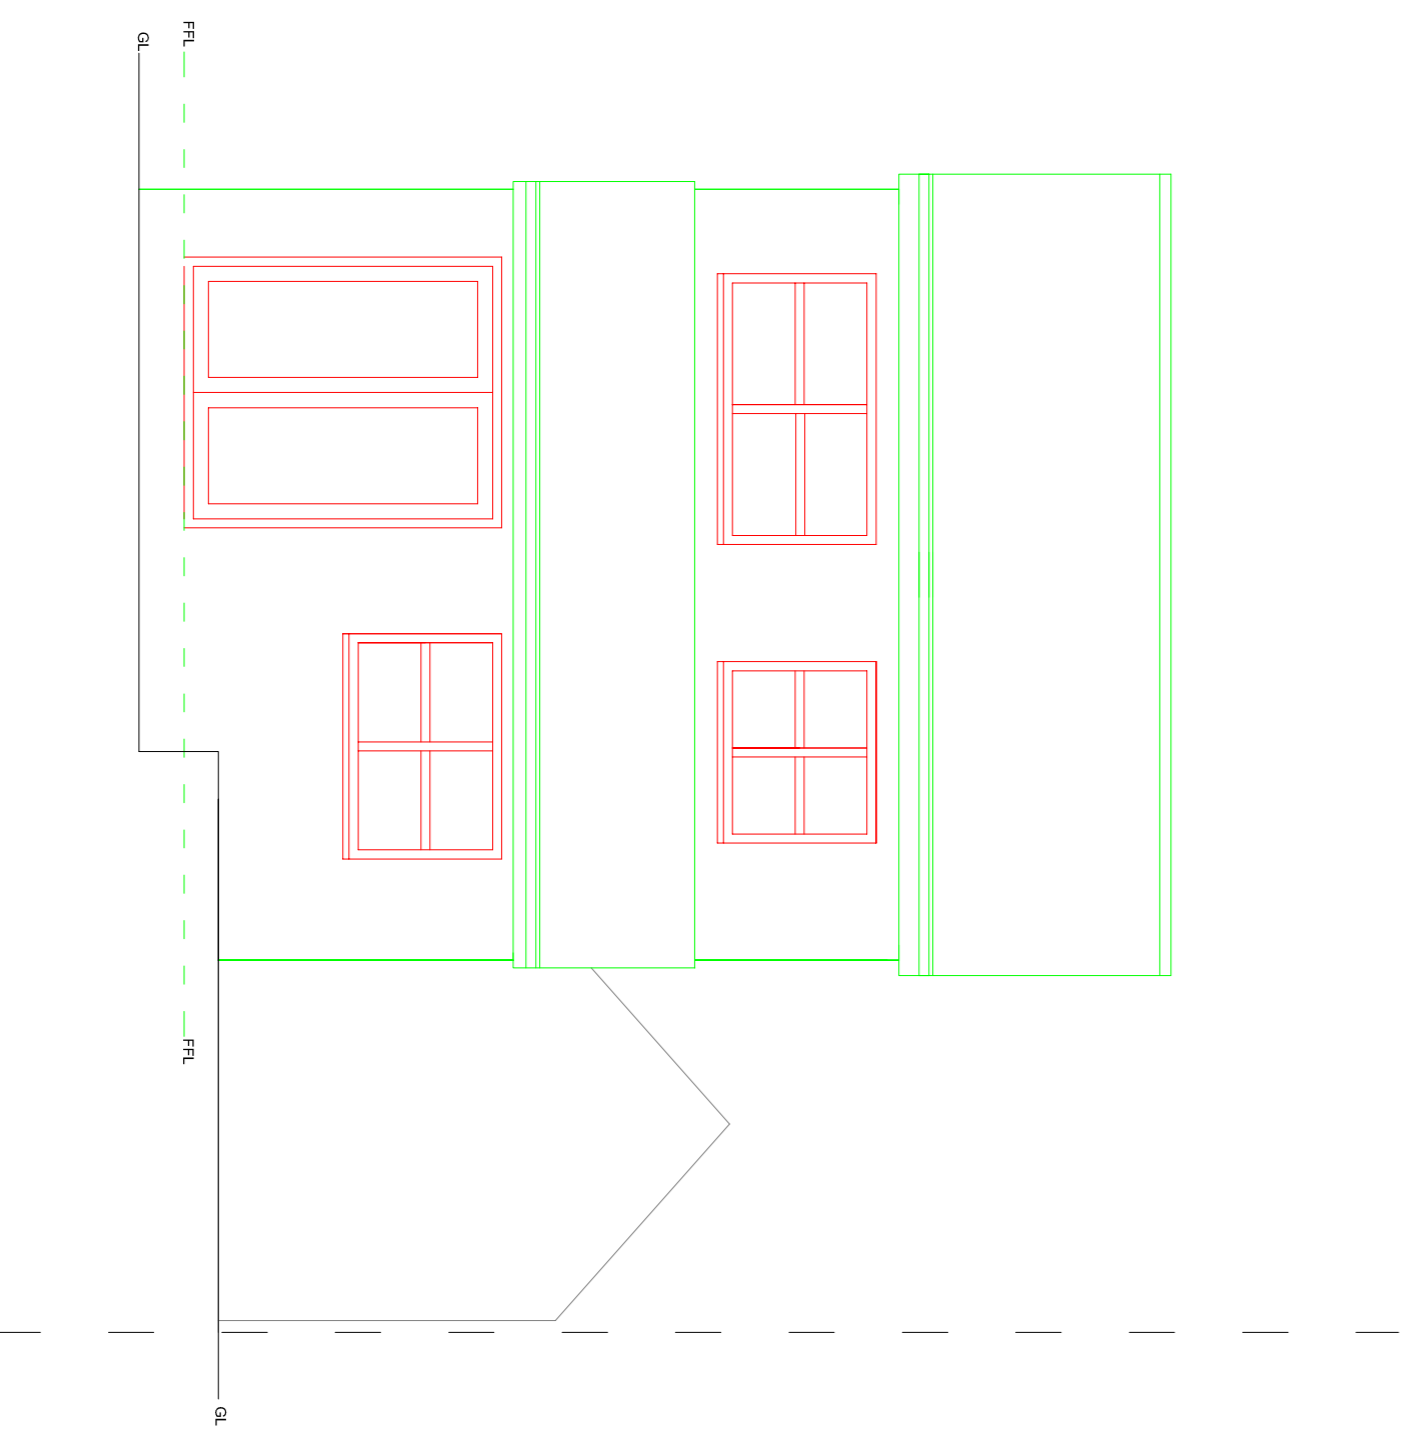



Note to contractor
 Contractor to check all dimensions on site. Do not scale from this drawing. All materials and works to comply with BS EN standards as appropriate and to meet Building Control approvals. Services to comply with L8 water regulations current gas and electricity supply regulations. All materials are to be new, unless otherwise described. This drawing to be read in conjunction with all other contract drawings and documents and also in conjunction where relevant with Mechanical & Electrical details and drawings. All works are to be carried out in compliance with CDM 2016 Regulations and all other Health and Safety legislation..

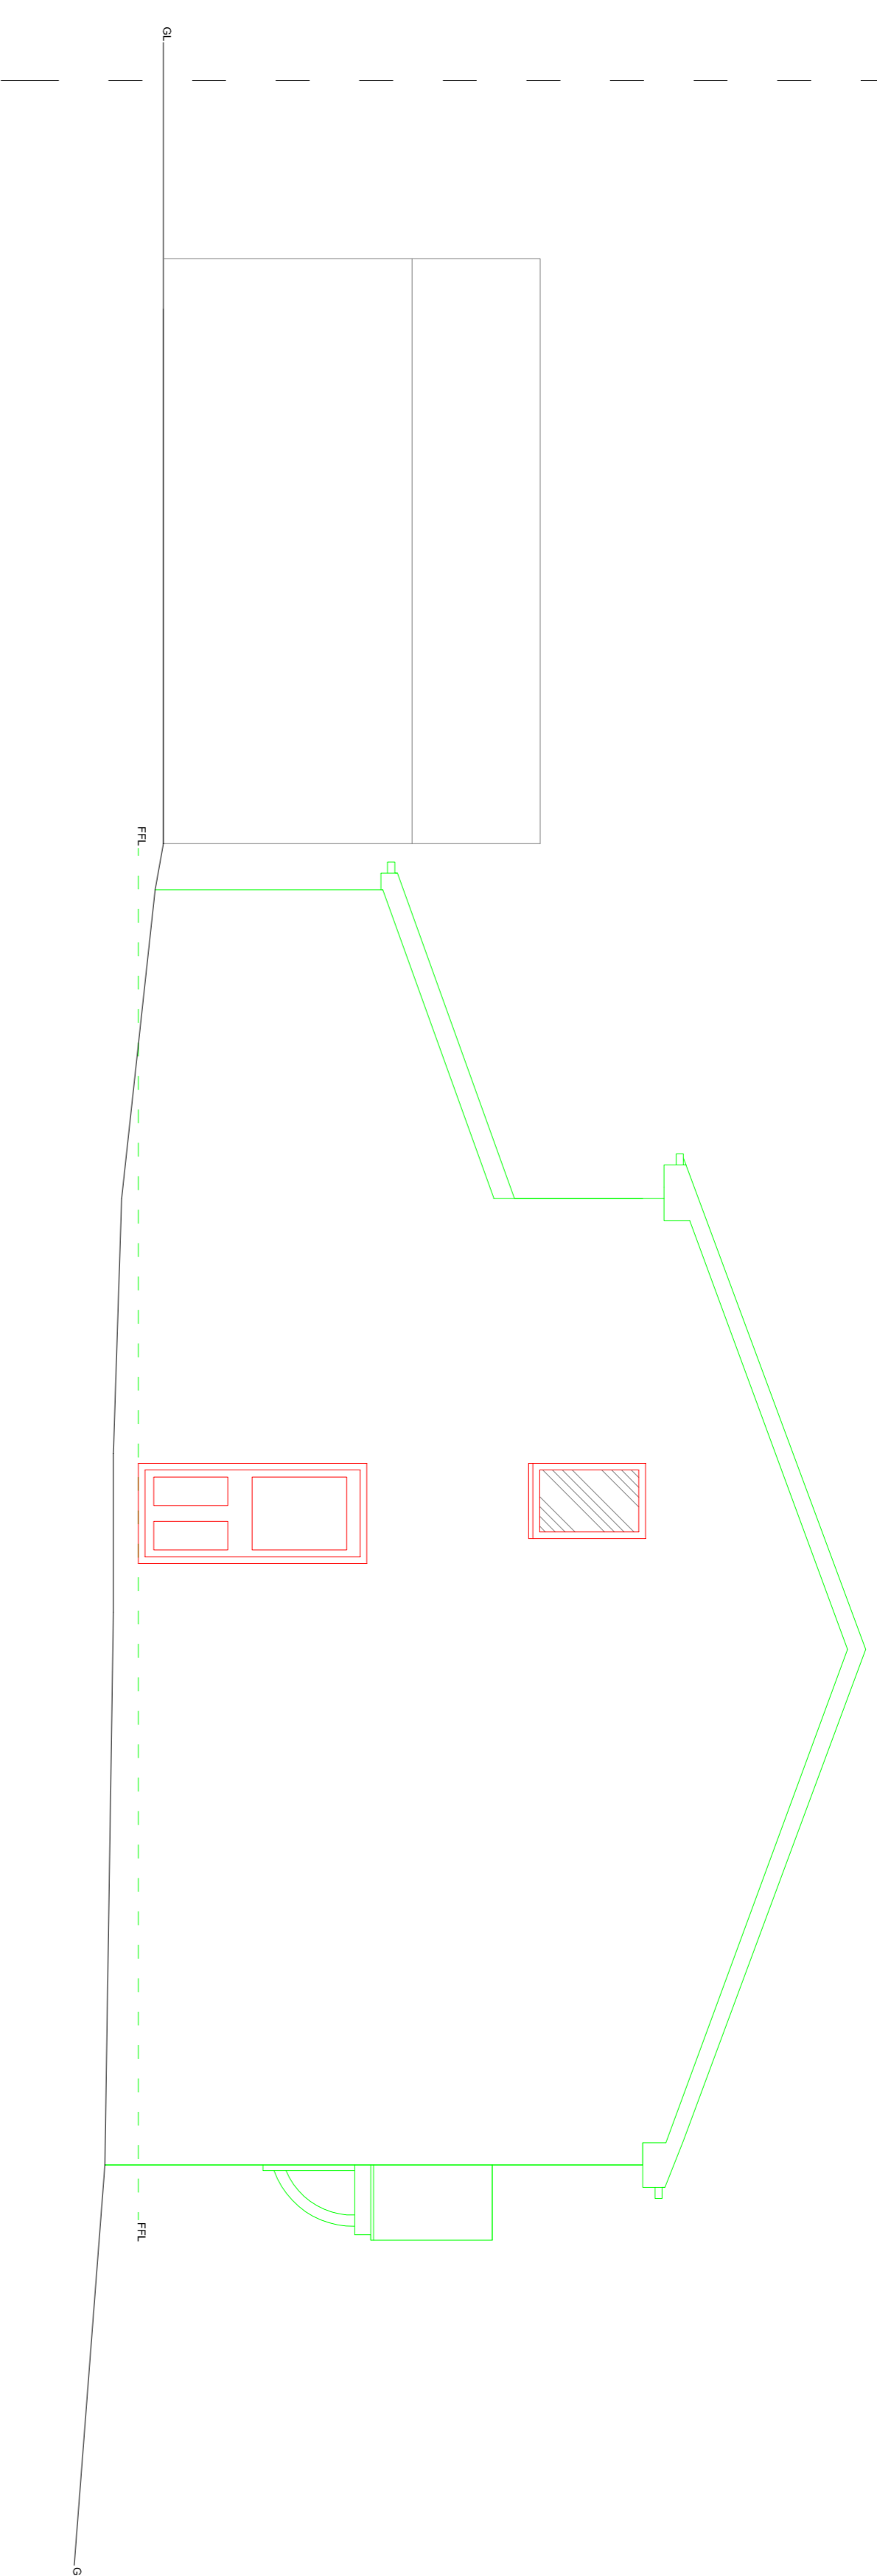

DO NOT SCALE
 © This drawing, including the design and technical information contained on it, is the copyright of sdb. The drawing may only be used for the specific purpose for which provided and may not be reproduced or copied without permission.

email: info@sdburyspecialist.com


PROJECT
Proposed Single Storey Side & Rear Extension
 2 Montrose Avenue, Darton, S75 5LS

DRAWING NUMBER	201810100104
DATE	JUL 18
SCALE	1:50
SHEET	A1
CHECKED	
REVISION	1.1

DRAWING TITLE
Existing Elevations