

©2020 Cellnex  
All rights reserved. No part of this publication may be reproduced, stored in a retrieval system or transmitted in any form or by any means (Electronic, Mechanical, Photocopying, Recording or otherwise), without the prior written consent of the Company.

NOTES

PROJ No. COL.MOD.UK.0004388

MBNL ID. 75956

4	COL.MOD.UK.0004388 PLANNING	26/09/24	WHP WHP
3	0023760 AS BUILT	23/12/22	BEA MIT
2	0023760 PLANNING ISSUE	17/08/22	HFC HFC
1	9BMOBL MD CREATE	17/03/20	KG KG
ISS	REVISION	DATE	DRN APP

cellnex

driving telecom connectivity

CELLNEX UK

R+, 4TH FLOOR, 2 BLAGRAVE STREET, READING, RG1 1AZ

Tel. 020 4526 8553

SITE No 87331

BARNSELY MARKET HILL

BLAH BAR

1 MARKET HILL

BARNSELY

SOUTH YORKSHIRE

S70 2PU

NGR SE 34410 06436

OS GRID 434410 406436

TITLE

SITE PLAN

PROPOSED

H3G & BTEE LTD

SCALE 1:100

DRAWN KG 12/03/20

APPROVED WHP 26/09/24

DRG No. 87331-02-100-MD004

Sheet 1 of 1

Rev 4

FEINT DETAILS INDICATE LOCATIONS RESERVED FOR OTHER PROPOSALS WHICH MAY BE THE SUBJECT OF SEPARATE APPLICATIONS



©2020 Cellnex  
All rights reserved. No part of this publication may be reproduced, stored in a retrieval system or transmitted in any form or by any means (Electronic, Mechanical, Photocopying, Recording or otherwise), without the prior written consent of the Company.

NOTES

BTEE 1No. MK1 BOB I.D. No. EQU200000000191160 TO BE REMOVED

PROPOSED BTEE 3No. MK2 BOB's I.D. No's. EQU200000000544320, EQU200000000544321 & EQU200000000544322 TO BE INSTALLED ON UNISTRUCT FRAME FIXED TO WALL

BTEE 1No. BTS3900AL CABINET  
I.D. No. EQU100000000088684 TO BE REMOVED

PROPOSED BTEE 1No. AIRO CABINET  
I.D. No. EQU100000000364977 TO BE INSTALLED ON STEEL GRILLAGE

H3G 1No. E-HYBRID CABINET  
I.D. No. EQU100000000086910 ON STEEL GRILLAGE c/w 3No. 2460 ERS's & 3No. 4480 ERS's

H3G 3No. RD0877 COMBINERS  
I.D. No's. EQU200000000191137, EQU200000000191147 & EQU200000000191149 ON WALL ADJACENT TO EHYBRID CABINET

H3G & BTEE 1No. LINK A/C Mk3 CABINET  
I.D. No. EQU100000000086907 ON STEEL GRILLAGE C/W COMMS & REC EQUIPMENT

H3G & BTEE 1No. FLEXI STACK  
I.D. No. EQU100000000086908 ON STEEL GRILLAGE C/W Mk2 UCU's

H3G & BTEE 300mm WIDE CABLE TRAY

LOWER ROOF LEVEL 10.50m

UPPER ROOF LEVEL 13.50m

EQUIPMENT PLAN



FEINT DETAILS INDICATE LOCATIONS RESERVED FOR OTHER PROPOSALS WHICH MAY BE THE SUBJECT OF SEPARATE APPLICATIONS

PROJ No. COL.MOD.UK.0004388

MBNL ID. 75956

4	COL.MOD.UK.0004388 PLANNING	26/09/24	WHP	WHP
3	0023760 AS BUILT	23/12/22	BEA	MIT
2	0023760 PLANNING ISSUE	17/08/22	HFC	HFC
1	9BMOBL MD CREATE	17/03/20	KG	KG
ISS	REVISION	DATE	DRN	APP



CELLNEX UK  
R+, 4TH FLOOR, 2 BLA GRAVE STREET, READING, RG1 1AZ  
Tel. 020 4526 8553

SITE No 87331  
BARNSELY MARKET HILL  
BLAH BAR  
1 MARKET HILL  
BARNSELY  
SOUTH YORKSHIRE  
S70 2PU

NGR SE 34410 06436

OS GRID 434410 406436

TITLE  
EQUIPMENT PLAN  
PROPOSED  
H3G & BTEE LTD

SCALE 1:50

DRAWN KG 12/03/20

APPROVED WHP 26/09/24

DRG No. Sheet 1 of 1 Rev

87331-02-101-MD004 4

H3G 3No. RD0448 1800/2100 MHA's I.D. No's. EQU200000000191058, EQU200000000191076 & EQU200000000191086 ON CABLE TRAY (BEHIND)

H3G & BTEE 3No. RD0448 1800/2100 MHA's I.D. No's. EQU200000000191089, EQU200000000191117 & EQU200000000191118 TO BE REMOVED (BEHIND)

H3G 3No. RD0877 COMBINERS I.D. No's. EQU200000000191137, EQU200000000191147 & EQU200000000191149 ON WALL ADJACENT TO EHYBRID CABINET (BEHIND)

H3G & BTEE 3No. RD0629 1800/2100/2600 COMBINERS I.D. No's. EQU200000000191146, EQU200000000191151 & EQU200000000191152 TO BE REMOVED (BEHIND)

H3G & BTEE 3 No. AW3363 FLAGPOLE TRI-SECTOR ANTENNAS AT 18.40m MEAN HEIGHT, BEARINGS 330°, 90° & 210° E.T.N. I.D. No's. EQU900204776, EQU900204777, EQU900181323 TO BE REMOVED

PROPOSED H3G & BTEE 3No. AW3836 FLAGPOLE TRI-SECTOR ANTENNA AT 18.40m MEAN HEIGHT, BEARINGS 330°, 90° & 210° E.T.N. I.D. No's. EQU200000000544299, EQU200000000544300 & EQU200000000544301 TO BE INSTALLED ON PROPOSED ALPHA AW3836 MOUNTING POLE

H3G 3No. E15R02P11 700/800 MHA's I.D. No's. EQU200000000191049, EQU200000000191057 & EQU200000000191110 ON GANTRY SUPPORT POLES

1800mm HIGH PARAPET WALL

LOWER ROOF LEVEL 10.5m

TOP OF STRUCTURE 19.8m

18.40m

BTEE 1 No. MK1 BOB I.D. No. EQU200000000191154 & 3No. 3262 2600 RRH's I.D. No's. EQU200000000288347, EQU200000000288349 & EQU200000000288350 TO BE REMOVED

PROPOSED BTEE 3No. 2460 700/800 ERS's AT 14.9m MEAN I.D. No's. EQU200000000544311, EQU200000000544312 & EQU200000000544313, 1No. MK2 BOB AT 14.4m MEAN I.D. No. EQU200000000191157 TO BE INSTALLED ON EXISTING GANTRY SUPPORT POLE

PROPOSED BTEE 3No. 4419 2600 ERS's AT 14.9m MEAN I.D. No's. EQU200000000544317, EQU200000000544318 & EQU200000000544319, 1No. MK2 BOB AT 14.4m MEAN I.D. No. EQU200000000191158 TO BE INSTALLED ON PROPOSED GANTRY SUPPORT POLE

PROPOSED 6No. RD0759-H4-09 COMBINERS TO BE INSTALLED ON PROPOSED GANTRY SUPPORT POLE

PROPOSED BTEE 1No. GPS NODE AT 15.3m MEAN I.D. No. EQU200000000544329 TO BE INSTALLED ON PROPOSED GANTRY SUPPORT POLE

PROPOSED BTEE 3No. 8863 3500 ERS's AT 14.9m MEAN I.D. No's. EQU200000000544305, EQU200000000544306 & EQU200000000544307, 1No. MK2 BOB AT 14.4m MEAN I.D. No. EQU200000000191163 TO BE INSTALLED ON PROPOSED GANTRY SUPPORT POLE

UPPER ROOF LEVEL 13.5m

 
H3G & BTEE 300mm WIDE VERTICAL CABLE TRAY RUNNING UP WALL

BTEE 1No. BTS3900AL CABINET I.D. No. EQU100000000088684 TO BE REMOVED (BEHIND)

PROPOSED BTEE 1No. AIRO CABINET I.D. No. EQU100000000364977 TO BE INSTALLED ON STEEL GRILLAGE (BEHIND)

BTEE 1No. MK1 BOB I.D. No. EQU200000000191160 TO BE REMOVED (BEHIND)

PROPOSED BTEE 3No. MK2 BOB's I.D. No's. EQU200000000544320, EQU200000000544321 & EQU200000000544322 TO BE INSTALLED ON UNISTRUCT FRAME FIXED TO WALL (BEHIND)



EAST ELEVATION

FEINT DETAILS INDICATE LOCATIONS RESERVED FOR OTHER PROPOSALS WHICH MAY BE THE SUBJECT OF SEPARATE APPLICATIONS

G.L.0.0m

©2020 Cellnex  
All rights reserved. No part of this publication may be reproduced, stored in a retrieval system or transmitted in any form or by any means (Electronic, Mechanical, Photocopying, Recording or otherwise), without the prior written consent of the Company.

NOTES

PROJ No. COL.MOD.UK.0004388

MBNL ID. 75956

4	COL.MOD.UK.0004388 PLANNING	26/09/24	WHP	WHP
3	0023760 AS BUILT	23/12/22	BEA	MIT
2	0023760 PLANNING ISSUE	17/08/22	HFC	HFC
1	9BMOBL MD CREATE	17/03/20	KG	KG
ISS	REVISION	DATE	DRN	APP



CELLNEX UK  
R+, 4TH FLOOR, 2 BLAGRAVE STREET, READING, RG1 1AZ  
Tel. 020 4526 8553

SITE No 87331  
BARNLEY MARKET HILL  
BLAH BAR  
1 MARKET HILL  
BARNLEY  
SOUTH YORKSHIRE  
S70 2PU

NGR SE 34410 06436

OS GRID 434410 406436

TITLE  
ELEVATION  
PROPOSED  
H3G & BTEE LTD

SCALE 1:100

DRAWN KG 12/03/20

APPROVED WHP 26/09/24

DRG No. Sheet 1 of 1 Rev  
87331-02-150-MD004 4





©2020 Cellnex  
All rights reserved. No part of this publication may be reproduced, stored in a retrieval system or transmitted in any form or by any means (Electronic, Mechanical, Photocopying, Recording or otherwise), without the prior written consent of the Company.

NOTES

PROJ No. COL.MOD.UK.0004388

MBNL ID. 75956

4	COL.MOD.UK.0004388 PLANNING	26/09/24	WHP	WHP
3	0023760 AS BUILT	23/12/22	BEA	MIT
2	0023760 PLANNING ISSUE	17/08/22	HFC	HFC
1	9BMOBL MD CREATE	17/03/20	KG	KG
ISS	REVISION	DATE	DRN	APP



CELLNEX UK  
R+, 4TH FLOOR, 2 BLA GRAVE STREET, READING, RG1 1AZ  
Tel. 020 4526 8553

SITE No. 87331  
BARNLEY MARKET HILL  
BLAH BAR  
1 MARKET HILL  
BARNLEY  
SOUTH YORKSHIRE  
S70 2PU

NGR SE 34410 06436

OS GRID 434410 406436

TITLE  
ANTENNA PLAN  
PROPOSED  
H3G & BTEE LTD


SCALE 1:50

DRAWN KG 12/03/20

APPROVED WHP 26/09/24

DRG No. Sheet 1 of 1 Rev

87331-02-151-MD004 4

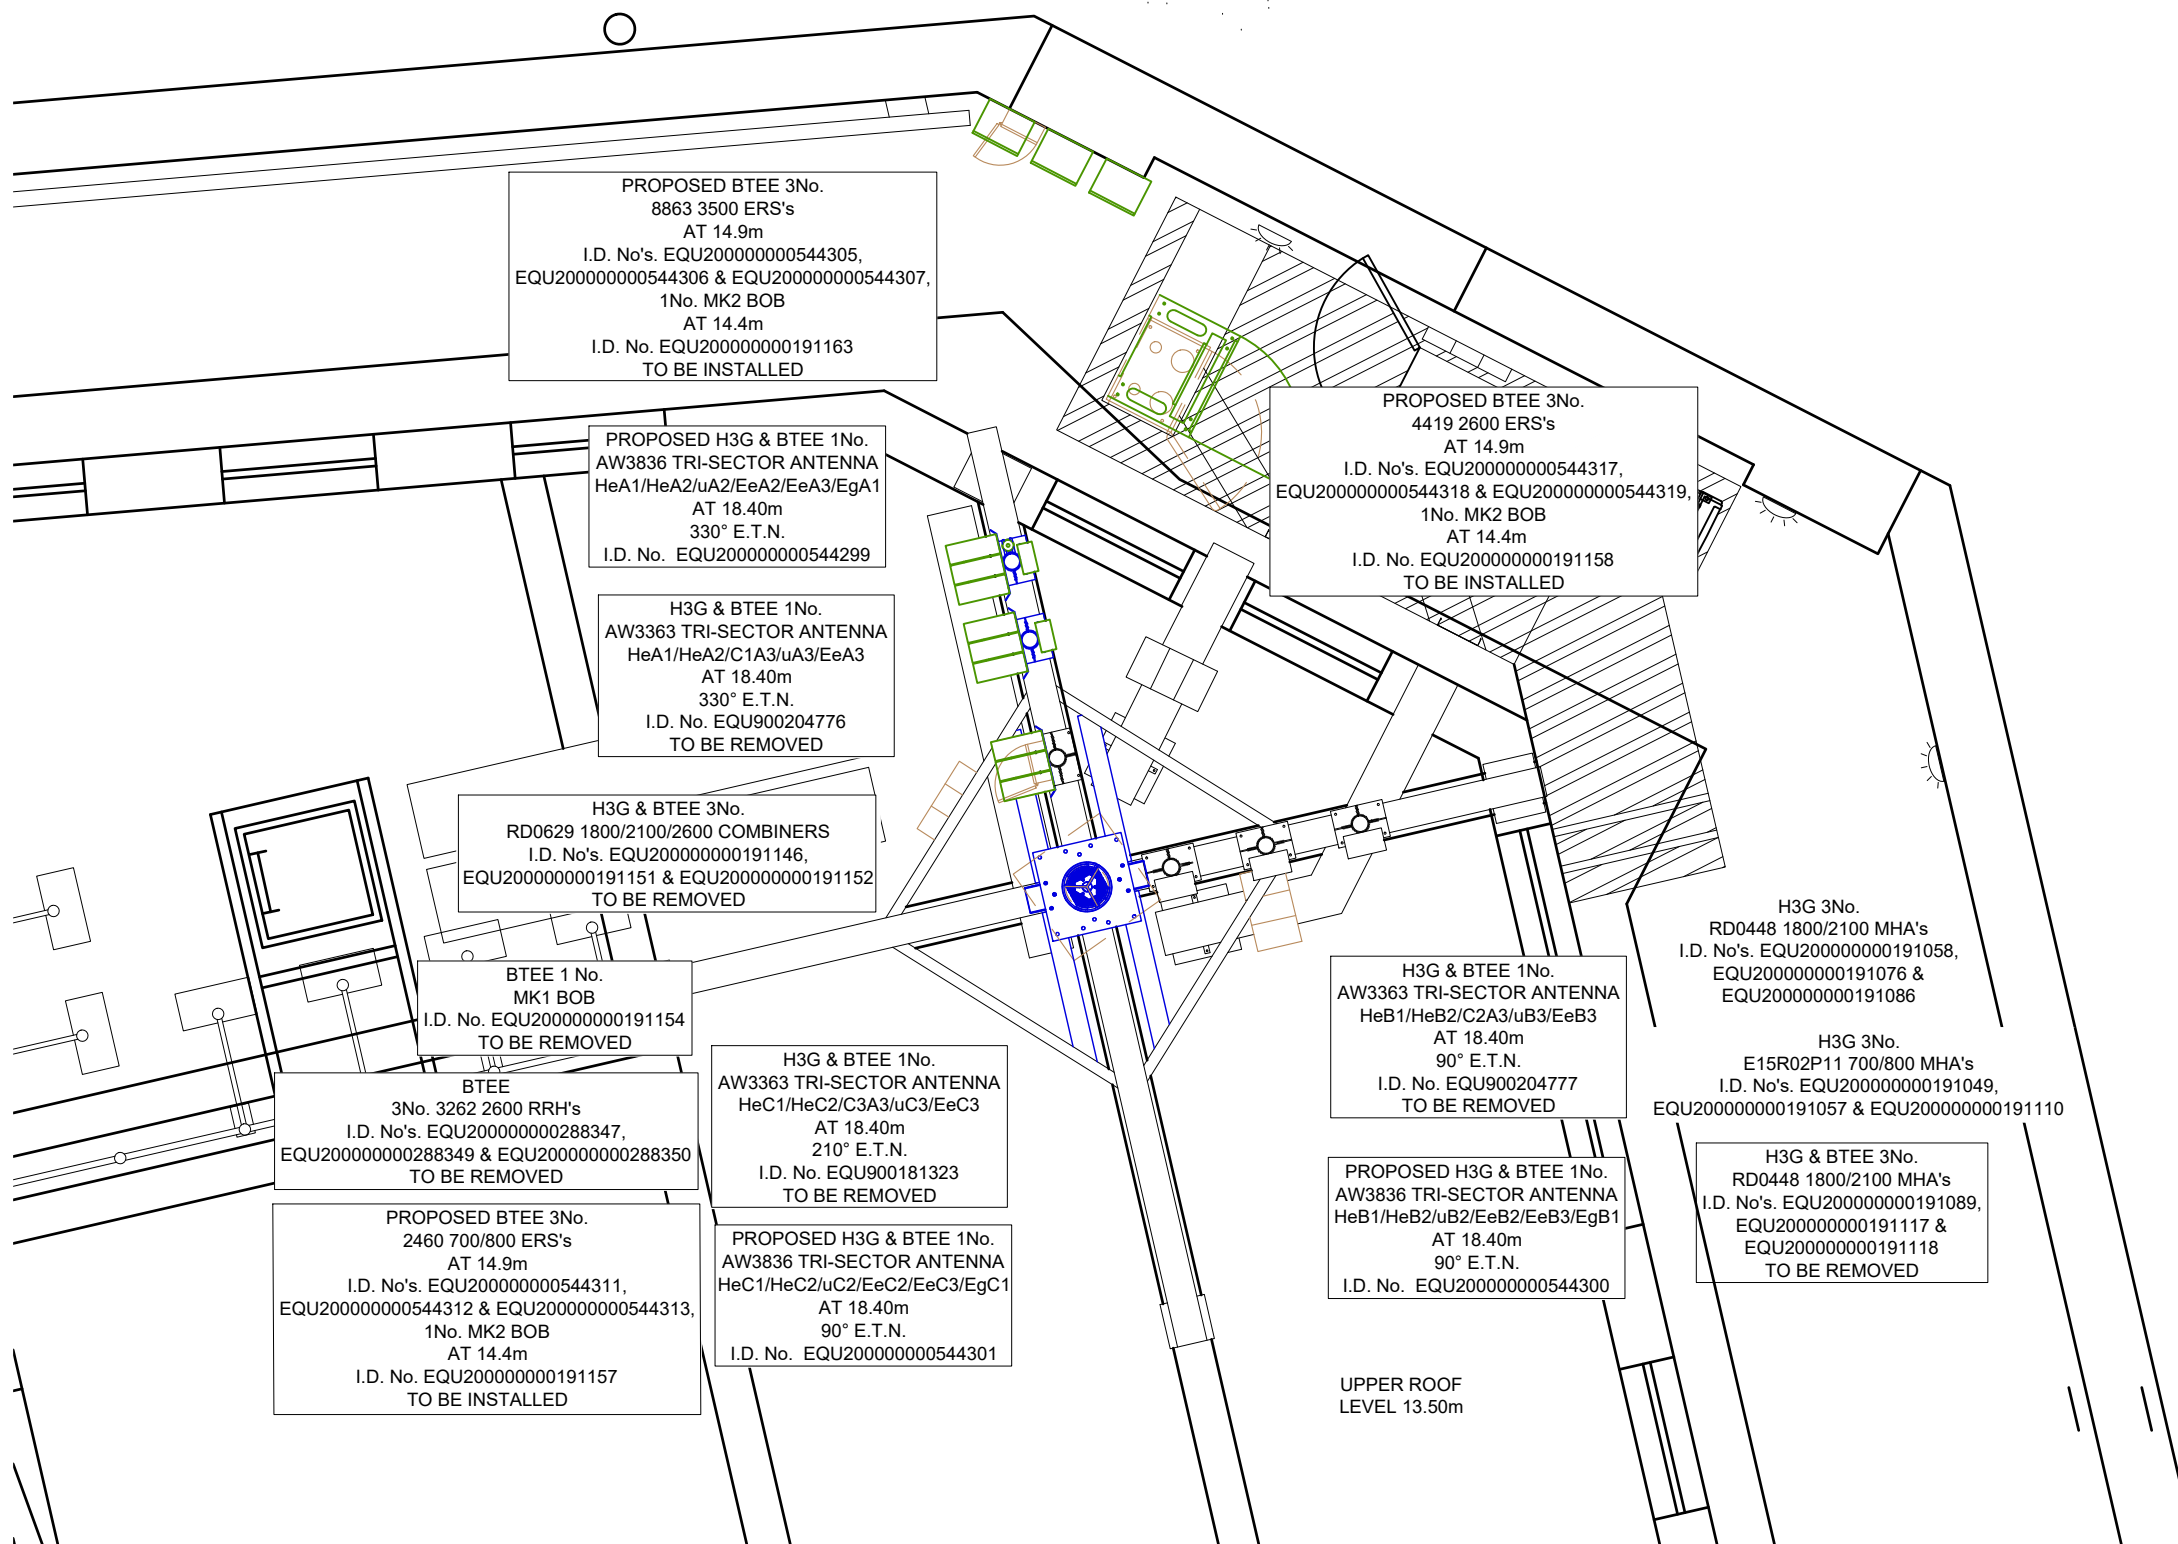

ANTENNA PLAN AT 18.40m



FEINT DETAILS INDICATE LOCATIONS  
RESERVED FOR OTHER PROPOSALS  
WHICH MAY BE THE SUBJECT OF  
SEPARATE APPLICATIONS