




Contractor must verify all dimensions on site before commencing any work or shop drawings. If this drawing exceeds the quantities taken in any way, the building designers are to be informed before the work is initiated.
 Only figured dimensions to be taken from this drawing. Do not scale off this drawing.
 Drawing based on Ordnance Survey and/or existing record drawings - design and drawing content subject to Site Survey, Structural Survey, Site Investigations, Planning and Statutory Requirements and Approvals.
 All drainage layouts are schematic and invert levels must be established prior to construction.

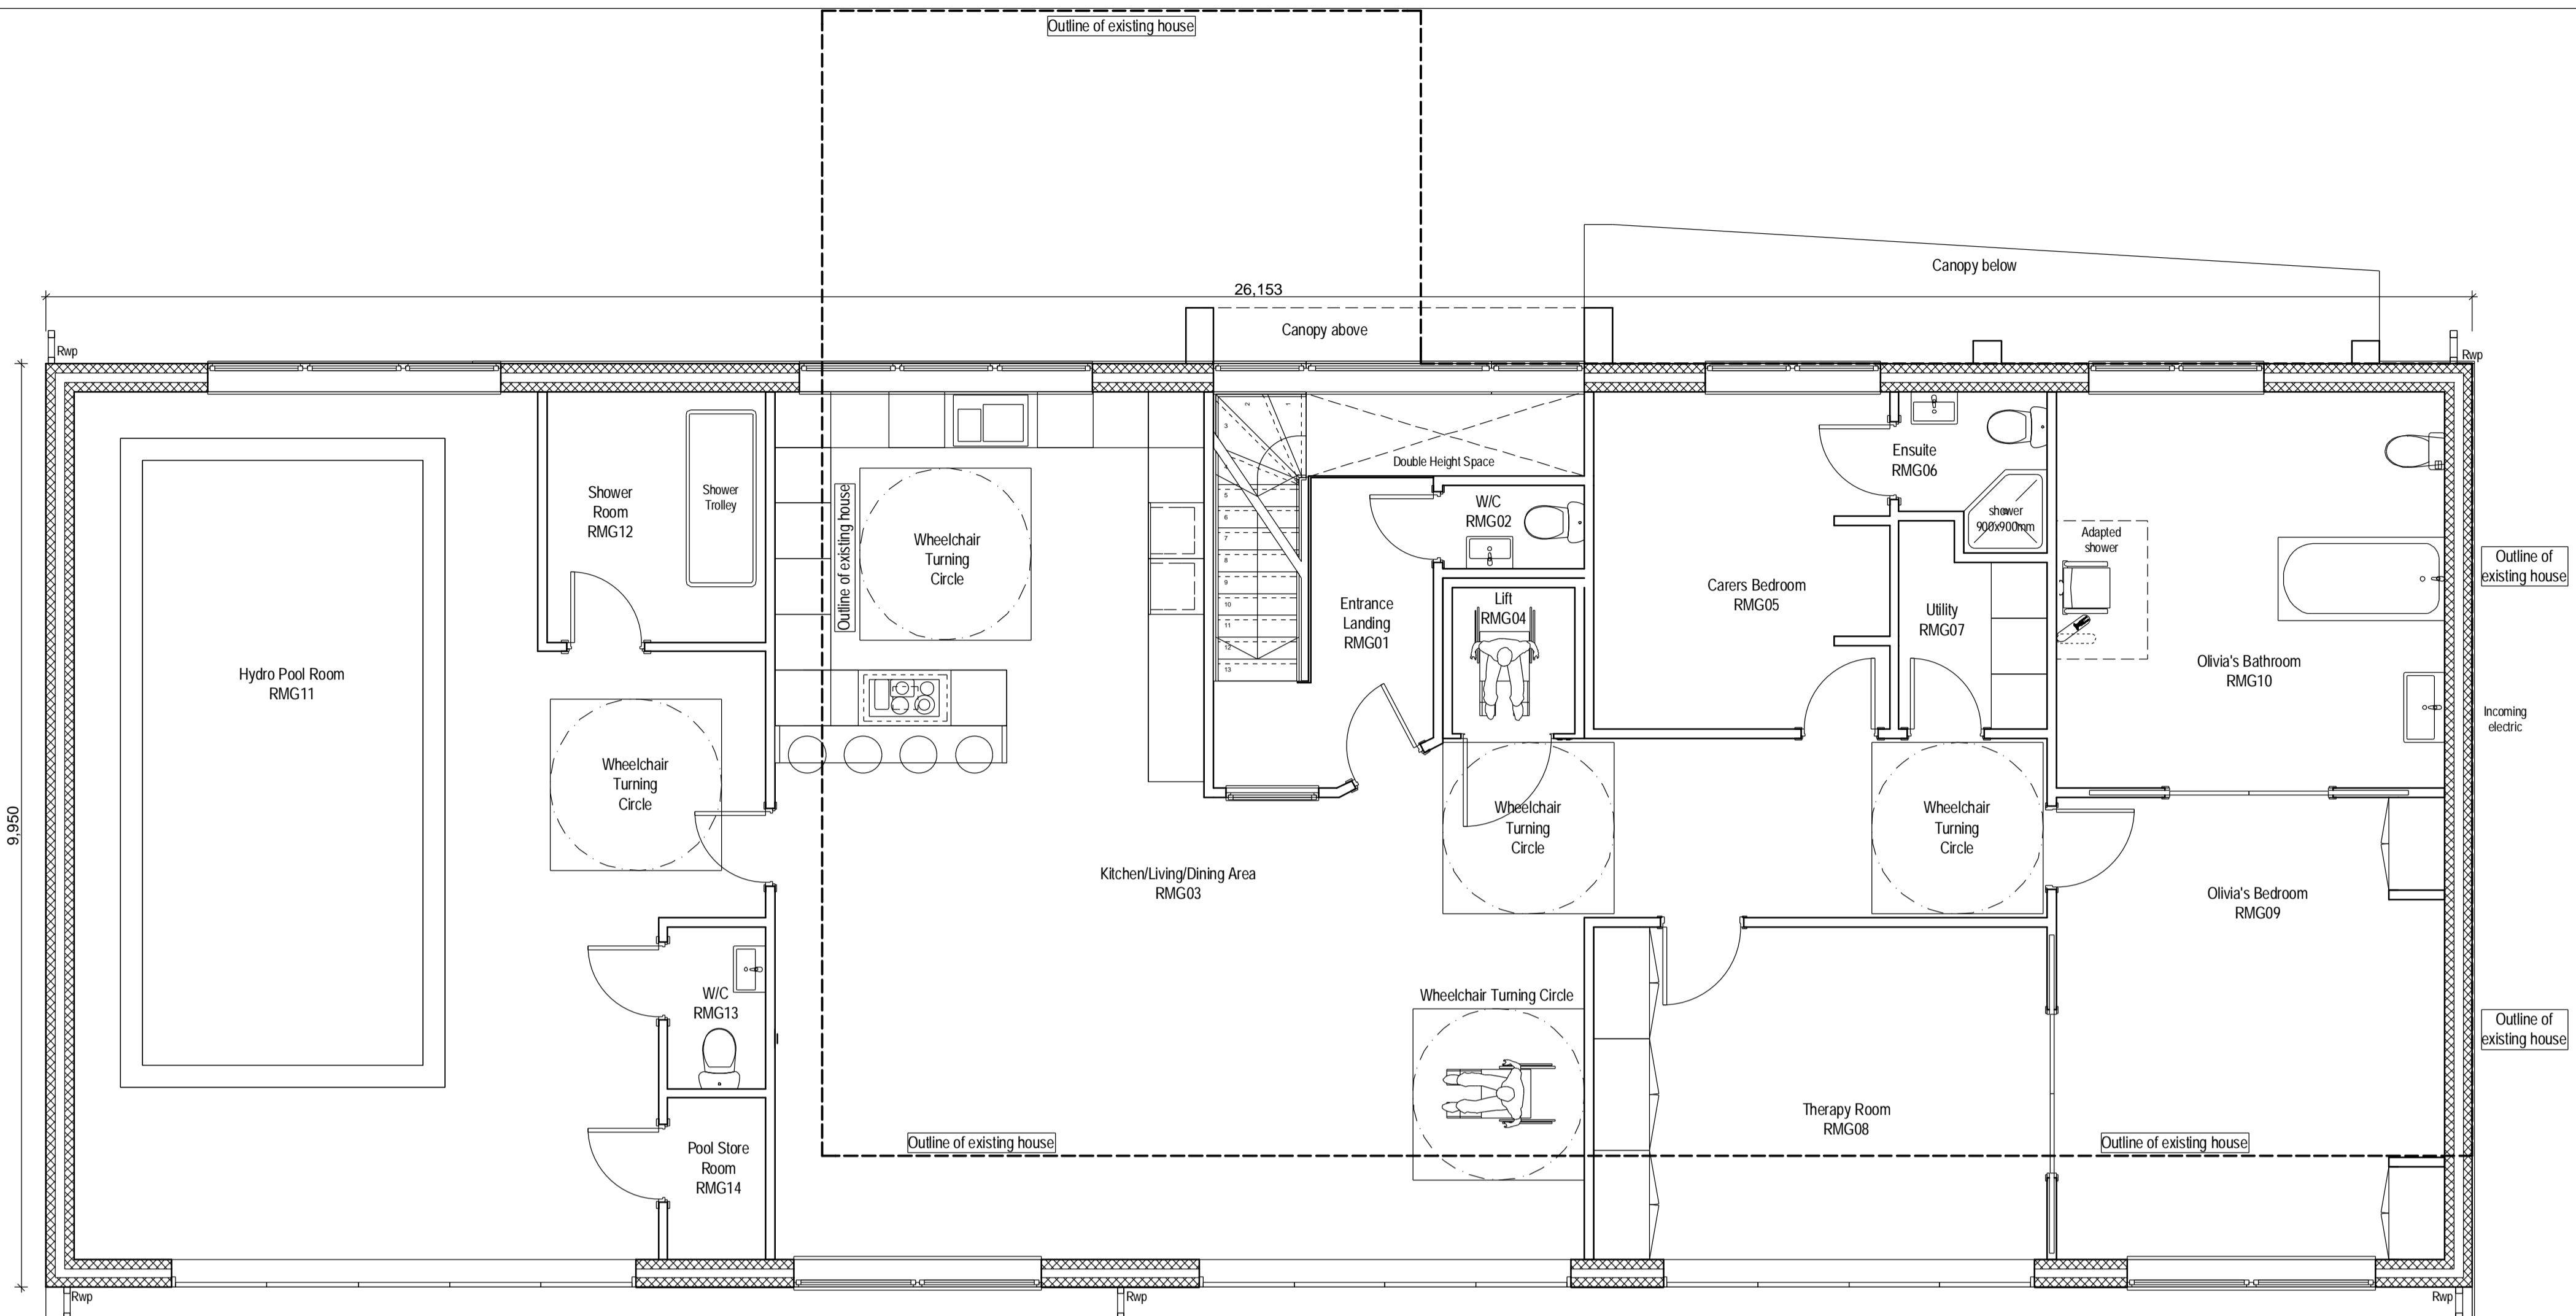


First Floor Plan 1:50

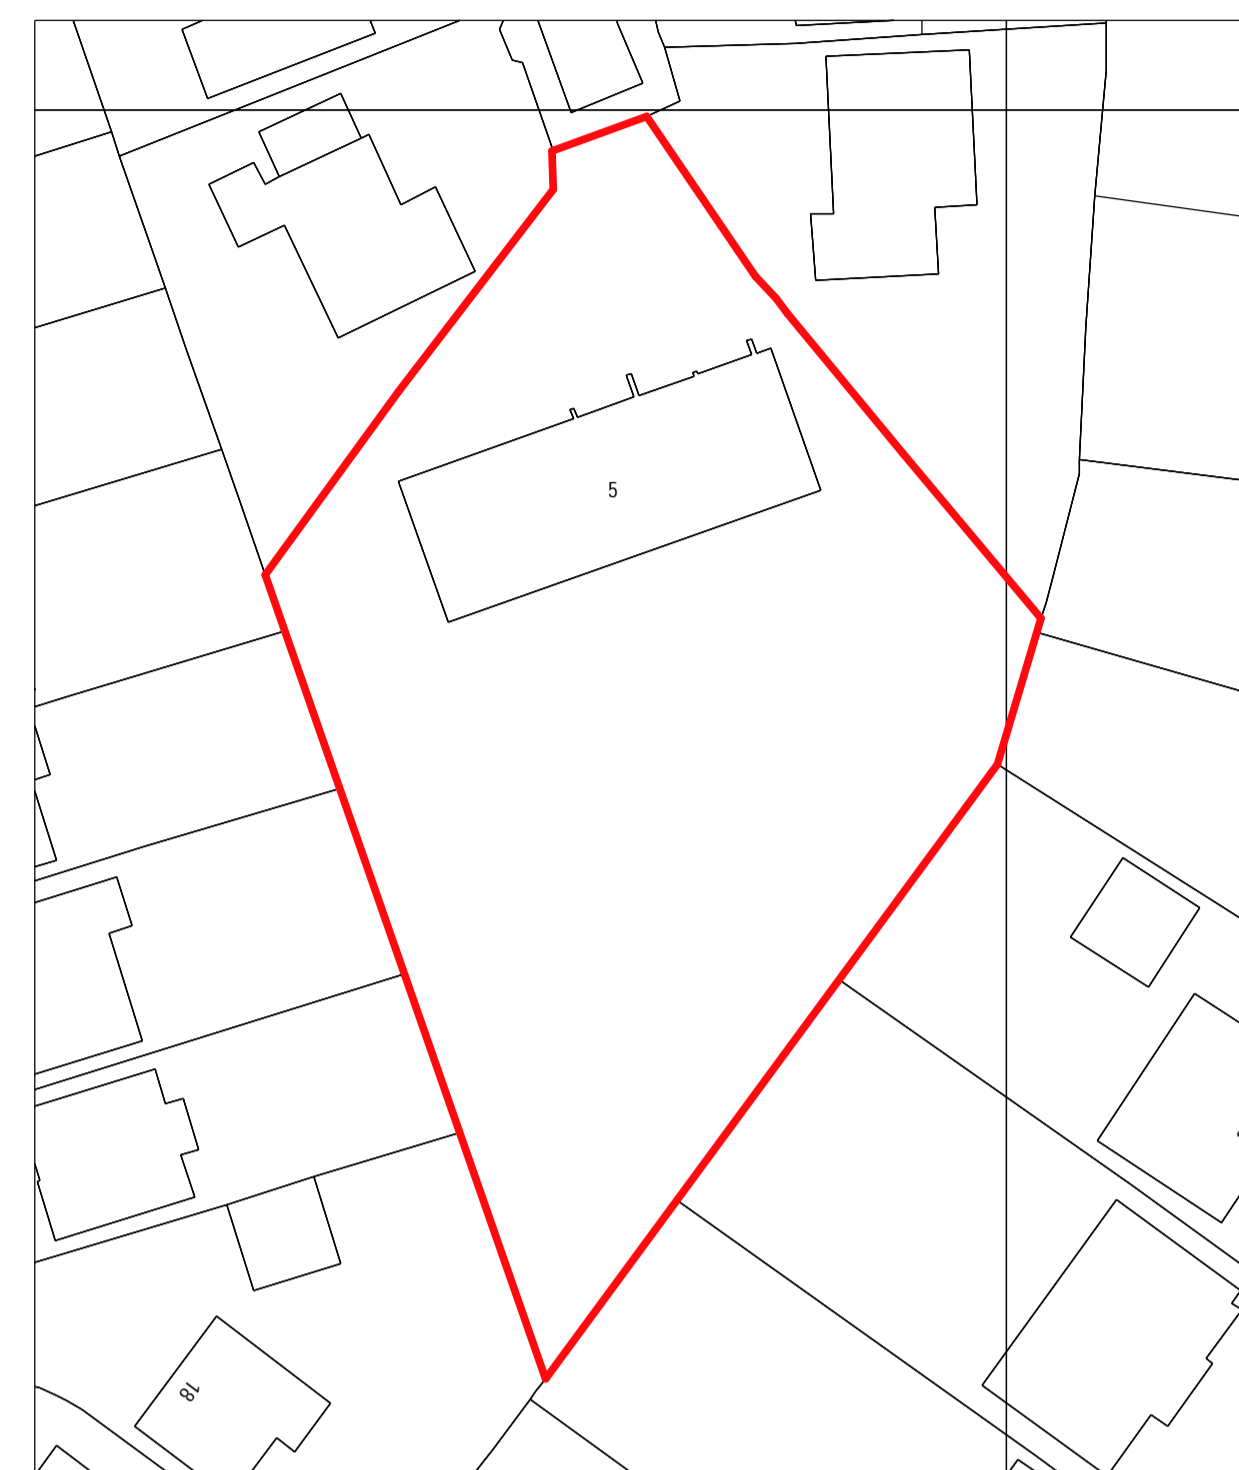

Site Block Plan 1:500

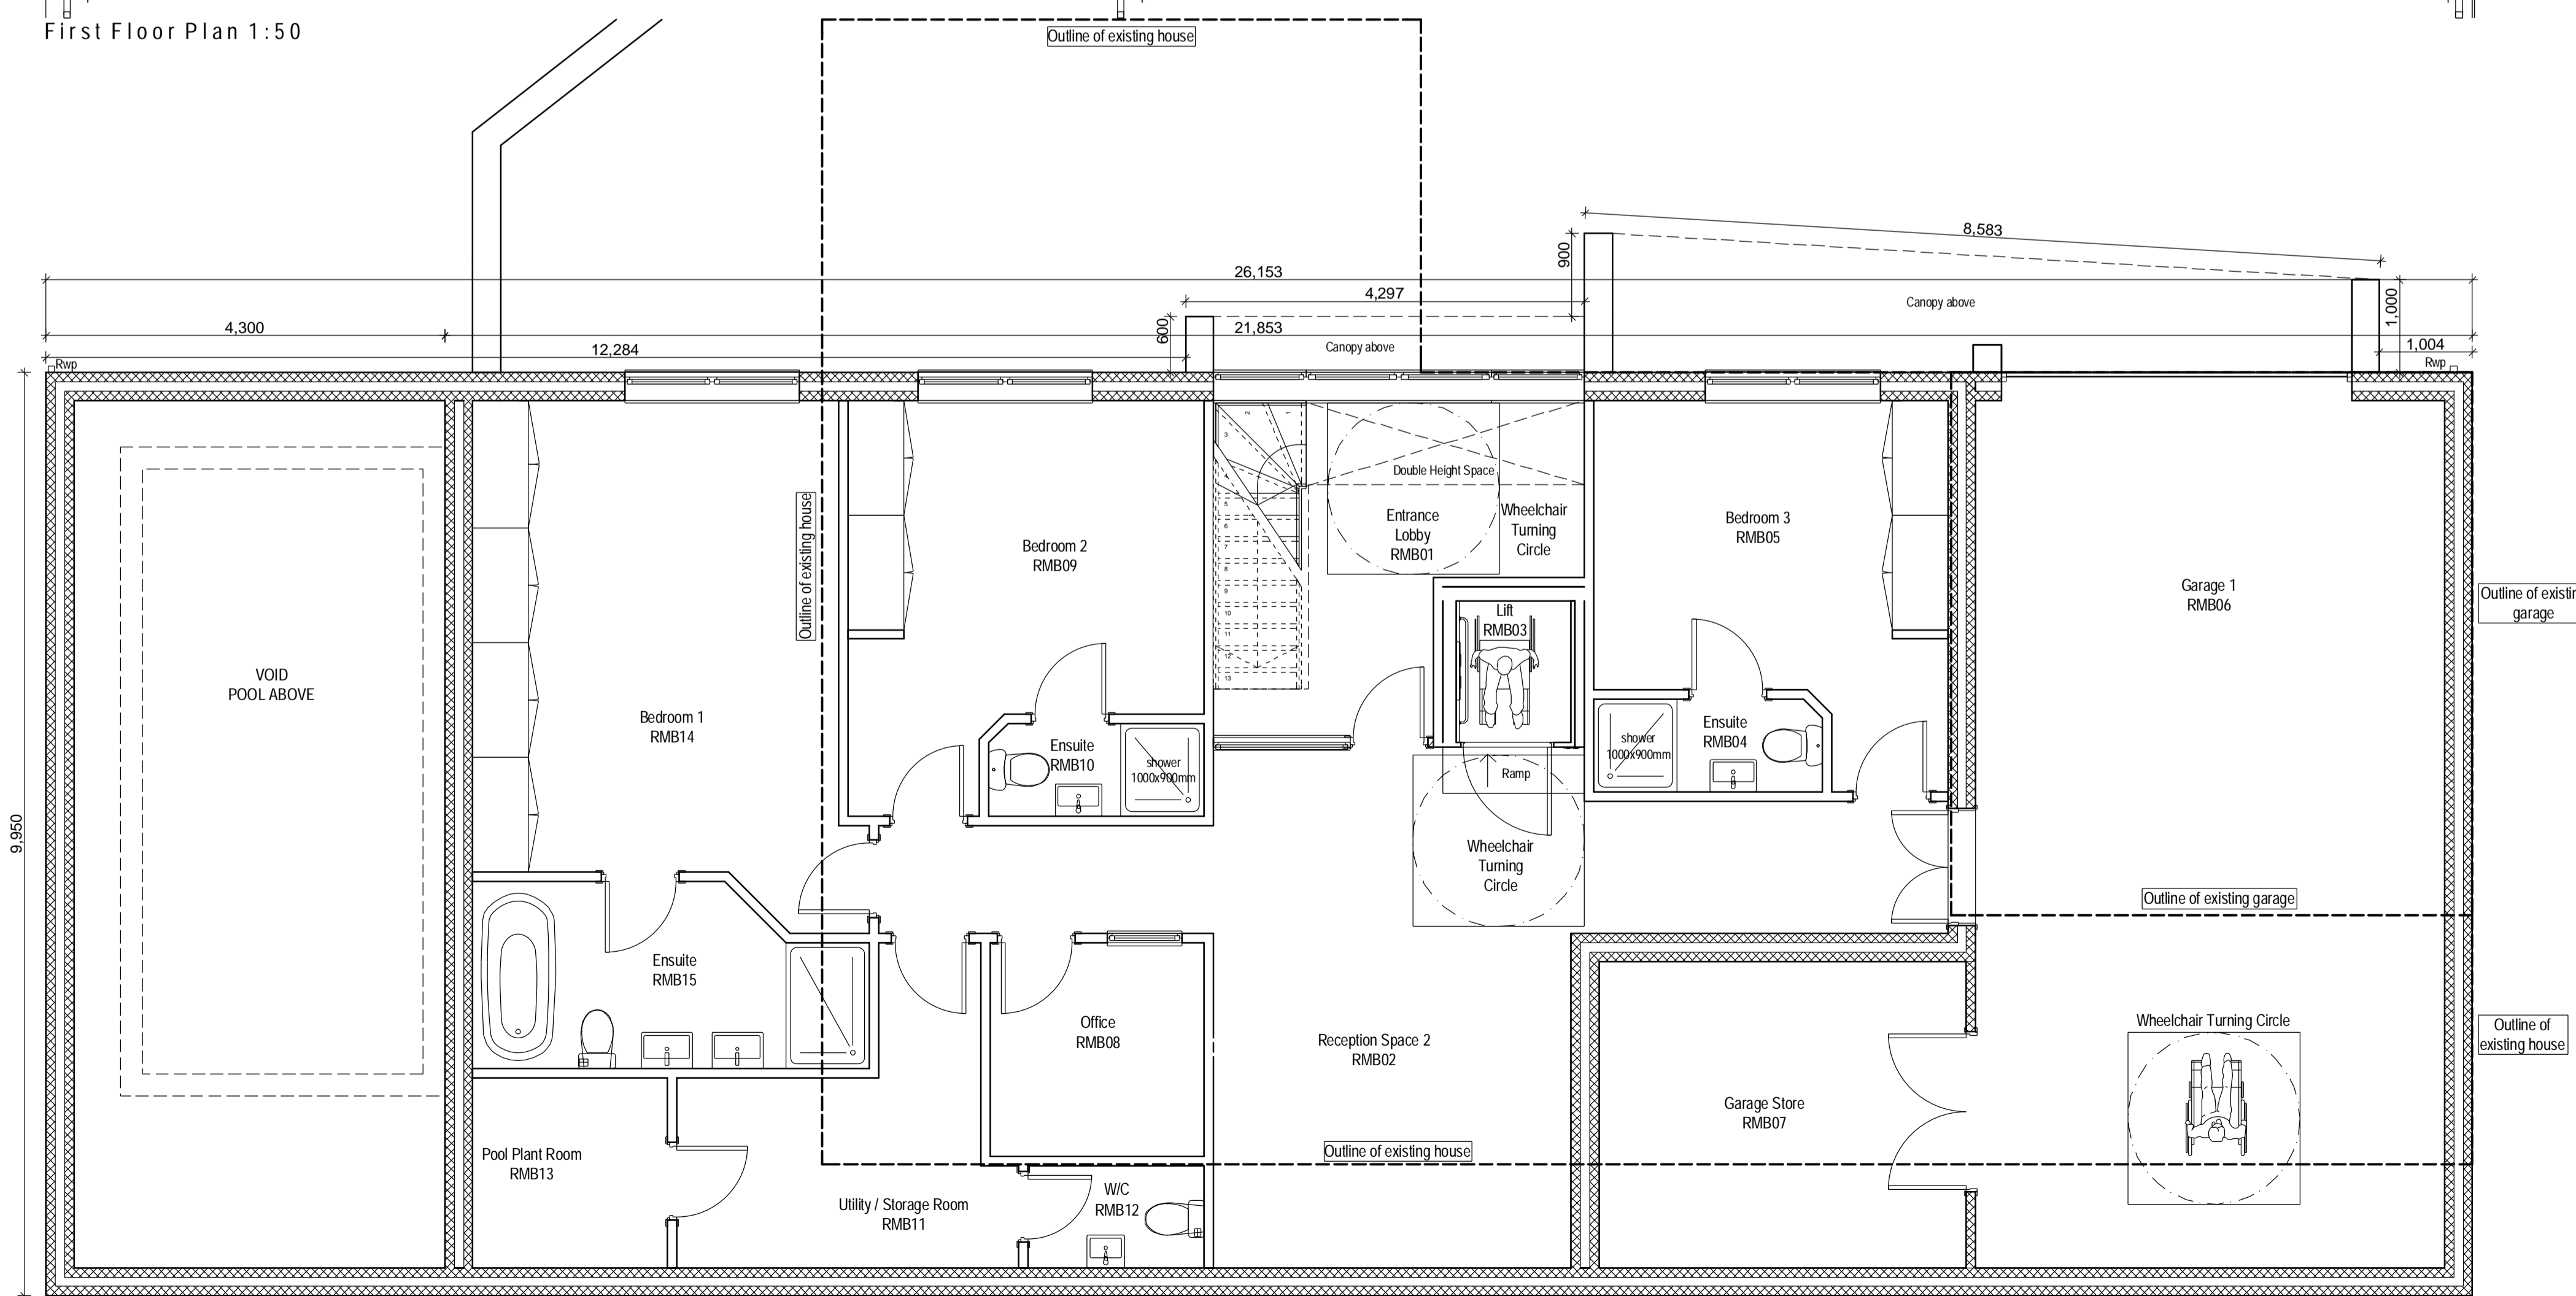

Ground Floor Plan 1:50

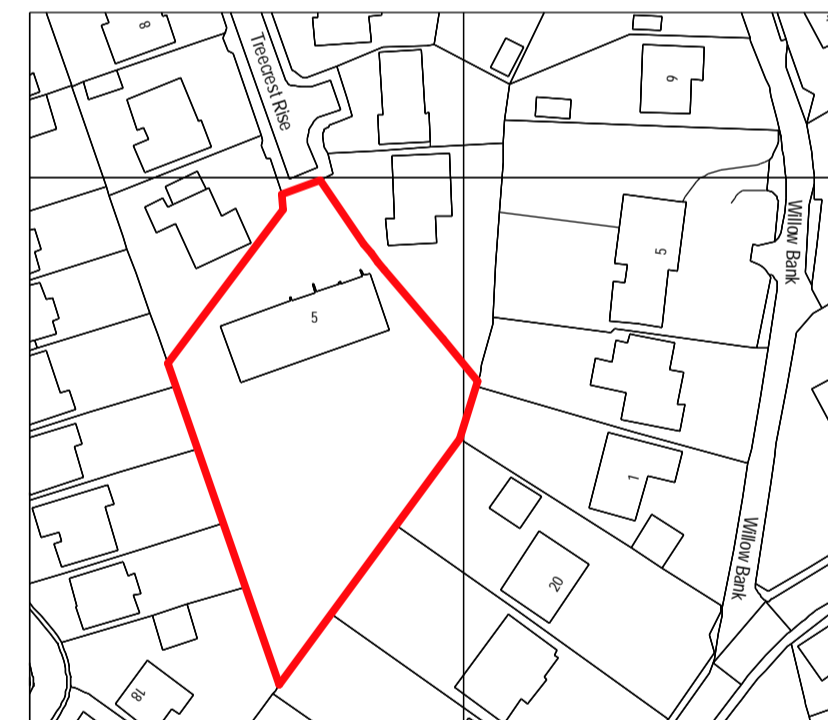

Site Location Plan 1:1250

Project Status:	PLANNING ONLY
transform architects...	
4 Rushmead Court, Ossett, WF5 0NZ tel: 01924 265 080 - fax: 0871 66 11 003 web: www.transformarchitects.co.uk email: info@transformarchitects.co.uk	
Project:	5 Treecrest Rise, Barnsley, South Yorkshire, S75 1EB
Client:	Mr & Mrs Cunliffe
Drawing Title:	Proposed Plans A1
Scale:	1:1250, 1:50, 1:500
Date:	29-07-2013
Drawn By:	MNB
Drawing Number:	T555 - PL02
Revision:	Nil