


Drawn by:	sp	Date:	16.08.18	Scale:	1:100	@ A1
Status:	Preliminary	Prepared by:	TR	Checked:		
Date:	16.08.18	Reviewed:		Drawn:	sp	Approved:
Approved by:	TR	Revision:	P1	Based for Review:		TR

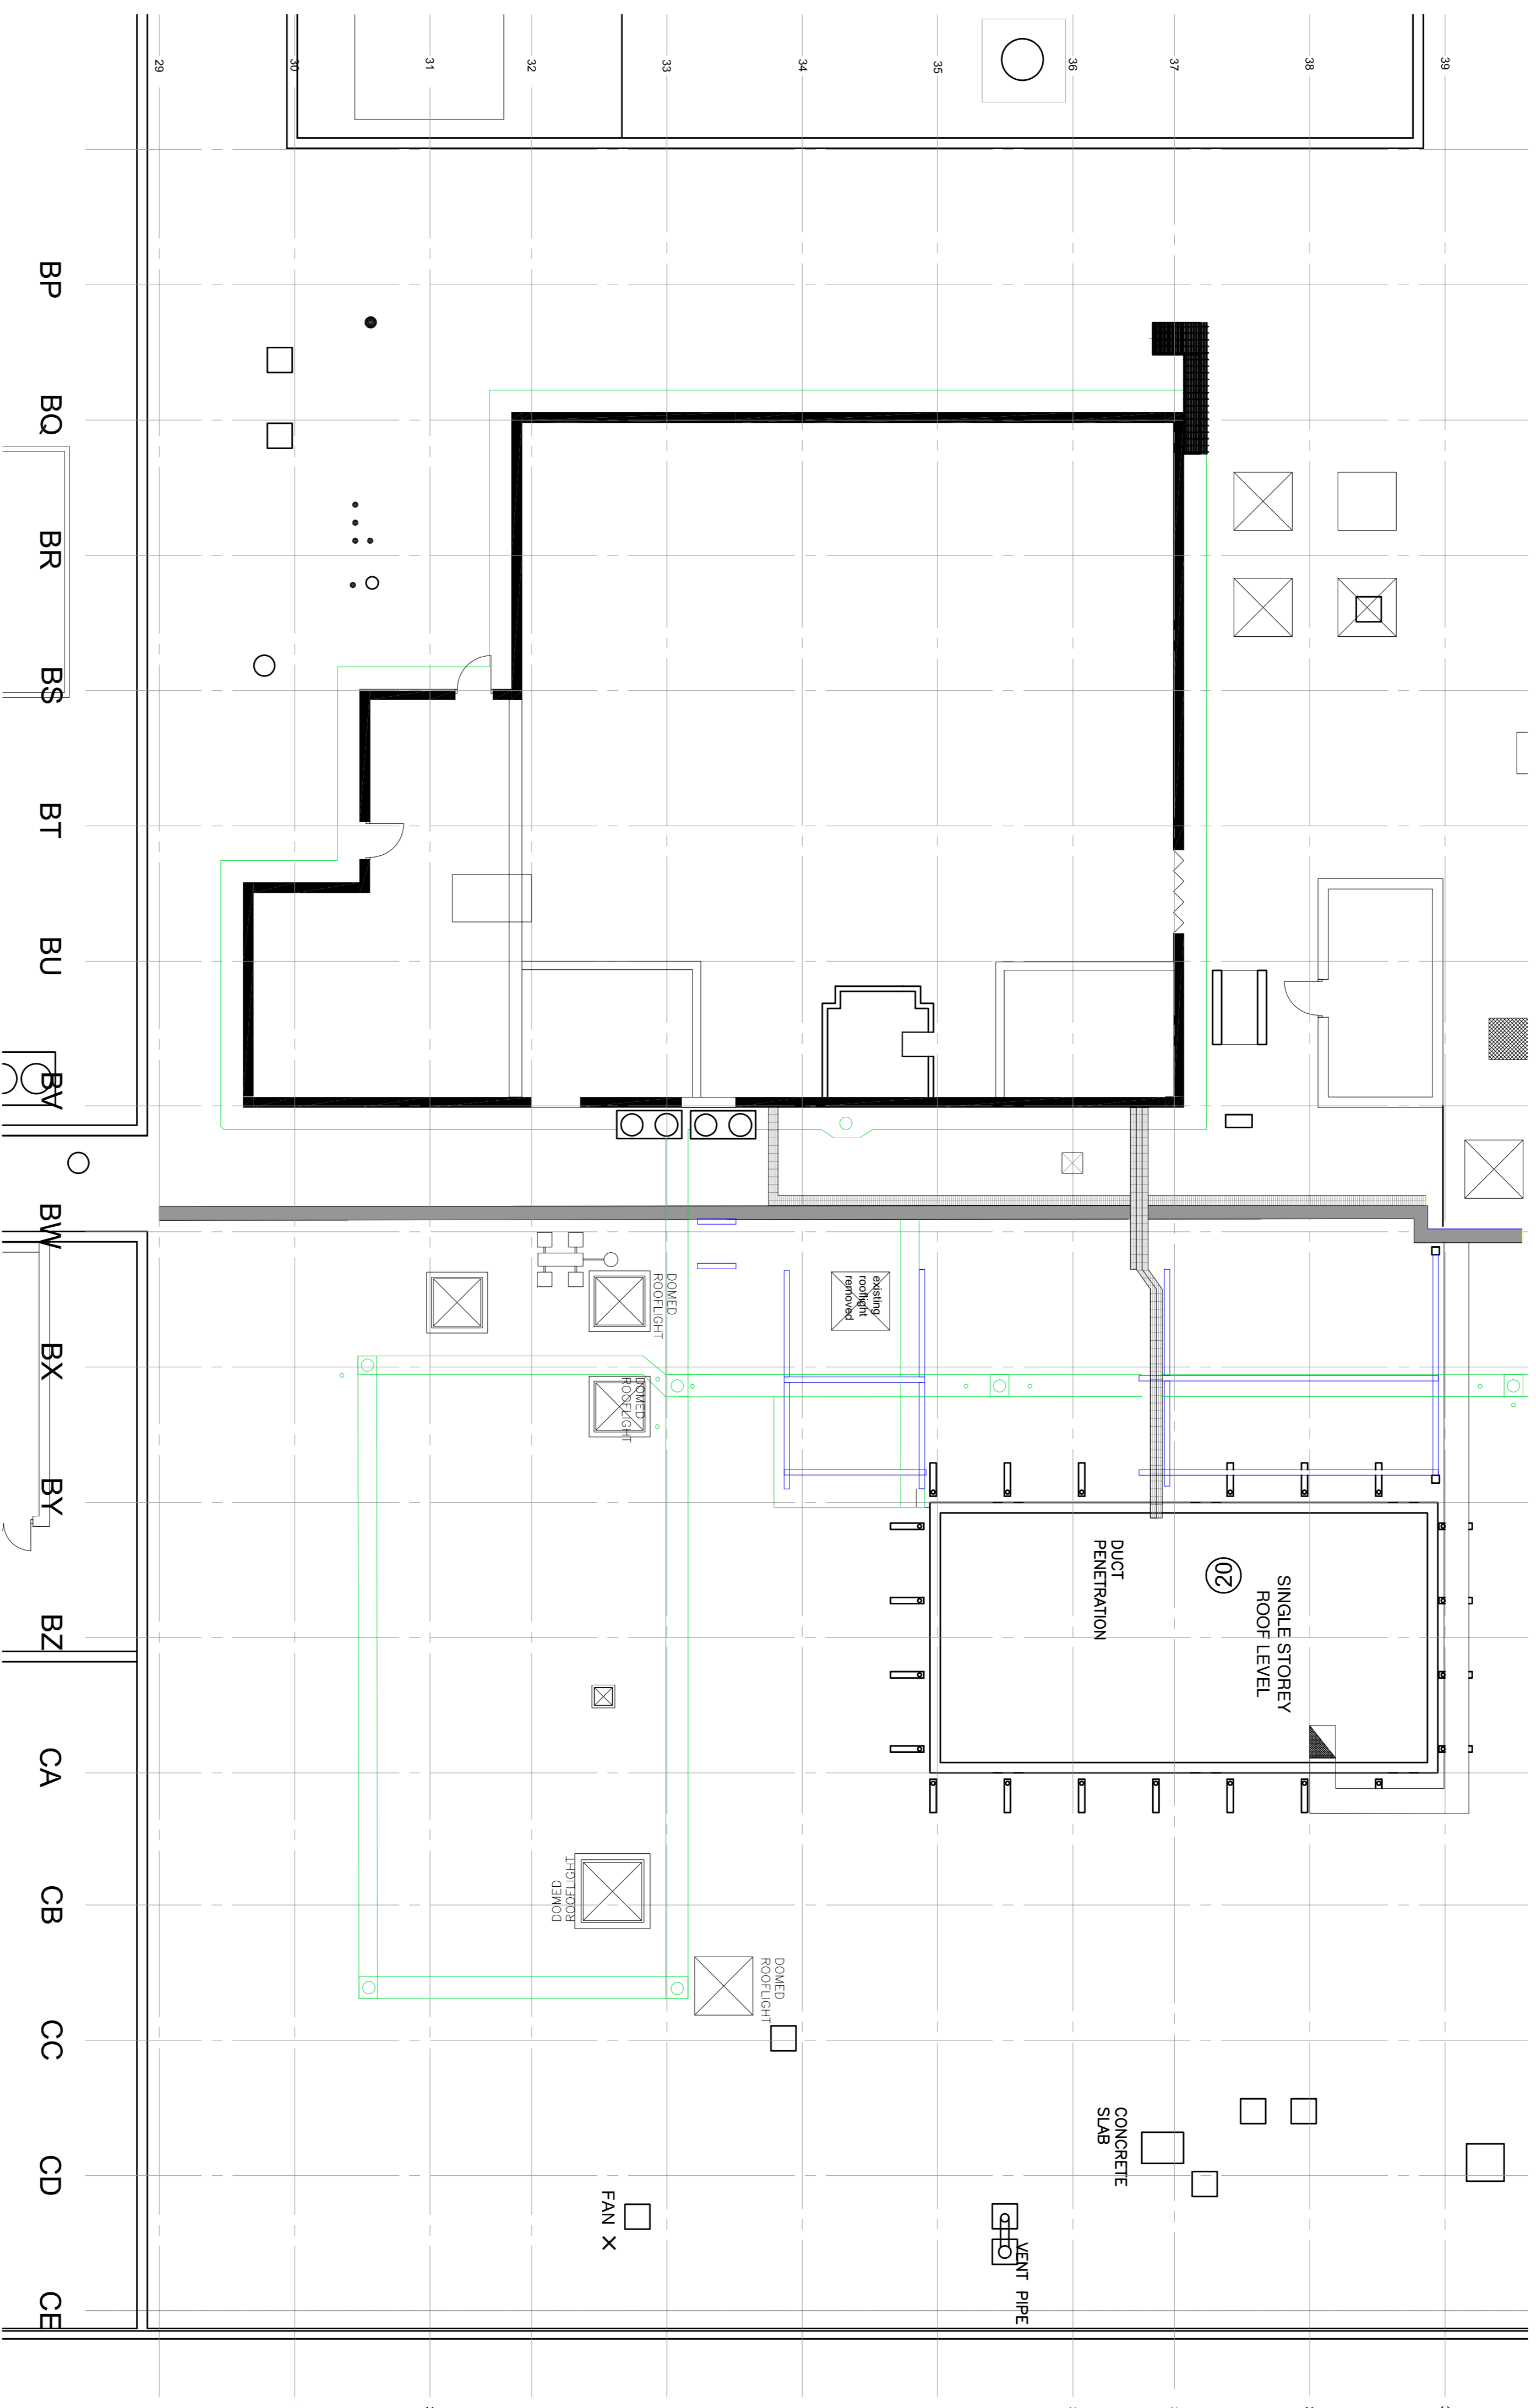

KEY
--- Ducts starting arrangements
--- Ducts stop arrangements

EXISTING ROOF PLAN - PLANT ROOM

Scale: 1:100

Client: **Barnsley Hospital NHS Foundation Trust**
Project: **Theatre Air Handling Replacement**

Project No.: Drawing No.:
3350-04 PL02

Drawing Title:
BTH-RCA-00-DR-A-PL02-Existing Roof Plan

Project Code: [Department] [Location] [Area] [Room] [Revision] [Date]
S3 P01
Sheffield Station 3, Vicarage Road, Sheffield | S1 4DB | 0114 273 7050

