


# NOTES

1. DO NOT SCALE - Use figured dimensions only.
2. All dimensions shown are in millimetres unless otherwise stated.
3. The Contractor is to verify all dimension on site before commencing work or preparing shop drawings.
4. This drawing is to be read in conjunction with all Engineers and Architects drawings and specifications.

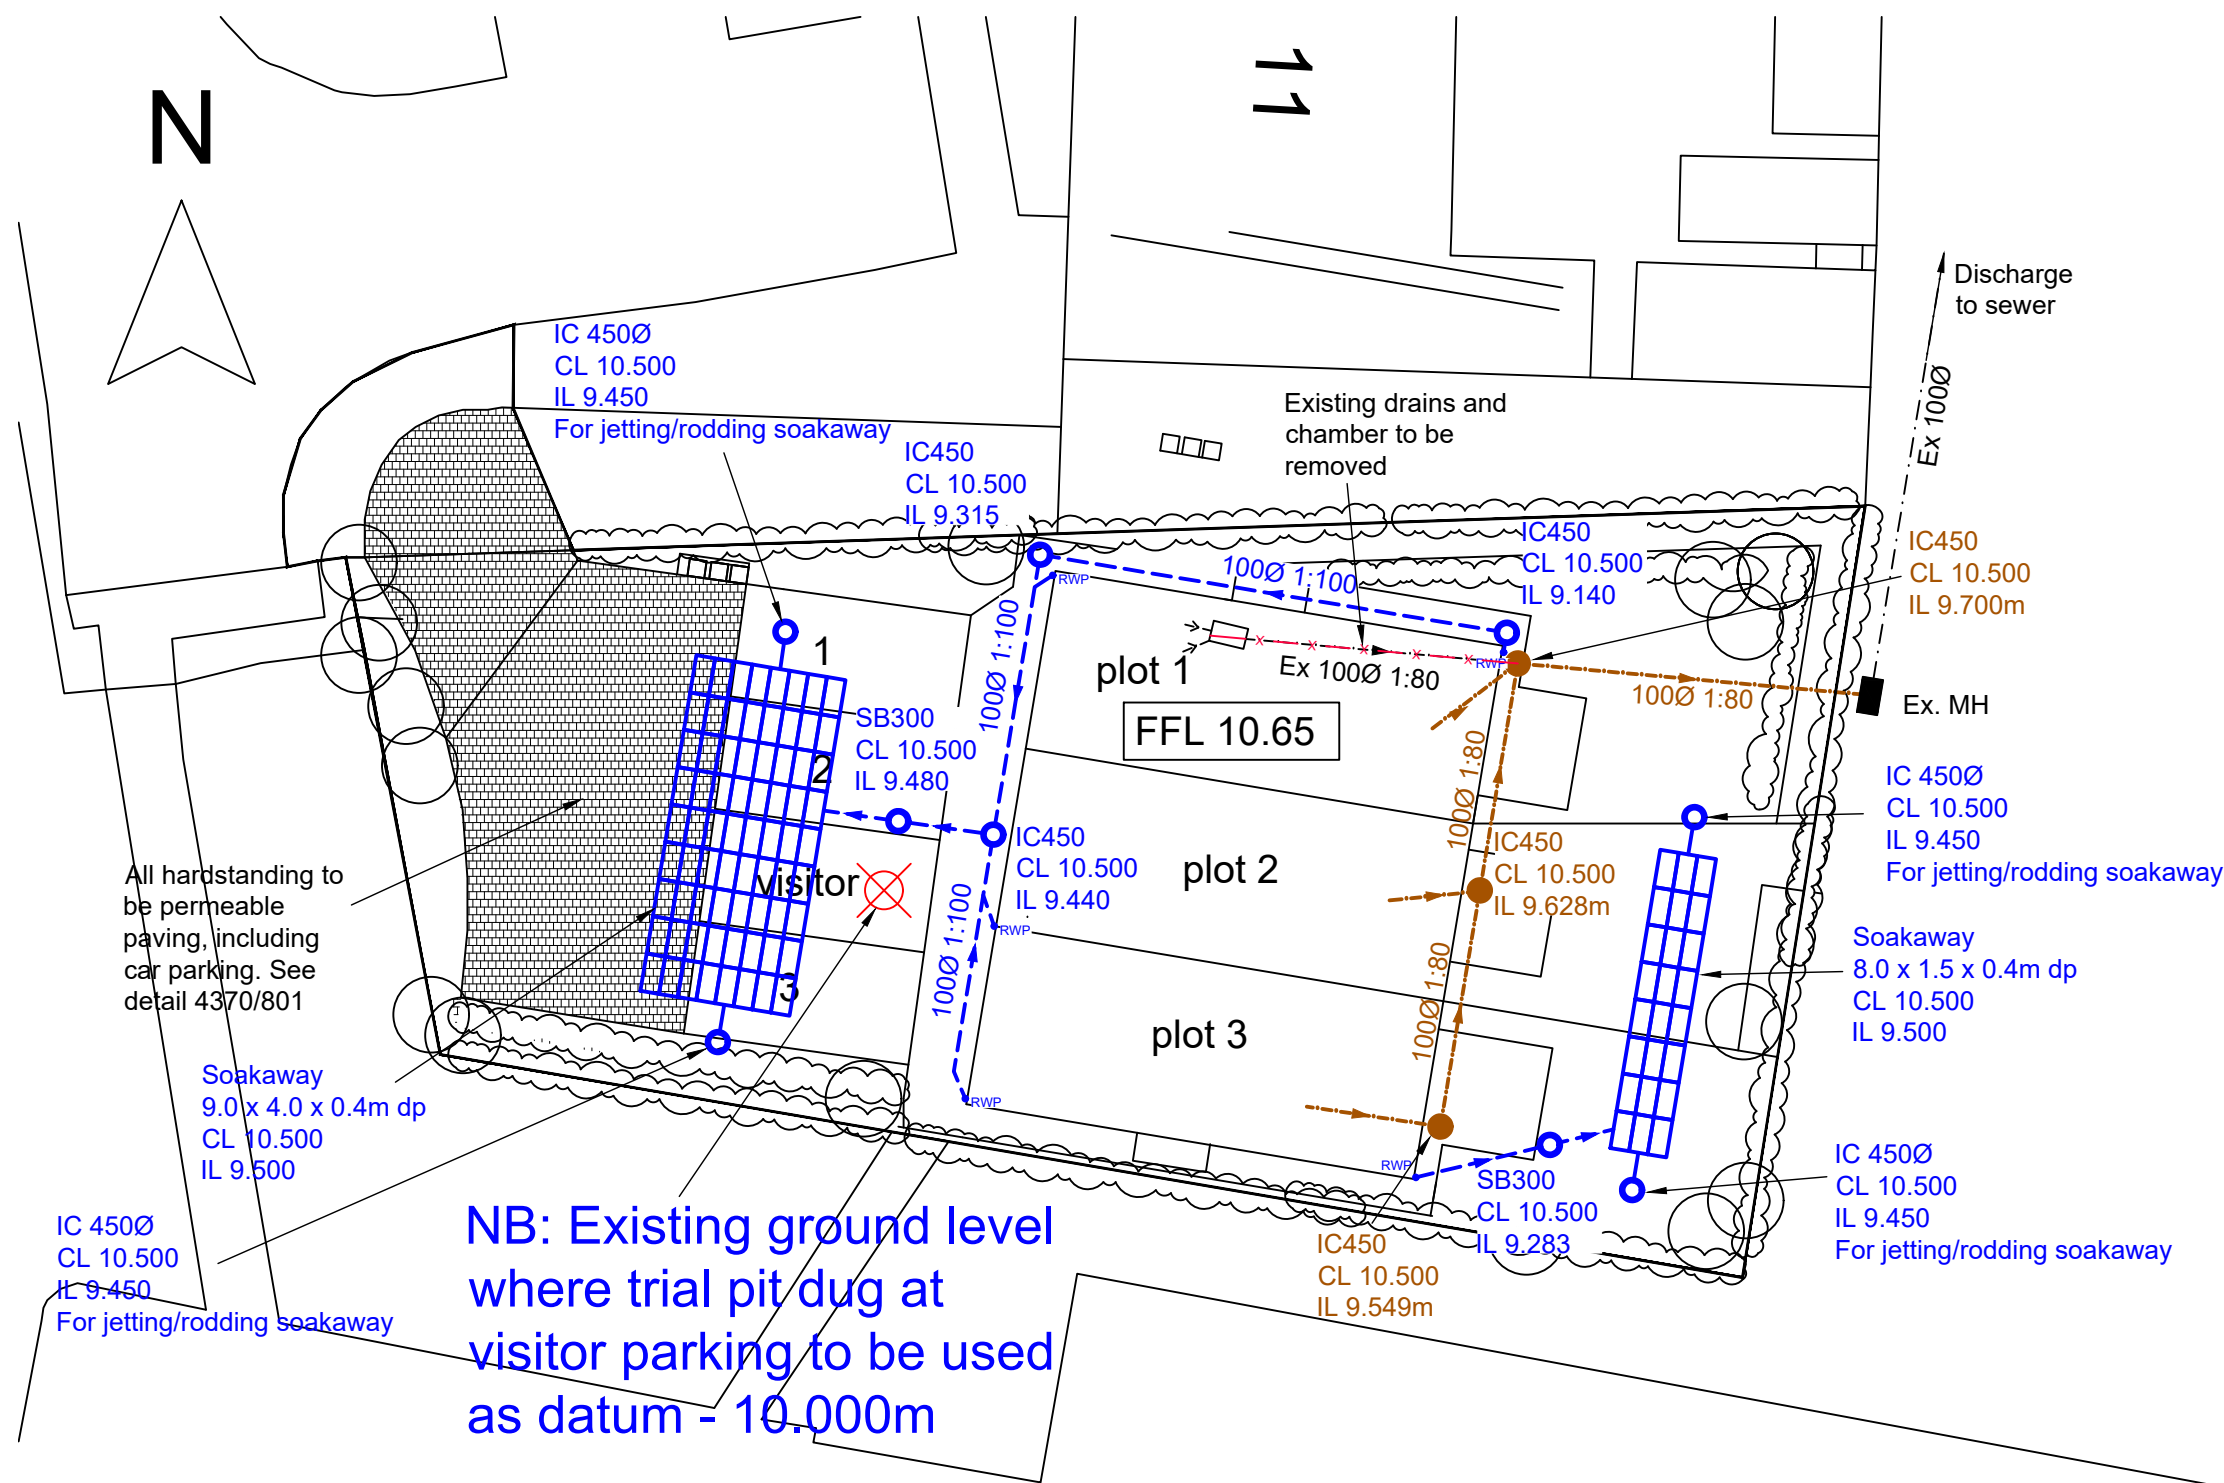

**NB: Existing ground level where trial pit dug at visitor parking to be used as datum - 10.000m**

Rev	Description	Dr	Ch	Date
P2	Note added for removal of existing chamber	JR		25/02/2025
P1	Initial Issue	LM	JR	20/02/2025

Drawing Status	Preliminary
----------------	-------------

Client	J. Wade
Project	9 Broom Close, Kendray Barnsley, S70 3EG
Title	Drainage Layout

Scale	1:200
Sheet Size	A3
Drawn	LM
Checked	JR
Approved	-

**J ROBERTS DESIGN LTD**  
STRUCTURAL AND CIVIL ENGINEERING CONSULTANTS  
Tel: 01709 917154  
www.jrobertsdesignltd.com

Drawing Number	4370/800	Rev	P2
----------------	----------	-----	----