

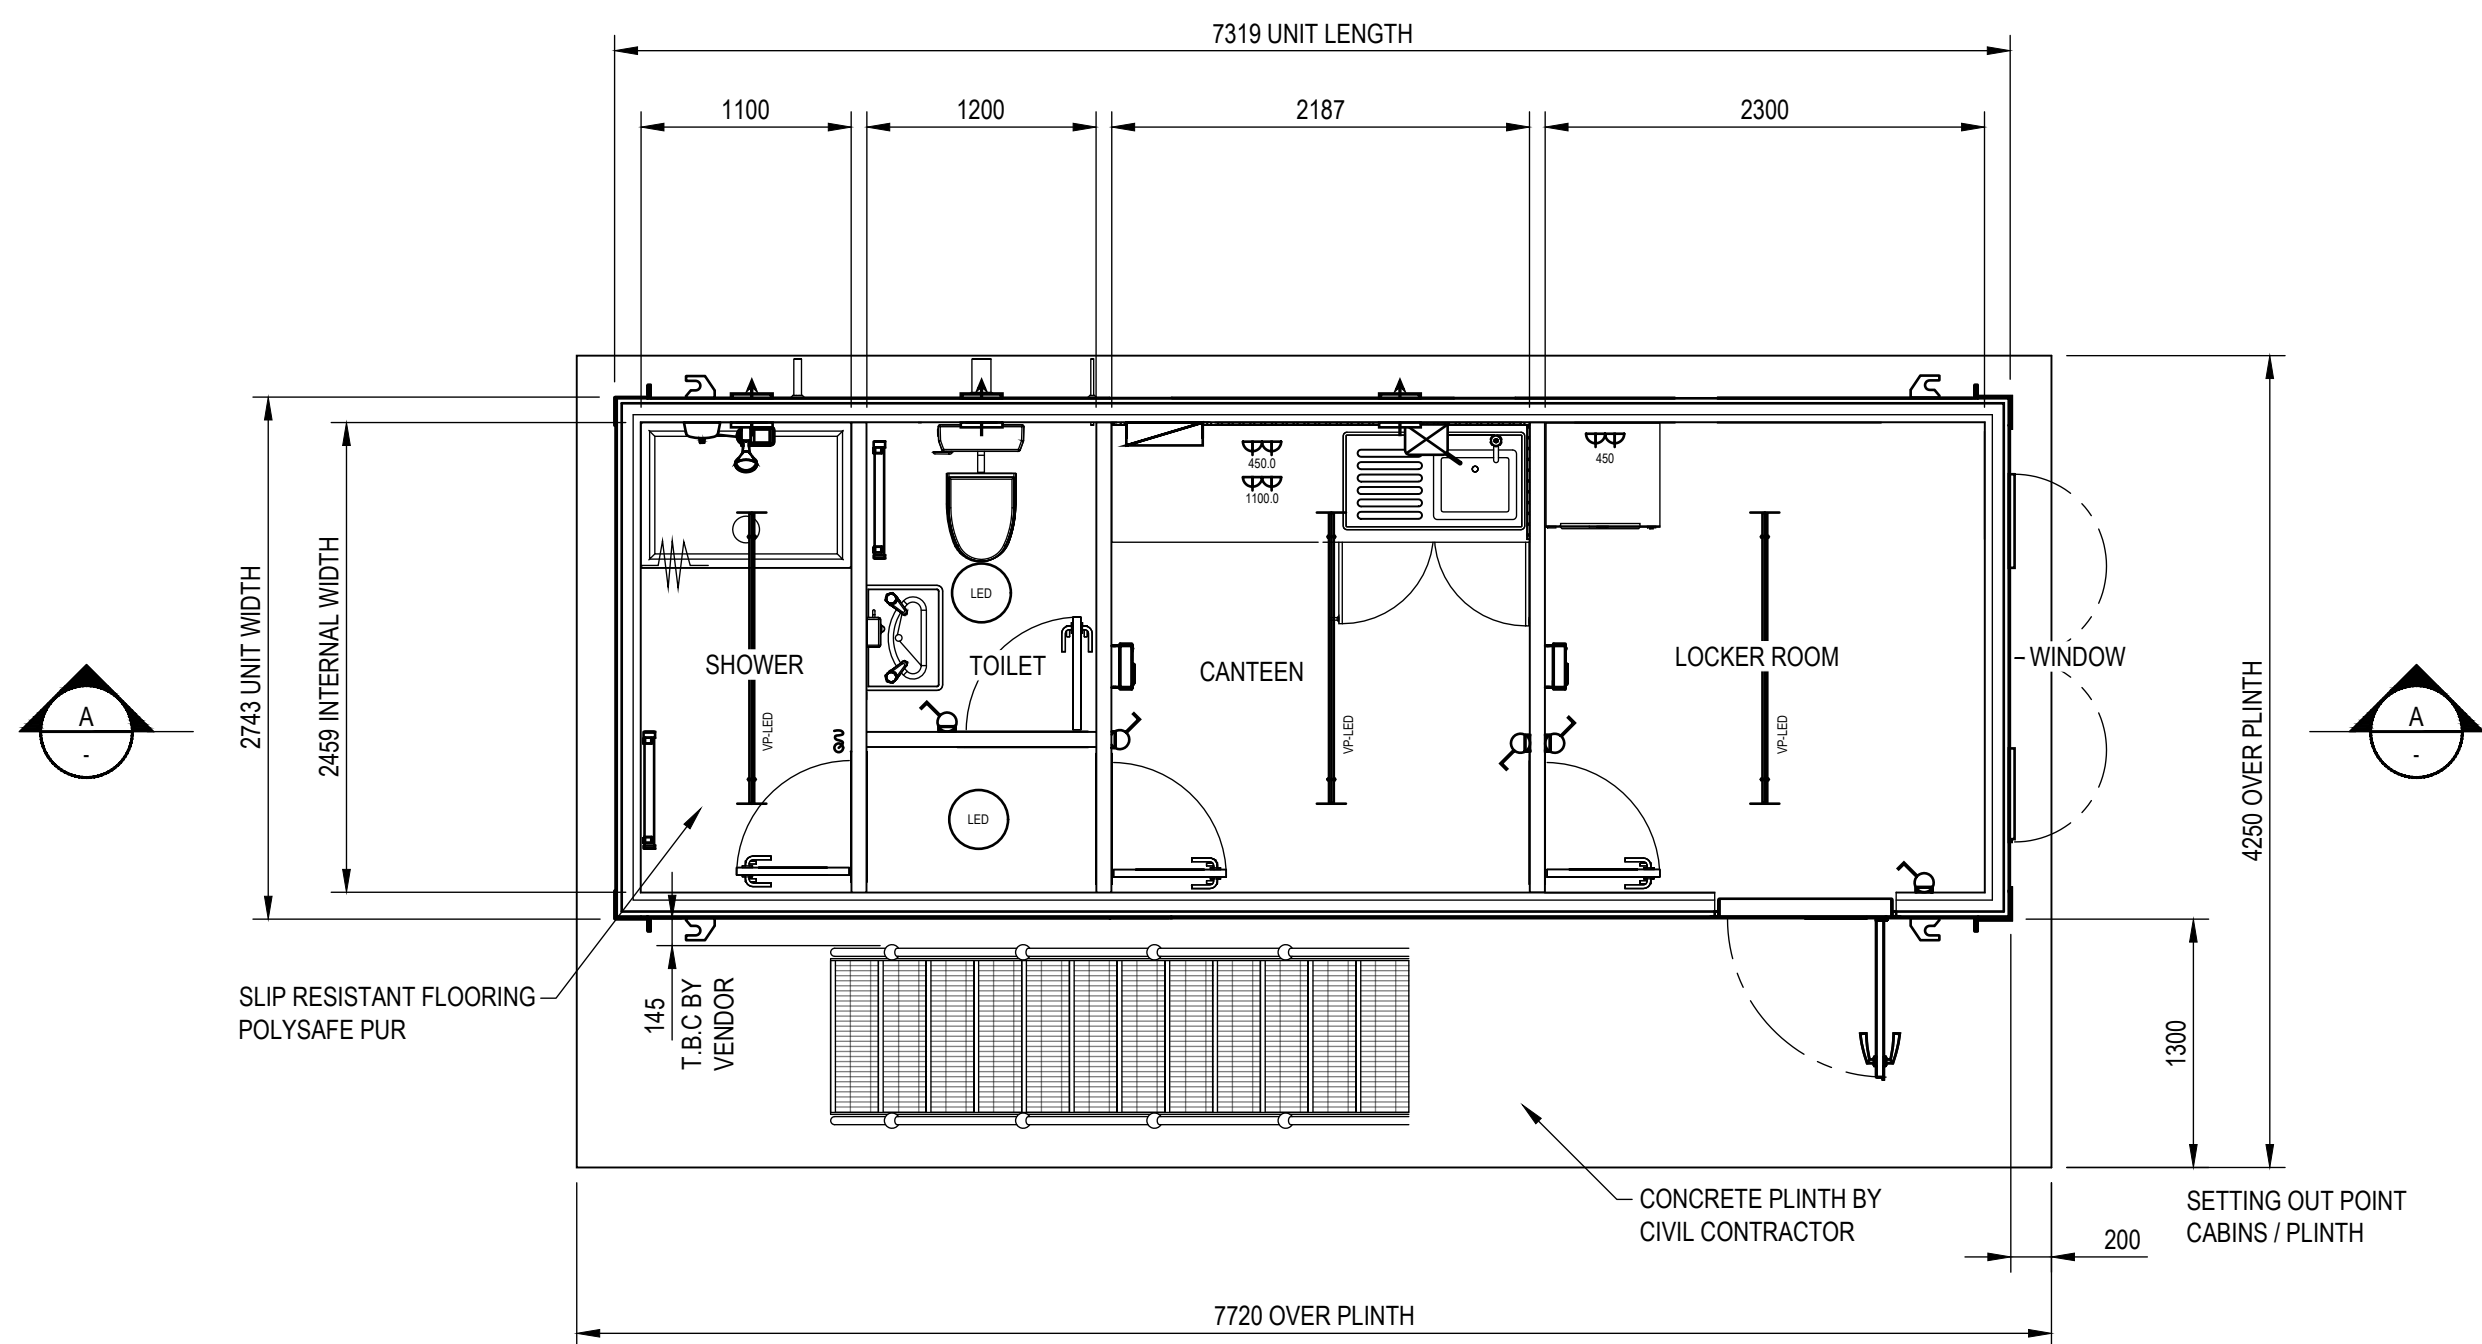
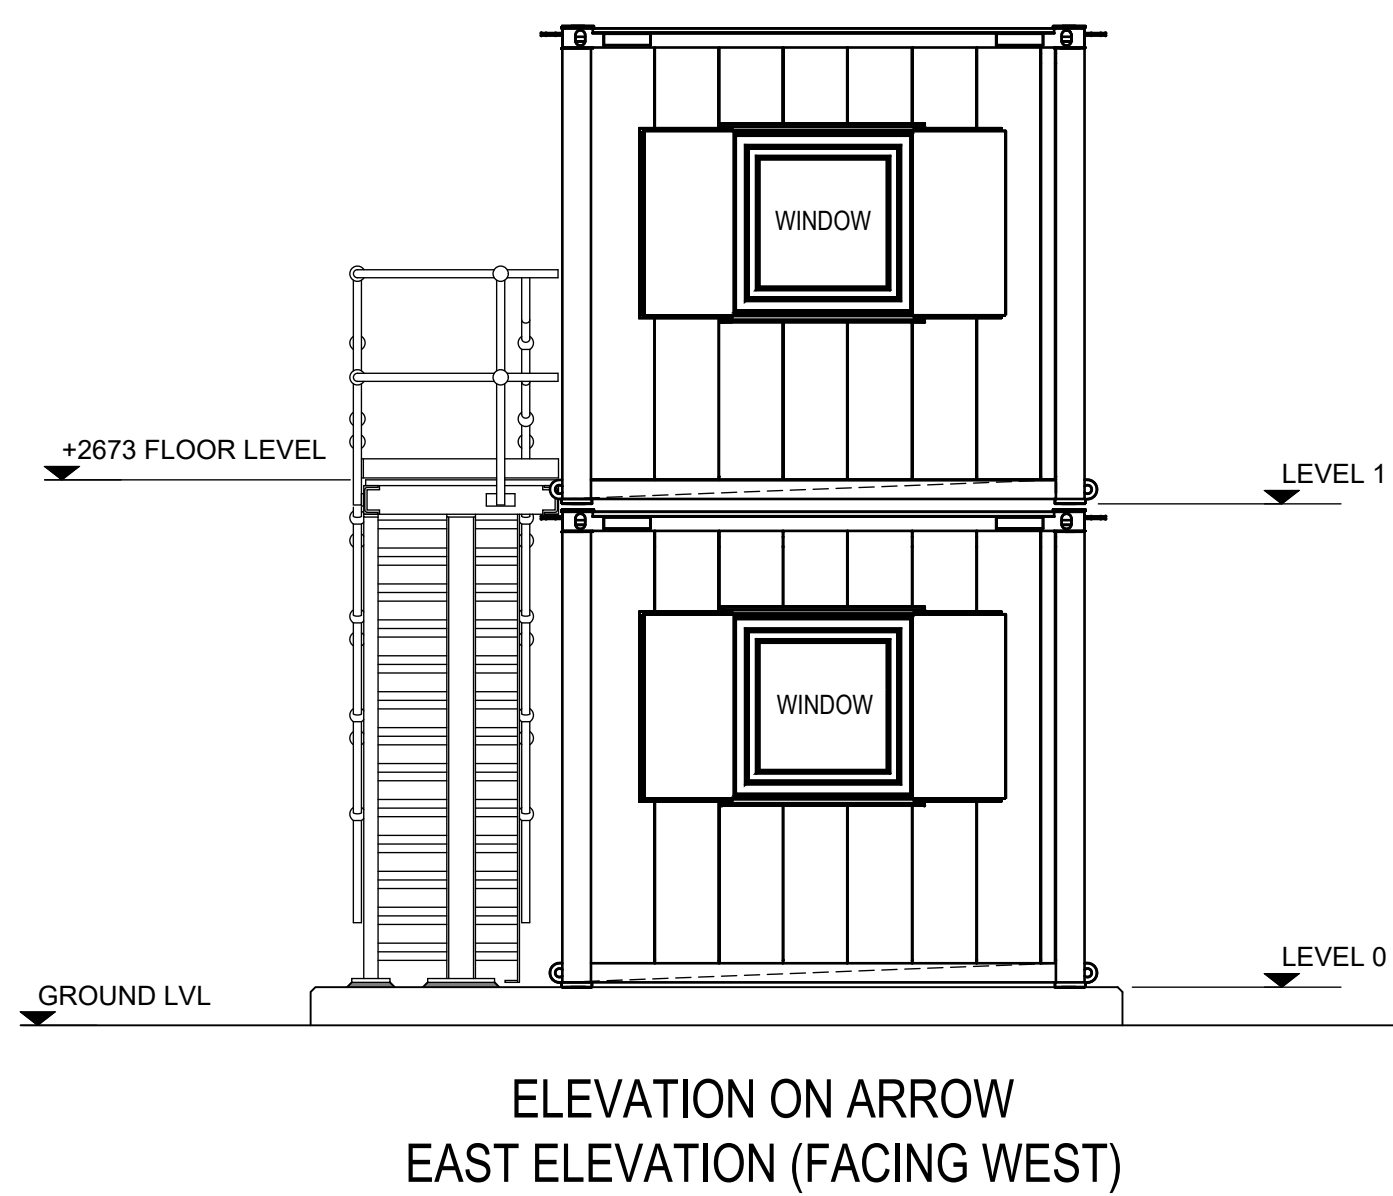
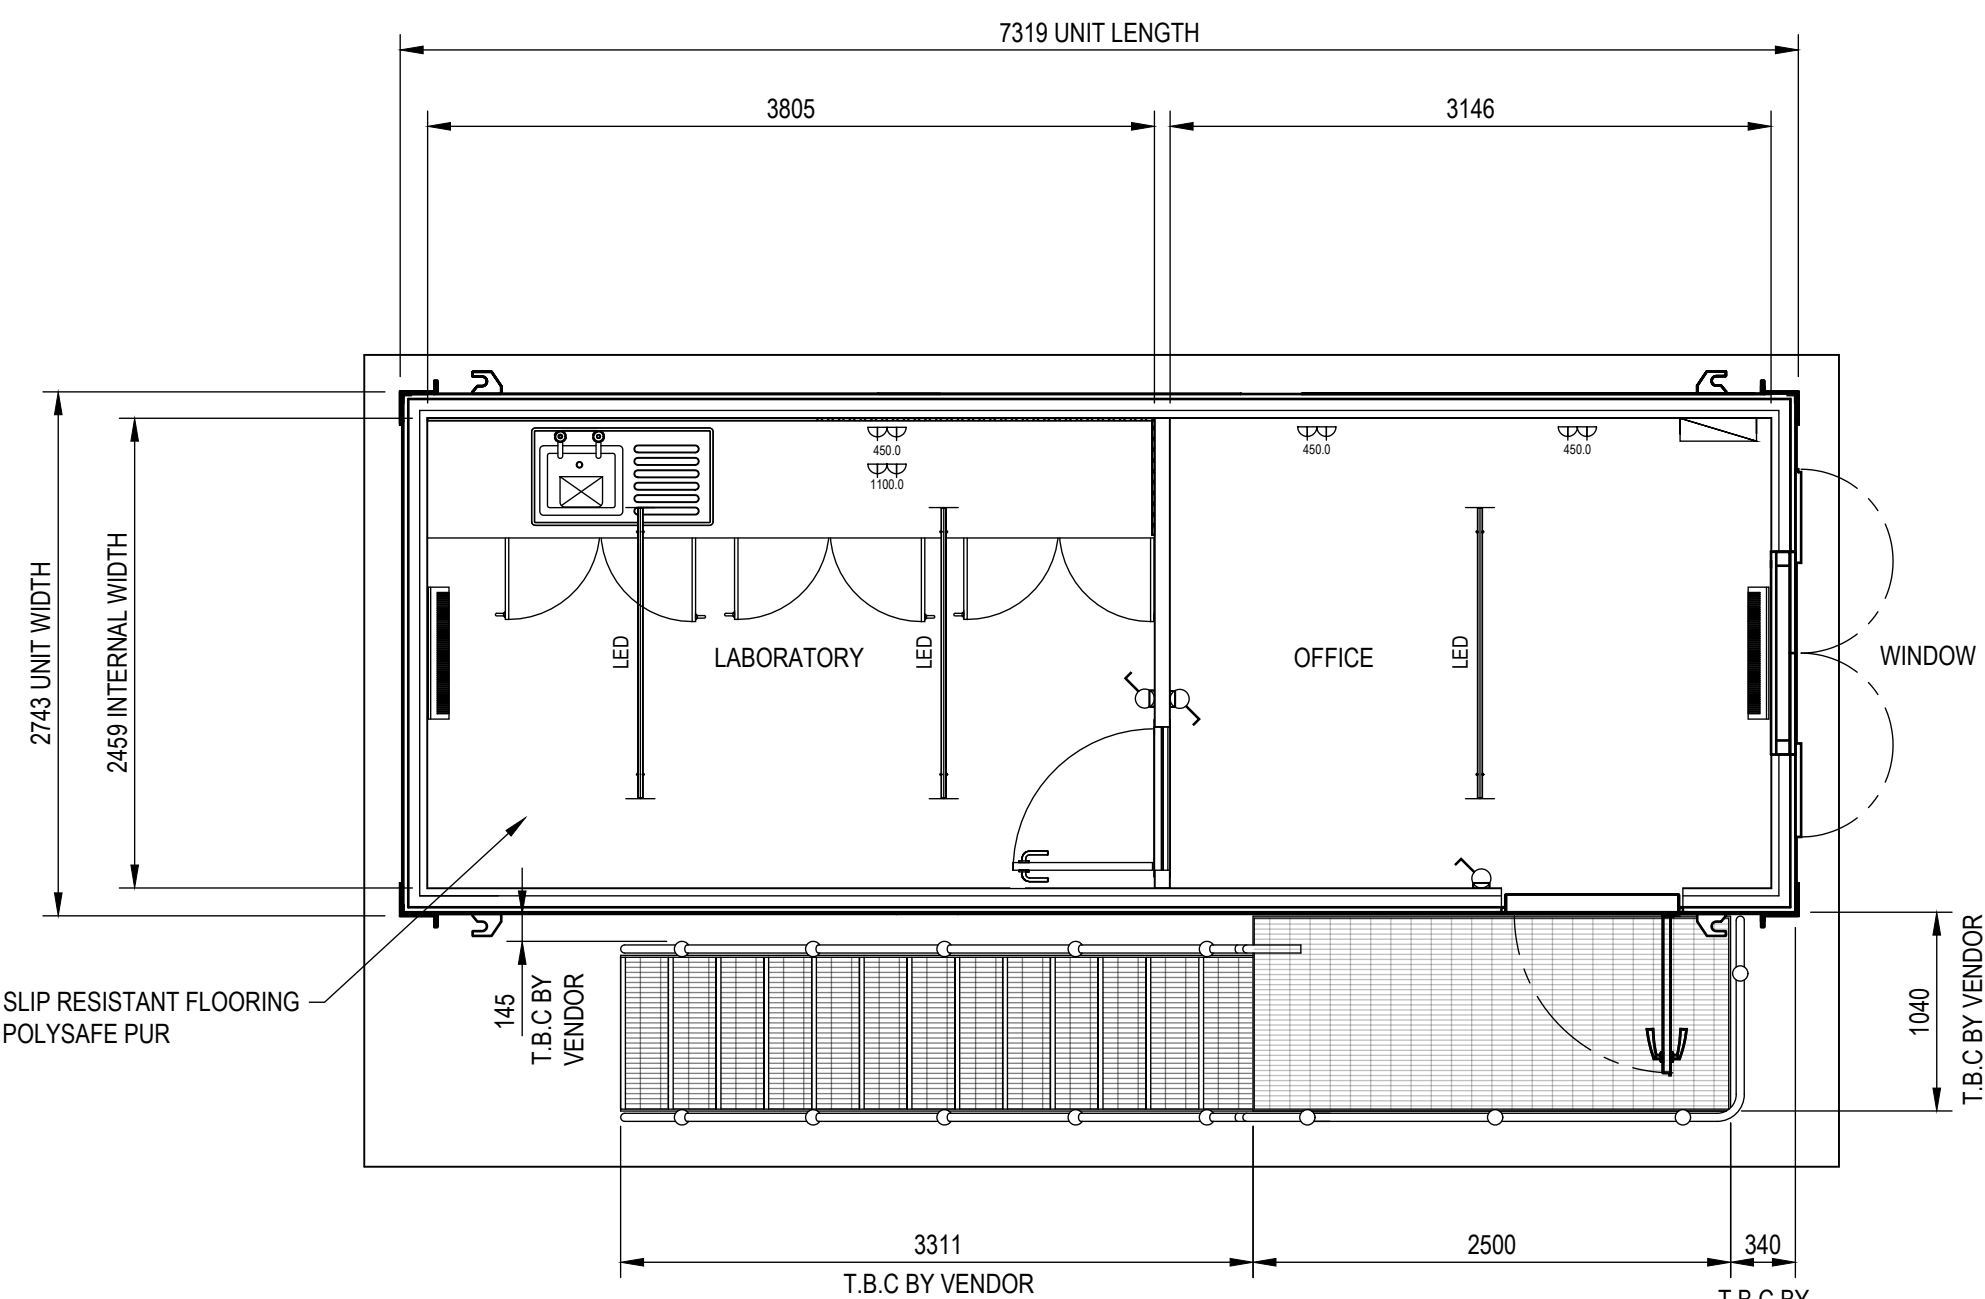
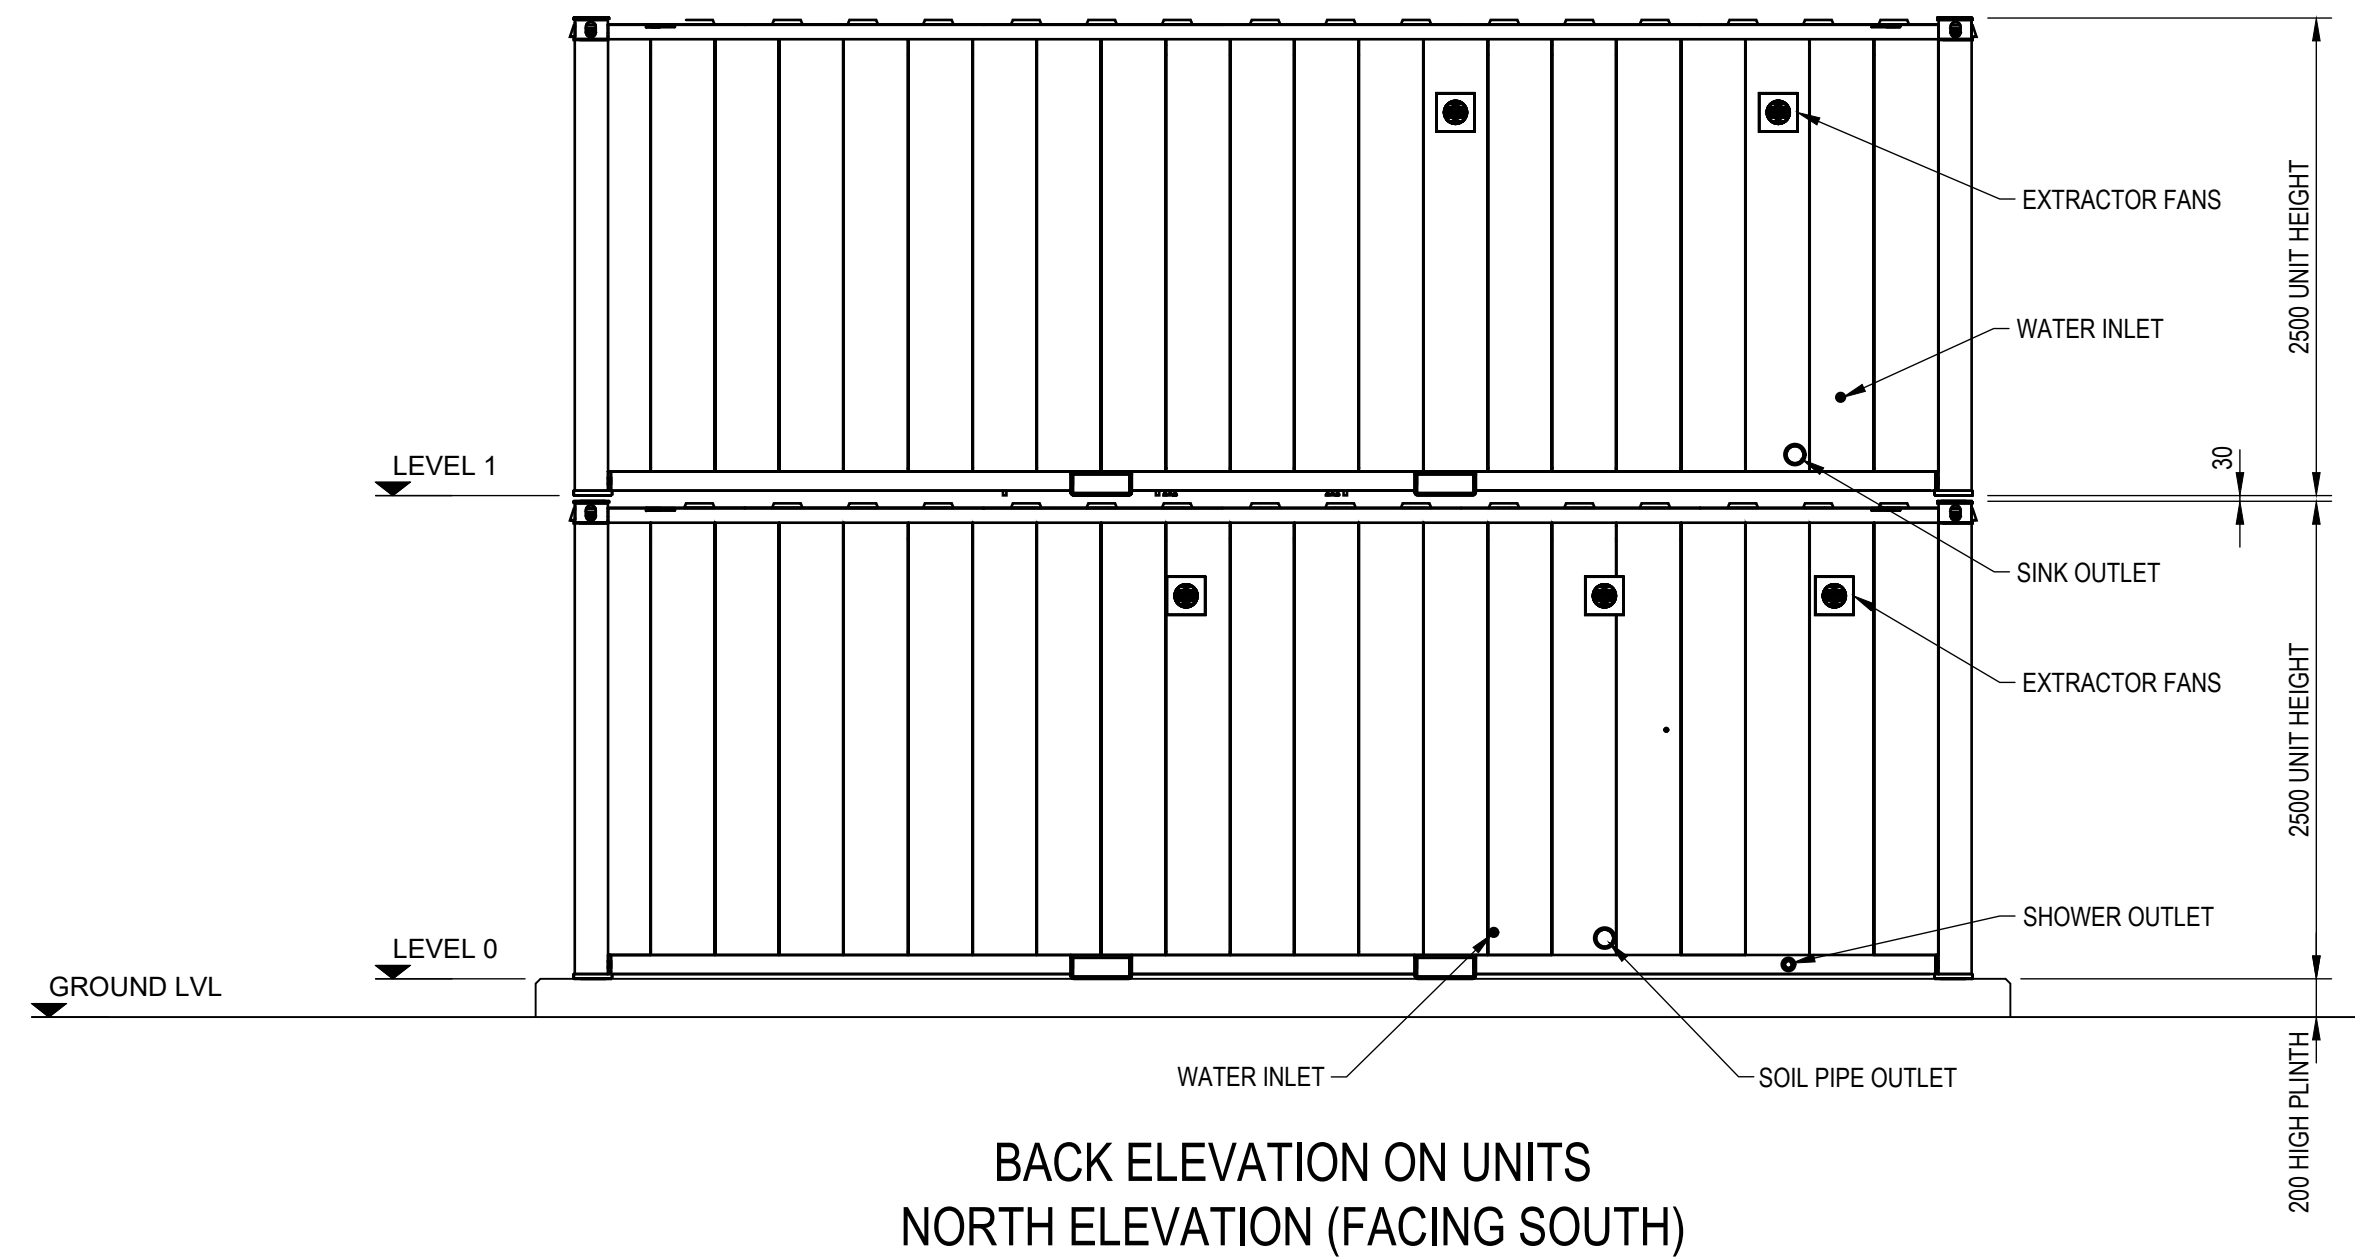


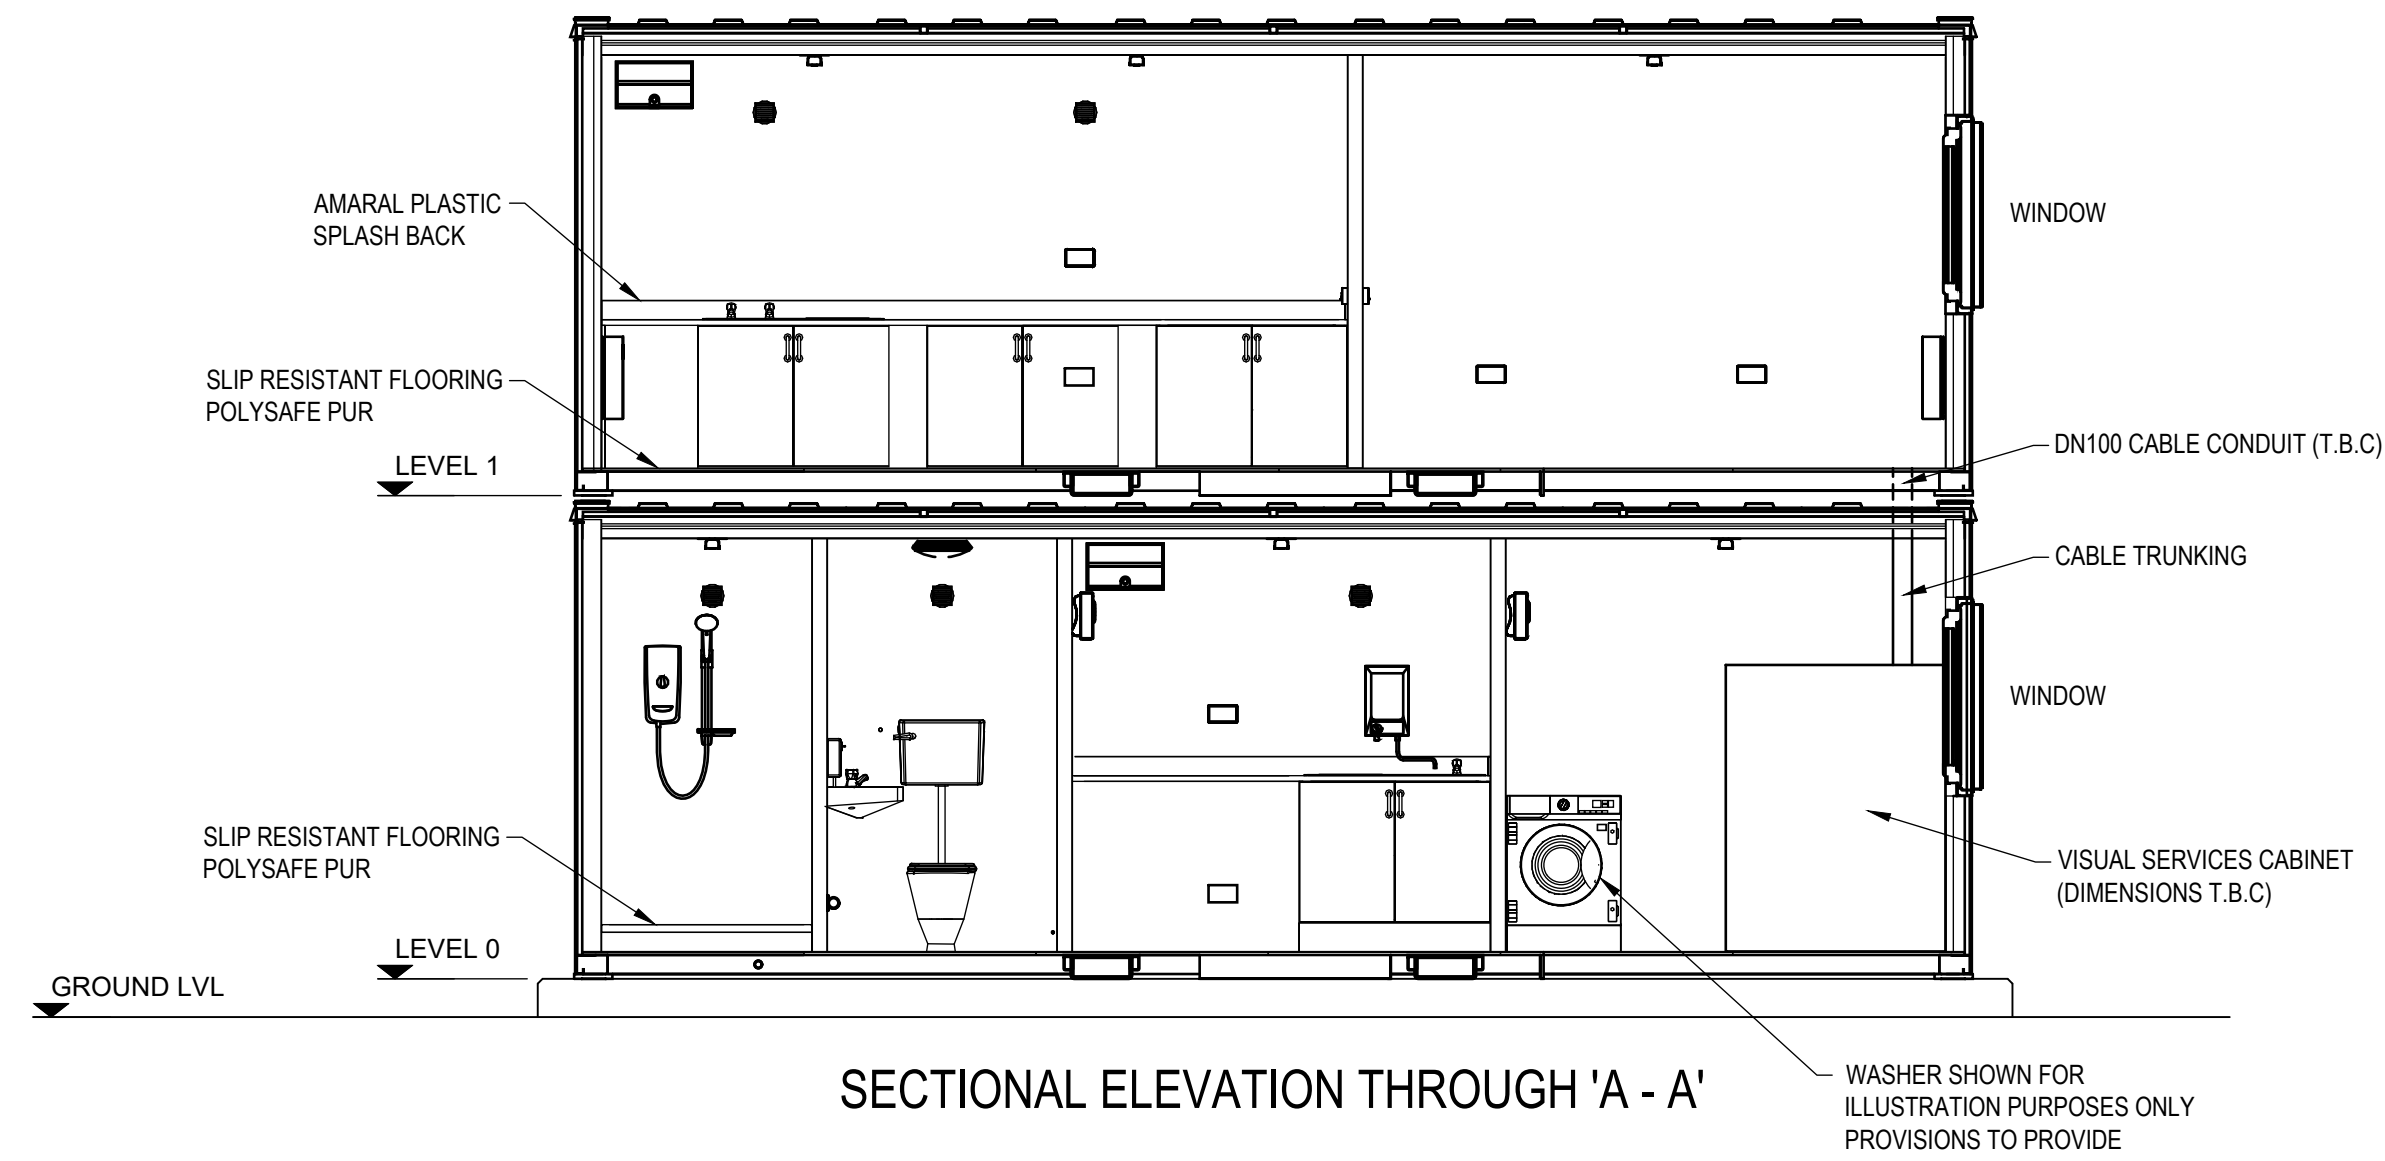

FLOOR PLAN ON LEVEL 0

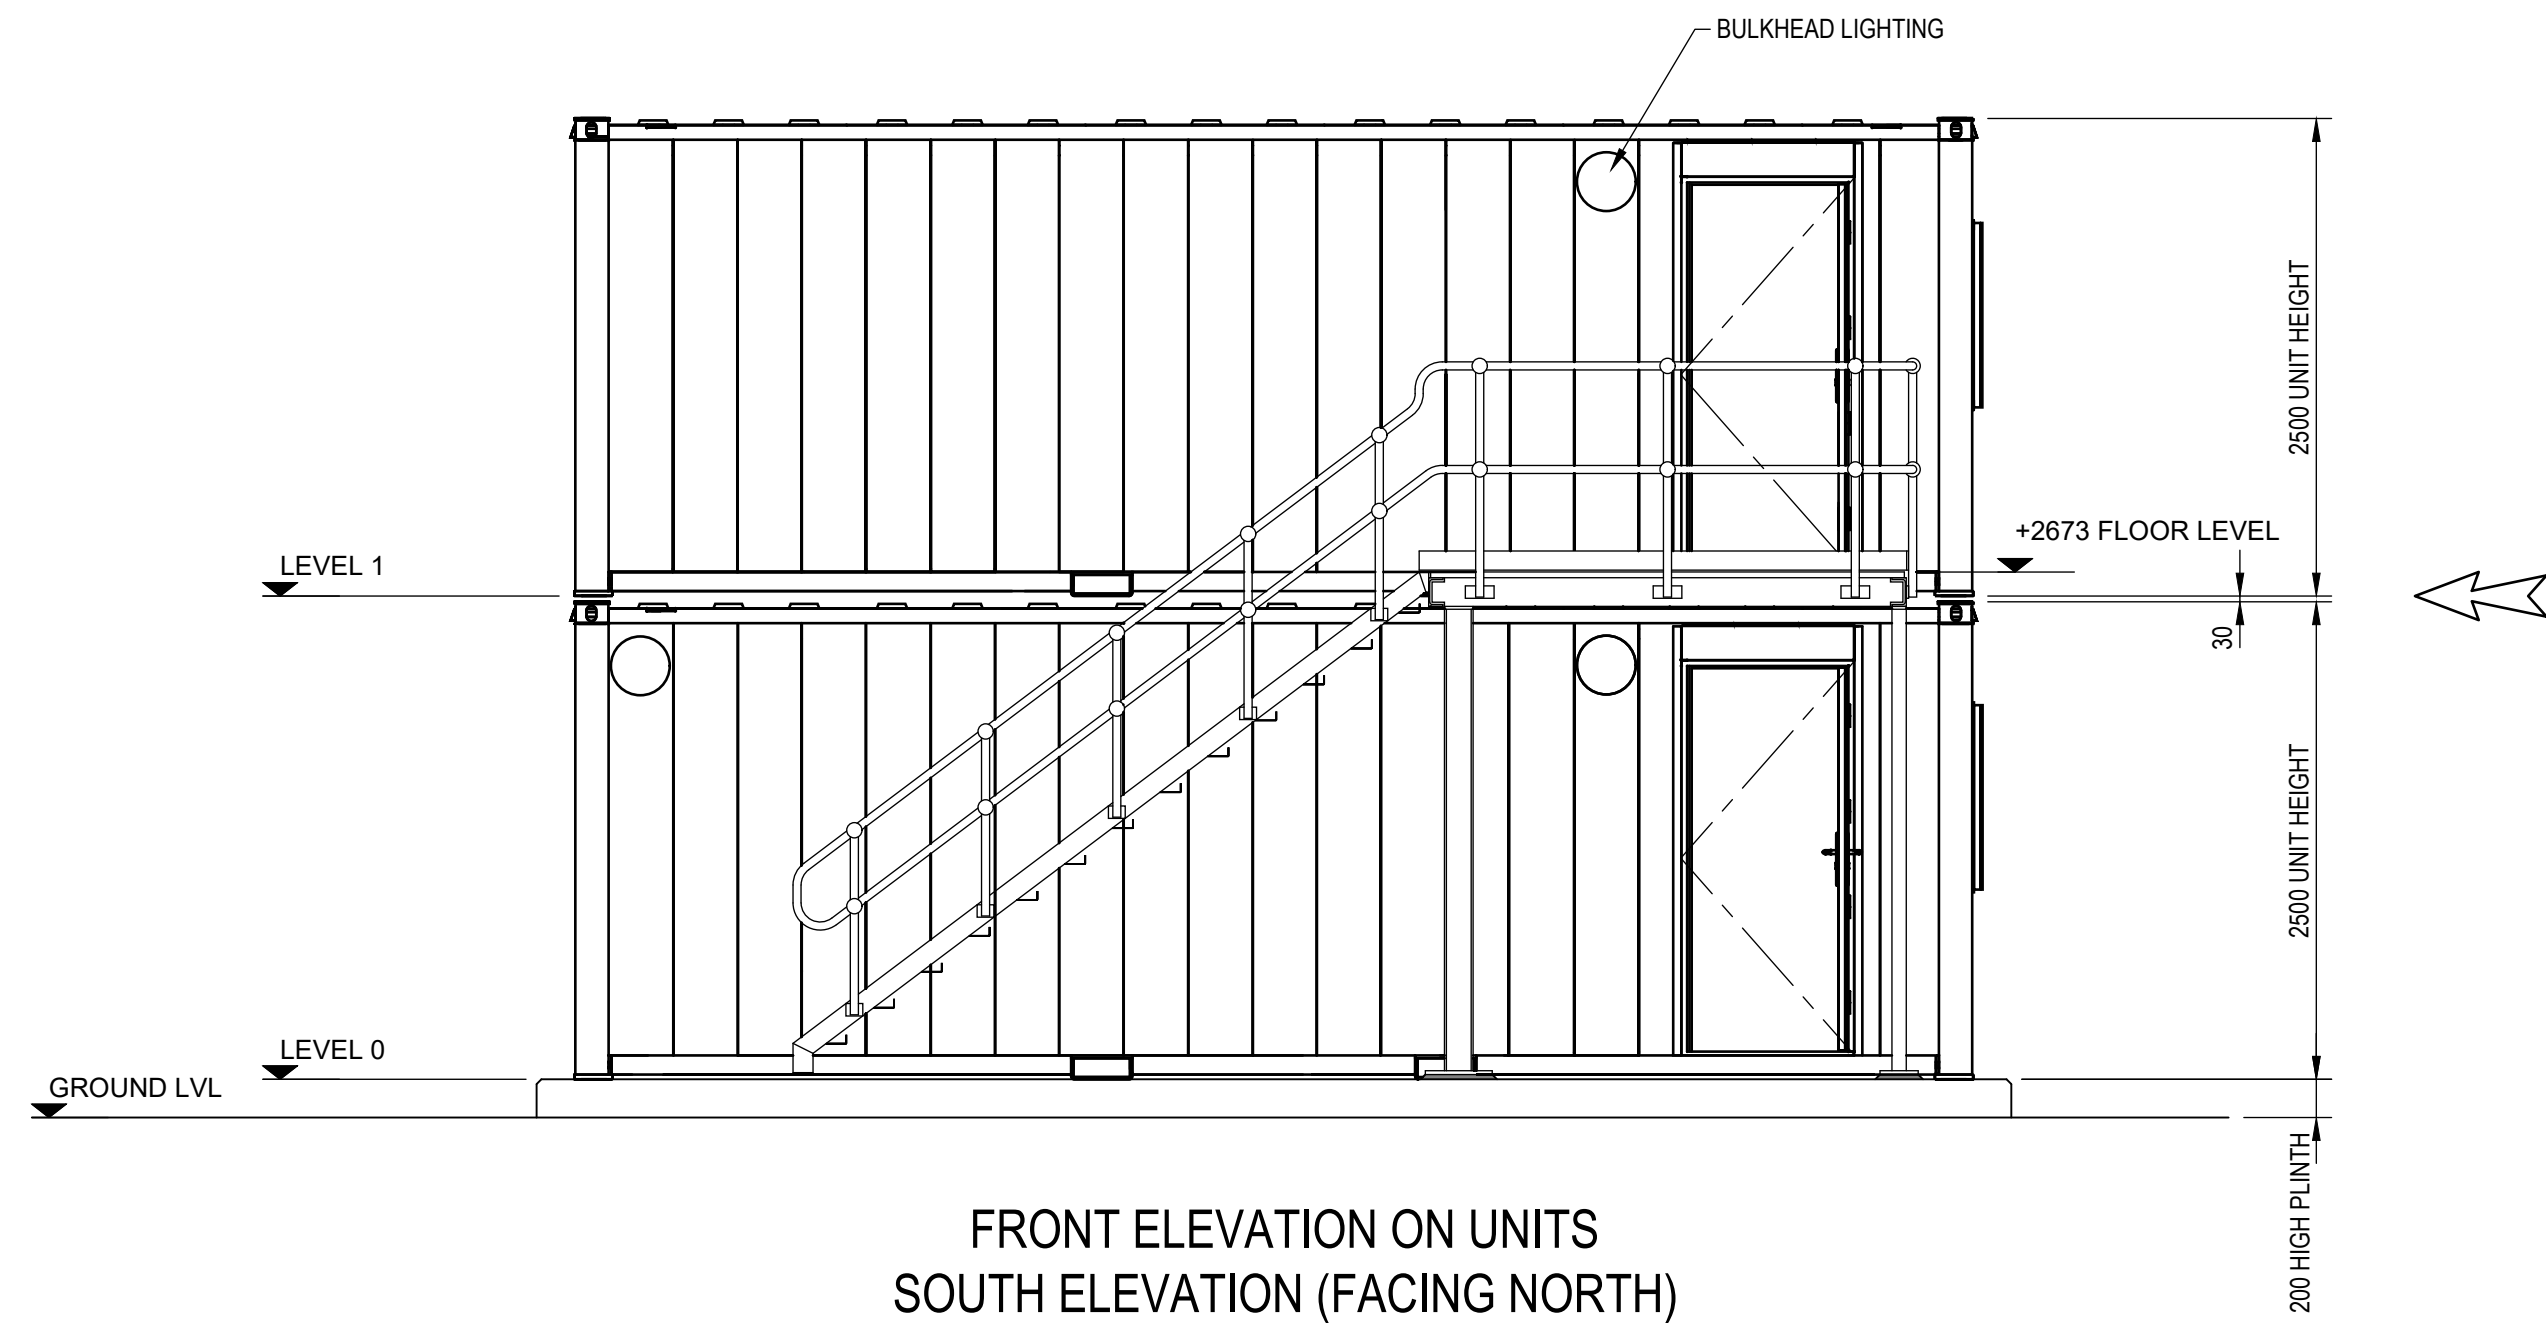


- DISCLAIMERS & NOTES:
- NOTES:
1. ALL DIMENSIONS ARE IN MILLIMETRES.
 2. ALL LEVELS ARE IN METRES A.O.D UNLESS OTHERWISE NOTED.
 3. ALL EXTERNAL SURFACES OF ANTI-VANDAL STEEL CONSTRUCTION, PAINTED HOLLY BUSH GREEN BS4800 5252 14 C39.
 4. STAIRS GALVANISED MILD STEEL CONSTRUCTION AND FINISH.

REFERENCE DRAWINGS:

BARHALE ENPURE:
WOR07 BNE WWT WWT GA M 0001 SITE LAYOUT GENERAL ARRANGEMENT.

HOLDS:
1.

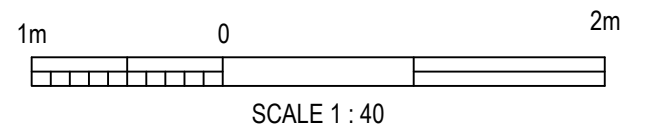

AC.P01	ENQUIRY ISSUE	RMA	SR	CH	23/11/2023
Status Rev	Description	Drawn	Check	App'd	Output Date

Construction Date: CONSTRUCTION COMPLETE DATE?

Originator / Partner / OEM Ref:

YORKSHIRE WATER
ALWAYS CONSIDERS

Barhale enpure

LIFE SAVING RULES

Client:

Yorkshire Water Services Ltd
Western House,
Western Way,
Halifax Road,
Bradford,
BD6 2SZ

YorkshireWater

Framework:	AMP7	Work Stream:	WINEP
YW Batch ID / Project Code:	YW.200418	YW Solution ID:	137376
Site:			
WORSBROUGH STW WOR07			
PSS Grid Reference:		DA2 or DMA References	
SE 3621103521			

Drawing Title:
NEW SITE WELFARE AND LABORATORY UNIT
PROPOSED LAYOUT

Original Design / OEM Reference:	C20099-B-31-ENP-MEC-DR-20100	Size:	A1	Scale:	1:40
Status Description:	GATE 5	Status:	AC	Revision:	P01
Drawing Number:	WOR07 BNE WWT WWT DR M 0100				