


Front

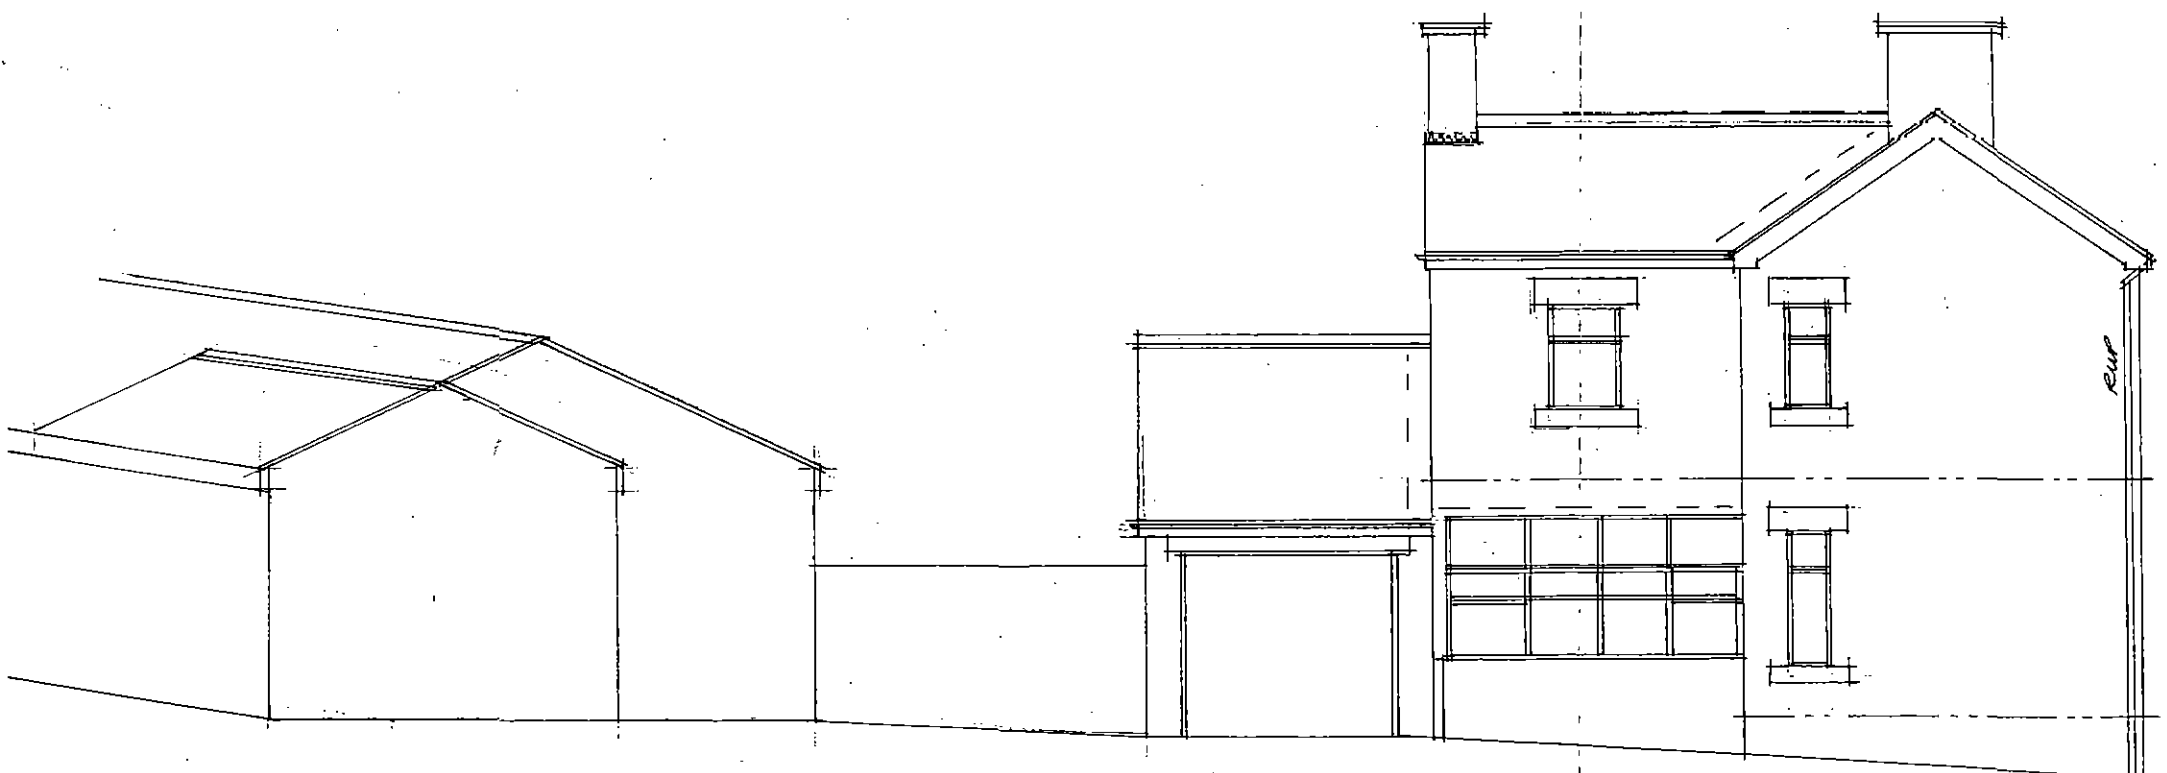

Side



Side

Rev	Notes	Date

**Garry Greetham Associates**  
 Residential Design Consultant  
 Westwood House  
 18 Carr Lane  
 Tankersley  
 Barnsley S75 3BE  
 Tel(01226)746573

PROJECT Various Extensions

CLIENT Mr. D. Howorth

TITLE Elevations as Existing



ADDRESS White Cross Farm,  
 White Cross Road, Cudworth  
 Barnsley. S72 8ED

DRAWN BY 999


SCALE 1:100 DATE Aug 19

DRAWING No 917-03 REV

Member of the Chartered Institute  
 of Architectural Technologists

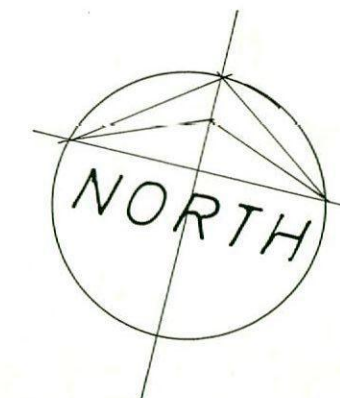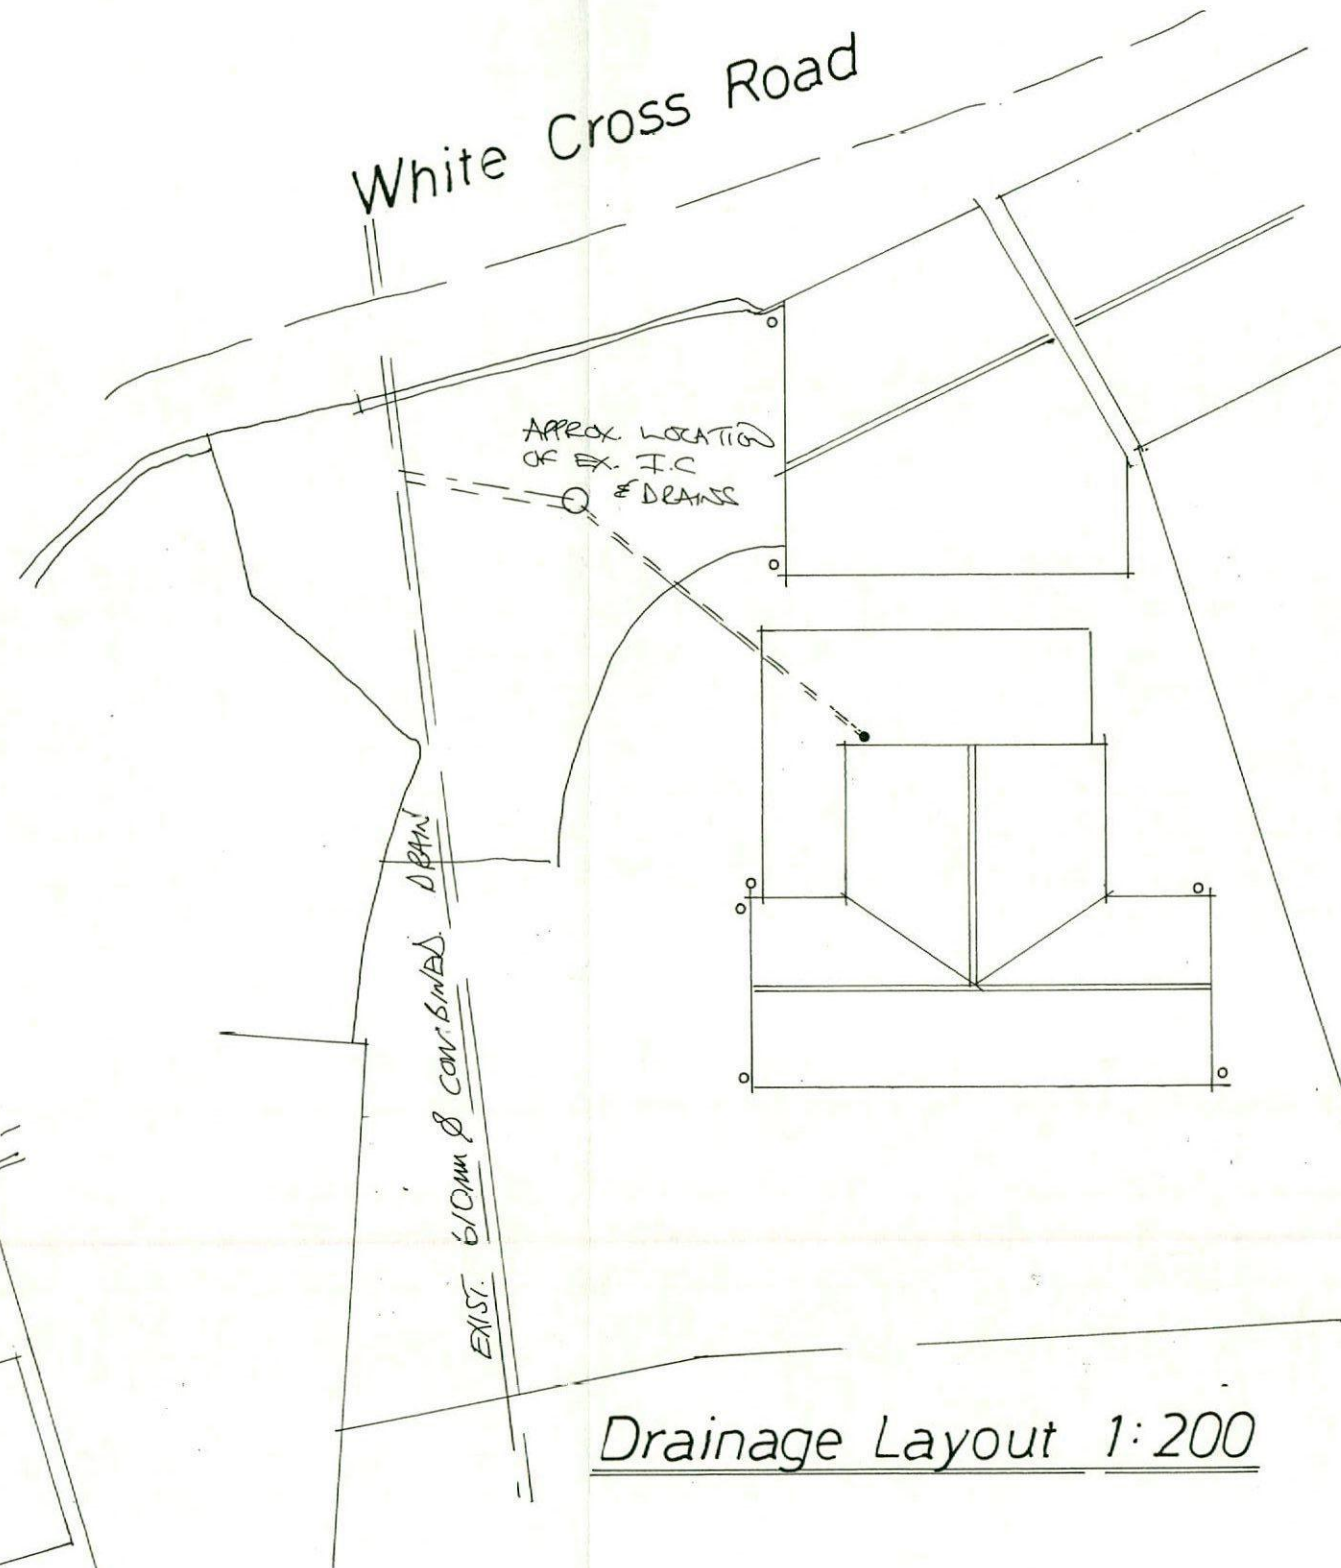

Rev	Notes	Date

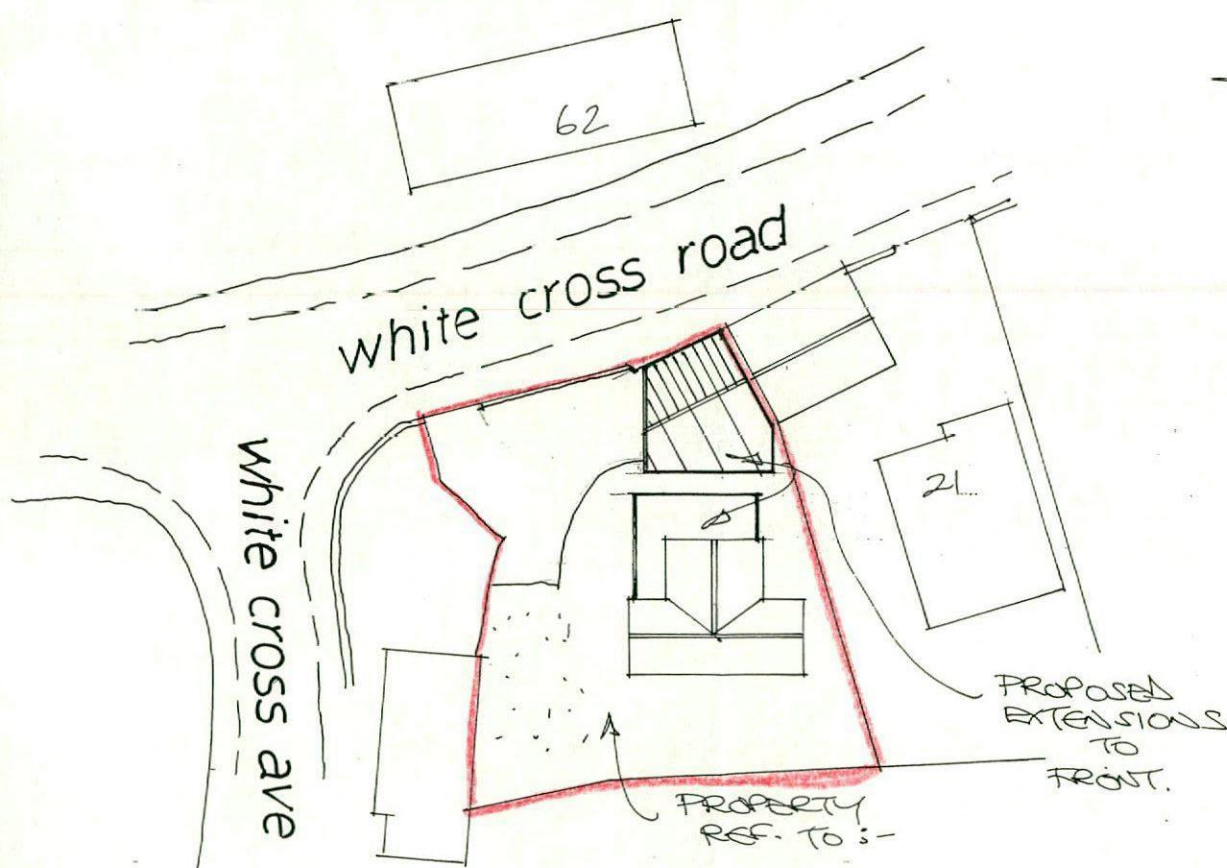

Site Layout 1:500

Drainage Layout 1:200

B/Reqs:

### Planning:

Garry  
Greetham  
Associates

Residential  
Design Consultant  
Westwood House  
18 Carr Lane  
Tankersley

Barnsley S75 3BE  
Tel(01226)746573

PROJECT	Various Extensions		
CLIENT	Mr. D. Howorth		
TITLE	Site & Location Layouts		
ADDRESS	White Cross Farm, White Cross Road, Cudworth Barnsley. S72 8ED		
DRAWN BY	ggg		
SCALE	as shown	DATE	Aug 1
DRAWING No	917-01		REV

Member of the Chartered Institute  
of Architectural Technologists