

NOTES

- 1. Driveway and car park surfacing design and construction to Engineer's Specification (by others).
- 2. All dimensions are in millimetres unless otherwise stated.
- 3. All manholes and soakaways shall comply with the relevant provisions of BS 5911 and be 'Kite Marked'.
- 4. Manhole covers and frames, girds and frames shall comply with the relevant provisions of BS EN 124. D400 class manhole cover to be used within trafficked areas. A15 class manhole cover to be used in untrafficked areas.
- 5. Do not scale from this drawing, if in doubt ask.

Percolation Tests completed by RAB Consultants dated July 2015. Infiltration rate of 0.035m/hr taken from report and used for sizing of infiltration devices.


Occupier should undertake inspection of sump manholes upstream of soakaways and clear when required.

KEY:

Rooted Areas draining to lined soakways
Rooted areas to sealed downpipes

Private SW PPIC Manhole 450mm dia
SW PPIC Manhole with 300mm deep sump

Fermeable Paving to individual drives
150mm deep sub-base

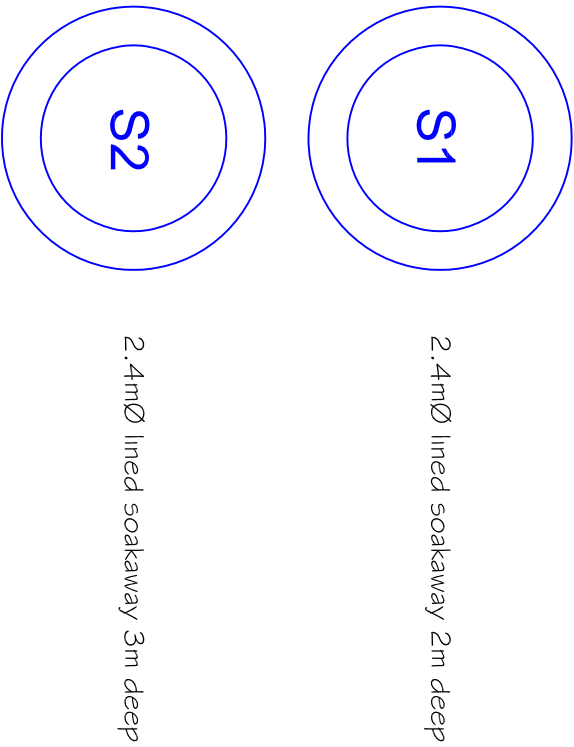

All soakways located at least 5m from new or proposed buildings

REV	DESCRIPTION	DATE
0	For Approval	25/04/19

EWE Associates Ltd

EWE Associates Limited
71 Wilton Road
Barton Upton, Stainer
Scunthorpe
DN15 9DT
Tel: 07875 972270

Email: lea.fawell@eweassociates.com


PROJECT
Grove Street Barnsley

CLIENT
CODA Planning

DRAWING TITLE
SW Drainage Layout

SCALE		DATE	
1:150		25/04/19	
DRAWN BY	CHECKED BY	REVISION	
JF	JF	0	

DRAWING No
EWE/2420/O1

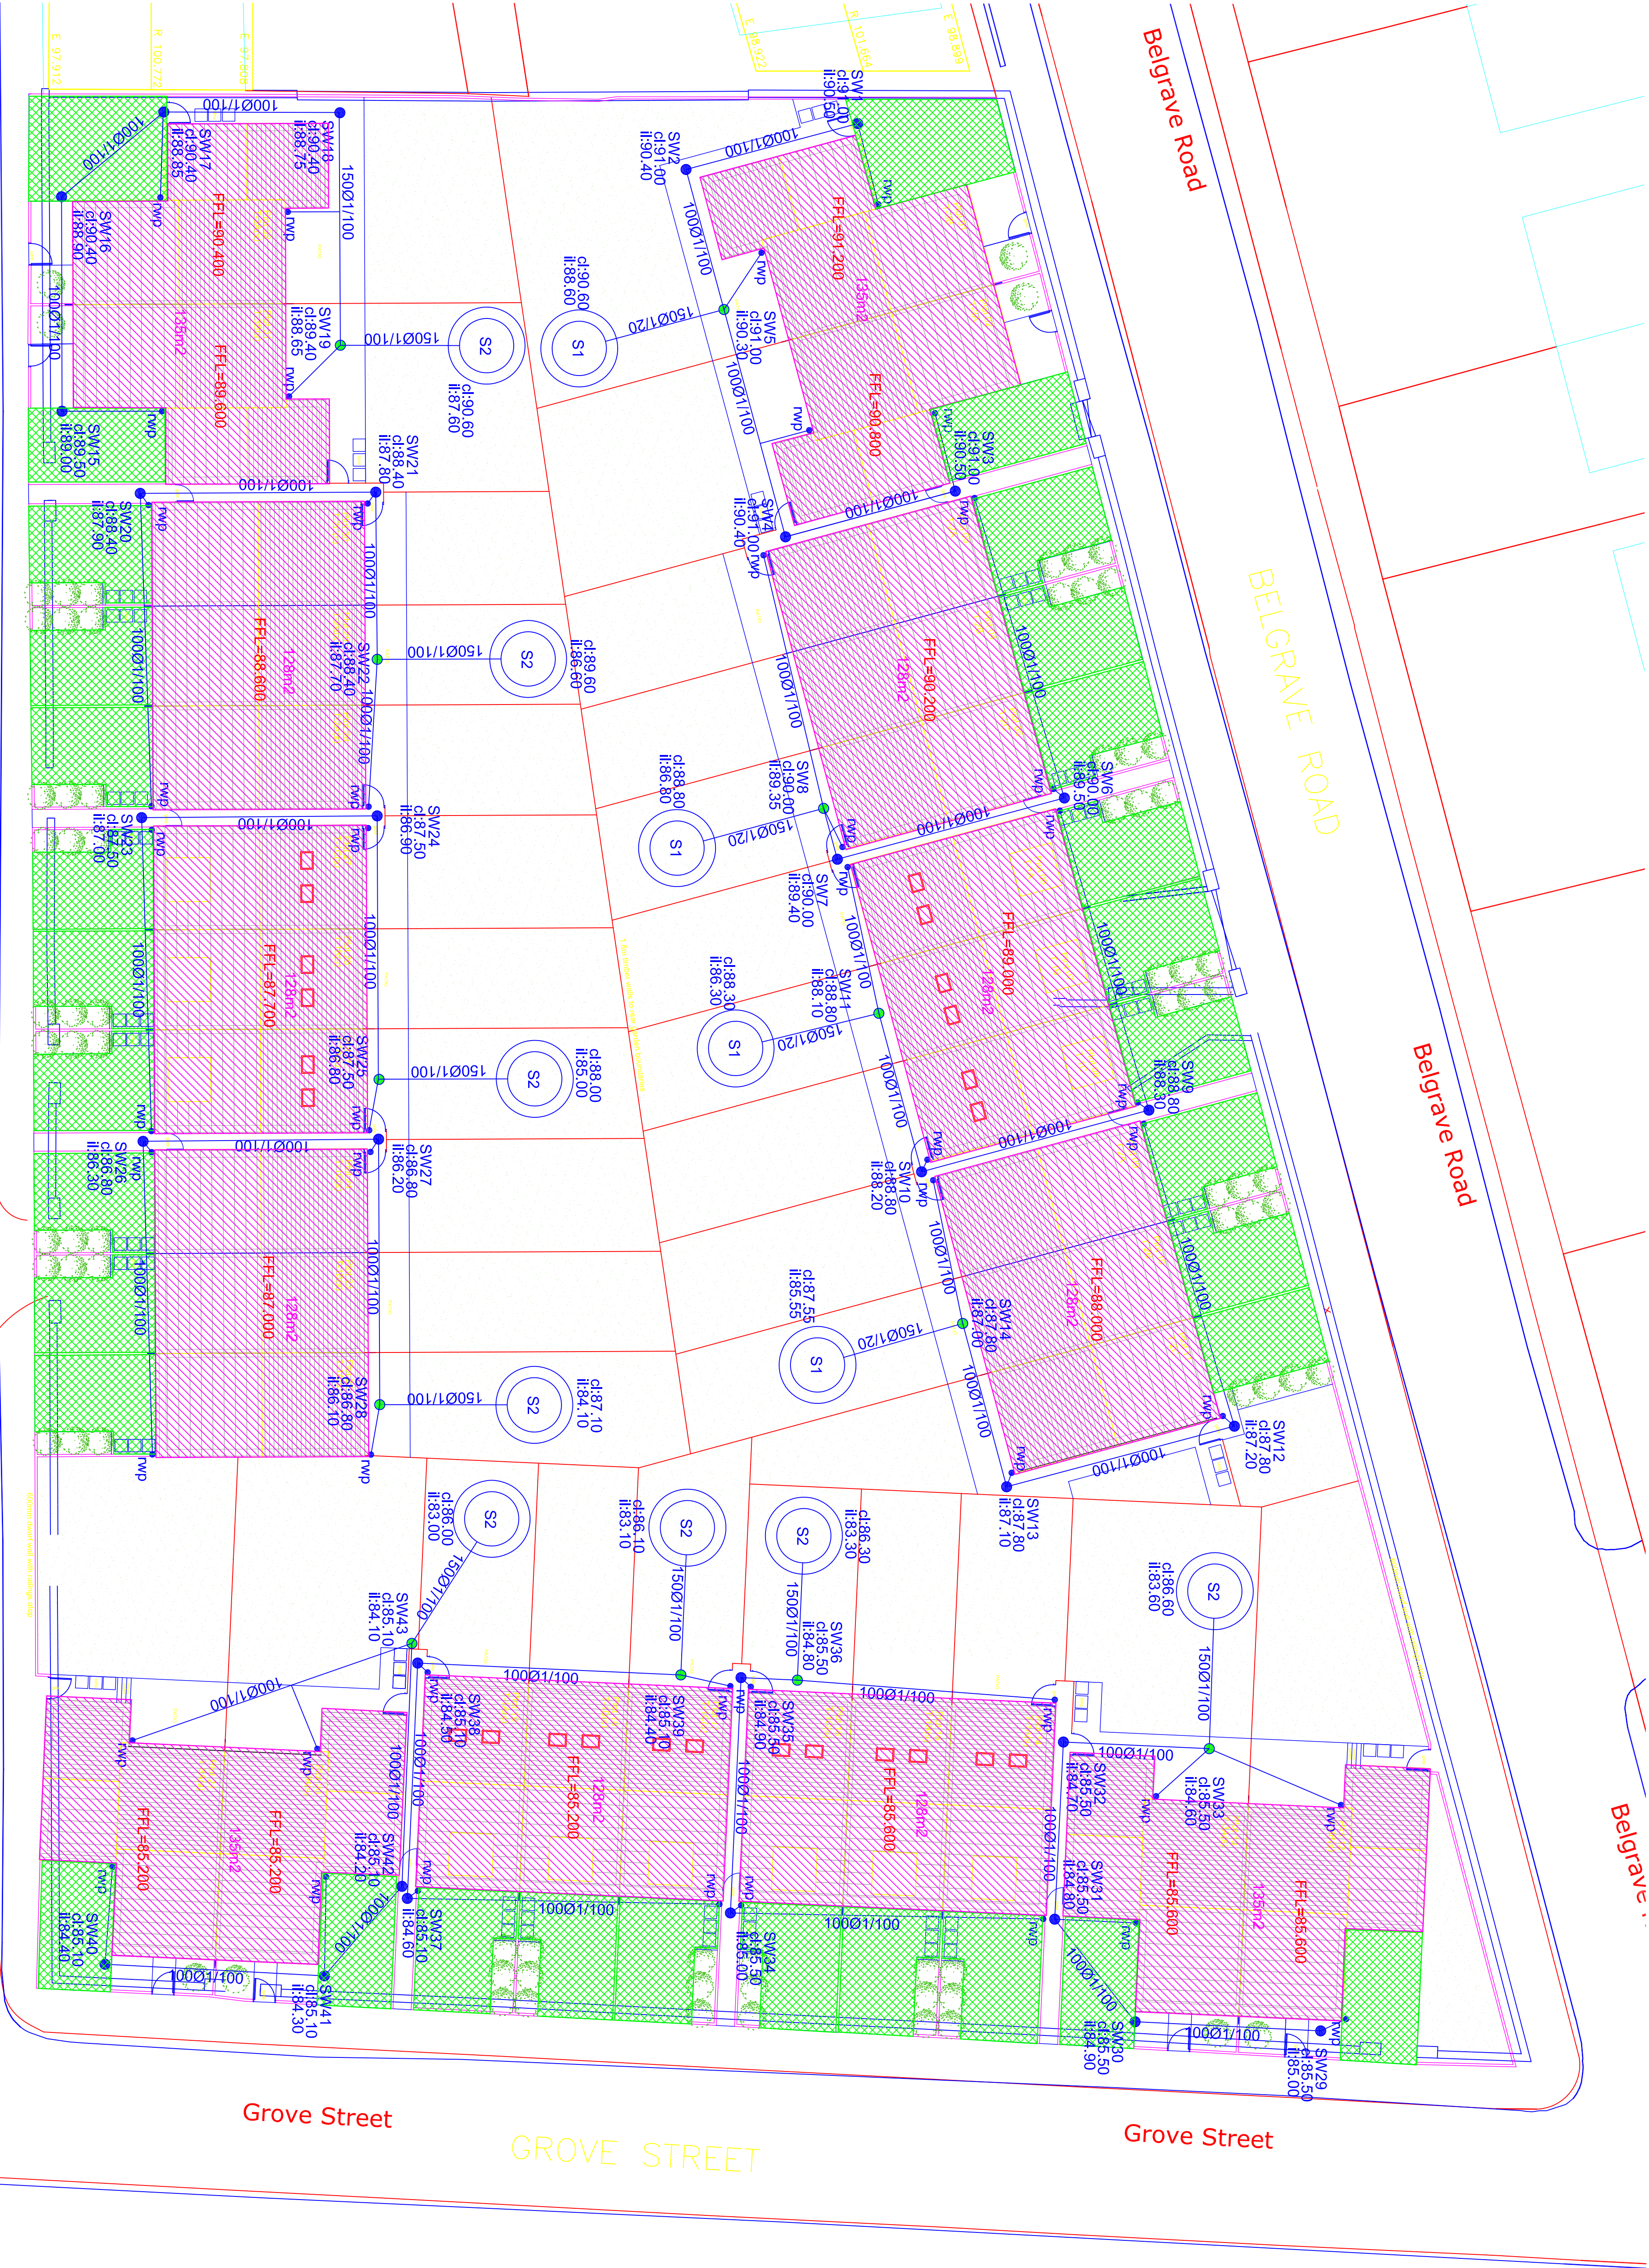

Grasmere Road
GRASMERE ROAD

Grasmere Road

Belgrave Road

BELGRAVE ROAD

Belgrave Road

Belgrave Road

Grove Street

GROVE STREET

Grove Street